


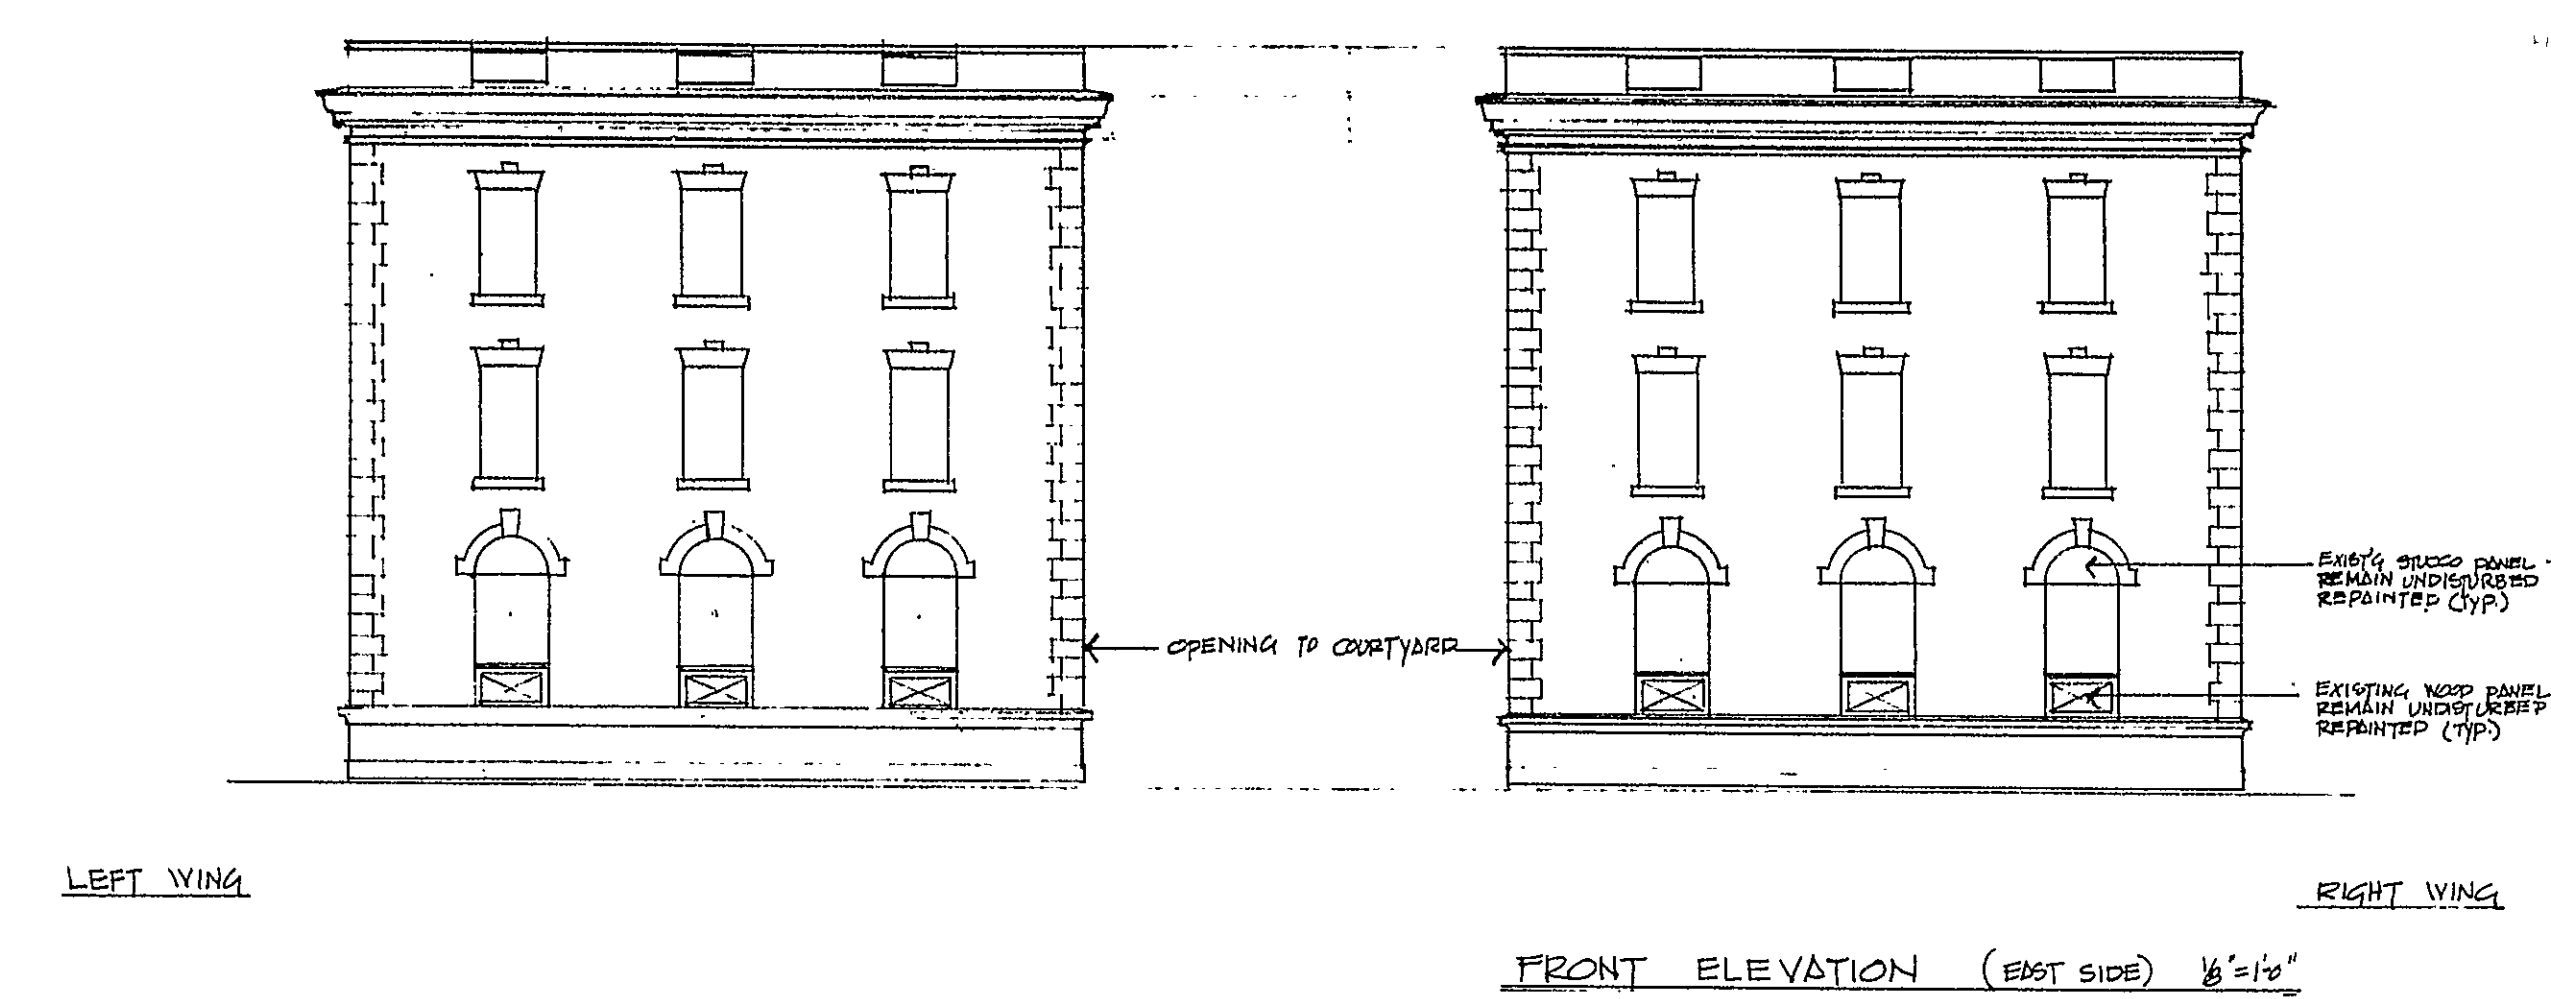


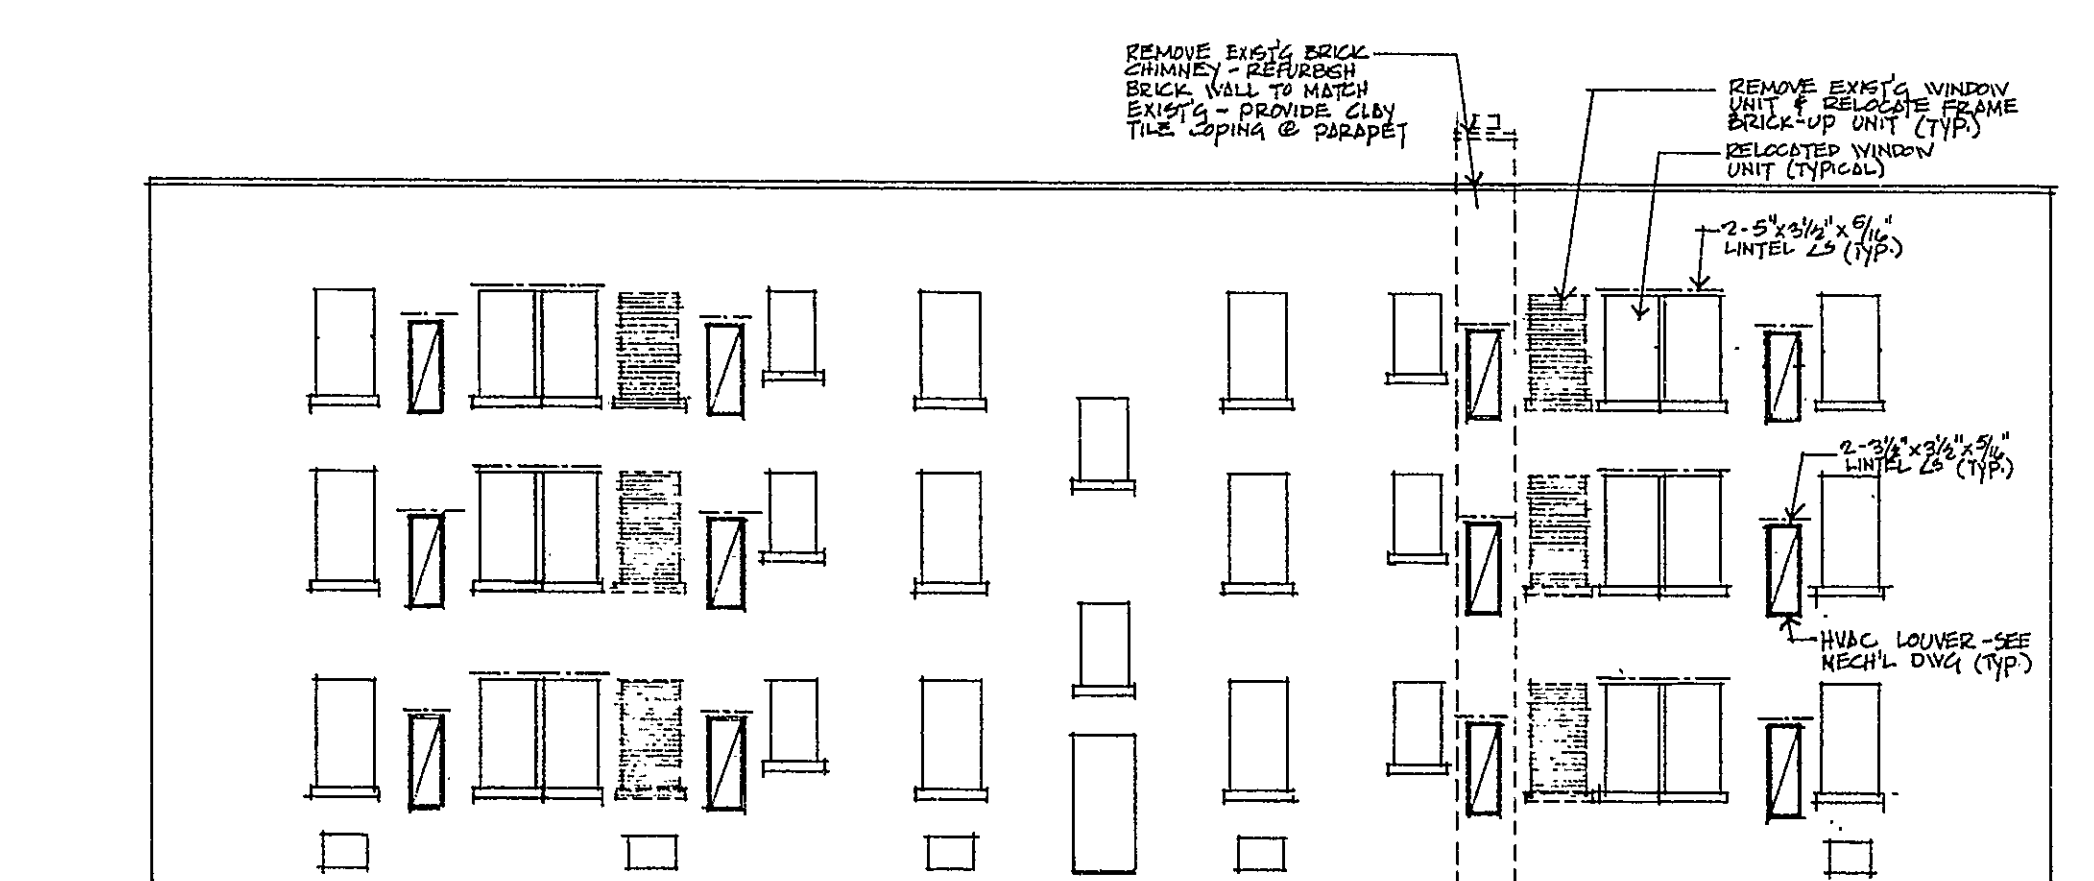

- GENERAL NOTES
1. CONCRETE WALKS, STEPS, WALLS, STOOP AND PORCHES OF NEW CONCRETE CONSTRUCTION, AS DETAILED.
 2. FENCING ACROSS FRONT OF PROPERTY TO BE WROUGHT IRON PICKETS AS WELL AS GATES. CONFIGURATION TO FOLLOW DRAWINGS. FENCING SURROUNDING REST OF THE PROPERTY TO BE 6'-0" HIGH CY-CLONE FENCE.
 3. PLANTING, LANDSCAPING, DECORATIVE WALKS, LIGHTING, ETC., AS SHOWN ON THE LANDSCAPE PLAN.
 4. ALL MASONRY ON EXTERIOR TO BE SANE-BLASTED, INCLUDING LIME-STONE SILLS AND ARCHES, THEN POINTED AND MADE TIGHT AND SECURE.
 5. ENTRANCE-WAY PORTICOS TO BE RECONSTRUCTION IN ACCORDANCE WITH ORIGINAL DESIGN. RE-ROOFED AND FLASHED TO WALLS. COLUMNS, PORCH RESURFACED AND NEW ENTRYWAY FLOOR PER DETAIL.
 6. WINDOWS REPLACED PER DETAIL, CAULKED AND MADE TIGHT (SEE PLAN & DETAIL).
 7. EXPOSED CONCRETE FOUNDATION TO BE REFINISHED (1) COAT THOROUGHLY SEAL STUCCO FINISH. AREAWAYS REFINISHED, NEW BASEMENT SASH WHERE CALLED FOR WITH PROTECTIVE SCREENING.
 8. THE "FRIEZE CORNICE" TO BE COMPLETELY REFINISHED WOOD DETAILS AND CORNICE REPAIRED, RE-ROOFED, FLASHED AND PAINTED.
 9. CURB-CUT WALKS, ETC. WHERE APPLICABLE TO BE INSTALLED PER CODE, DEPARTMENT PUBLIC WORKS, CITY OF HARTFORD.
 10. CONCRETE BASES FOR POLE LIGHTS, BRICKED-IN WALKS LIGHTS SHOULD BE NOTED ON ARCHITECTURAL AND ELECTRICAL PLANS.

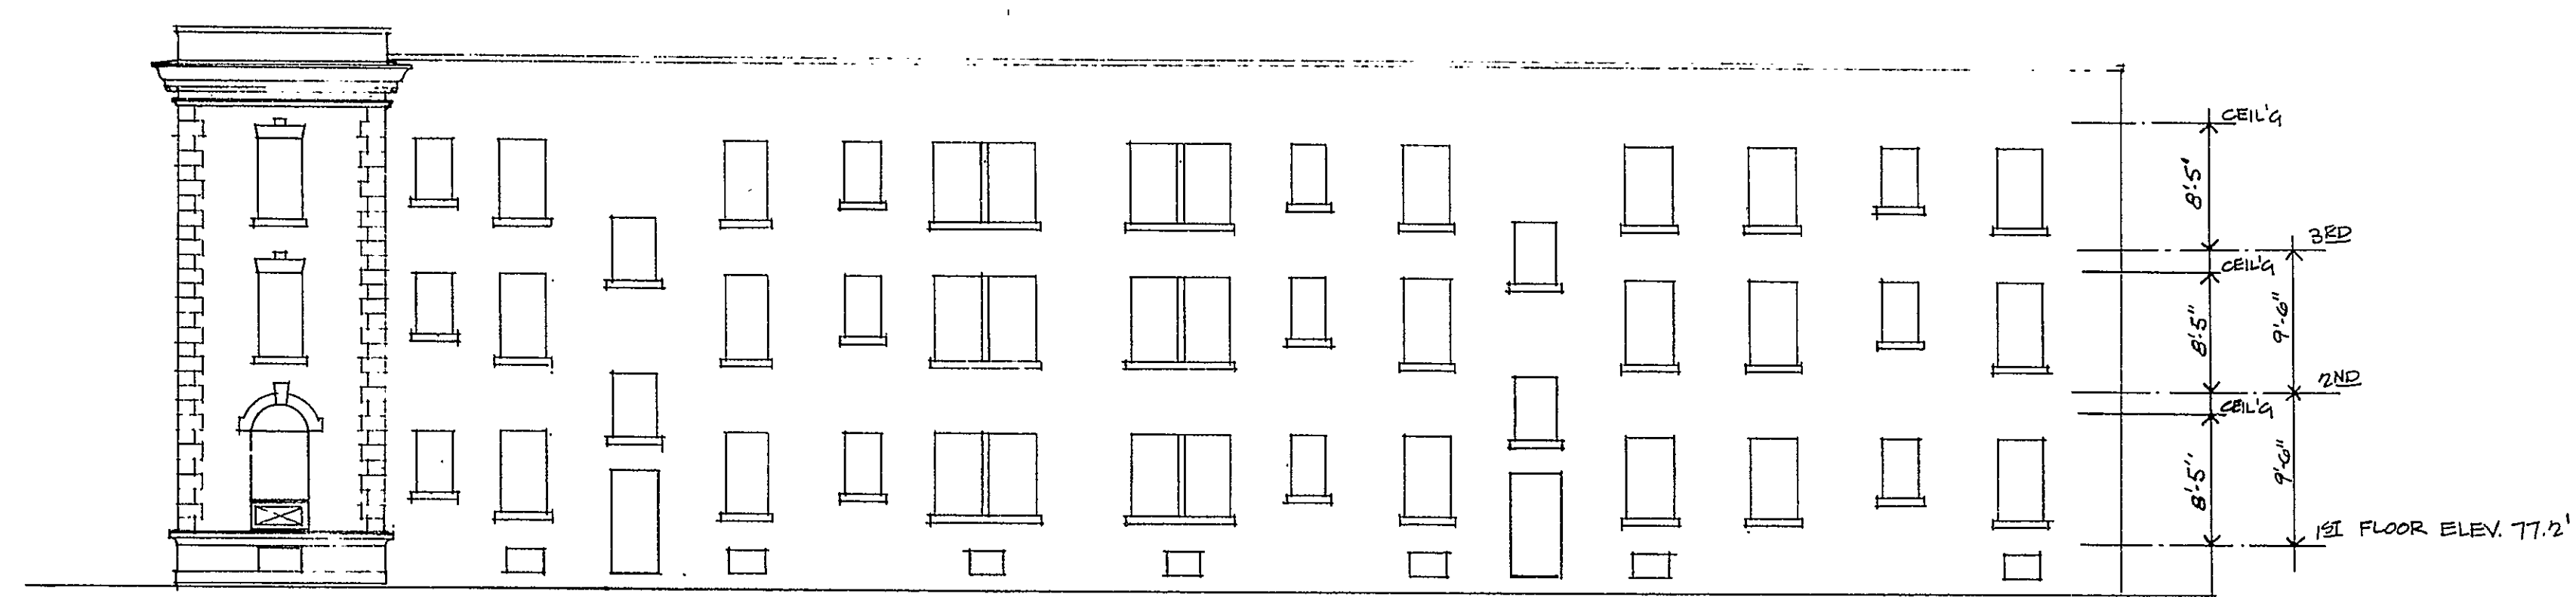


RIGHT SIDE ELEVATION (NORTH SIDE) 1/8"=1'-0" SCL
ABOVE ELEVATION IS OF RIGHT WING
LEFT SIDE ELEVATION (SOUTH SIDE) OF
LEFT WING, SIMILAR BUT OPPOSITE HAND

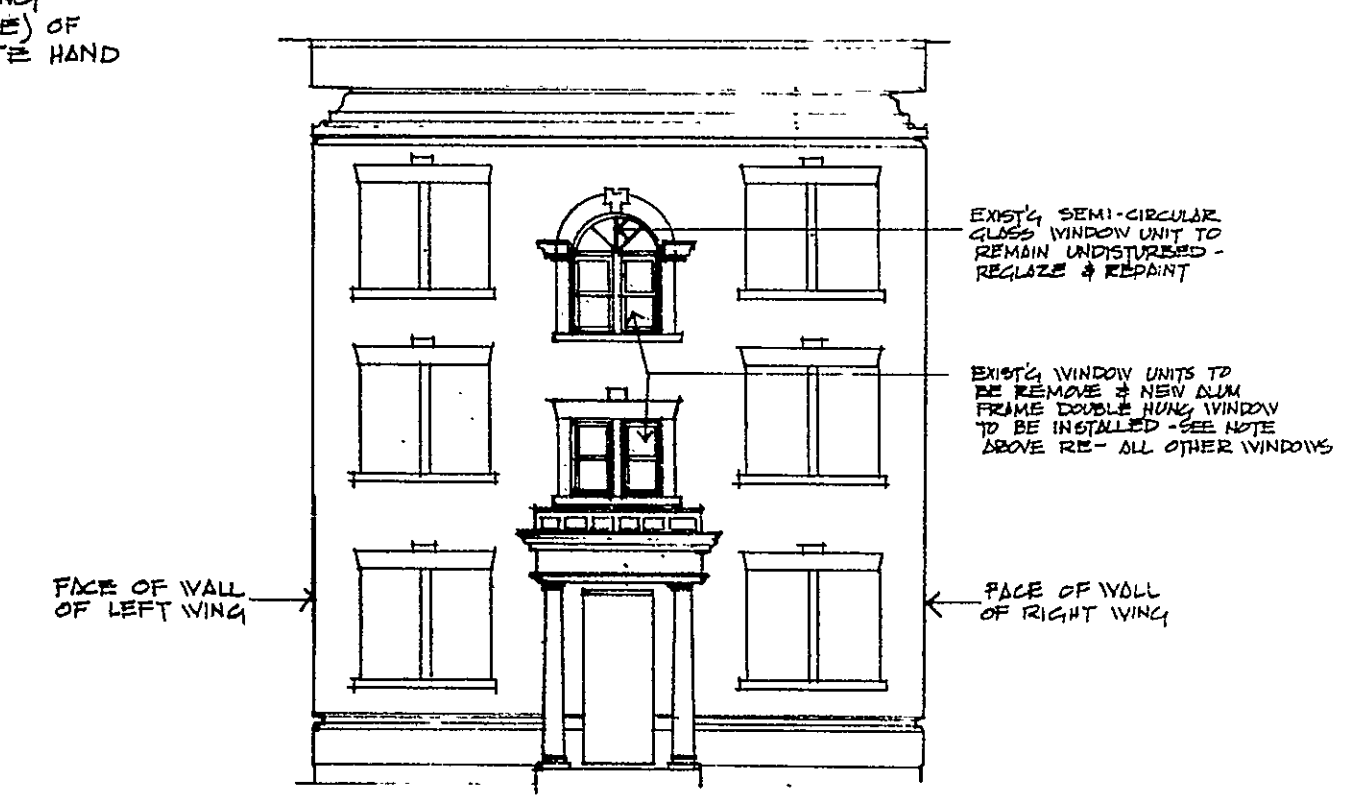


FRONT ELEVATION (EAST SIDE) 1/8"=1'-0" SCL
ABOVE ELEVATION IS OF CENTER PORTION
WITHIN INTERIOR COURTYARD

REAR ELEVATION (WEST SIDE) 1/8"=1'-0" SCL

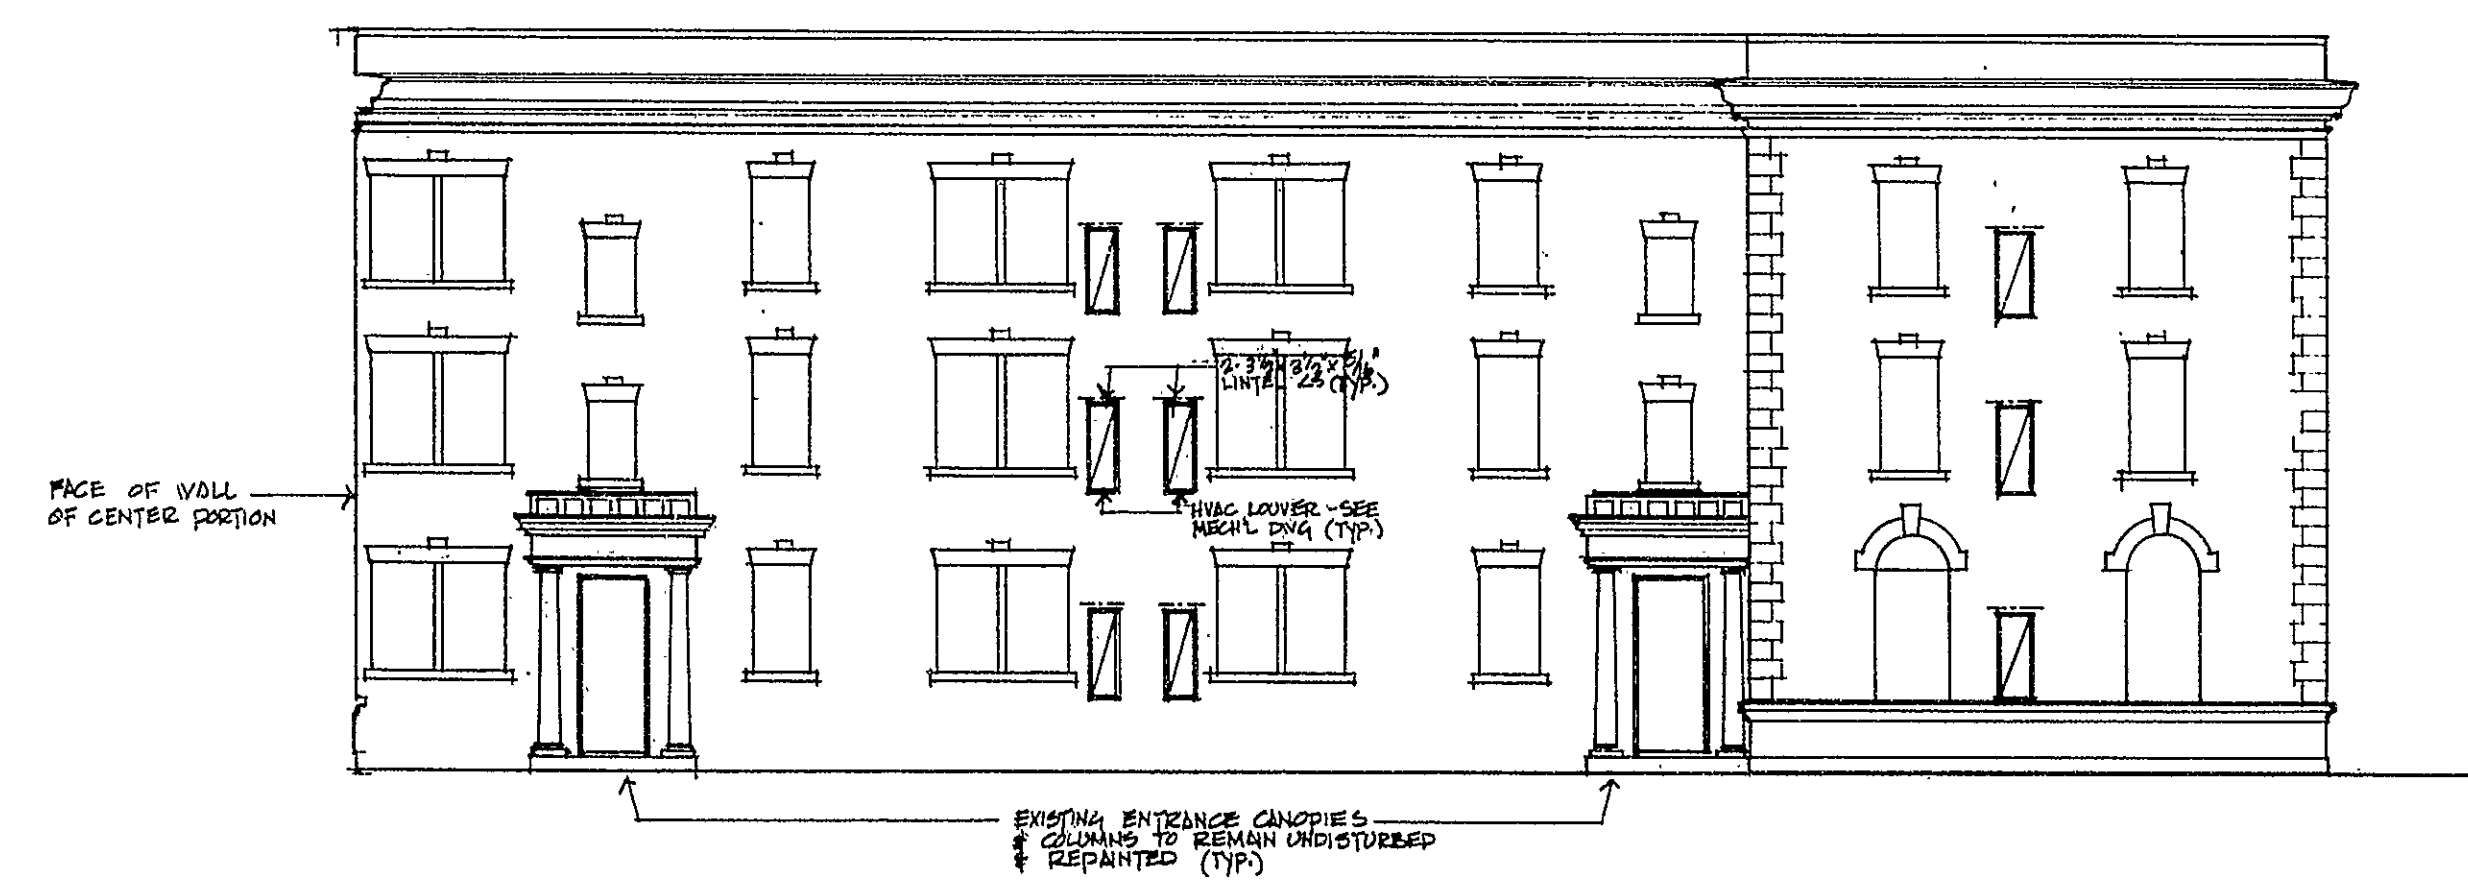

 
LEFT SIDE ELEVATION (SOUTH SIDE) 1/8"=1'-0" SCL
ABOVE ELEVATION IS OF RIGHT WING
RIGHT ELEVATION (NORTH SIDE) OF
LEFT WING, SIMILAR BUT OPPOSITE HAND



DATE	REVISIONS
1-12-79	PRELIM

THE WILLARD HOUSE
A CONDOMINIUM
WILLARD STREET
HARTFORD, CONNECTICUT

philip j. diorcia
a.i.a.
architect
95 miles street
hartford ct.

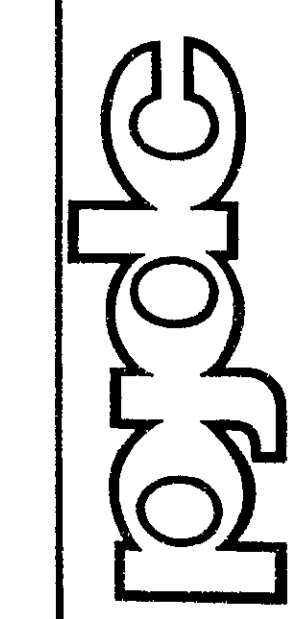

SCALE	
1/8" = 1'-0"	
DRAWN	CHECKED
DATE	
10-17-79	
CONTR. NO.	
79-370	
FILE NO.	
C-1	
SHEET NO.	

A-5a

Condo #19

