



RECEIVED BY
Robert A. Callahan
AUG 18 10 28 AM '80
TOWN & CITY CLERK
HARTFORD
VOL _____ PAGE _____

MARK	NOTES
	1. ELECTRIC BASEBOARD HEAT IS RATED AT 250 WATTS PER LINEAR FOOT, 208V, 1Ø. 2 EXTERIOR LIGHTING SHALL BE CONTROLLED BY A PHOTO CONTROL ON ROOF, TWO PHOTOCONTROLS PER BLDG.

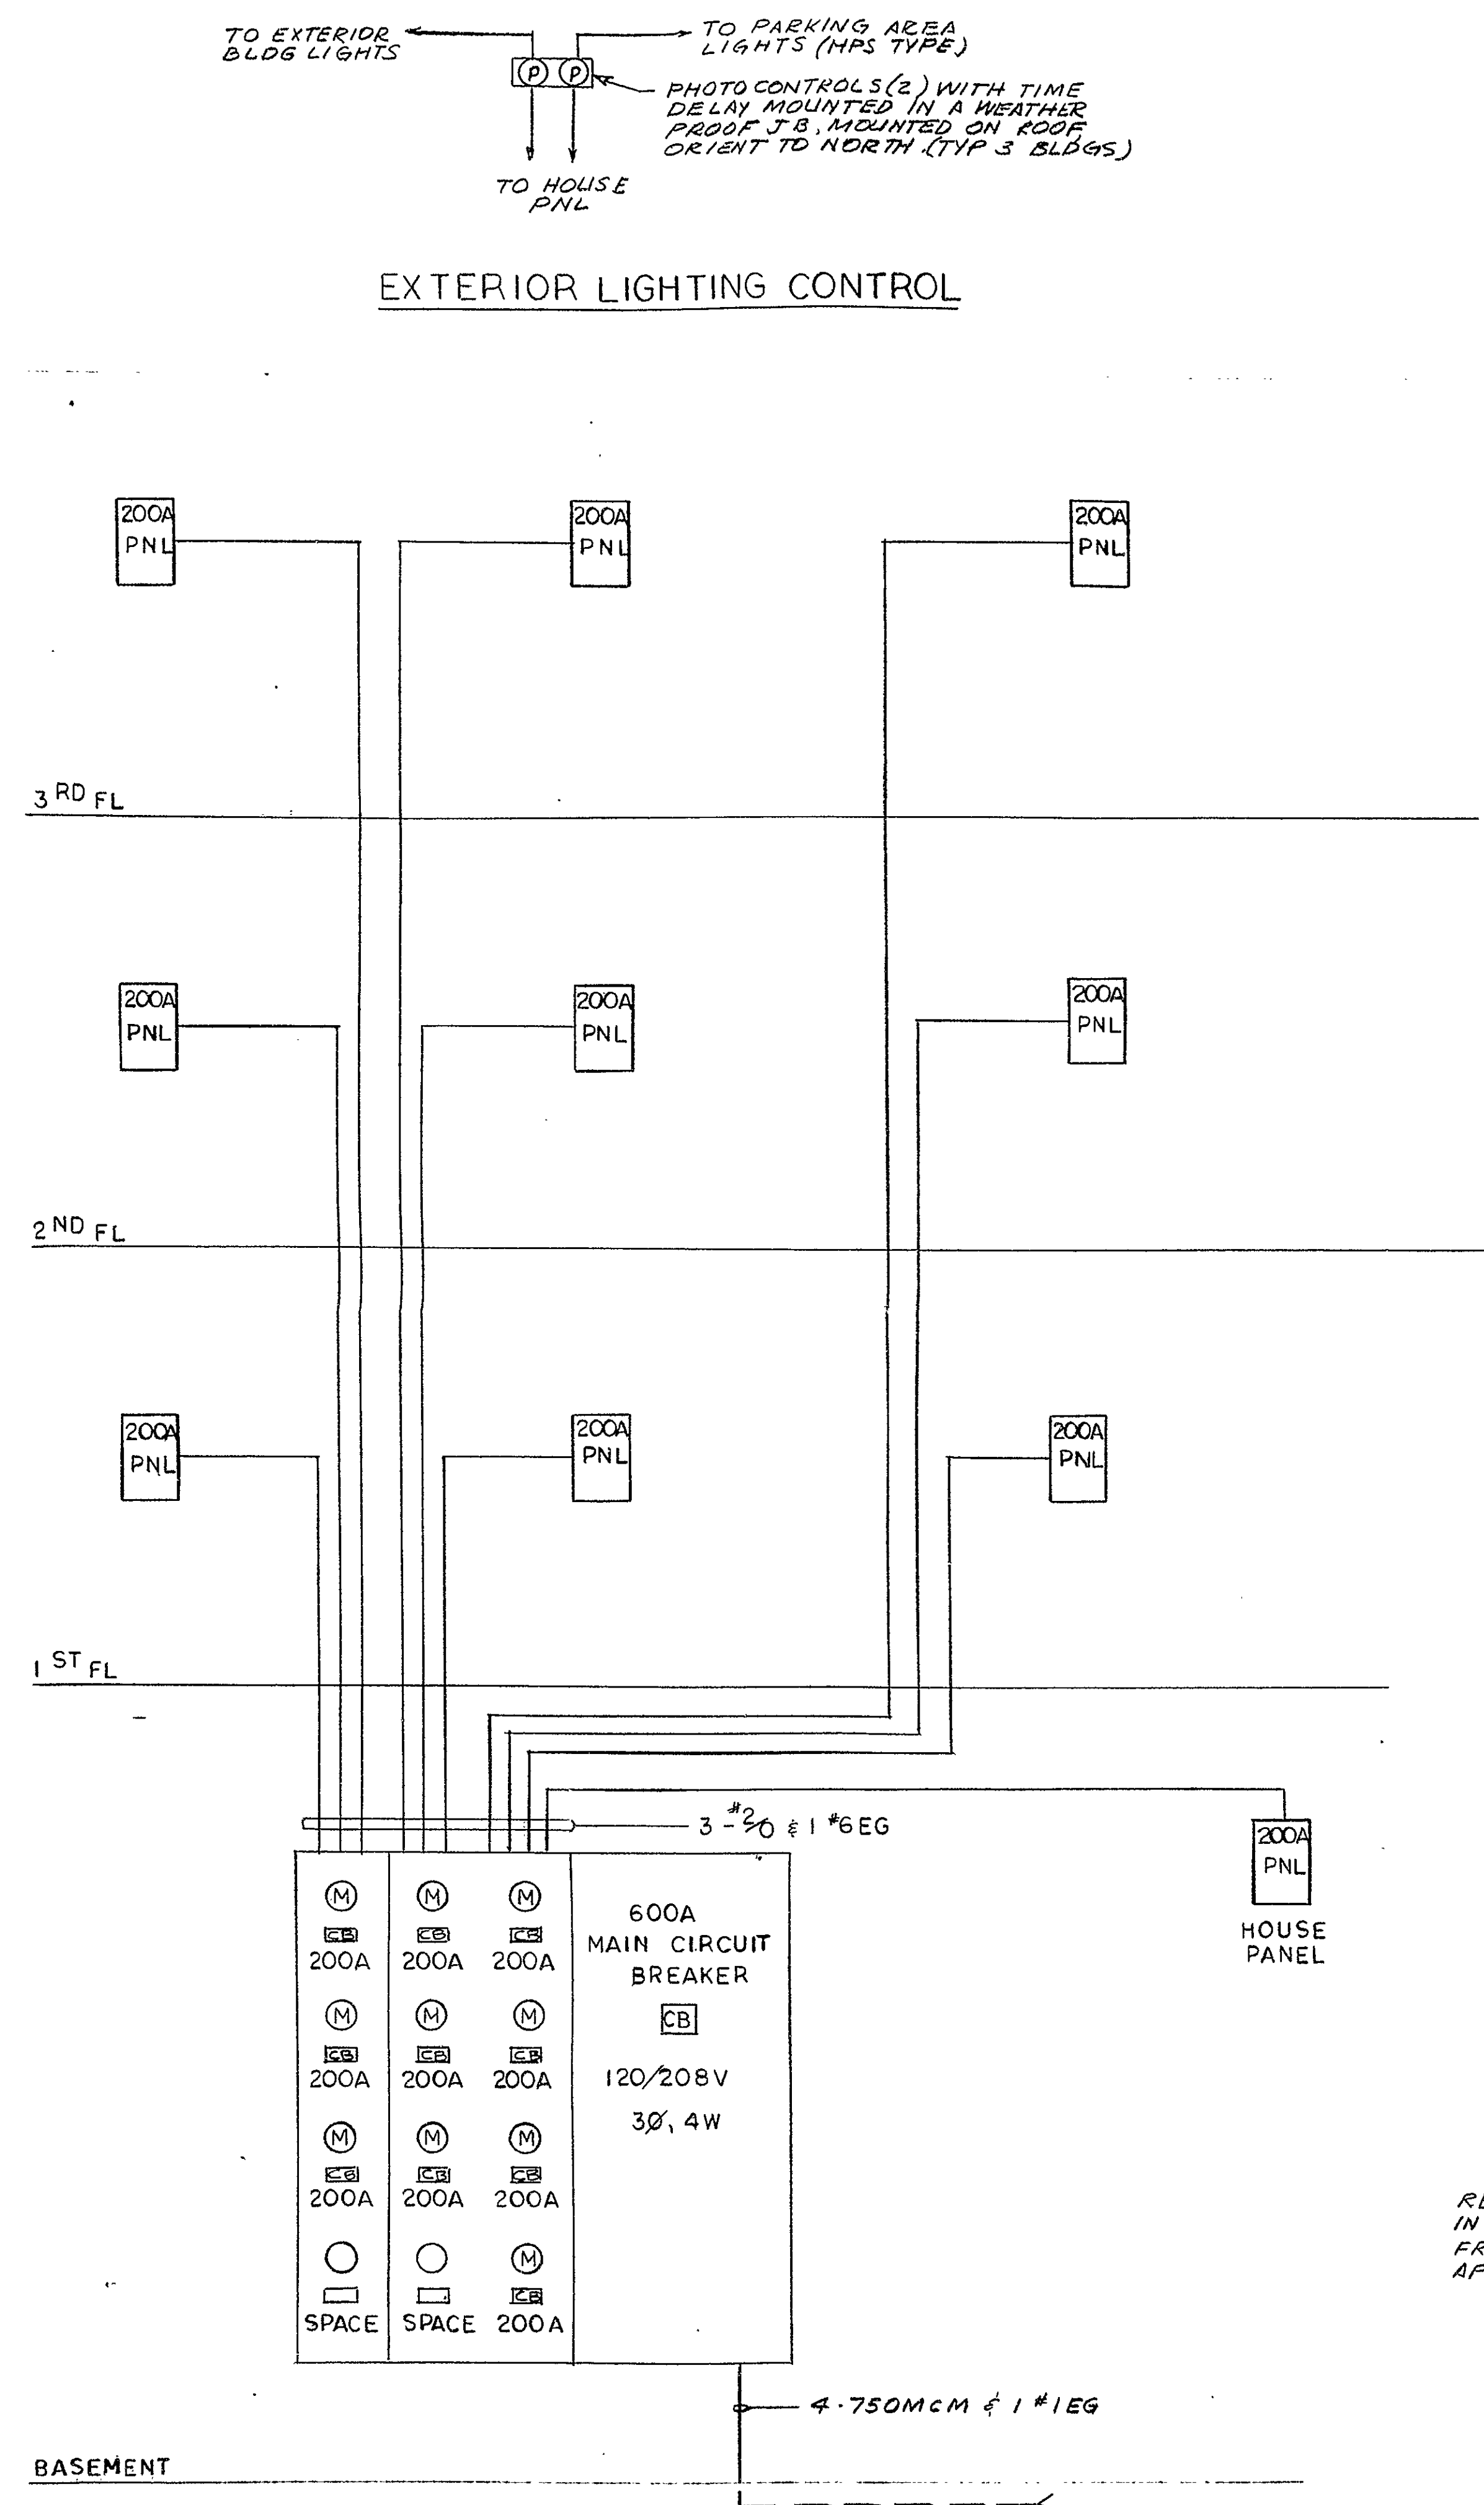

TYPICAL APARTMENT PANEL SCHEDULE						
200A M.L.O.		120/208V 1Ø, 3W		FLUSH MOUNTED		
CKT NO	SERVICE DESCRIPTION	CONNECT. KW	CKT BKR			REMARKS
			POLES	FRAME	TRIP	
1	LTG & RECEPTS - LIVING & DINING ROOM	1.2	1	20	2"1/2 #1"1/2 EG	
2	- BEDROOMS	1.2	1			
3	- KITCHEN, BATH & CLOSETS	1.2	1			
4	KITCHEN SMALL APPLIANCE RECEPTS	1.5	1			
5	↓ ↓ ↓	1.5	1	↓		
6	ELECTRIC WATER HEATER	4.0	2	30	2"10 #1"10 EG	
7	ELECTRIC RANGE	9.0	2	50	2"6 #1"10 EG	
8	DISHWASHER	1.2	1	20	2"1/2 #1"1/2 EG	
9	ELECTRIC BASEBOARD HEAT - LIVING RM	6.0	2	40	2"8 #1"10 EG	
10	↓ ↓ ↓	3.0	2	20	2"1/2 #1"1/2 EG	
11	BEDROOM	2.0	2	20		
12	BATHROOM	1.2	1	20		
13	CONTROL PANEL FOR BASEBOARD HEAT	0.3	1	20		
14	SPARE		1	20		
15	SPARE		2	20		

HOUSE PANEL SCHEDULE						SURFACE MOUNTED	
200A M.C.O.						120/208 1Ø, 3W	
CKT. NO.	SERVICE DESCRIPTION	CONNECT KW	CKT BKR		REMARKS		
			POLES	FRAME TRIP			
1	LIGHTING - BASEMENT	1.2	1	20	2*12 & 1*12 EG		
2	↓	1.2	1		↓		
3	↓	1.2	1				
4	- BLDG EXTERIOR	1.0	1				
5	- PARKING AREA	0.5	1	↓			
6	ELECTRIC WATER HEATER	4.0	2	30	2*10 & 1*10 EG		
7	ELECTRIC DRYER	5.0	1				
8	↓	5.0	1	↓			
9	WASHING MACHINE (2)	1.2	1	20	2*12 & 1*12 EG		
10	ELECTRIC HEAT - FOYER	1.0	2	20	↓		
11	RECEPTACLES	1.0	1	20	2*12 & 1*12 EG		
12	SPARE		2	20			
13	SPARE		2	20			
14	SPARE		1	20			
15	SPARE		1	20			

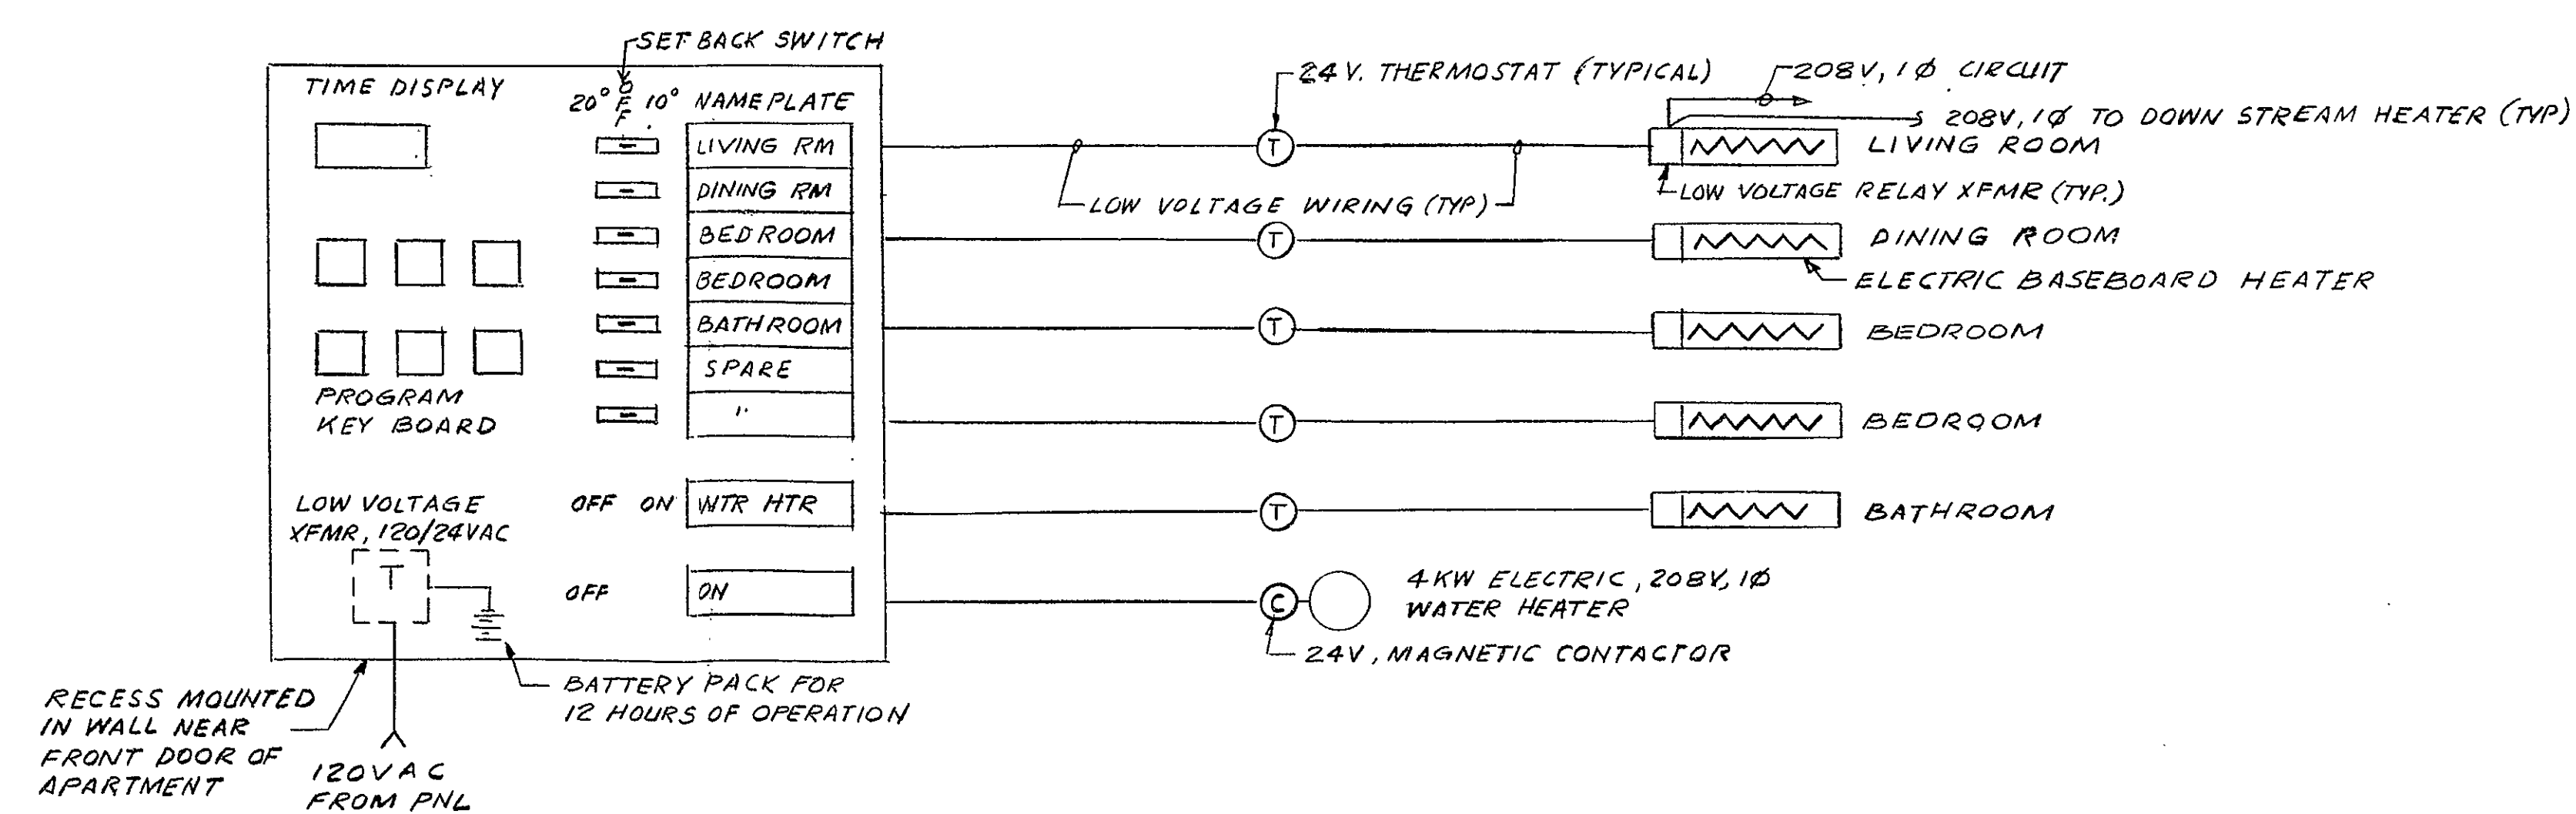

POWER RISER DIAGRAM-TYPICAL 3 BLDGS
NO SCALE

MARK	DATE	REVISIONS
------	------	-----------

DRAWING TITLE
ELECTRICAL PLAN - TYPICAL

DRAWING No. E · 1	SHEET No.
-----------------------------	-----------

AIWOOD CONDOMINIUMS

DATE 27 JUNE 1980

RESOURCE DEVELOPMENT CORPORATION

999 ASYLUM AVENUE
HARTFORD
CONNECTICUT
06105
203 • 246 • 8585

JOHN O'ROFINO • ARCHITECT

