



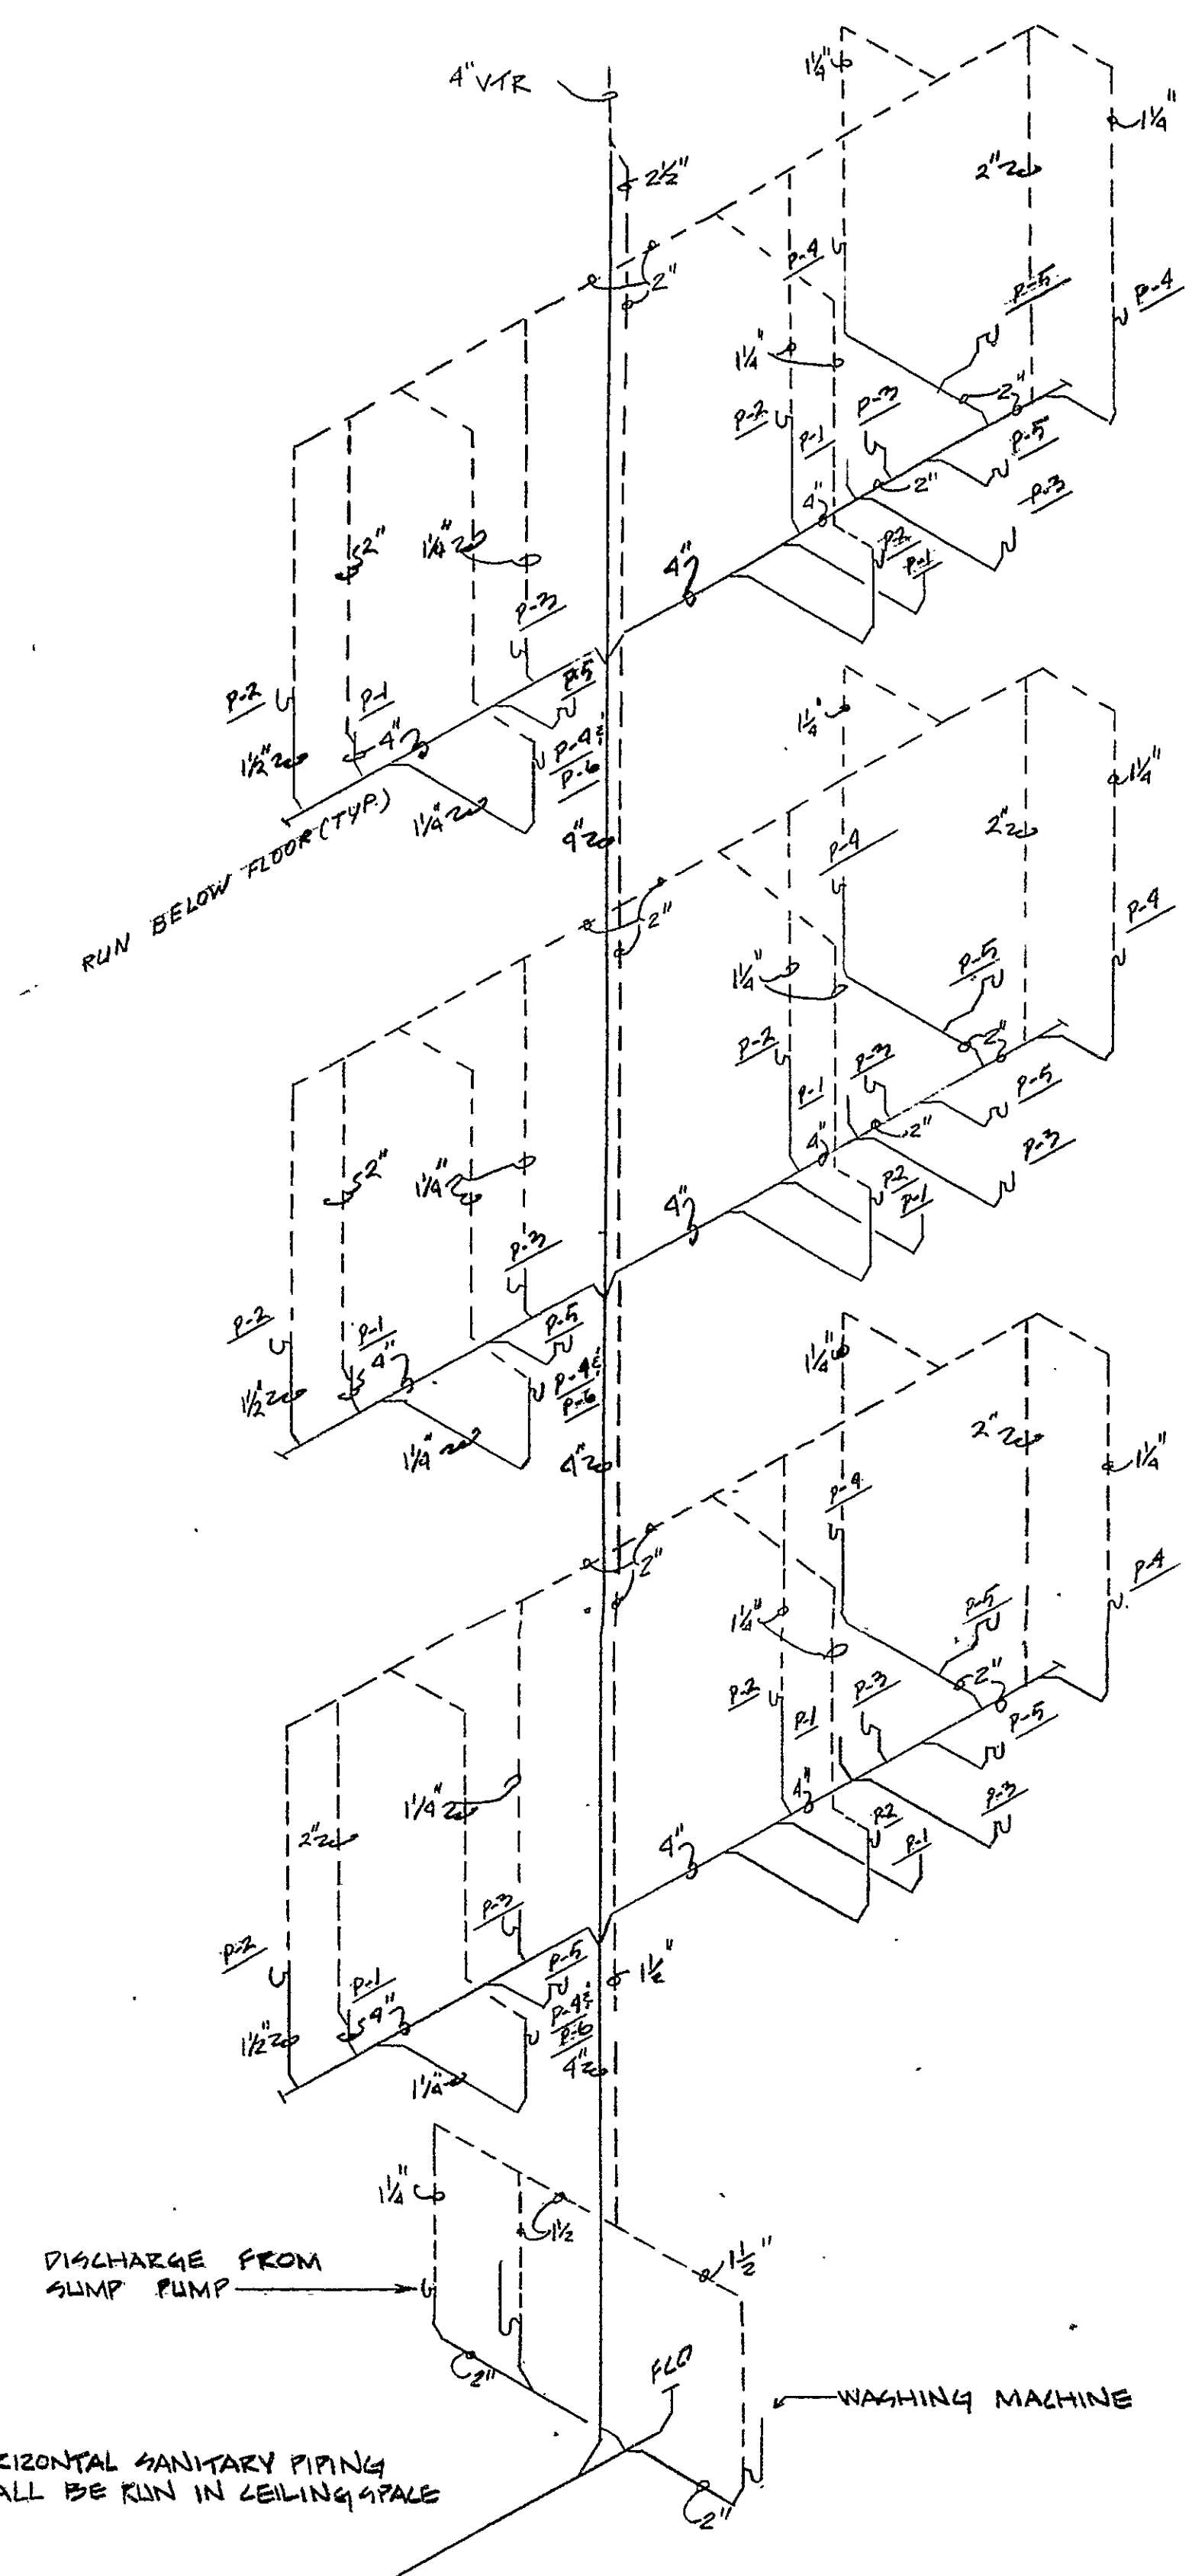

NOTE:
HORIZONTAL SANITARY PIPING
SHALL BE RUN IN CEILING SPACE

SANITARY & VENT PIPING DIAGRAM
NO SCALE

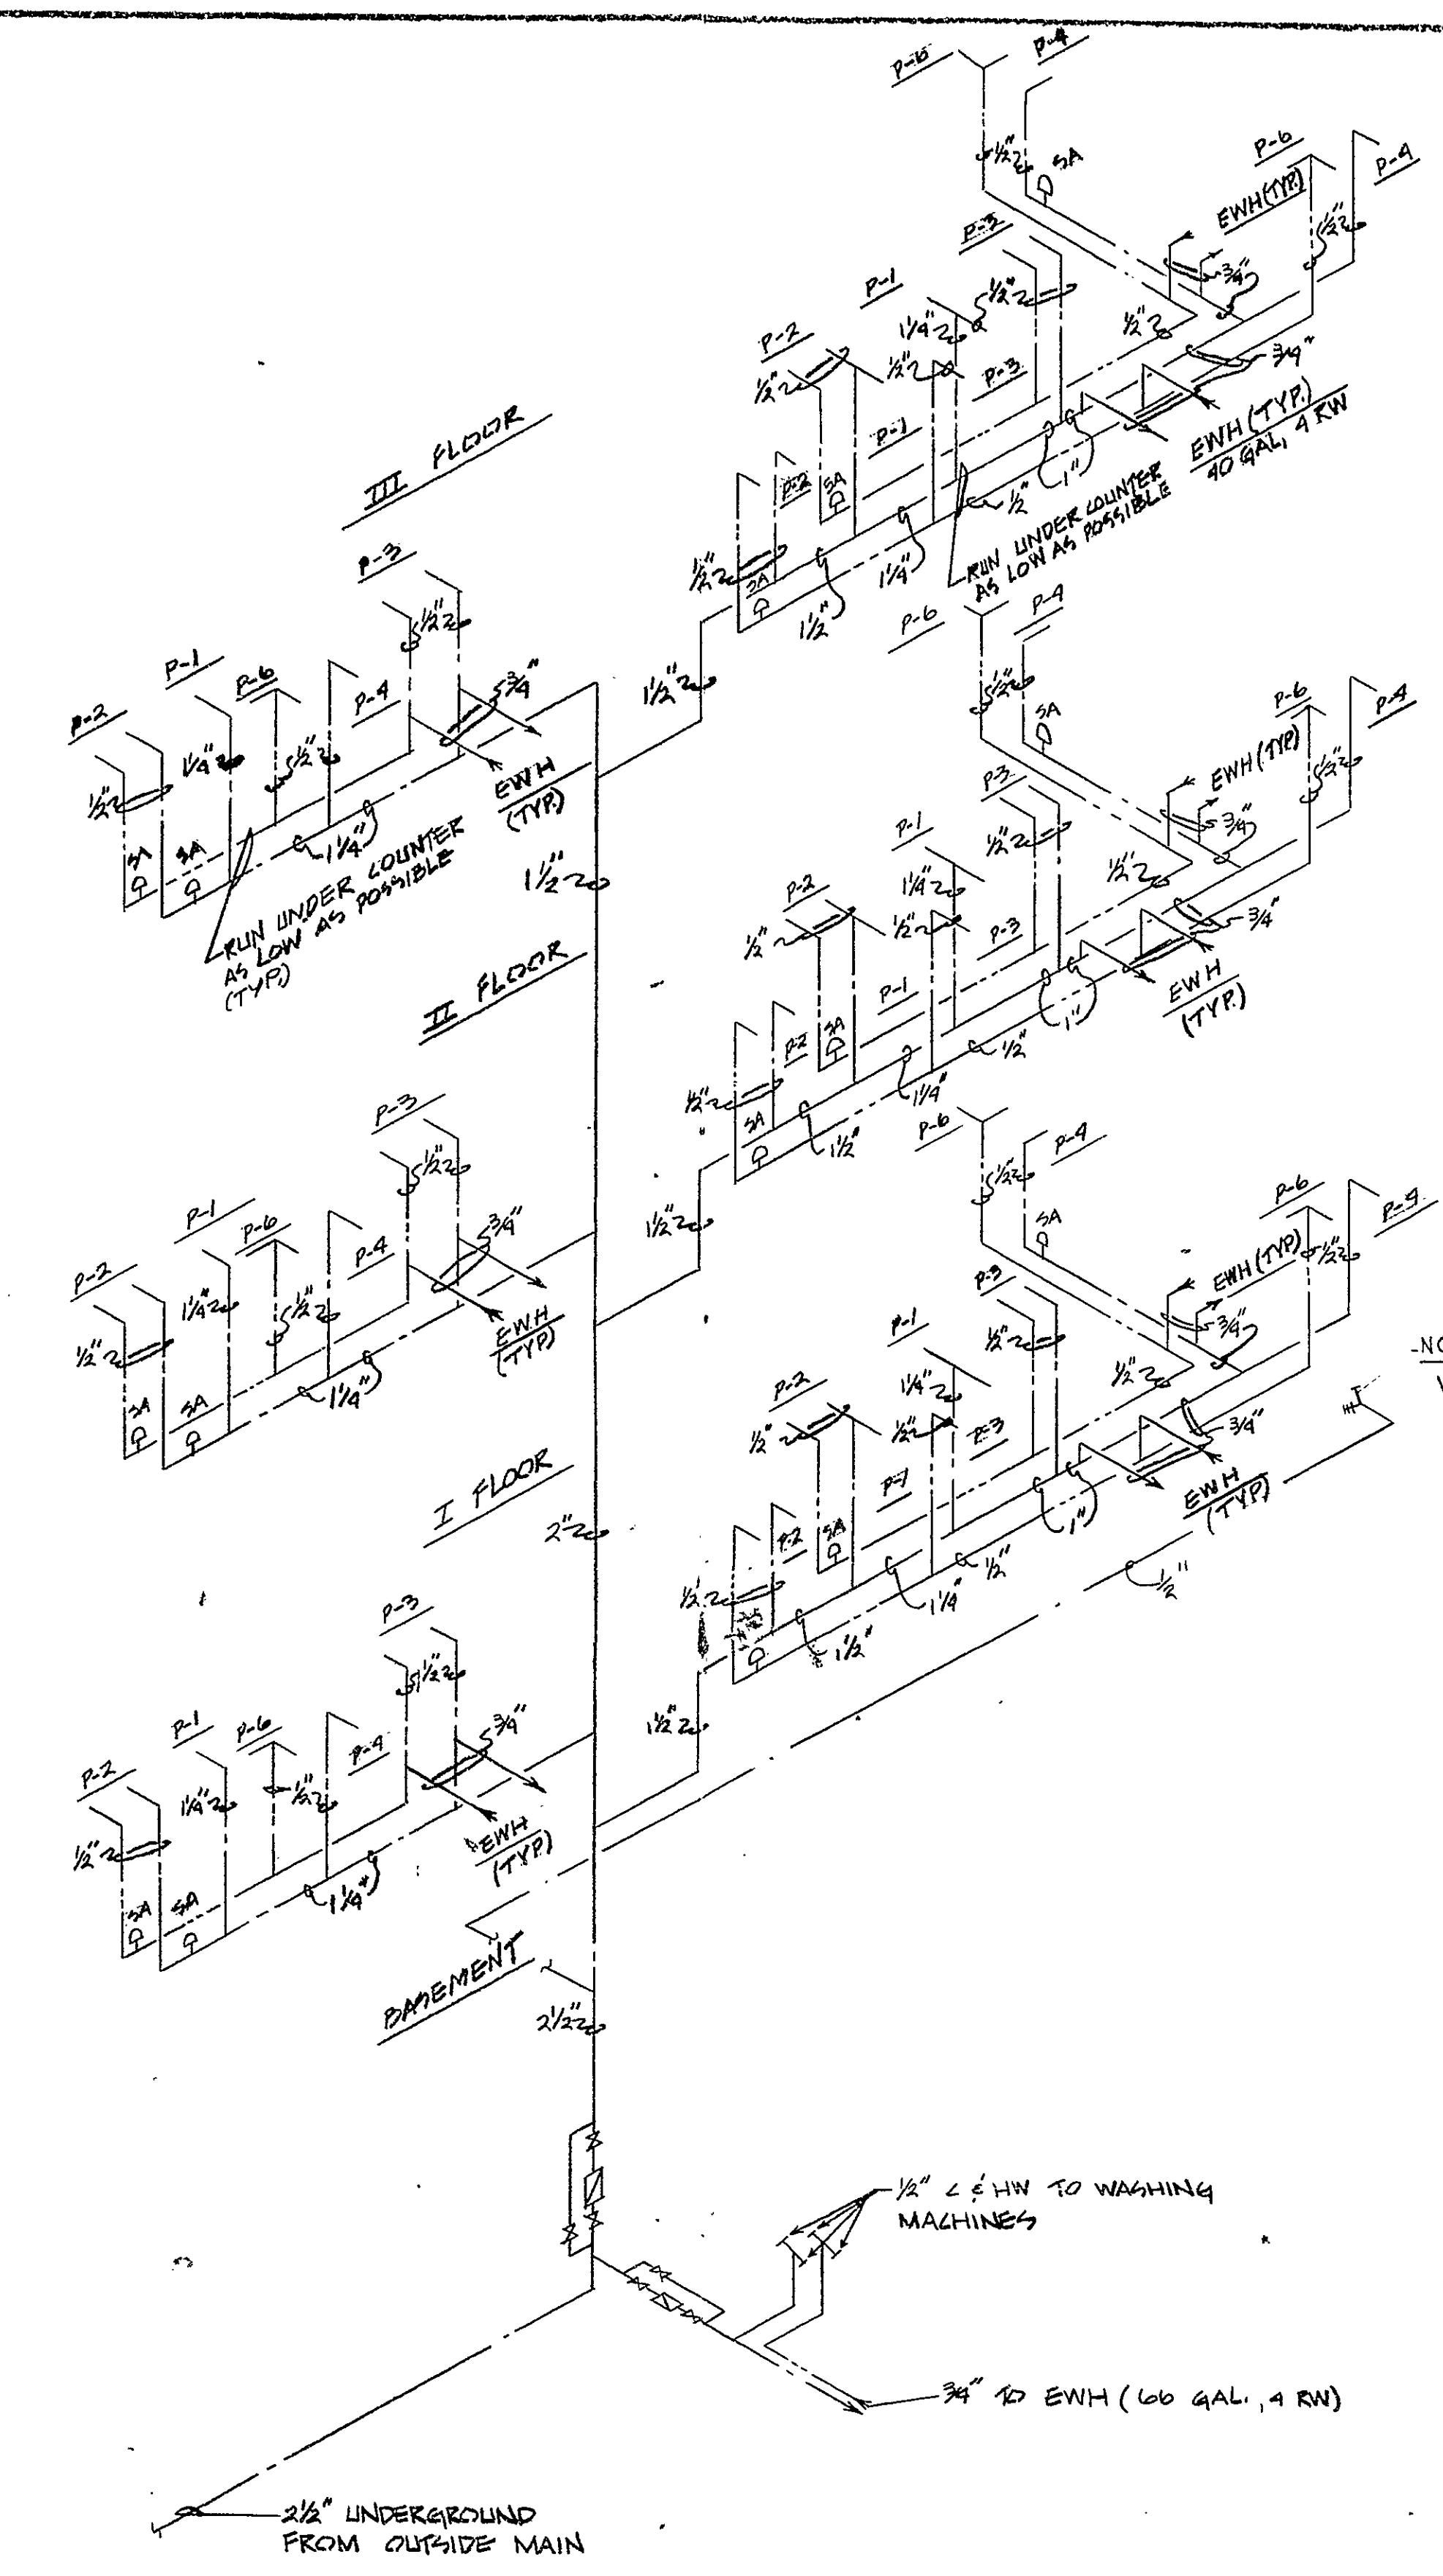


COLD & HOT WATER PIPING DIAGRAM
NO SCALE

LEGEND

- SANITARY & WASTE PIPE
- - - VENT PIPE
- COLD WATER (C.W.)
- HOT WATER (H.W.)
- PLUMBING FIXTURES (SEE SCHEDULE)
- EWH ELECTRIC WATER HEATER
- WATER METER
- SA SHOCK ABSORBER
- VTR VENT THRU ROOF

P #	TYPE OF FIXTURE	FIX. UNIT		DRAINAGE		WATER	
		DRAIN	WATER W.P.	V.P.	C.W.	H.W.	
P-1	WATERCLOSET	6	12	4"	2"	1 1/2"	-
P-2	LAVATORY	1	1	1 1/2"	1/4"	1/2"	1/2"
P-3	BATHTUB	2	2	2"	1/4"	1/2"	1/2"
P-4	KITCHEN SINK	2	2	1 1/2"	1/4"	1/2"	1/2"
P-5	FLOOR DRAIN (FOR EWH)	2	-	2"	1/4"	-	-
P-6	DISHWASHER	1	2	1 1/4"	1/4"	-	1/2"

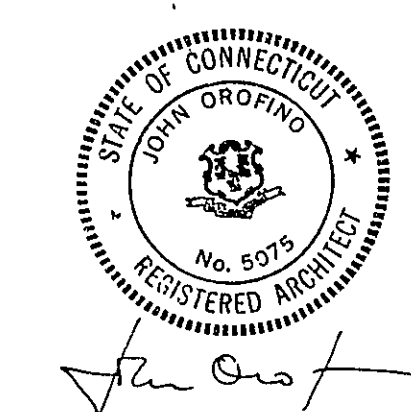

RECEIVED BY
Don A. Ballin

MARK NOTES
AUG 19 11 28 AM '80
TOWN & CITY CLERK
H.A. - ORD
VOL PAGE

REVISIONS

DRAWING TITLE
PLUMBING PLAN - TYPICAL

DRAWING No. **P.1** SHEET NO.

ATWOOD CONDOMINIUMS

DATE 27 JUNE 1980

RESOURCE DEVELOPMENT CORPORATION
999 AVENUE AVENUE
HARTFORD
CONNECTICUT
06105
203-246-8585

JOHN OROFINO-ARCHITECT