


RECEIVED
HARTFORD CONN.
AUG 21 11 33 AM '50
WILLIAM L. LORANE
TOWN & CITY CLERK

LEGEND

- ⊕ WATER SUPPLY & DRAIN
- ⊕ 110 VOLT DUPLEX OUTLET
- ⊕ 220 VOLT 3-PHASE OUTLET
- GAS OUTLET

NOTE: FINISH FLOOR THROUGHOUT A 2" x 6" SPACED
EASTERN 2" x 6" GRADE ELECTRIC CEILING FIXTURES
INSULATING THE CEILINGS THROUGHOUT
WALLS & FIRM PAINTED IN ORDER SELECTED BY ARCHITECT

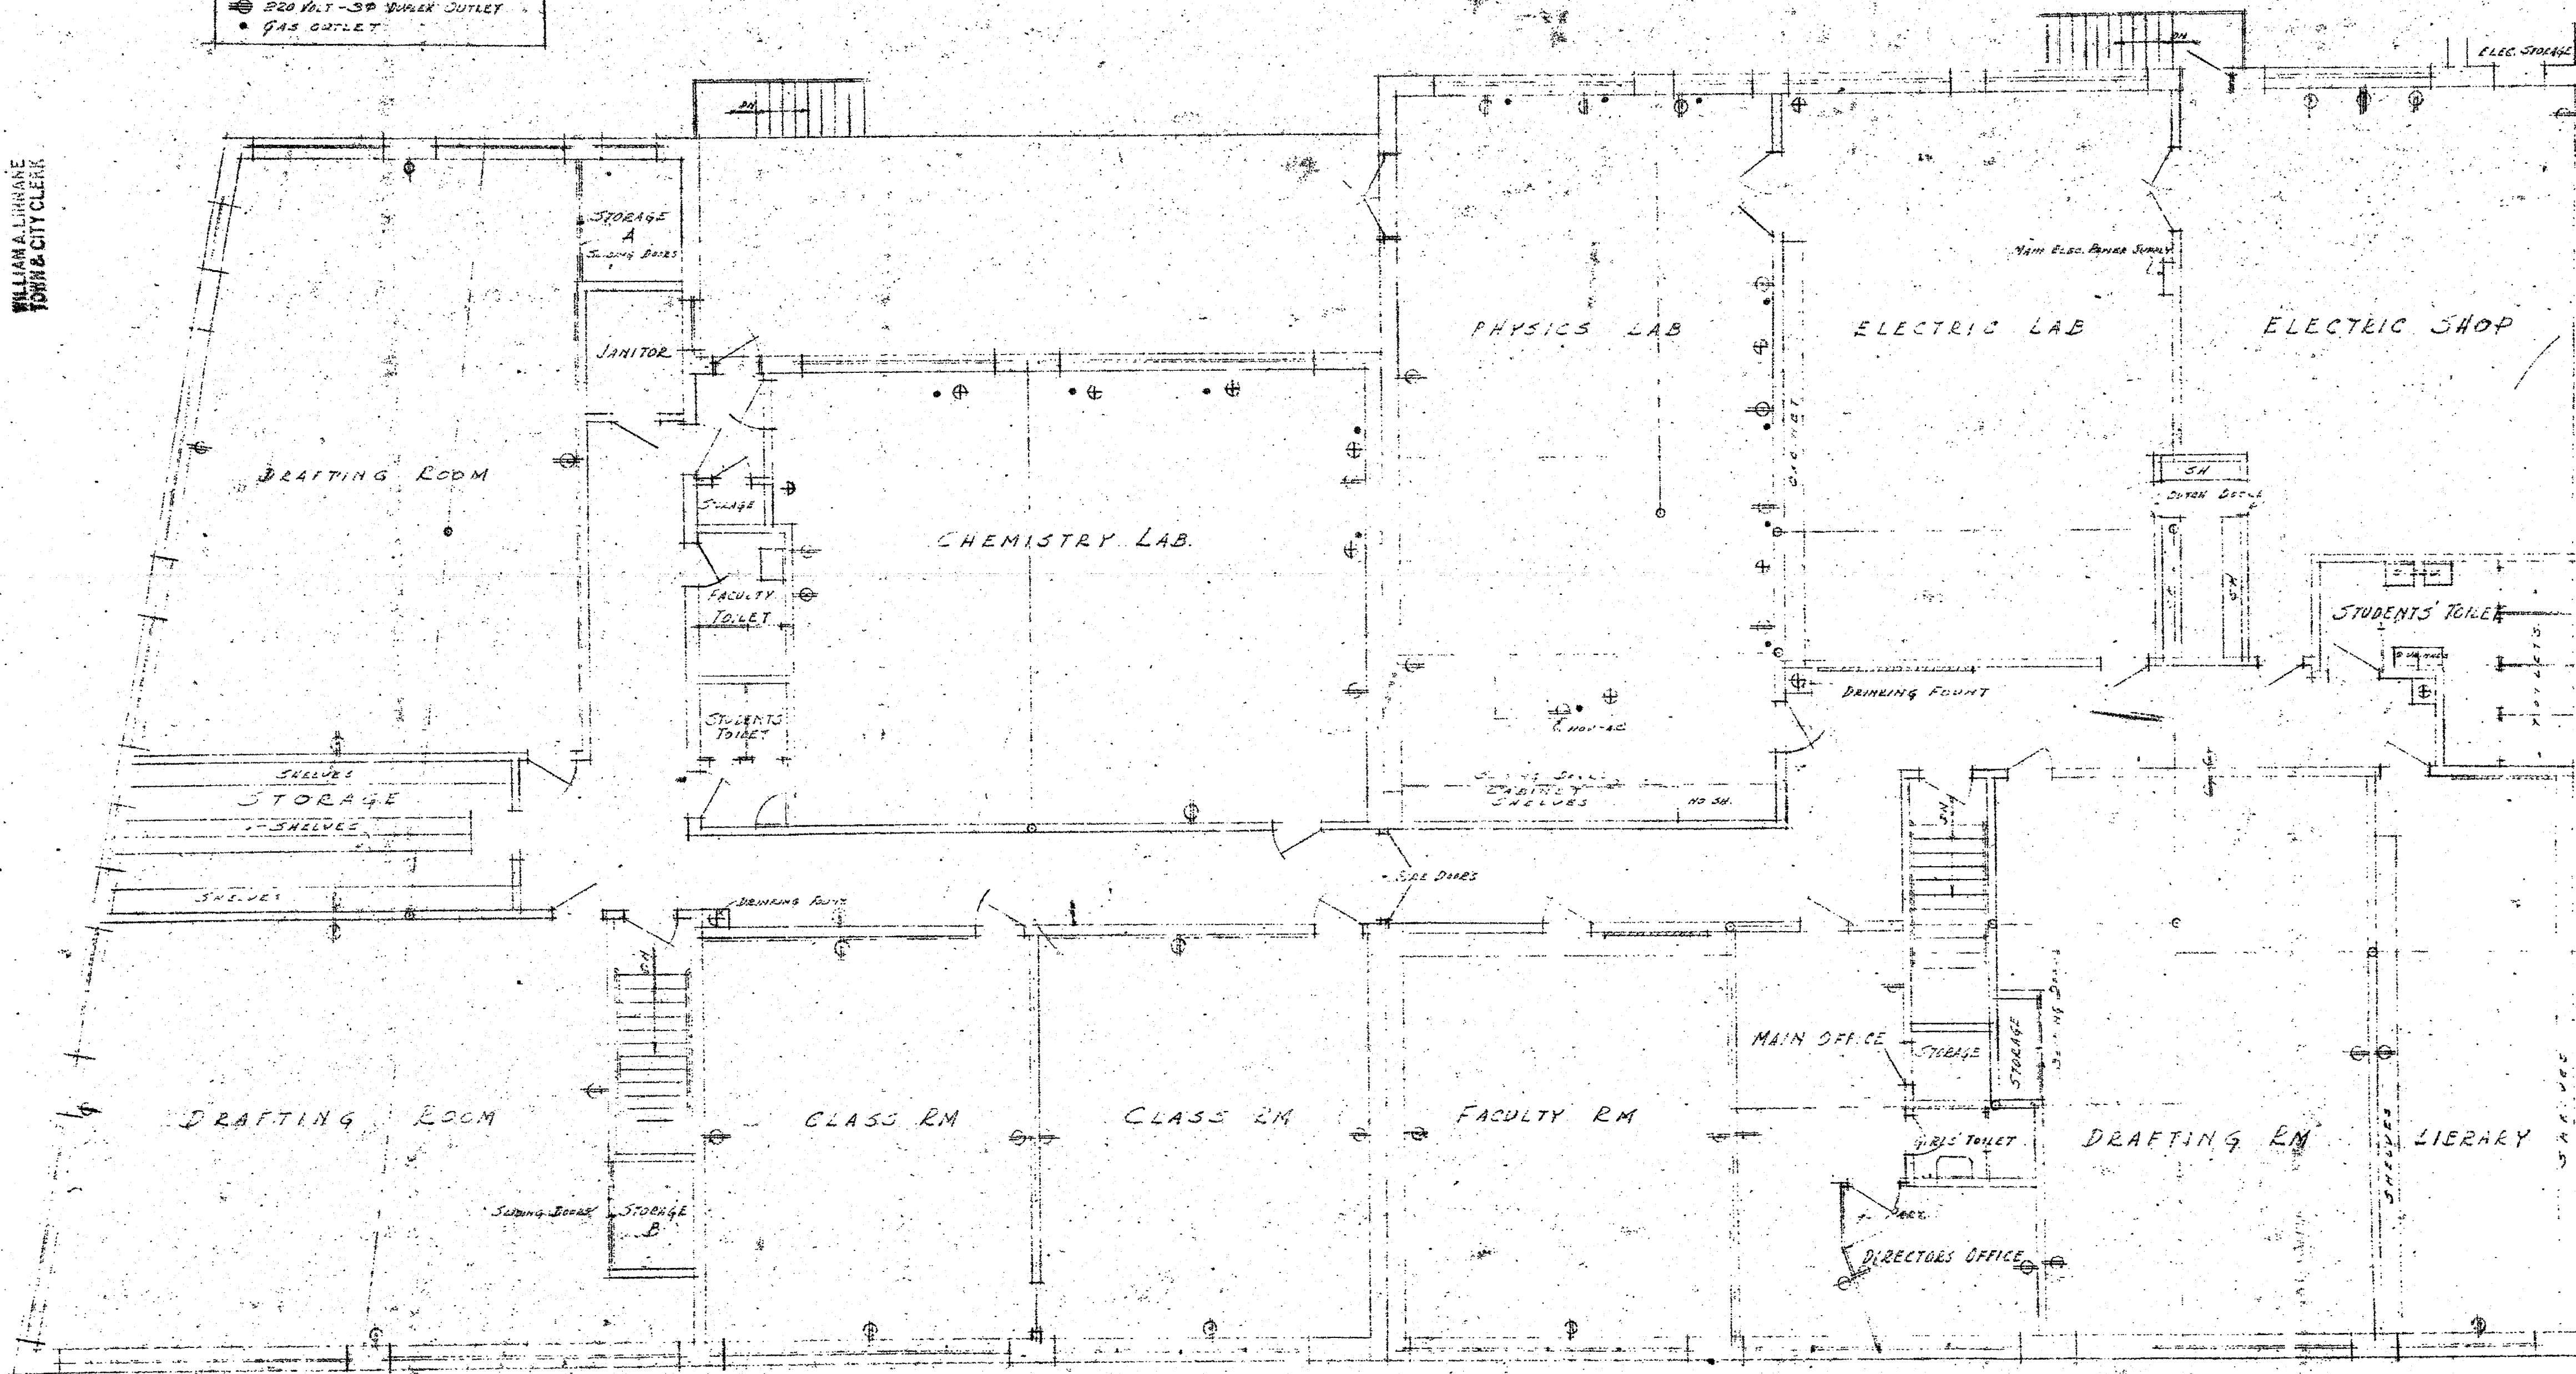

PROPOSED ALTERATIONS
AT NOS. 541-561 MAIN ST. HARTFORD CONN.
FOR THE WEST REALTY CO.

SECOND FLOOR PLAN

JULIUS BERENSON ARCHITECT
40 FOREST ST. HARTFORD CONN.
COND. NO. 1614-A
SCALE 1/4" = 1'-0"
DATE 7-1-50