

E&P FILE NO. 806 806	E&P NO.
-------------------------	---------


The portion of Enfield Street and Winchester Street shown on this plan are established public streets of the City of Hartford.

Robert J. Pittman, Jr.
City Engineer

September 19, 1966

LEGEND

- TRANSCLUSURE
- 2'x2'x2' SERVICE BOX
- METER LOCATION
- PRIMARY CONDUIT
- - - SECONDARY CONDUIT

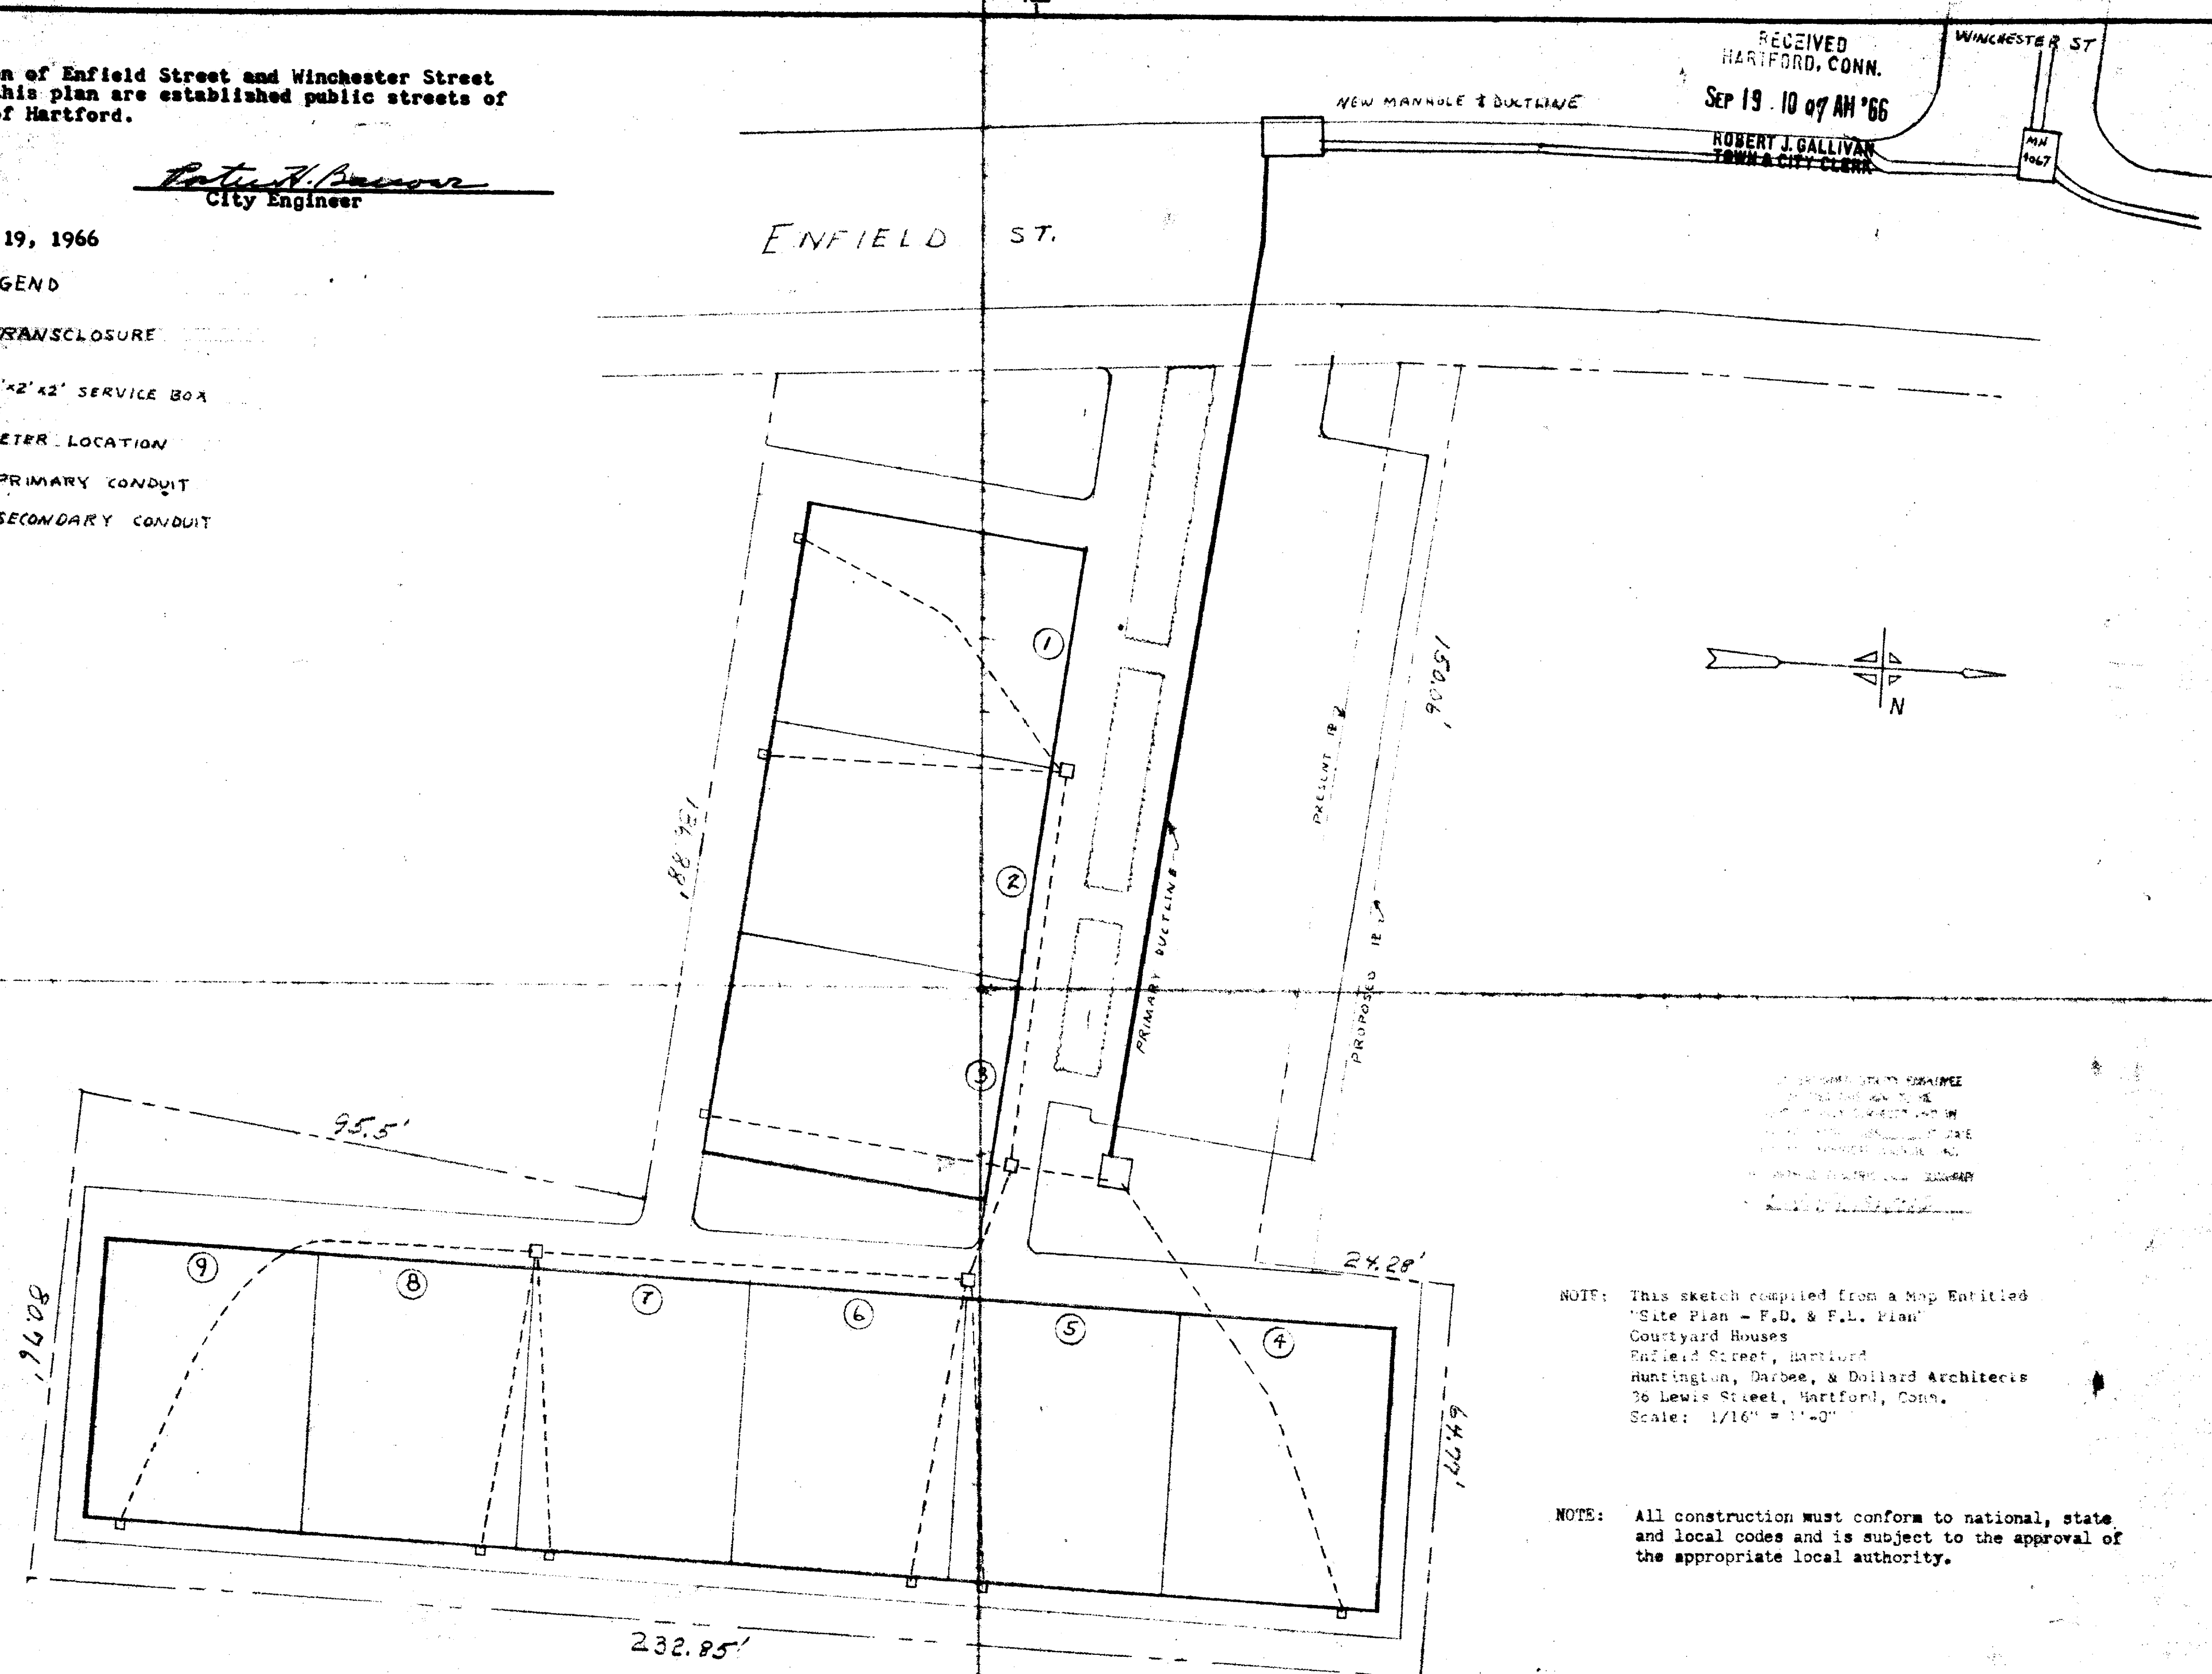

RECEIVED
HARTFORD, CONN.
SEP 19 10 07 AM '66
ROBERT J. GALLIVAN
TOWN & CITY CLERK

NOTE: This sketch compiled from a Map Entitled "Site Plan - F.D. & F.L. Plan" Courtyard Houses, Enfield Street, Hartford, Huntington, Darlow, & Dillard Architects, 26 Lewis Street, Hartford, Conn. Scale: 1/16" = 1'-0"

NOTE: All construction must conform to national, state and local codes and is subject to the approval of the appropriate local authority.

Sketch showing facilities of The Hartford Electric Light Company on the property of Leroy Pittman, Jr., 264-266 Enfield Street, Hartford. Scaled 1/16" = 1'-0" June 7, 1966 File No. D-51271

THE HARTFORD ELECTRIC LIGHT CO.
ELECTRIC OPERATIONS DEPARTMENT

DRAWN BY LVG CHECKED BY _____ APPROVED BY _____
SCALE 1" = 20'
DATE 6-7-66 NO. _____

NO.	DATE	DESCRIPTION	BY	APP. BY

