


JUL 10 12 49 PM '85
VOL. 1 PAGE 1

LEGEND

- 3PHASE PRIMARIES
- QUADRAPLEX SERVICE
- POLE
- ANCHOR
- 3PHASE TRANSFORMER BANK

EXISTING FACILITIES

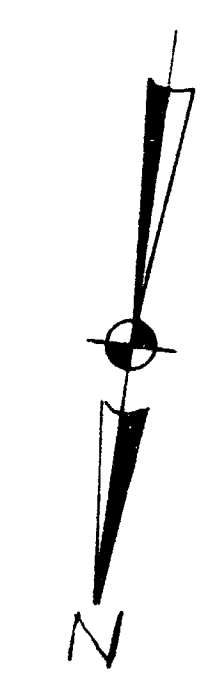

THE UNDERSIGNED UTILITY EMPLOYEE
CERTIFIES THIS MAP TO BE
"SUBSTANTIALLY CORRECT" AND IN
ACCORDANCE WITH CLASS D OF CODE
OF "N.Y. TECHNICAL COUNCIL, INC."
THE CONNECTICUT LIGHT AND POWER COMPANY
PER *Donald Albert*

THIS SKETCH COMPILED FROM A
MAP ENTITLED:
SITE PLAN SHOWING PROPERTY
OF FRANK T. & MARY P. CAPETTA
PARCEL A
SCALE 1"=20' 10/20/83
DRAWN BY: R.J. CARLO

#253 LOCUST ST

PARCEL "A"

PARCEL "B"

LOCUST STREET

392.87'

The portion of Locust St. shown on this plan
is an established public street of the City of
Hartford.
7/11/85 Date *James C. Milazzo*
City Engineer

DRAWN BY	B.E.W.
CHECKED BY	SJK
APPROVED BY	RJC

THE CONNECTICUT LIGHT AND POWER COMPANY
FACILITIES ON THE PROPERTY OF
SALVATOR G AND ROSALIE MILAZZO
255 LOCUST ST HARTFORD CONN
SCALE 1"=20' DATED 3-22-85
NUMBER E-C-J06L2-1446

1439

