


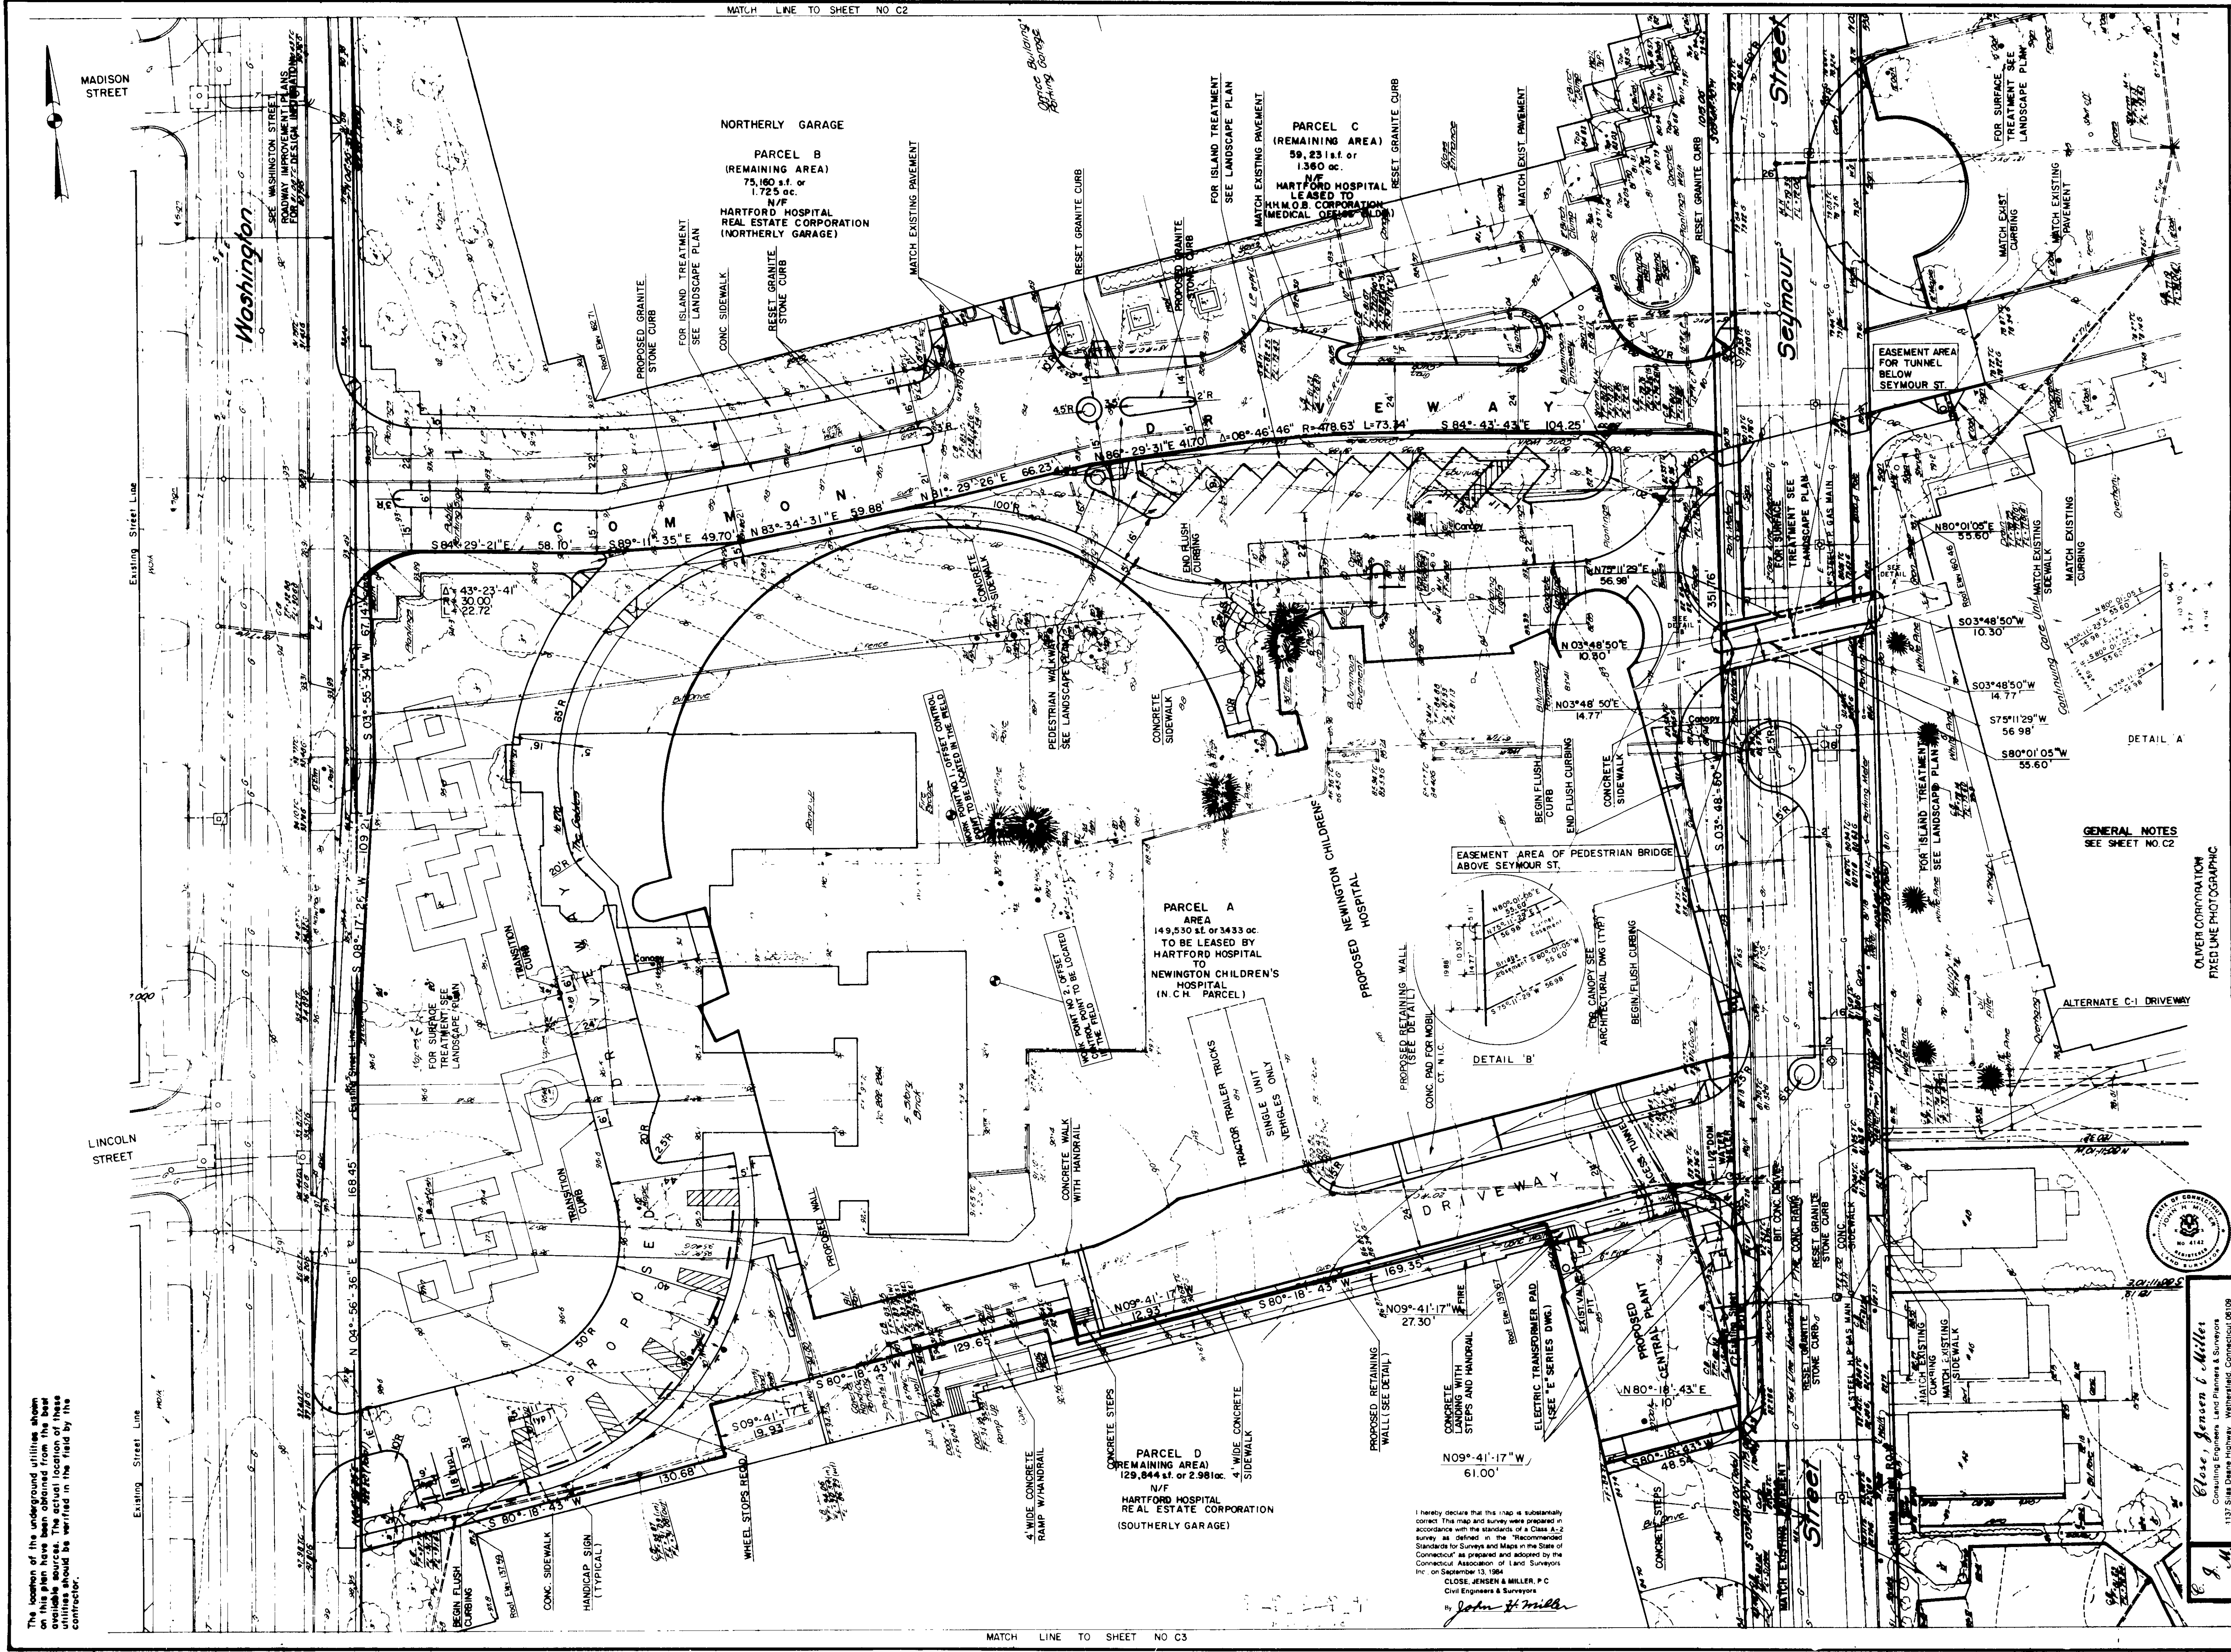

HKS

1400 Inc. Architects/Engineers/Planners
1111 Plaza of the Americas North, LB307
Dallas, Texas 75201 214/969-6599

**THE NEW NEWTON HOSPITAL
CHILDREN'S HOSPITAL**

HARTFORD, CT

OLIVER CORPORATION
FIXED LINE PHOTOGRAPHIC

NEWINGTON CHILDREN'S HOSPITAL

HARTFORD, CT

PROPERTY TO BE
LEASED TO
NEWINGTON CHILDREN'S HOSPITAL

SITE PLAN

SCALE: 1" = 20'
5/13/94