

INDEX TO DRAWINGS

SHEET NO.	DESCRIPTION	FILE NO.
1	PROJECT LOCATION AND INDEX	CT-4-2606
2	HYDROGRAPH NO. 1, CONNECTICUT RIVER	CT-3-1174
3	HYDROGRAPH NO. 2, CONNECTICUT RIVER	CT-3-1175
4	HYDROGRAPH PARK RIVER	CT-3-1173
5	SUBSURFACE EXPLORATIONS NO. 1	CT-2-1286
6	SUBSURFACE EXPLORATIONS NO. 2	CT-2-1287
7	SUBSURFACE EXPLORATIONS NO. 3	CT-2-1288
8	SUBSURFACE EXPLORATIONS NO. 4	CT-2-1289
9	CONTRACTOR'S WORK AREAS	CT-4-2607
10	PLAN AND PROFILE NO. 1	CT-4-2608
11	PLAN AND PROFILE NO. 2	CT-4-2609
12	PLAN AND PROFILE NO. 3	CT-4-2610
13	PLAN AND PROFILE NO. 4	CT-4-2611
14	PLAN AND PROFILE NO. 5	CT-4-2612
15	PLAN AND PROFILE NO. 6	CT-4-2613
16	CONDUIT SECTIONS NO. 1	CT-4-2614
17	CONDUIT SECTIONS NO. 2	CT-4-2615
18	PILING NO. 1	CT-4-2616
19	PILING NO. 2	CT-4-2617
20	PARK RIVER INTERCEPTOR SIPHON DETAILS NO. 1	CT-4-2618
21	PARK RIVER INTERCEPTOR SIPHON DETAILS NO. 2	CT-4-2619
22	SIPHON INLET CHAMBER DETAILS	CT-4-2620
23	SIPHON INLET CHAMBER STEEL REINFORCEMENT	CT-4-2621
24	SIPHON OUTLET CHAMBER DETAILS	CT-4-2622
25	SIPHON OUTLET CHAMBER STEEL REINFORCEMENT	CT-4-2623
26	INLET STRUCTURE WALLS	CT-4-3040
27	INLET STRUCTURE WALL REINFORCEMENT NO. 1	CT-4-2625
28	INLET STRUCTURE WALL ELEVATIONS	CT-4-2626
29	MISCELLANEOUS INLET DETAILS	CT-4-2627
30	OUTLET STRUCTURE DETAILS NO. 1	CT-4-2628
31	OUTLET STRUCTURE DETAILS NO. 2	CT-4-2629
32	OUTLET STRUCTURE STEEL REINFORCEMENT NO. 1	CT-4-2630
33	OUTLET STRUCTURE STEEL REINFORCEMENT NO. 2	CT-4-2631
34	CONNECTICUT RIVER INTERCEPTOR AND HUDSON ST. SIPHONS	CT-4-2632
35	DRAIN CHAMBERS	CT-4-2633
36	DRAIN MANHOLES AND CATCHBASINS	CT-4-2634
37	SEWER CONNECTIONS NO. 1	CT-4-2635
38	SEWER CONNECTIONS NO. 2	CT-4-2636
39	MISCELLANEOUS DETAILS	CT-4-2637
40	TEMPORARY WATER LINE TO THE DUTCH POINT LIGHTING PLANT	CT-4-2706
19A	PILING NO. 3 (NOT IN CONTRACT)	CT-4-3045
41	GULLY BROOK CONNECTION AND TRANSITION	CT-4-3067
42	TILE STAFF GAGES	CT-4-3122
43	CONDUIT SECTIONS 1A	CT-4-3138
44	CONDUIT SECTIONS 2A	CT-4-3139
45	BUSHNELL PARK CONNECTIONS	CT-4-3141
46	TEMPORARY FLOOD PROTECTION AT PROSPECT ST.	CT-4-3142

CONNECTICUT RIVER FLOOD CONTROL

PARK RIVER CONDUIT

HARTFORD, CONN.

PROJECT LOCATION AND INDEX

CONNECTICUT RIVER CONNECTICUT

IN 48 SHEETS SCALE 1 IN. = 400 FT. SHEET NO. 1



U.S. ENGINEER OFFICE PROVIDENCE, R.I. MAY 1940

REVIEWED: *[Signature]* APPROVAL RECOMMENDED: *[Signature]* APPROVED: *[Signature]*

ENGINEER: *[Signature]* PRINCIPAL ENGINEER: *[Signature]* CHIEF F.C. ENGINEERING DIV.: *[Signature]* DISTRICT ENGINEER: *[Signature]*

SUBMITTED: *[Signature]* (PARTNER) TRACED BY: E.S.B. FILE NO. CT-4-2606

METCALF & EDDY BOSTON, MASS. CHECKED BY: R.W.T.

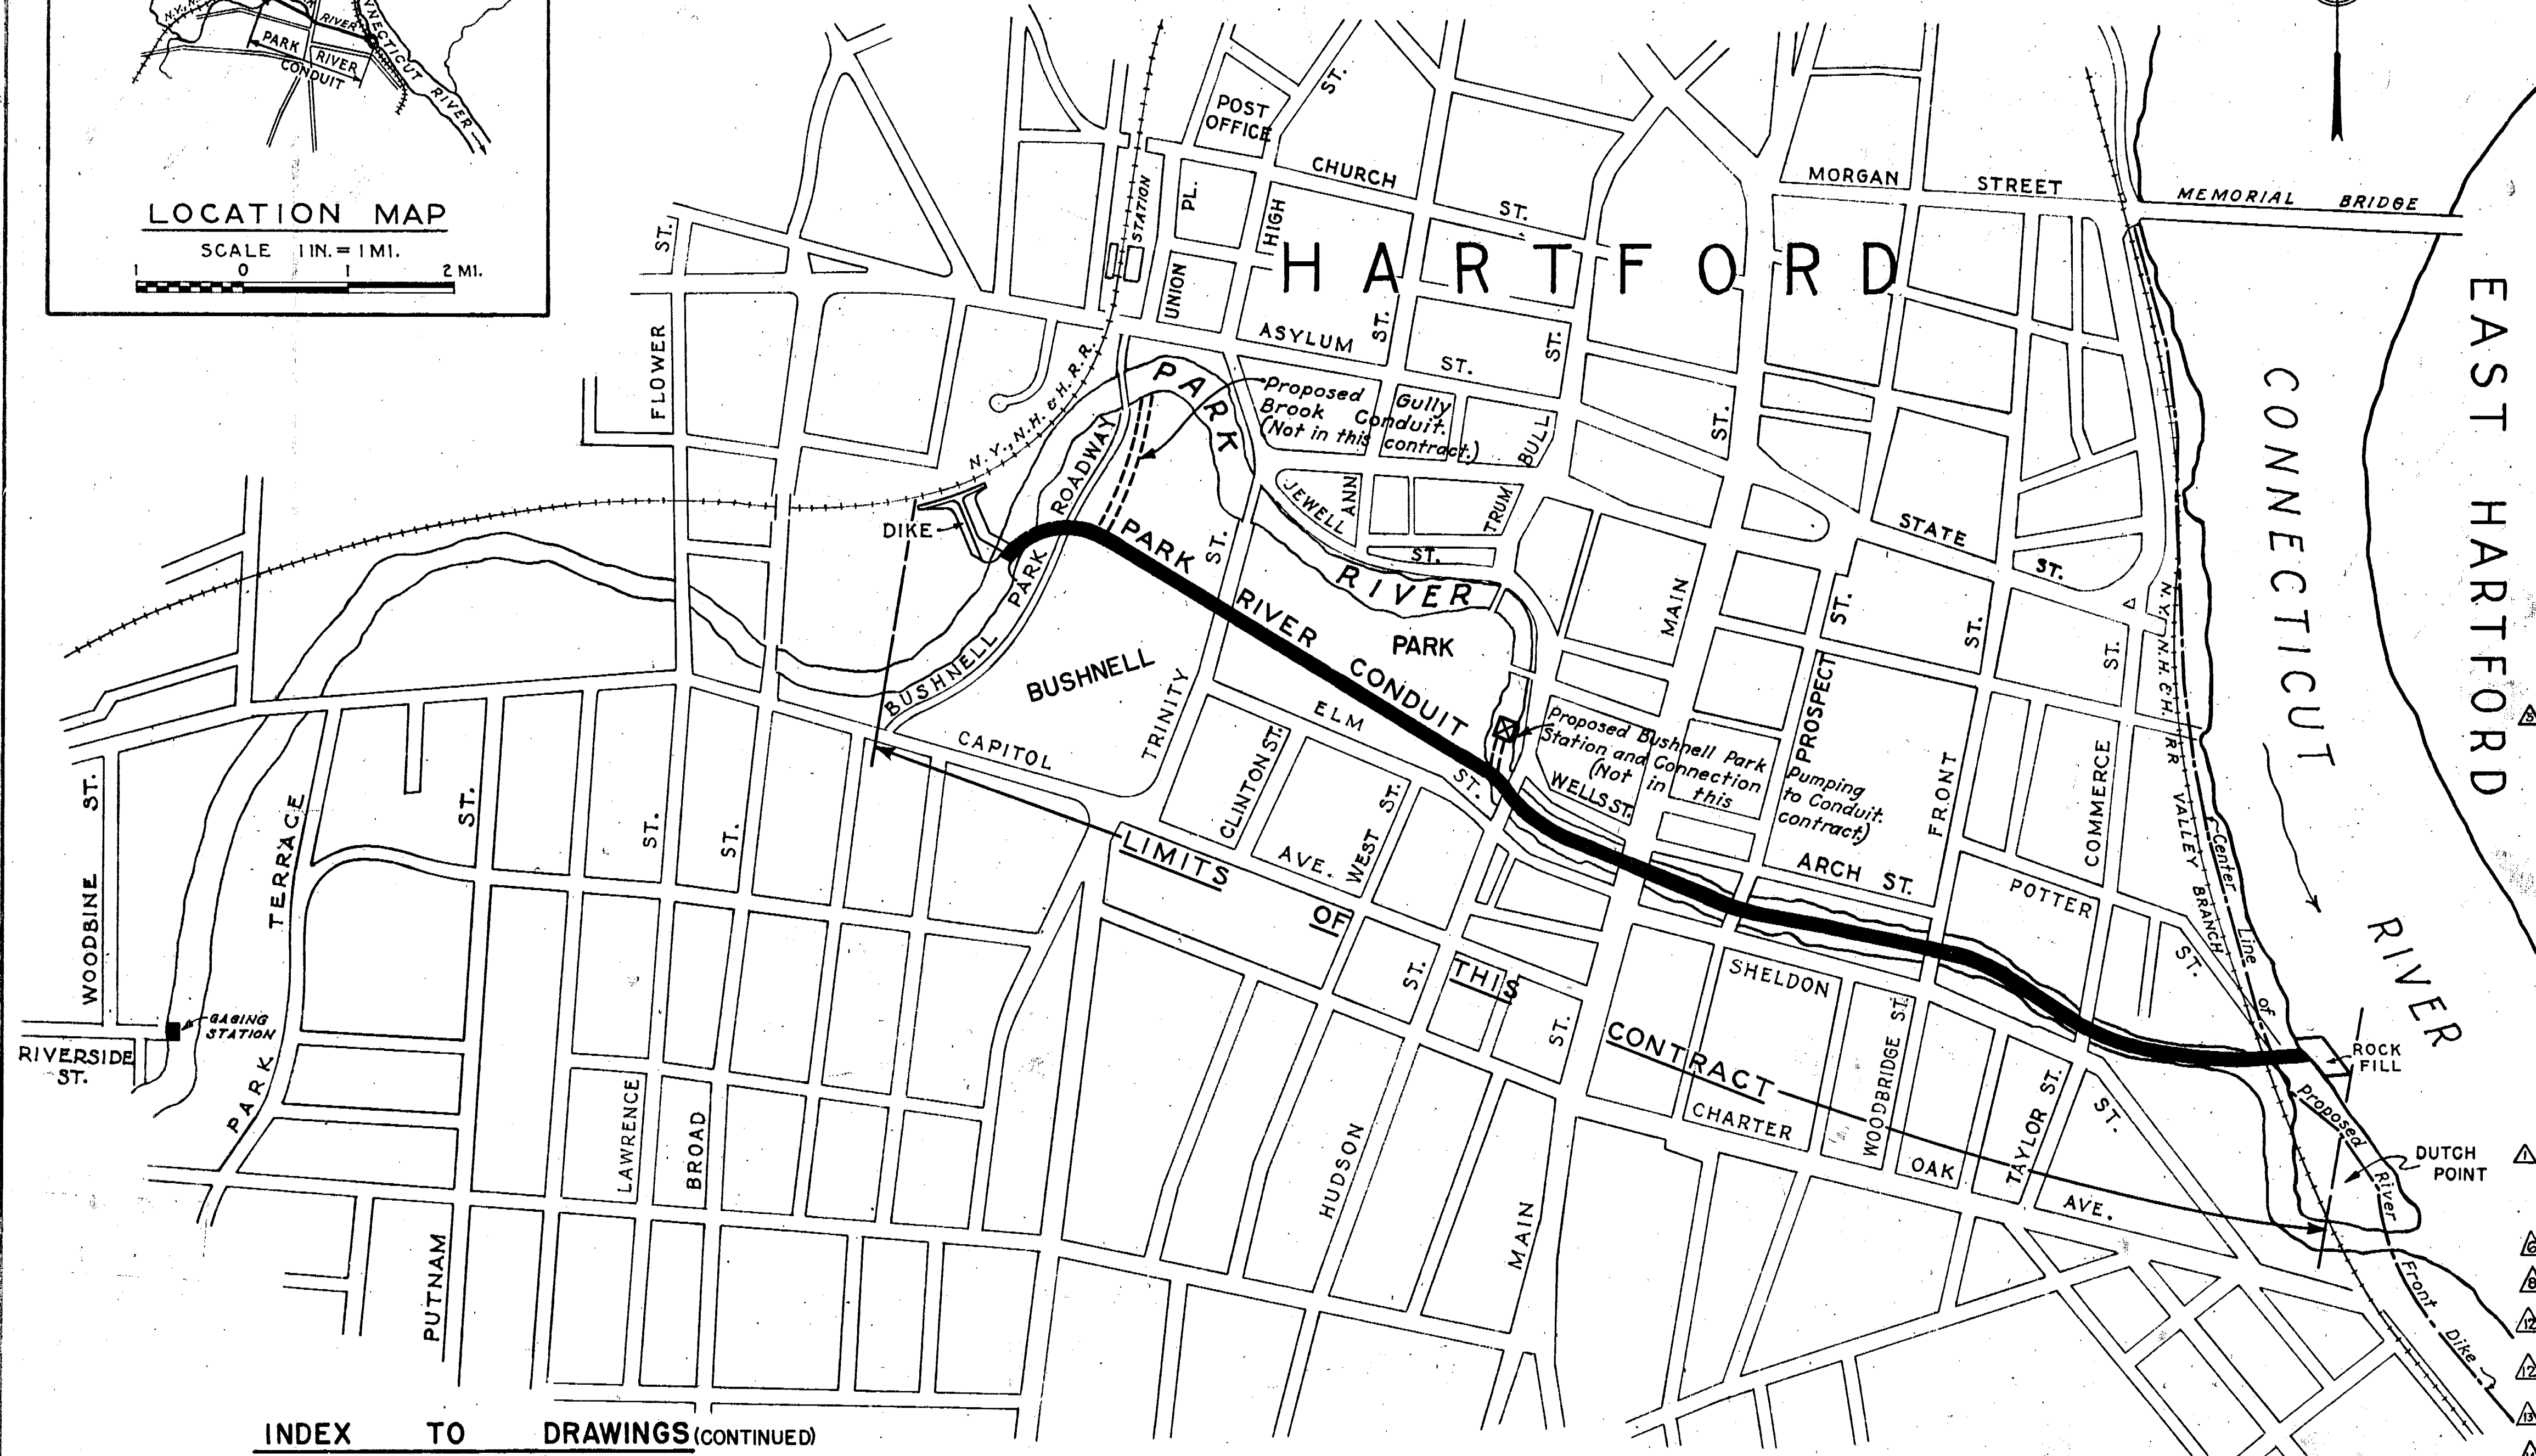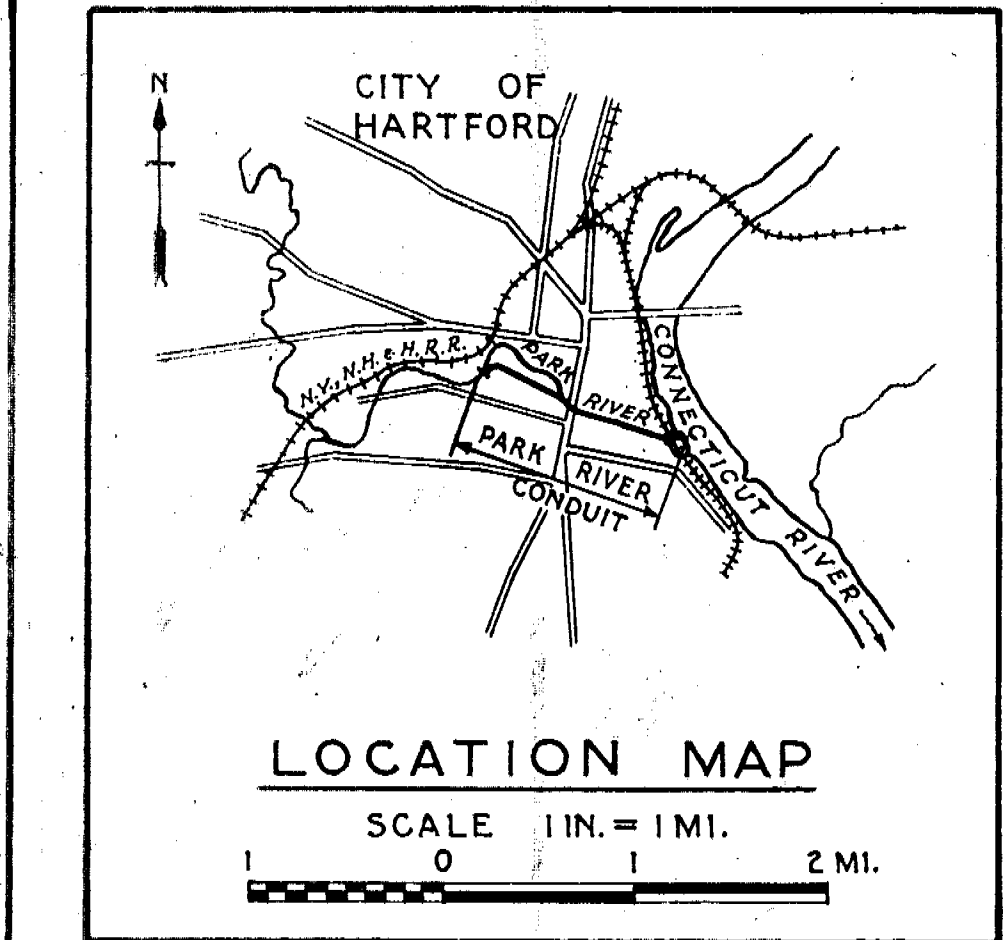

INDEX TO DRAWINGS (CONTINUED)

SHEET NO.	DESCRIPTION	FILE NO.
47	TEMPORARY SHEET PILING BULKHEAD AT PROSPECT ST.-PLAN AND SECTION	CT-4-3143
48	TEMPORARY SHEET PILING BULKHEAD AT PROSPECT ST.-DETAILS	CT-4-3144

VICINITY MAP
SCALE 1 IN. = 400 FT.

METCALF & EDDY
ENGINEERS
BOSTON, MASS.

12-31-45	As built			
11-17-43	Sheets Nos. 10, 11, 12, 13, 34, 37 & 38 revised	E.D.C.	<i>[Signature]</i>	<i>[Signature]</i>
3/13/43	Sheets Nos. 47 and 48 added	E.D.C.	<i>[Signature]</i>	<i>[Signature]</i>
9/12/42	Sheet No. 46 added	E.D.C.	<i>[Signature]</i>	<i>[Signature]</i>
4/22/42	Sheet No. 42 added	E.D.C.	<i>[Signature]</i>	<i>[Signature]</i>
8/30/41	Sheet No. 41 added	E.D.C.	<i>[Signature]</i>	<i>[Signature]</i>
7-10-41	File No. changed	E.D.C.	<i>[Signature]</i>	<i>[Signature]</i>
10-7-40	Sheet No. 40 added	P.C.H.	<i>[Signature]</i>	<i>[Signature]</i>
KEY	DATE	REVISION (Indicated by Δ)	REV. BY	CK. BY