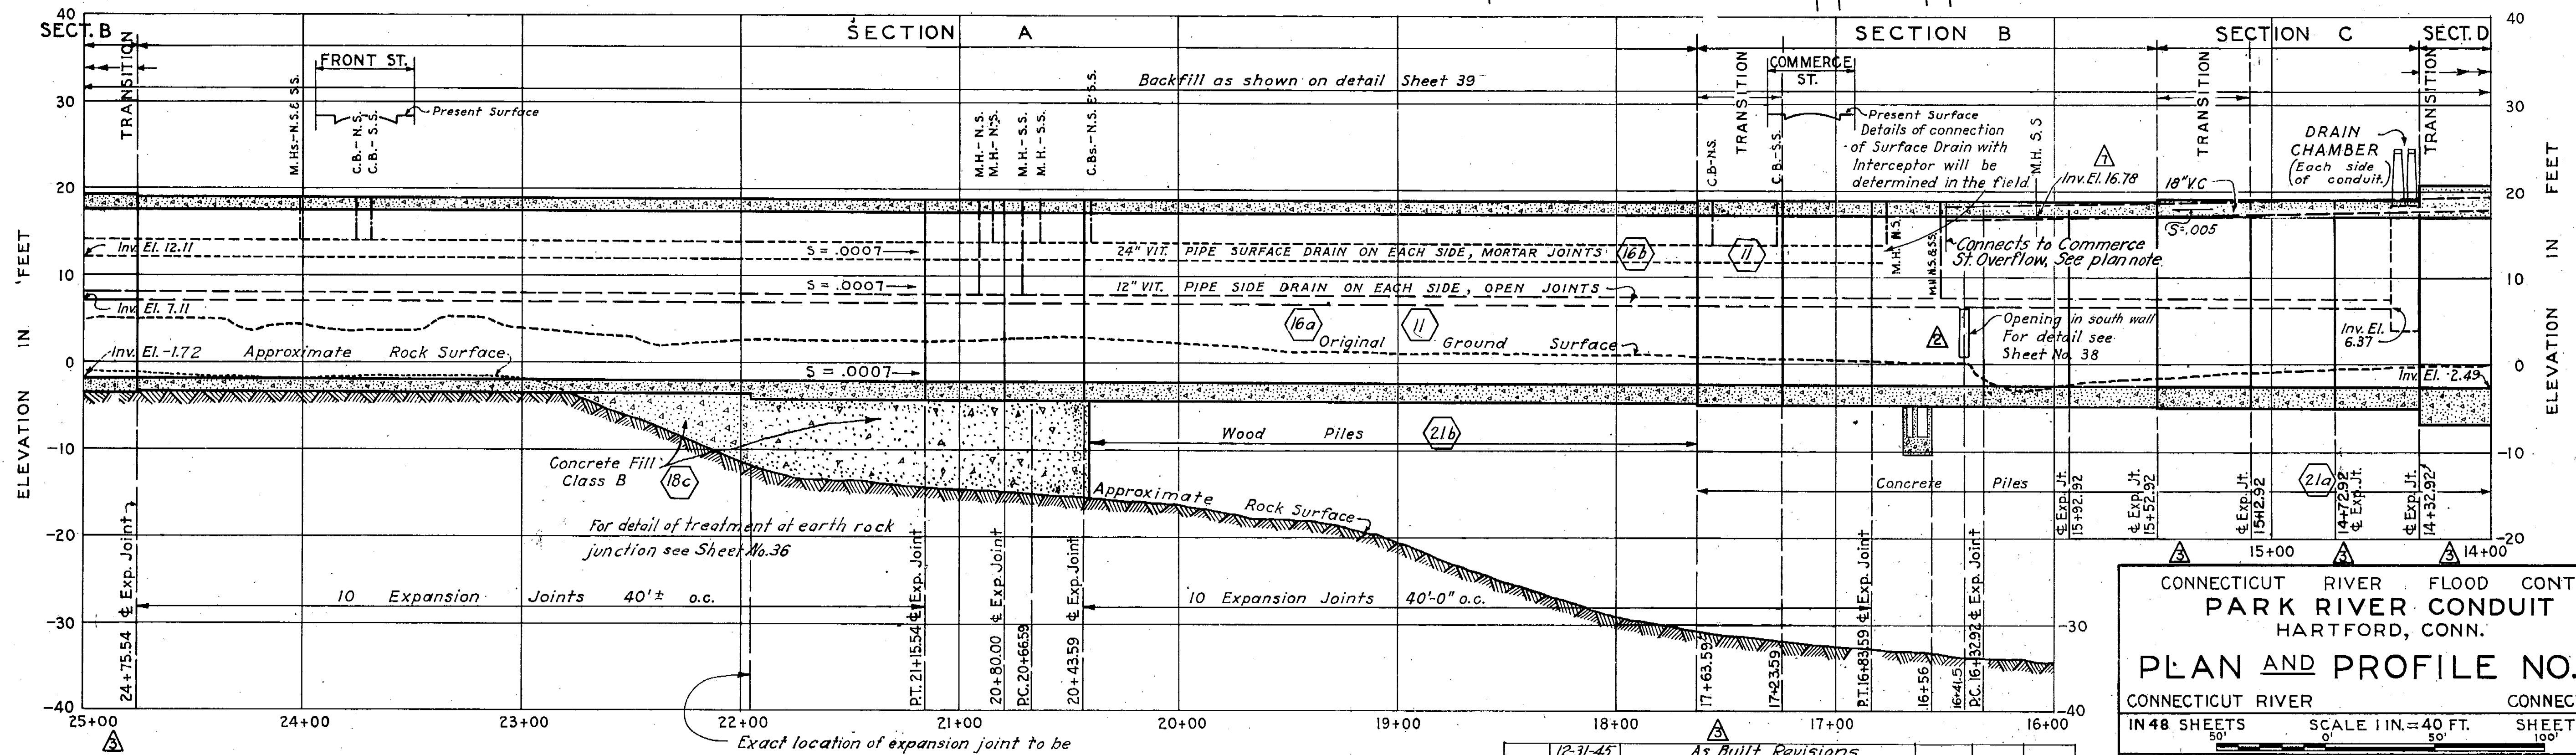
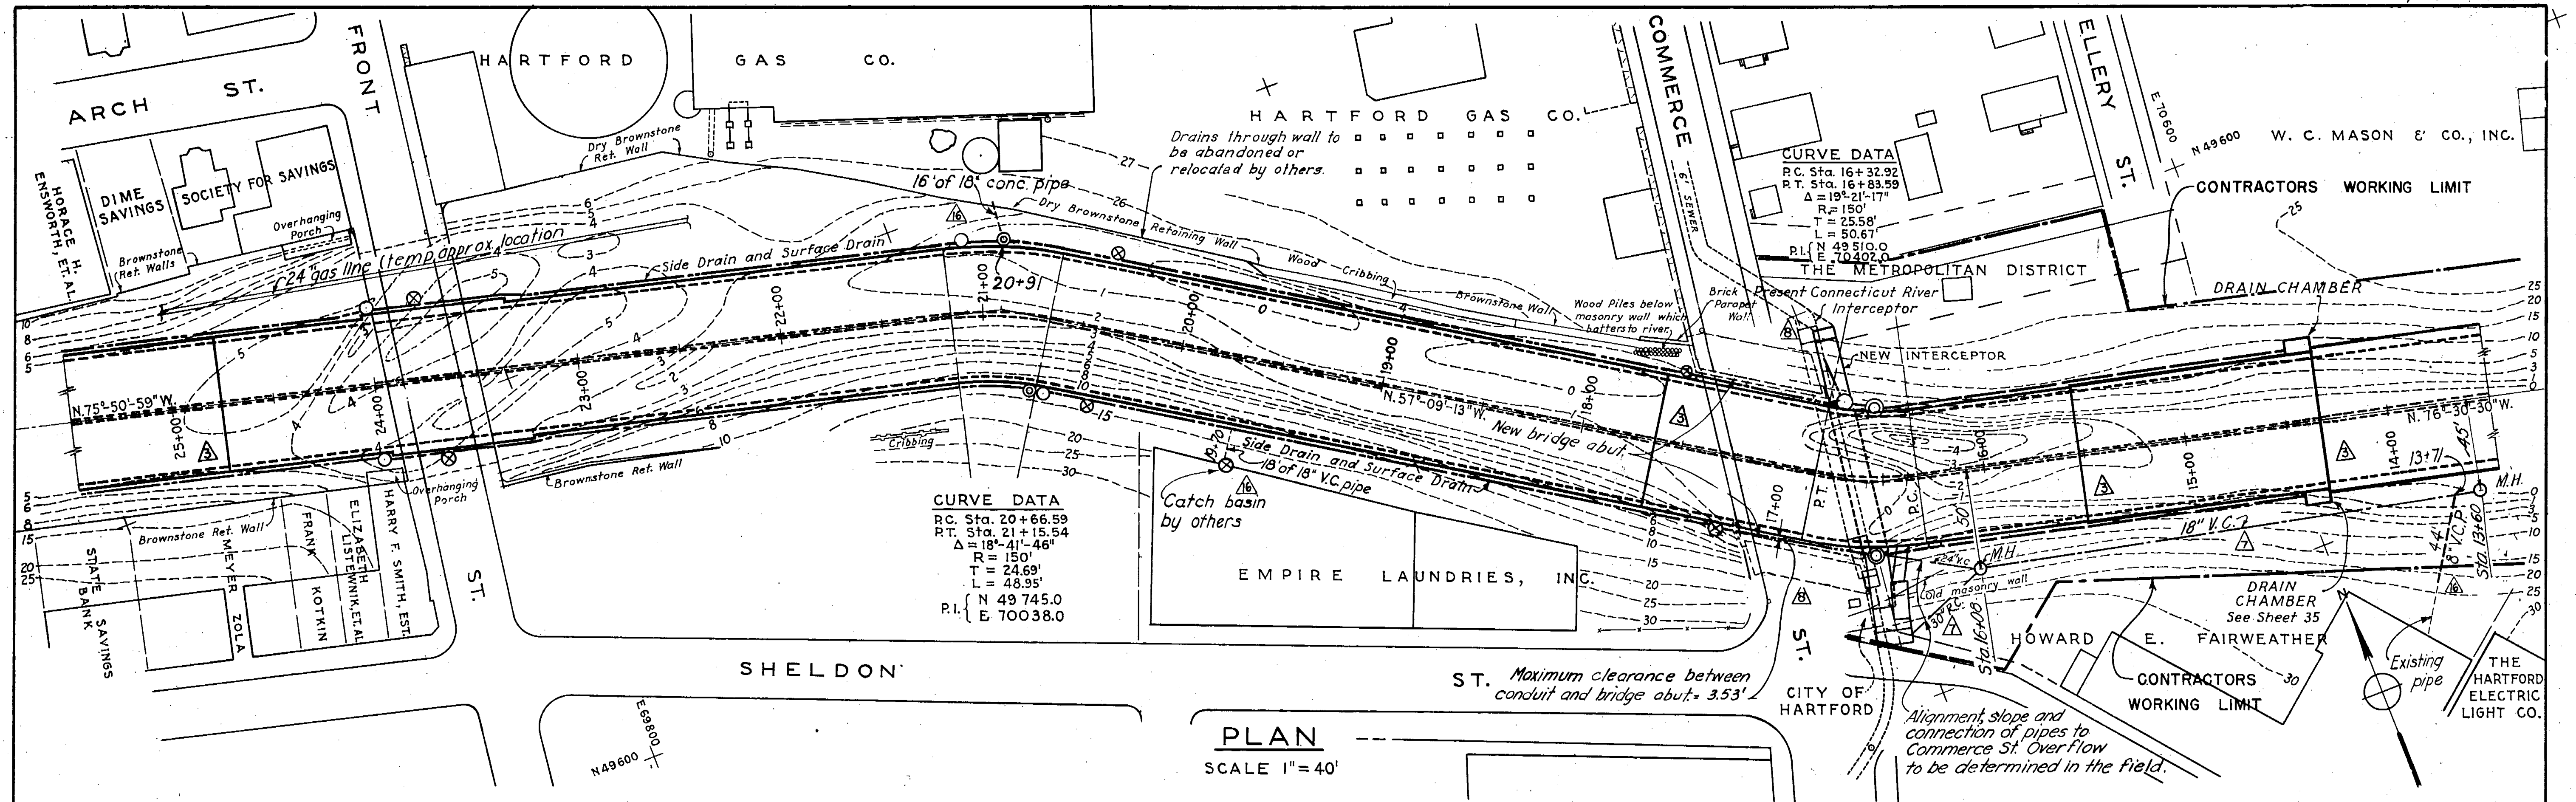


**NOTES**

For general notes applying to details shown on this sheet, see Sheet No. 10. See legend on Sheet No. 10. For Contractor's working limit above Commerce St. see Sheet No. 9.

METCALF & EDDY
ENGINEERS
BOSTON, MASS.

PROFILE

HOR. 1" = 40'
VERT. 1" = 10'

KEY	DATE	REVISION (Indicated by Δ)	REV. BY	CK. BY	AP. BY
Δ	12-31-43	As Built Revisions			
Δ	11-17-43	Sewer connections added.	B.S. C.M.A.		
Δ	4-22-42	Drain pipes at Commerce St. revised	E.P.E.		
Δ	10-28-41	18" V.C. pipe added	P.C.H.		
Δ	2-17-41	Transitions changed	I.C.D.		
Δ	11-22-40	Opening relocated at Sta. 16+41.5	P.C.H.		

CONNECTICUT RIVER FLOOD CONTROL PARK RIVER CONDUIT HARTFORD, CONN.		
PLAN AND PROFILE NO. 2		
CONNECTICUT RIVER	CONNECTICUT	
IN 48 SHEETS	SCALE 1 IN. = 40 FT.	SHEET NO. 11
U.S. ENGINEER OFFICE PROVIDENCE, R.I. MAY 1940		
REVIEWED: M. H. HANES ENGINEER P.C. DESIGN SECTION	APPROVAL RECOMMENDED: J. B. STURGEON PRINCIPAL ENGINEER CHIEF P.C. ENGINEERING DIV.	APPROVED: M. H. HANES DISTRICT ENGINEER LT. COL. CORPS OF ENGINEERS
SUBMITTED M. H. HANES (PARTNER) METCALF & EDDY BOSTON, MASS.		FILE NO. CT-4-2609