

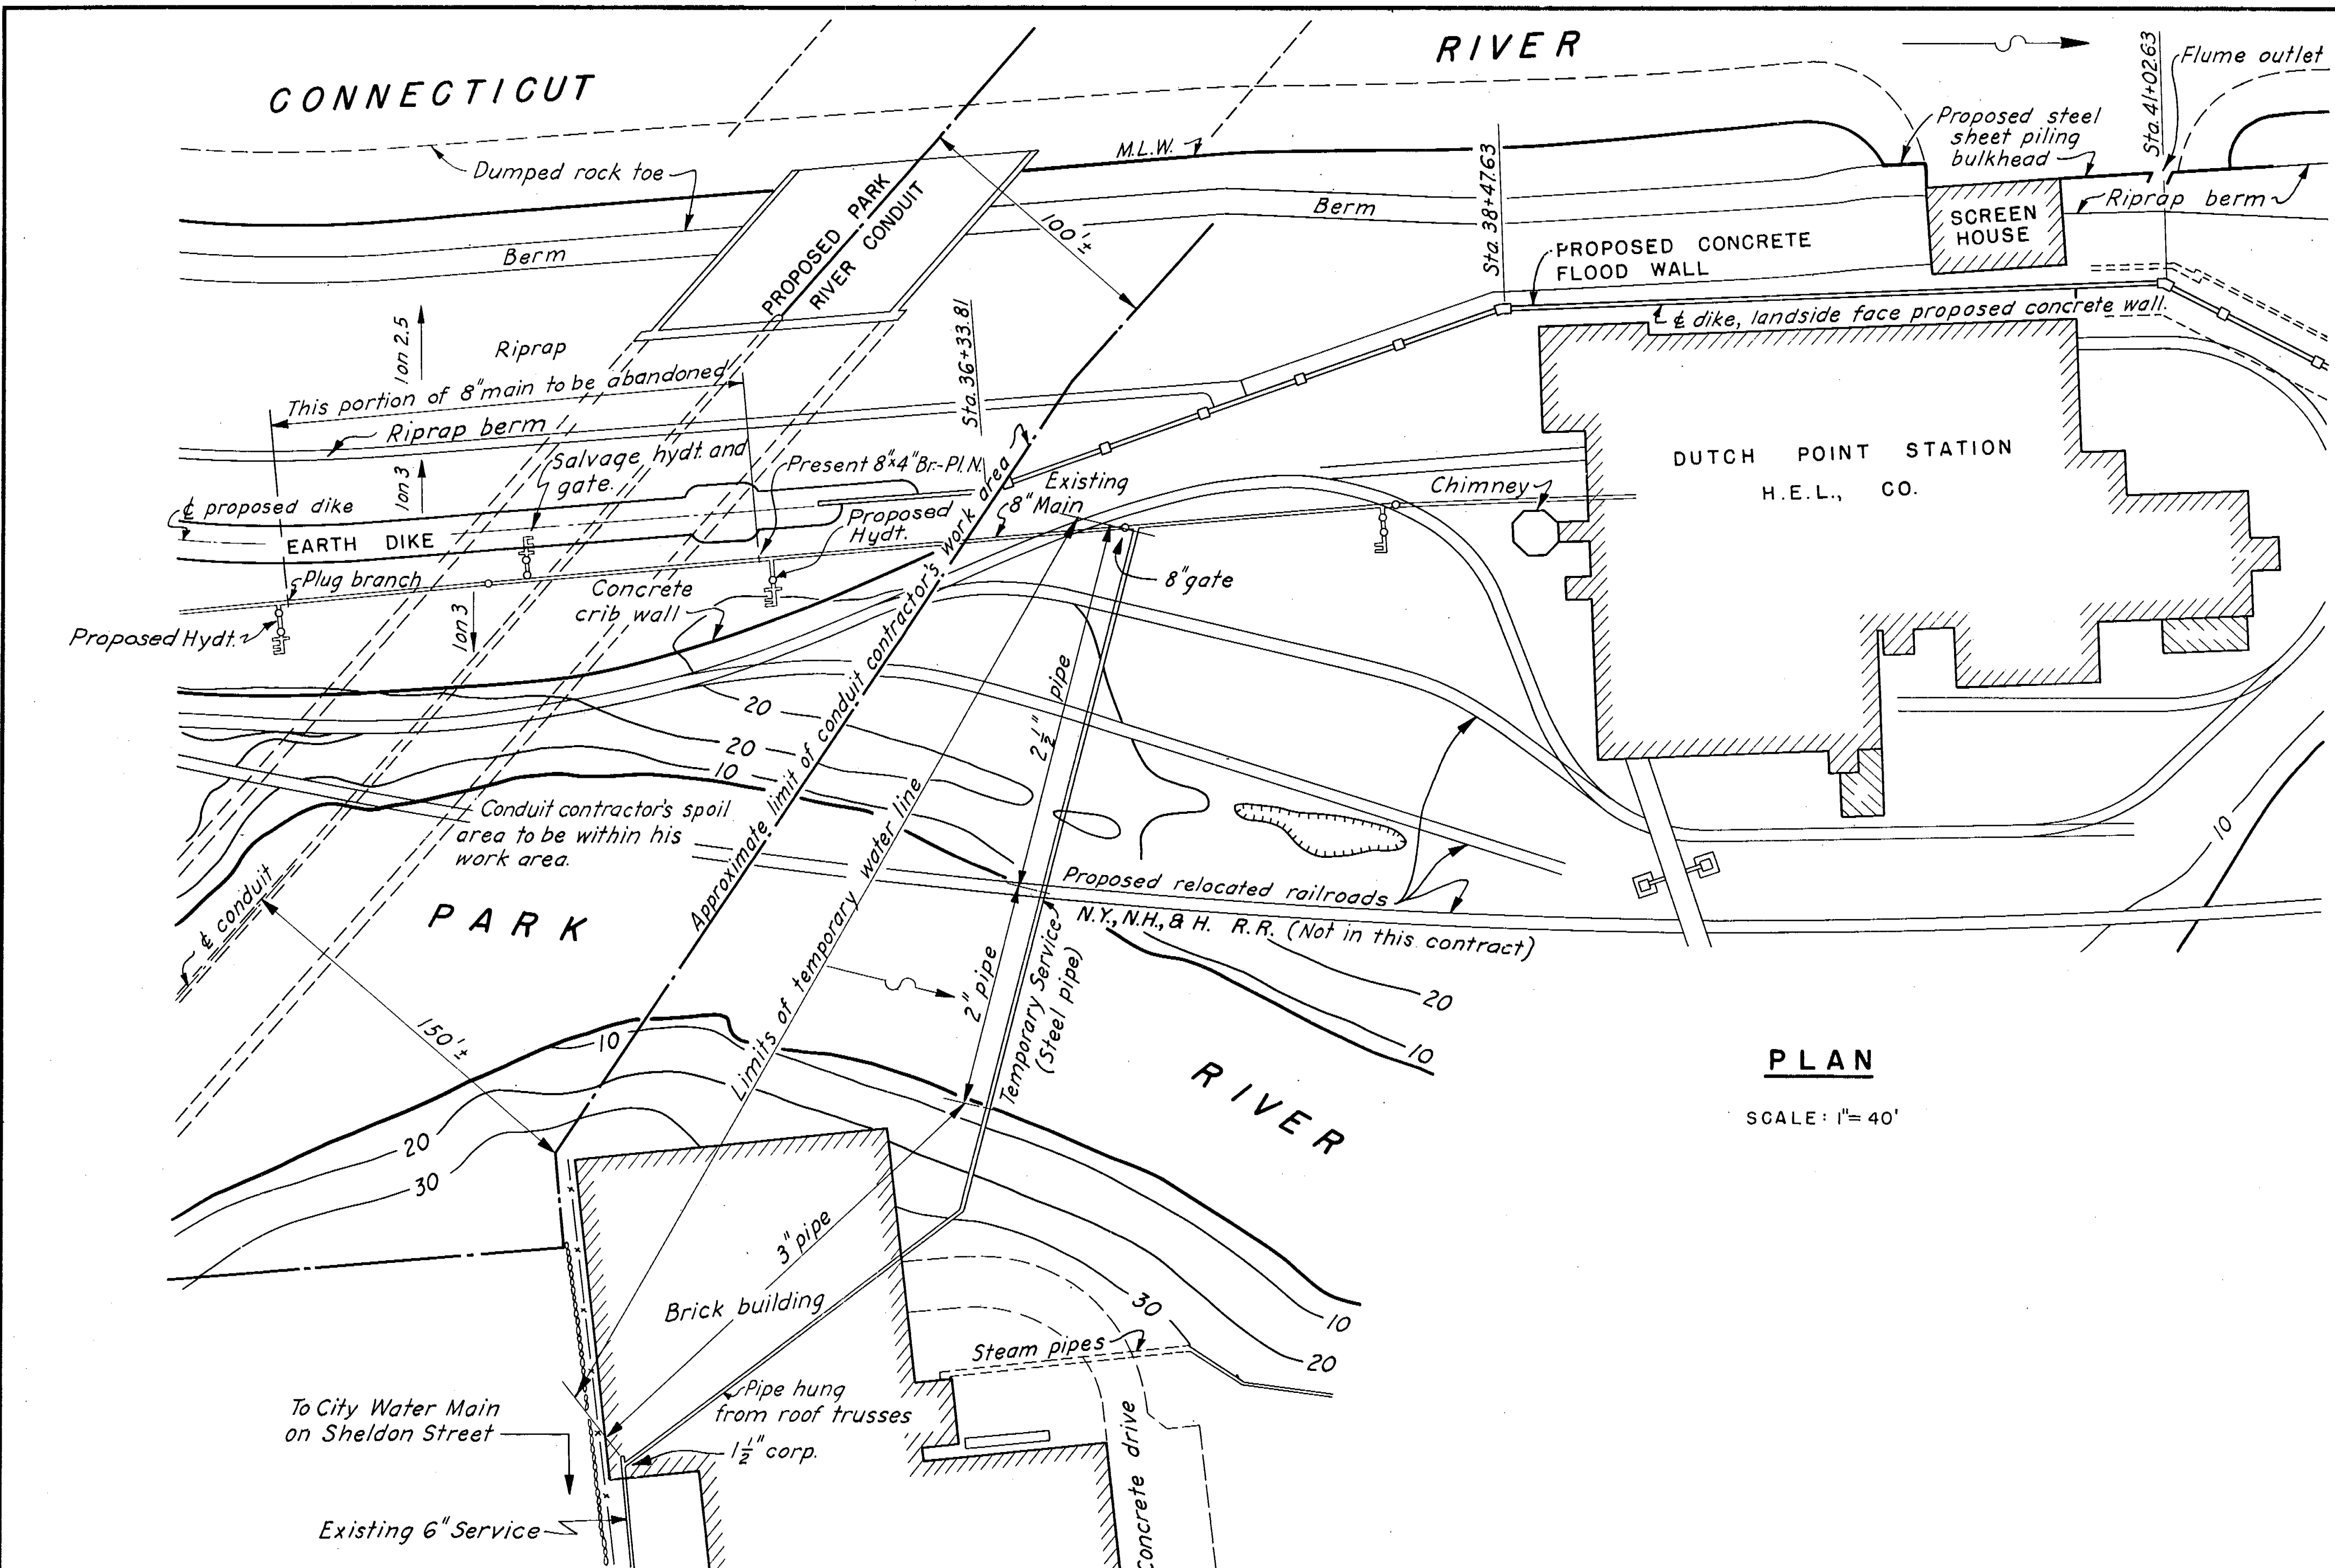


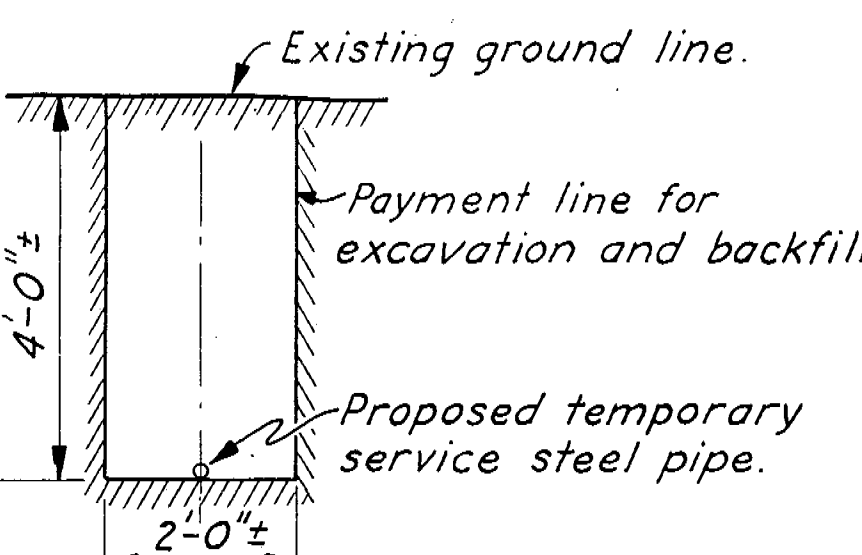

PLAN

SCALE: 1" = 40'

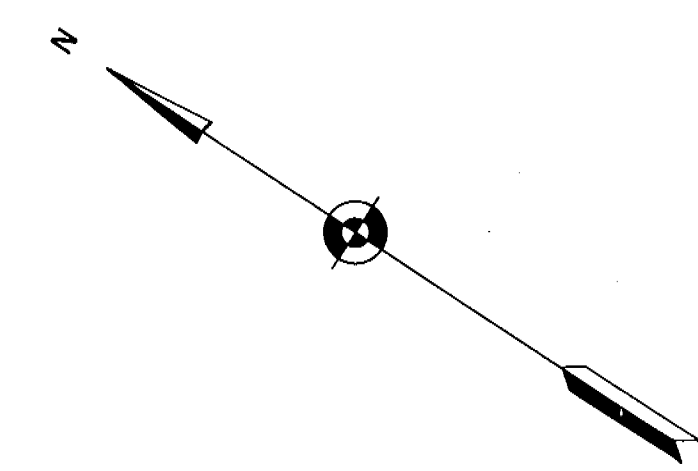


TYPICAL TRENCH SECTION

SCALE: 1/2" = 1'-0"
0 1' 2' 3' 4' 5'

NOTES

- Elevations refer to Mean Sea Level Datum.
- Payment for furnishing and installing temporary water line will be made under Item No. 32.
- Existing 8" main to be cut and plugged by others. Hydrants to be installed by others.

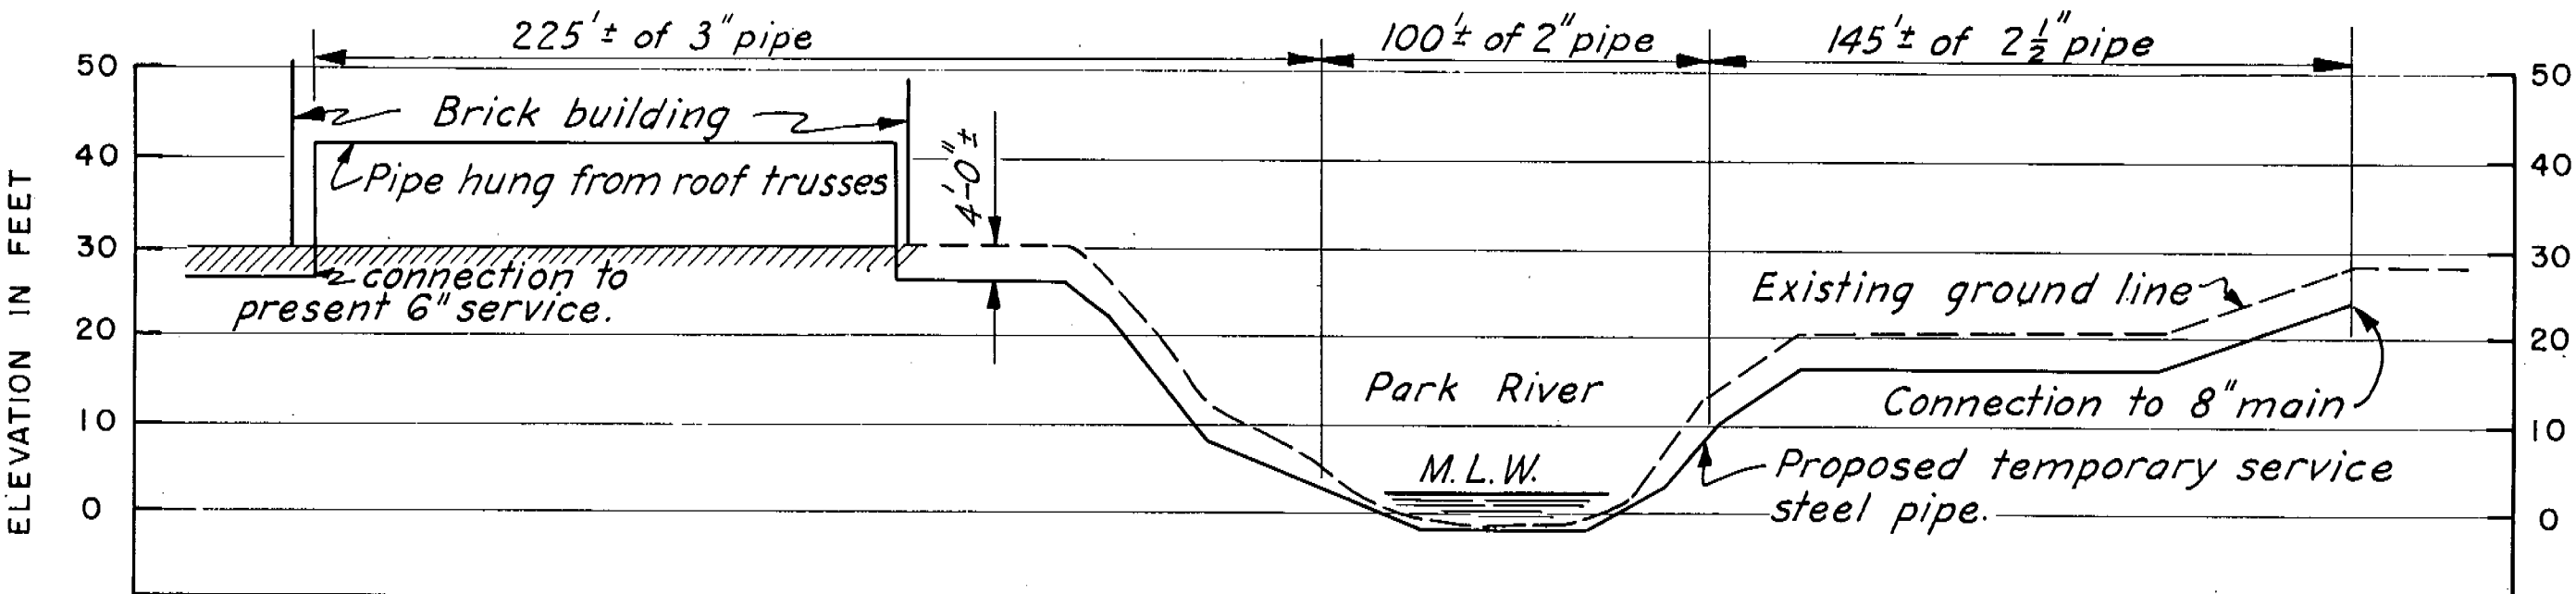

PROFILE ON C OF PIPE

SCALE: VERT. 1" = 20'
HOR. 1" = 40'

KEY	DATE	REVISION (Indicated by Δ)	REV. BY	CK. BY	AP. BY
	12-31-45	As built			

CONNECTICUT RIVER FLOOD CONTROL			
PARK RIVER CONDUIT			
HARTFORD, CONN.			
TEMPORARY WATER LINE TO THE DUTCH POINT LIGHTING PLANT			
CONNECTICUT RIVER		CONNECTICUT	
IN 48 SHEETS		SCALE: 1 IN. = 40 FT.	
0 40 80		SHEET NO. 40	
U.S. ENGINEER OFFICE, PROVIDENCE, R.I., OCT., 1940			
SUBMITTED:		APPROVAL, RECOMMENDED:	
HEAD, DESIGN SECTION		PRINCIPAL ENGINEER	
DESIGNED:		DRAWN:	
P. C. HANCOCK		D.W.C.	
ASST. ENGINEER		G.M.A.	
CHECKED:		FILE NO. CT-4-2706	