
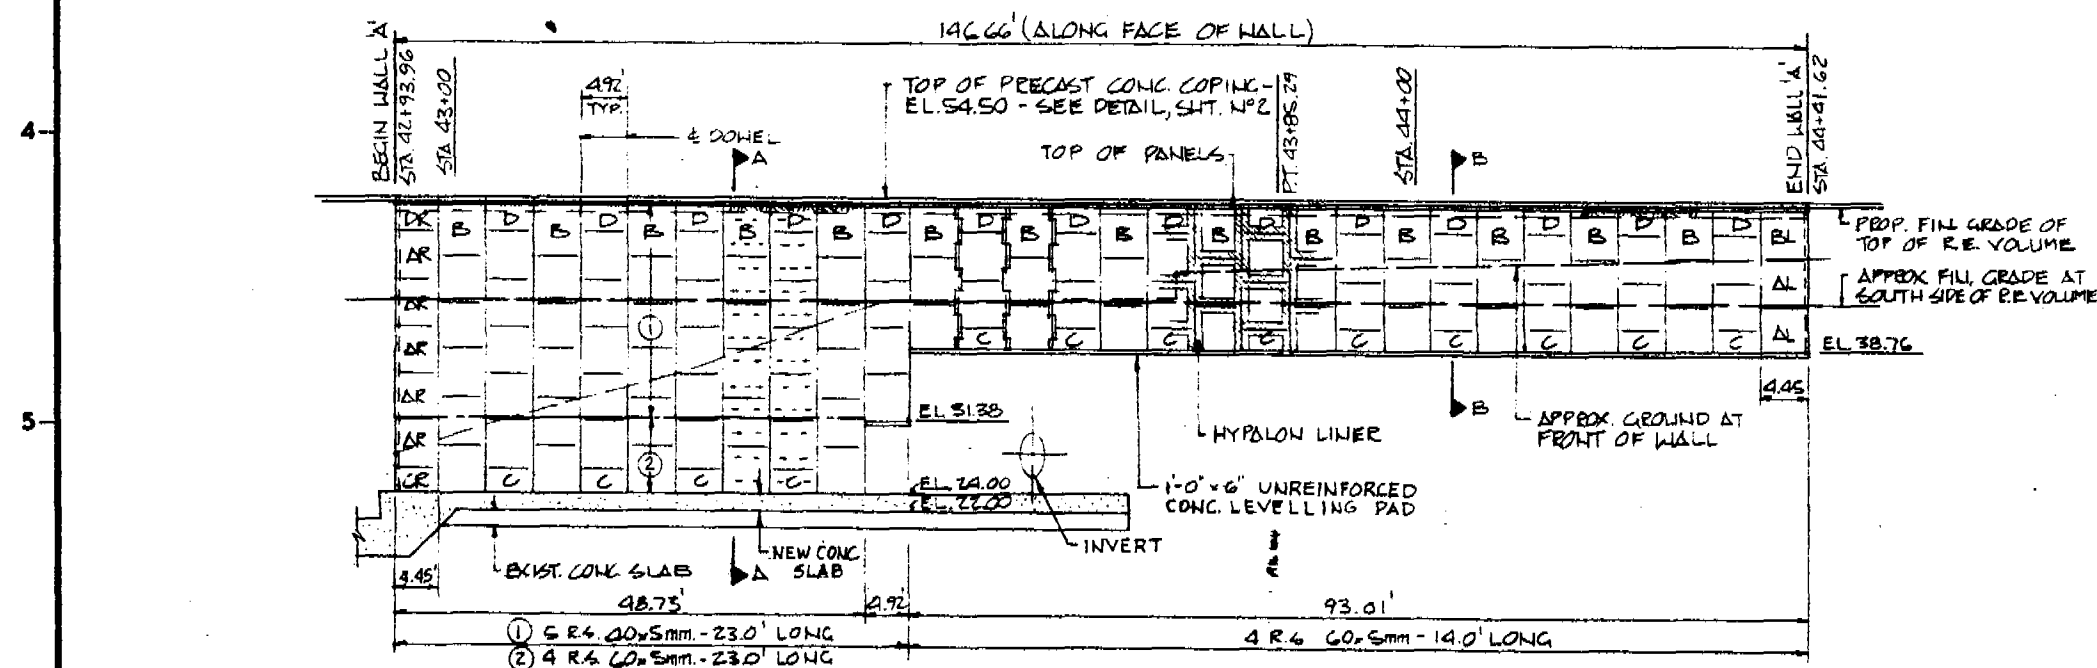


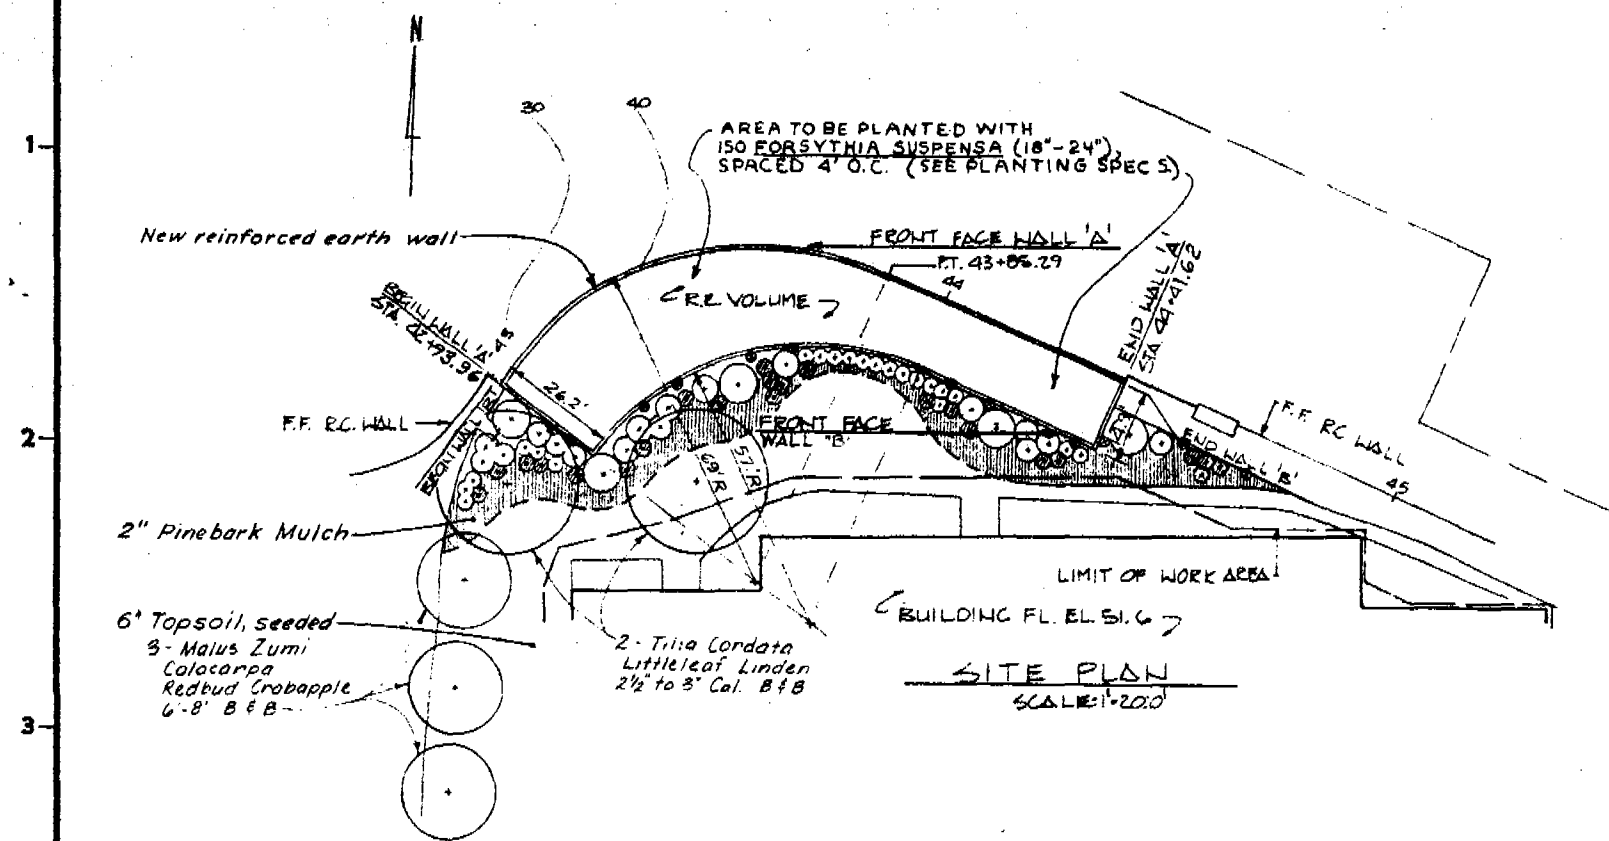

REINFORCING STRIP SCHEDULE	TYPE	LENGTH	QUANTITY
40x5mm	14.0'	23.0'	242
60x5mm	6.24'	6.0'	60

TOTAL PANEL SURFACE AREA: 5,243.6 SQ. FT.

PANEL SCHEDULE	TYPE	LENGTH	QUANTITY
2	27.23'	1	1
4	106.23'	1	1
5	35.5'	1	1
6	35.5'	1	1
7	35.5'	1	1
100	35.5'	1	1

PLANTING LEGEND

- 3 MALUS ZUMI CALOCARPA REDBUD CRABAPPLE 6'-8' B & B
- 2 TILIA CORDATA LITTLELEAF LINDEN 2 1/2"-3" Col. B & B
- 23 AZALEA KAEMPFERI "FEDORA" 9'-0" C FEDORA AZALEA 15"-18" Cont.
- 21 BERBERIS THUNBERGI - 9' O.C. JAPANESE BARBERRY 2'-3' B & B

- 5 RHODODENDRUM CATAWBIENSE ALBUM WHITE CATAWBA RHODODENDRUM 2 1/2"-3' B & B
- 17 KALMIA LATIFOLIA - 5' O.C. MOUNTAIN LAUREL 18"-24" B & B
- 250 HEDERA HELIX BALTICA - 2' O.C. BAL TIC IVY - 2 YR. CONTAINER GROWN
- 12 PARTHENOCISSUS TRICUSPIDATA VEITCHI BOSTON IVY 6" POT

As Built Drawing

CONTRACT NO. DACW 33-76-C-0098

REVISION	DATE	DESCRIPTION	BY
4-83	Final field corrections		

DEPARTMENT OF THE ARMY
NEW ENGLAND DIVISION
CORPS OF ENGINEERS
WALTHAM, MASS.WATER RESOURCES DEVELOPMENT PROJECT
PARK RIVER LOCAL PROTECTION
BOX CONDUIT AT SECTION 9
EAST FLOOD WALL DETAILS NO. 1HARTFORD CONNECTICUT
APPROVED: *James B. Fagan* DATE: APRIL 1979
CHIEF, ENGINEERING DIVISIONSCALE AS SHOWN SPEC. NO. DACW 33-76-B-0040
DRAWING NUMBER
PAR-1

SHEET 79A

DATE: 3-22-79

R.E. 574