



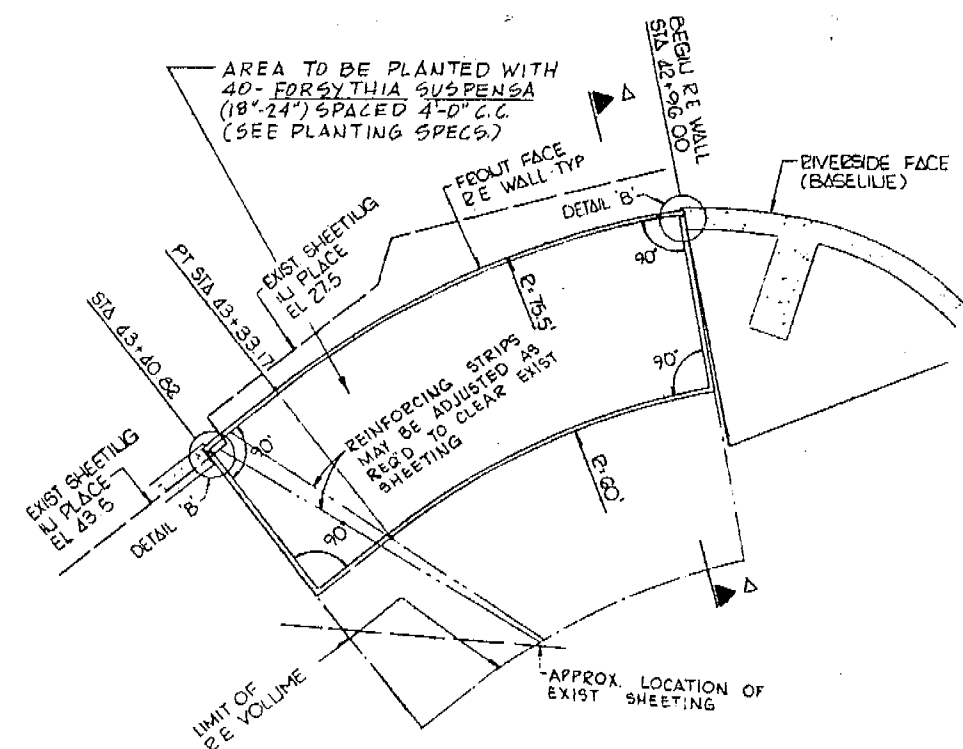

PLAN
SCALE: 1/8" = 1'-0"


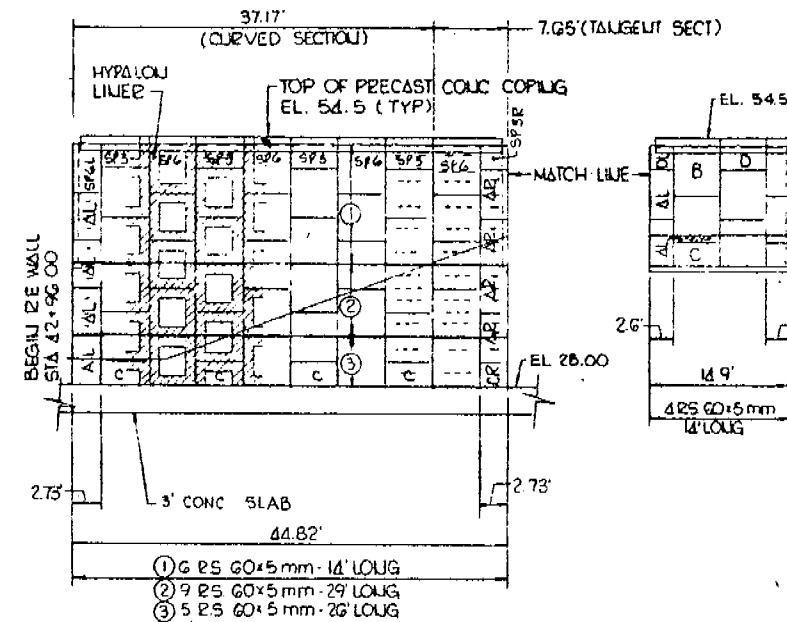


ELEVATION - FRONT FACE
SCALE: 1" = 10'

PANEL SCHEDULE																							
		STANDARD PANEL						90° BEND PANEL				27'3" CUT PANEL				26' CUT PANEL				26'3" NARROW PANEL			
TYPE	No. TS	A	B	C	D	SP3	SP6	ΔB	BB	CB	ΔL	SPΔL	ΔR	CE	SP3R	ΔL	DL	ΔR	DR	ΔU	BU	C-U	
P3	2	—	—	B	G	—	—	—	—	2	—	—	—	1	1	2	1	2	1	1	1	1	
	3	—	—	—	—	—	—	—	—	—	4	—	—	4	—	—	—	—	—	—	—	—	
	4	16	4	—	—	4	—	2	2	—	—	1	—	—	—	—	—	—	—	—	—	—	
	5	4	—	—	—	—	—	—	—	—	—	—	—	—	—	—	—	—	—	—	—	—	
	6	20	—	—	—	—	—	—	—	—	—	—	—	—	—	—	—	—	—	—	—	—	
	7	—	—	—	—	—	—	—	—	—	—	—	—	—	—	—	—	—	—	—	—	—	
	8	—	—	—	—	—	4	—	—	—	—	—	—	—	—	—	—	—	—	—	—	—	
	9	8	—	—	—	—	—	—	—	—	—	—	—	—	—	—	—	—	—	—	—	—	
SQ. FT. PER PANEL		24.2	24.2	12.1	12.1	17.9	30.0	24.2	24.2	12.1	13.4	16.6	13.4	6.7	9.9	12.8	6.4	12.8	6.4	12.2	12.2	6.1	

		REINFORCING STRIP SCHEDULE		
TYPE	LENGTH	14'	26'	29'
		286	46	106


WALL SURFACE AREA = 1,975.3 SQ. FT.

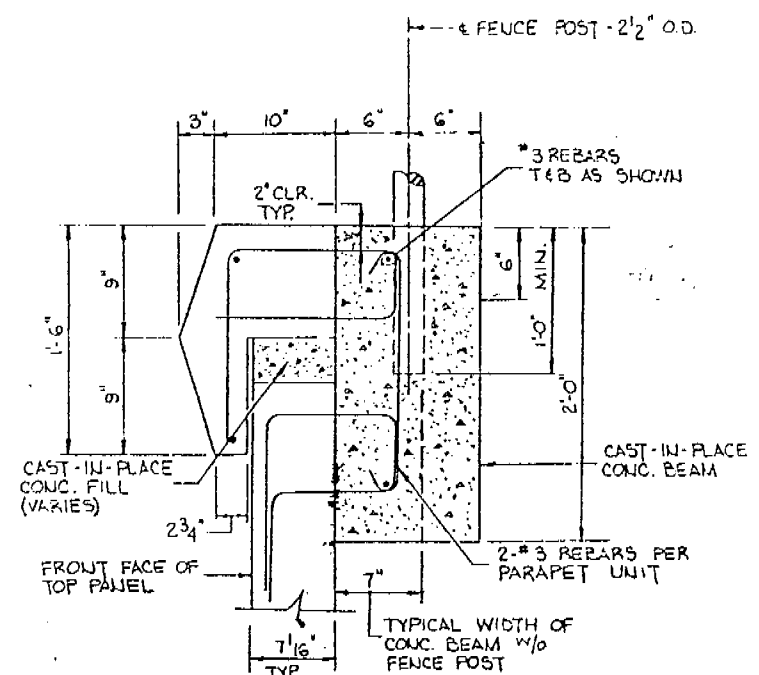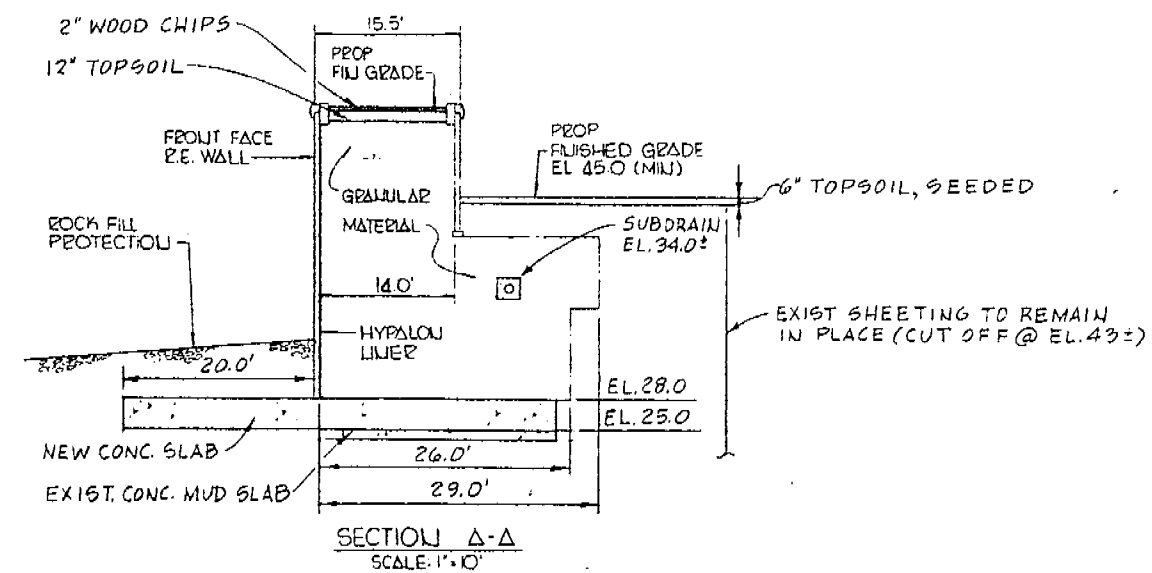

TYPICAL COPING DETAIL
W/FENCE POST BASE
SCALE: 1/2" = 1'-0"

As Built Drawing

Contract No. DACW 33-76-C-0088

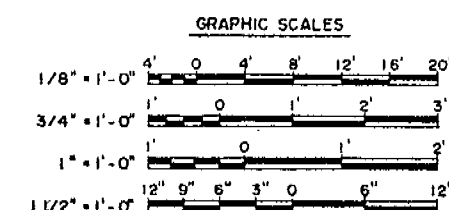

This drawing contains information proprietary to The Reinforced Earth Company, and is being furnished for the use of the U.S. Army, New England Division, Corps of Engineers, only in connection with this project, and the information contained herein is not to be transmitted to any other organization unless specifically authorized in writing by The Reinforced Earth Company. The Reinforced Earth Company is exclusive licensee in the United States under patents issued to Havel Vidal, and the furnishing of this drawing does not constitute an express or implied license under the Vidal patents.

DES. BY L. B. R.	DR. BY L. J. W.	CK. BY L. J. W.	DEPARTMENT OF THE ARMY NEW ENGLAND DIVISION CORPS OF ENGINEERS WALTHAM, MASS. WATER RESOURCES DEVELOPMENT PROJECT PARK RIVER LOCAL PROTECTION BOX CONDUIT AT SECTION 9 WEST FLOOD WALL DETAILS NO. 1 HARTFORD CONNECTICUT APPROVED: <i>[Signature]</i> DATE: JUNE 1979 CHIEF, PROJECT BRANCH
SUBMITTED: <i>[Signature]</i>	CHIEF, CIVIL ENG. SECTION	CHIEF, DESIGN BRANCH	
APPROVED: <i>[Signature]</i>	CHIEF, DESIGN BRANCH	PROJECT MANAGER	
REVIEWED: <i>[Signature]</i>	CHIEF, DESIGN BRANCH	CHIEF, PROJECT BRANCH	
SCALE AS SHOWN SPEC. NO. DACW 33-76-B-0040 DRAWING NUMBER PAR - J			SHEET 79C