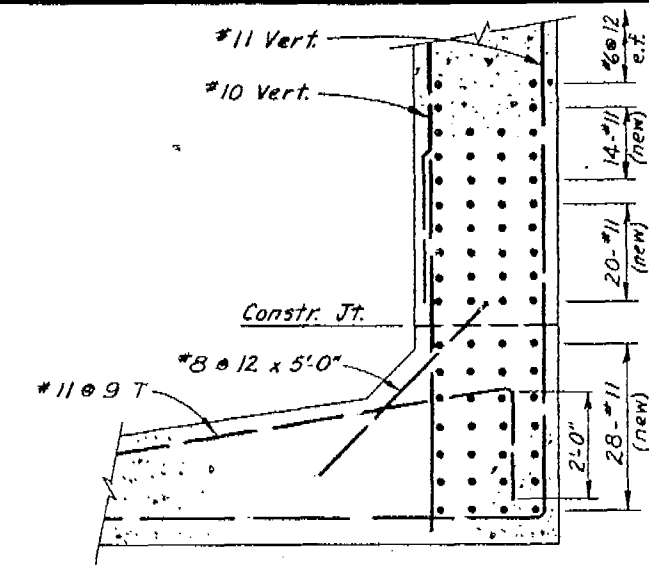
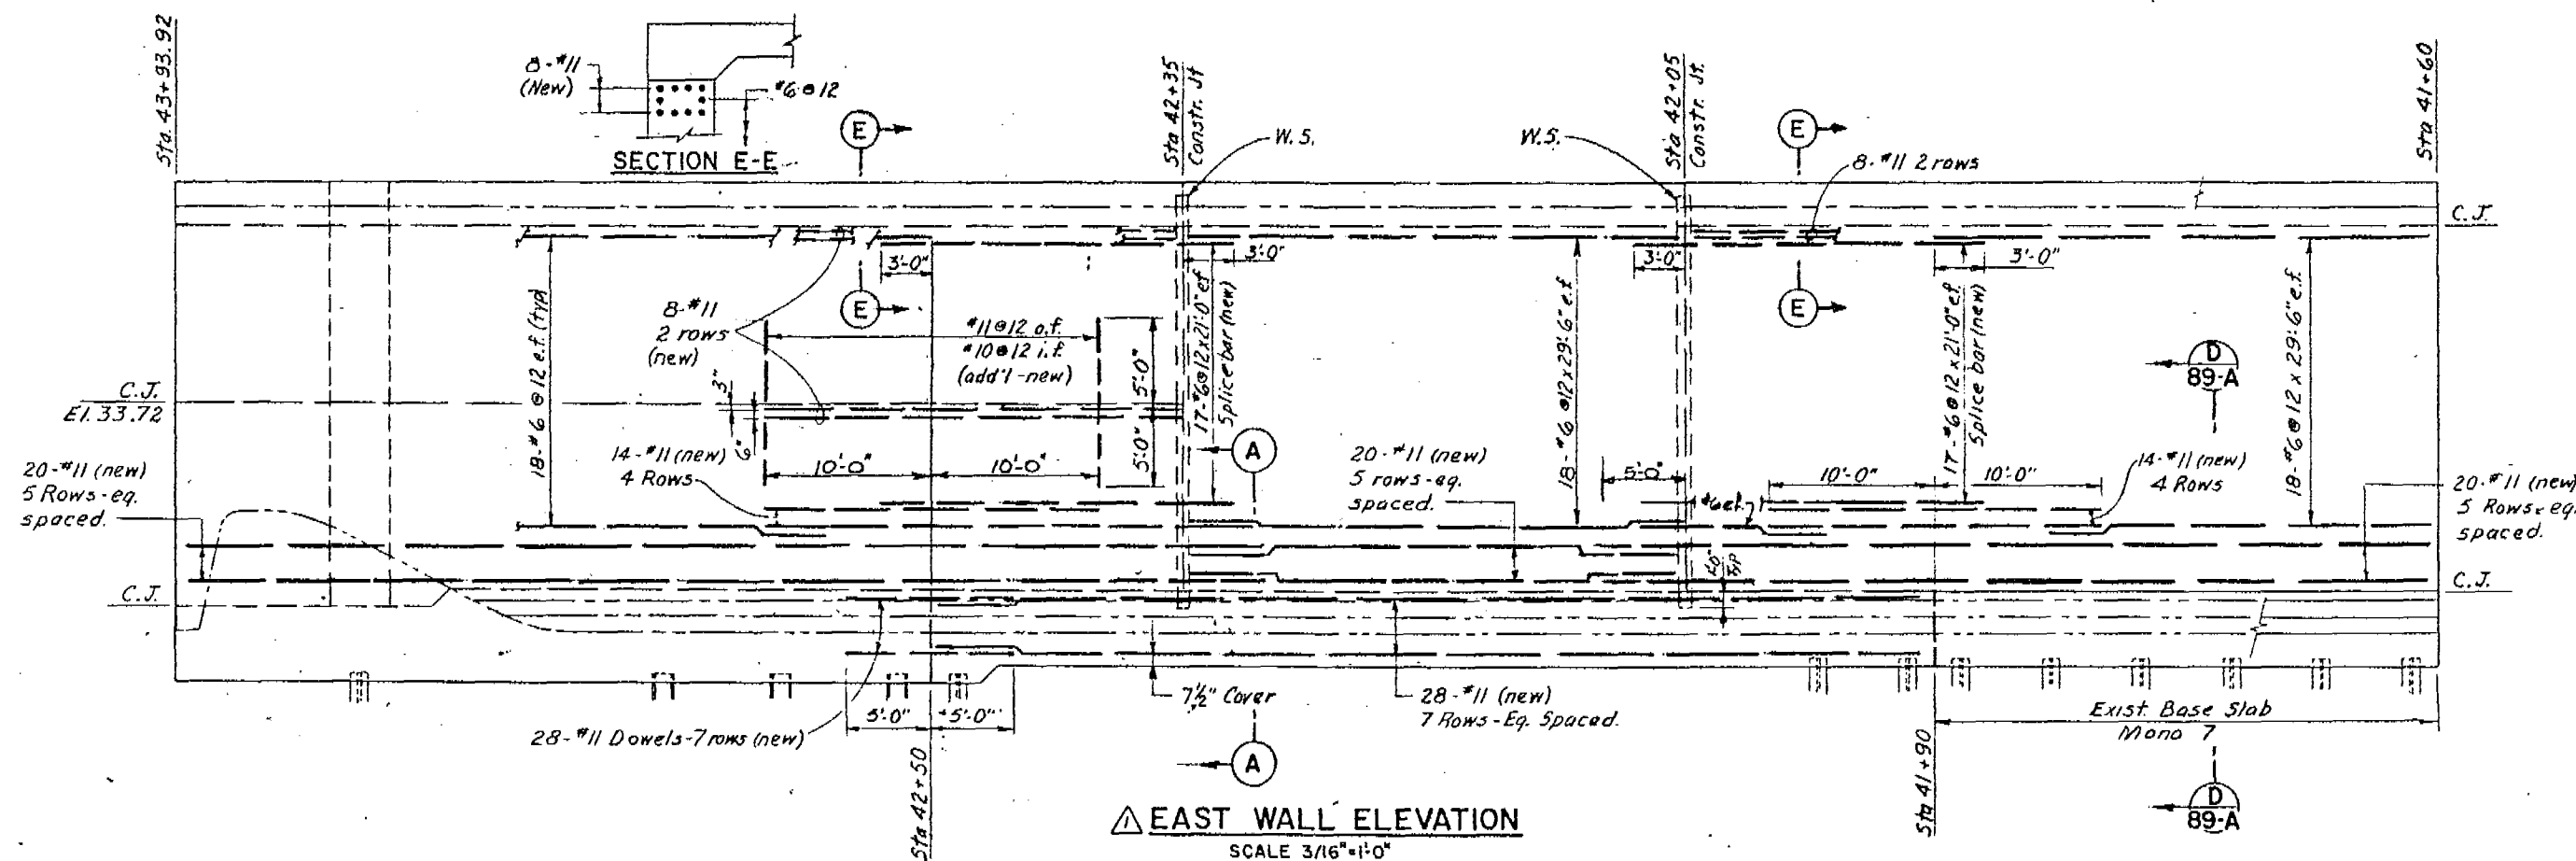
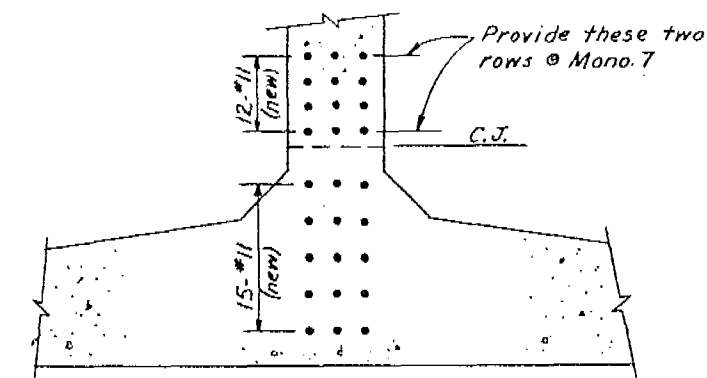
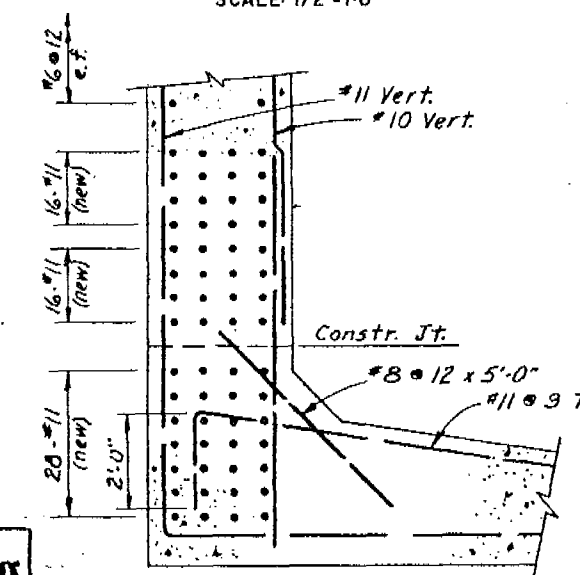
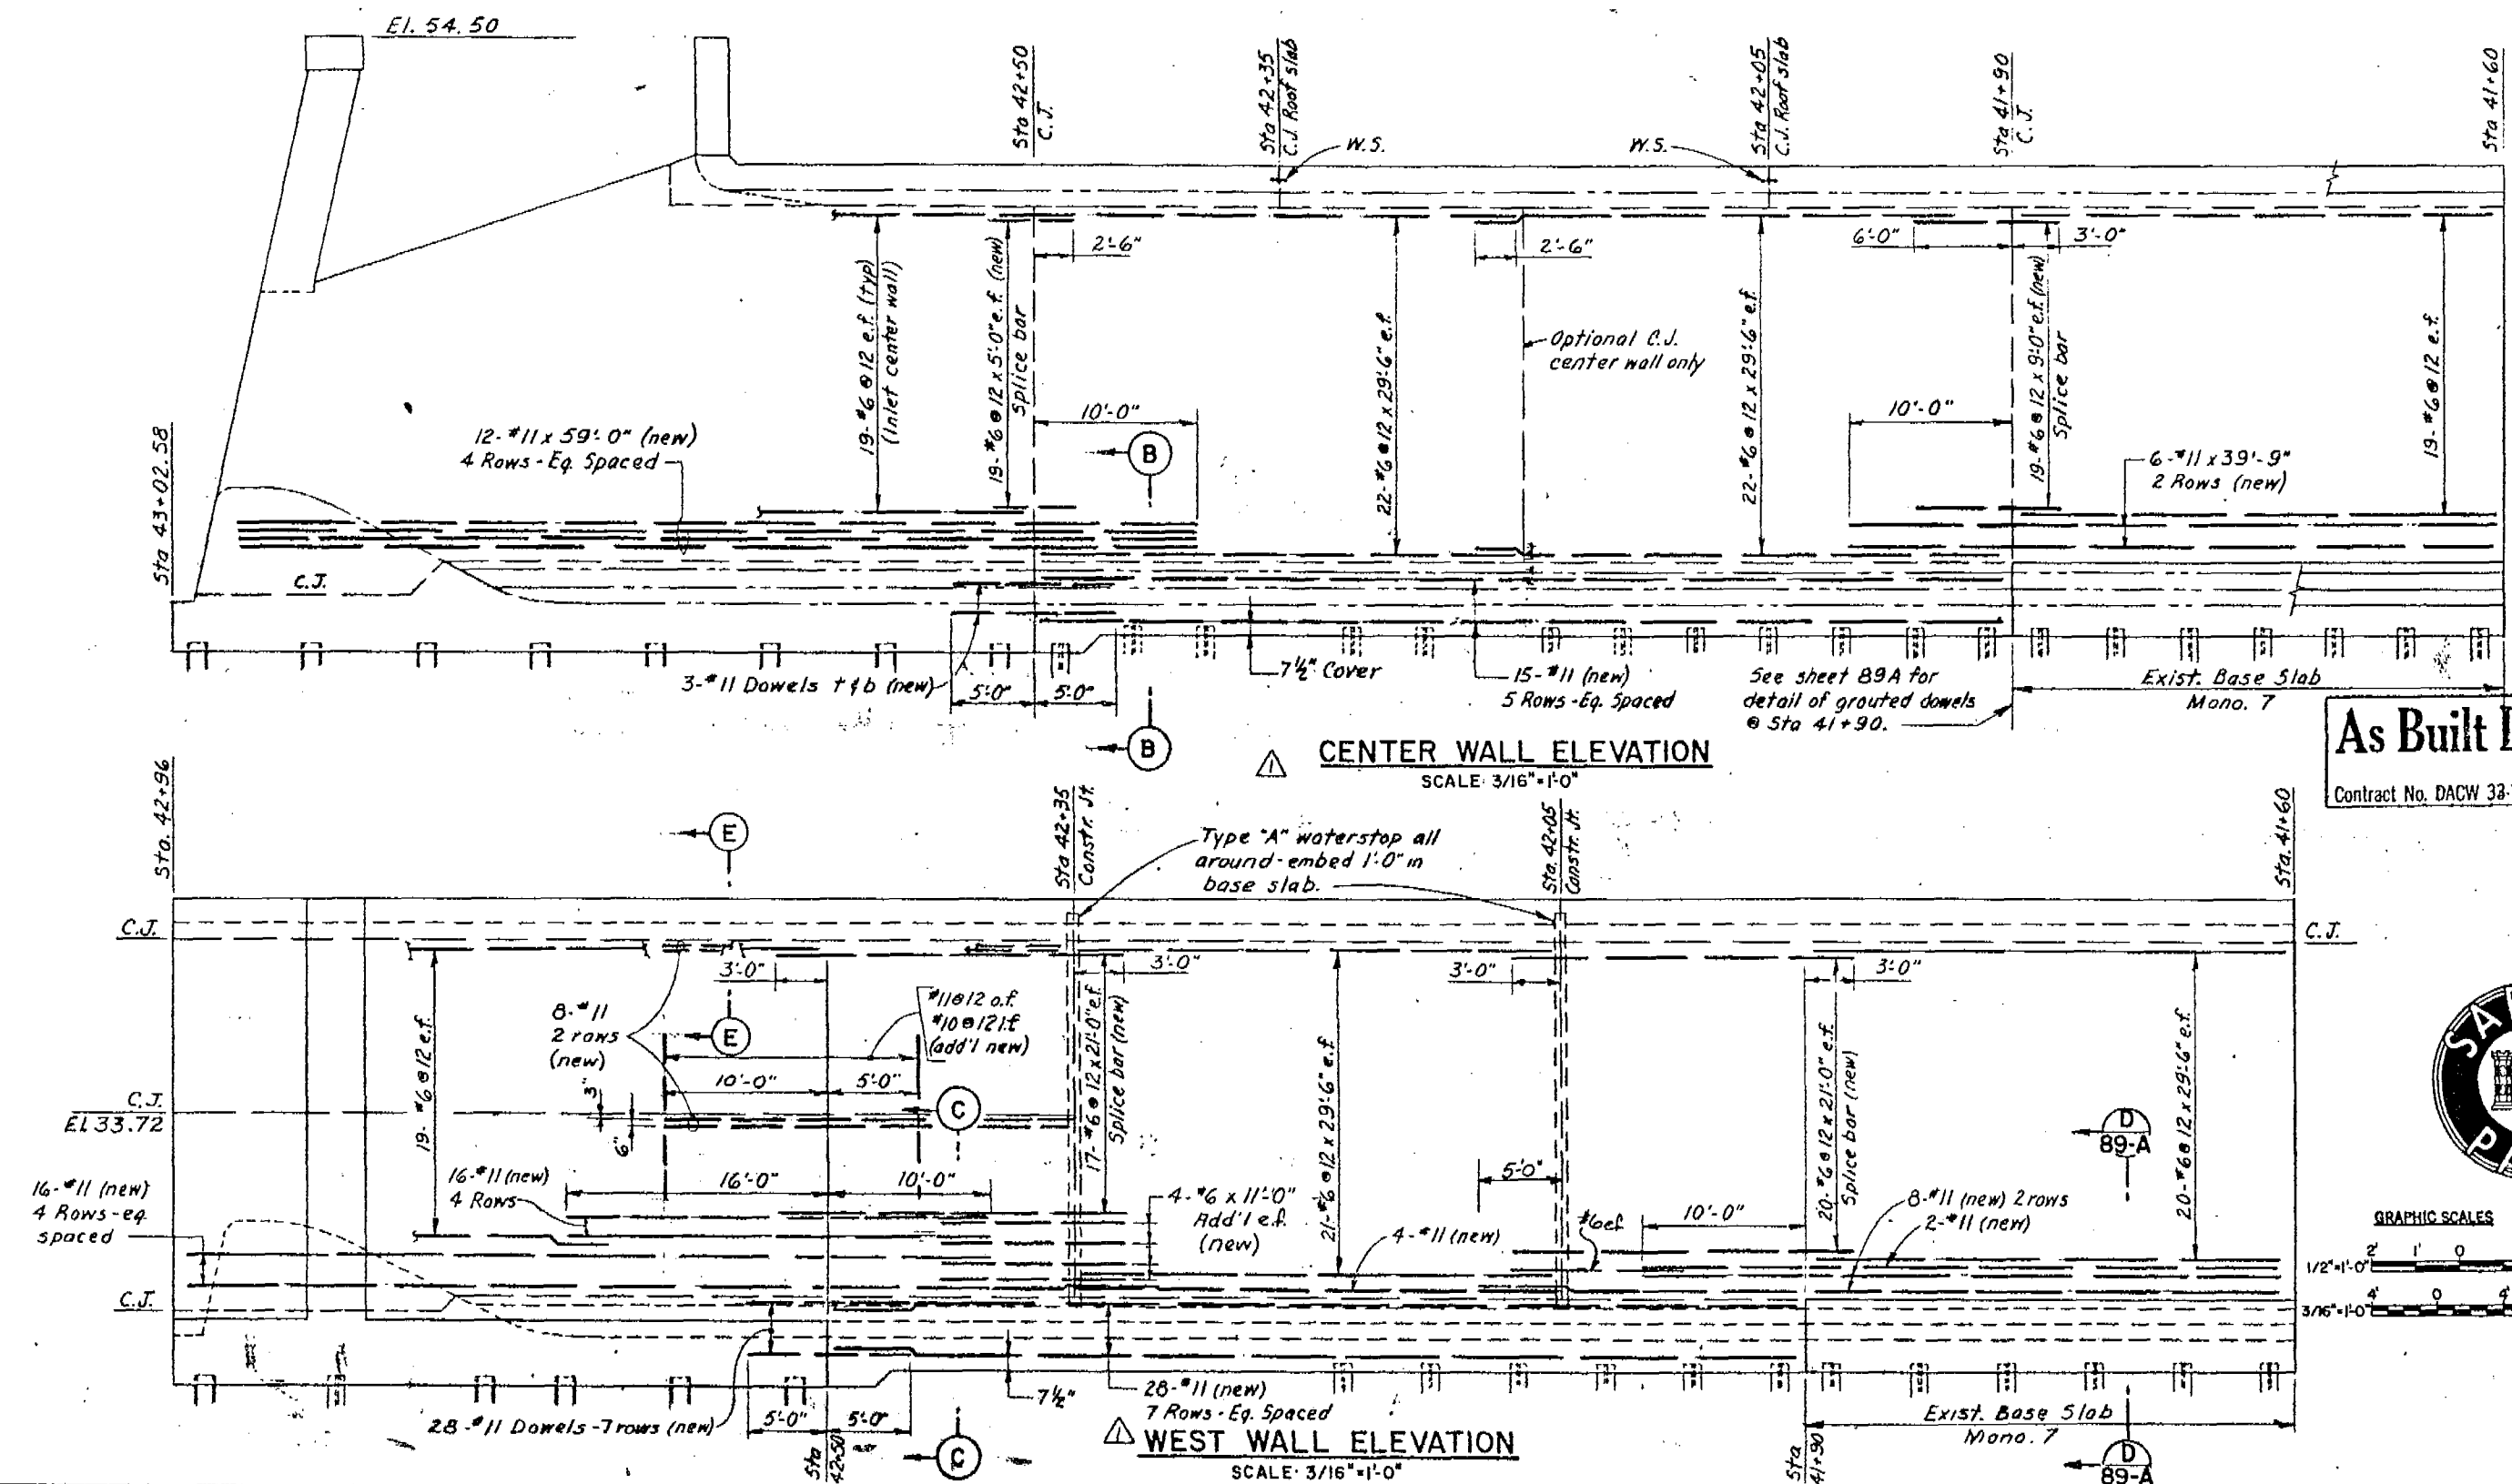


SECTION A-A
SCALE 1/2"=1'-0"SECTION B-B
SCALE 1/2"=1'-0"SECTION C-C
SCALE 1/2"=1'-0"

As Built Drawing

 
Contract No. DACW 33-76-C-0088

Notes:

1. Monolith 7 walls & Inlet walls shall be placed before monolithic placement of walls from Sta 42+05 to Sta 42+35
2. See sh. 89A for detail of grouted dowels @ Sta 41+90.
3. For construction procedure see sh. 89C.



GRAPHIC SCALES



REVISION	DATE	DESCRIPTION	BY
1	9 JAN 79	Revised due to construction procedure	205/102

DEPARTMENT OF THE ARMY
NEW ENGLAND DIVISION
CORPS OF ENGINEERS
WALTHAM, MASS.

WATER RESOURCES DEVELOPMENT PROJECT
PARK RIVER LOCAL PROTECTION

INLET STRUCTURE
PART PLAN AND REINFORCEMENT DETAILS
HARTFORD CONNECTICUT

APPROVED: *[Signature]* DATE: JAN 1979
CHIEF, ENGINEERING DIVISION

SCALE: AS SHOWN SPEC. NO. DACW 33-76-C-0040
DRAWING NUMBER
PAR - 1
SHEET 89B