


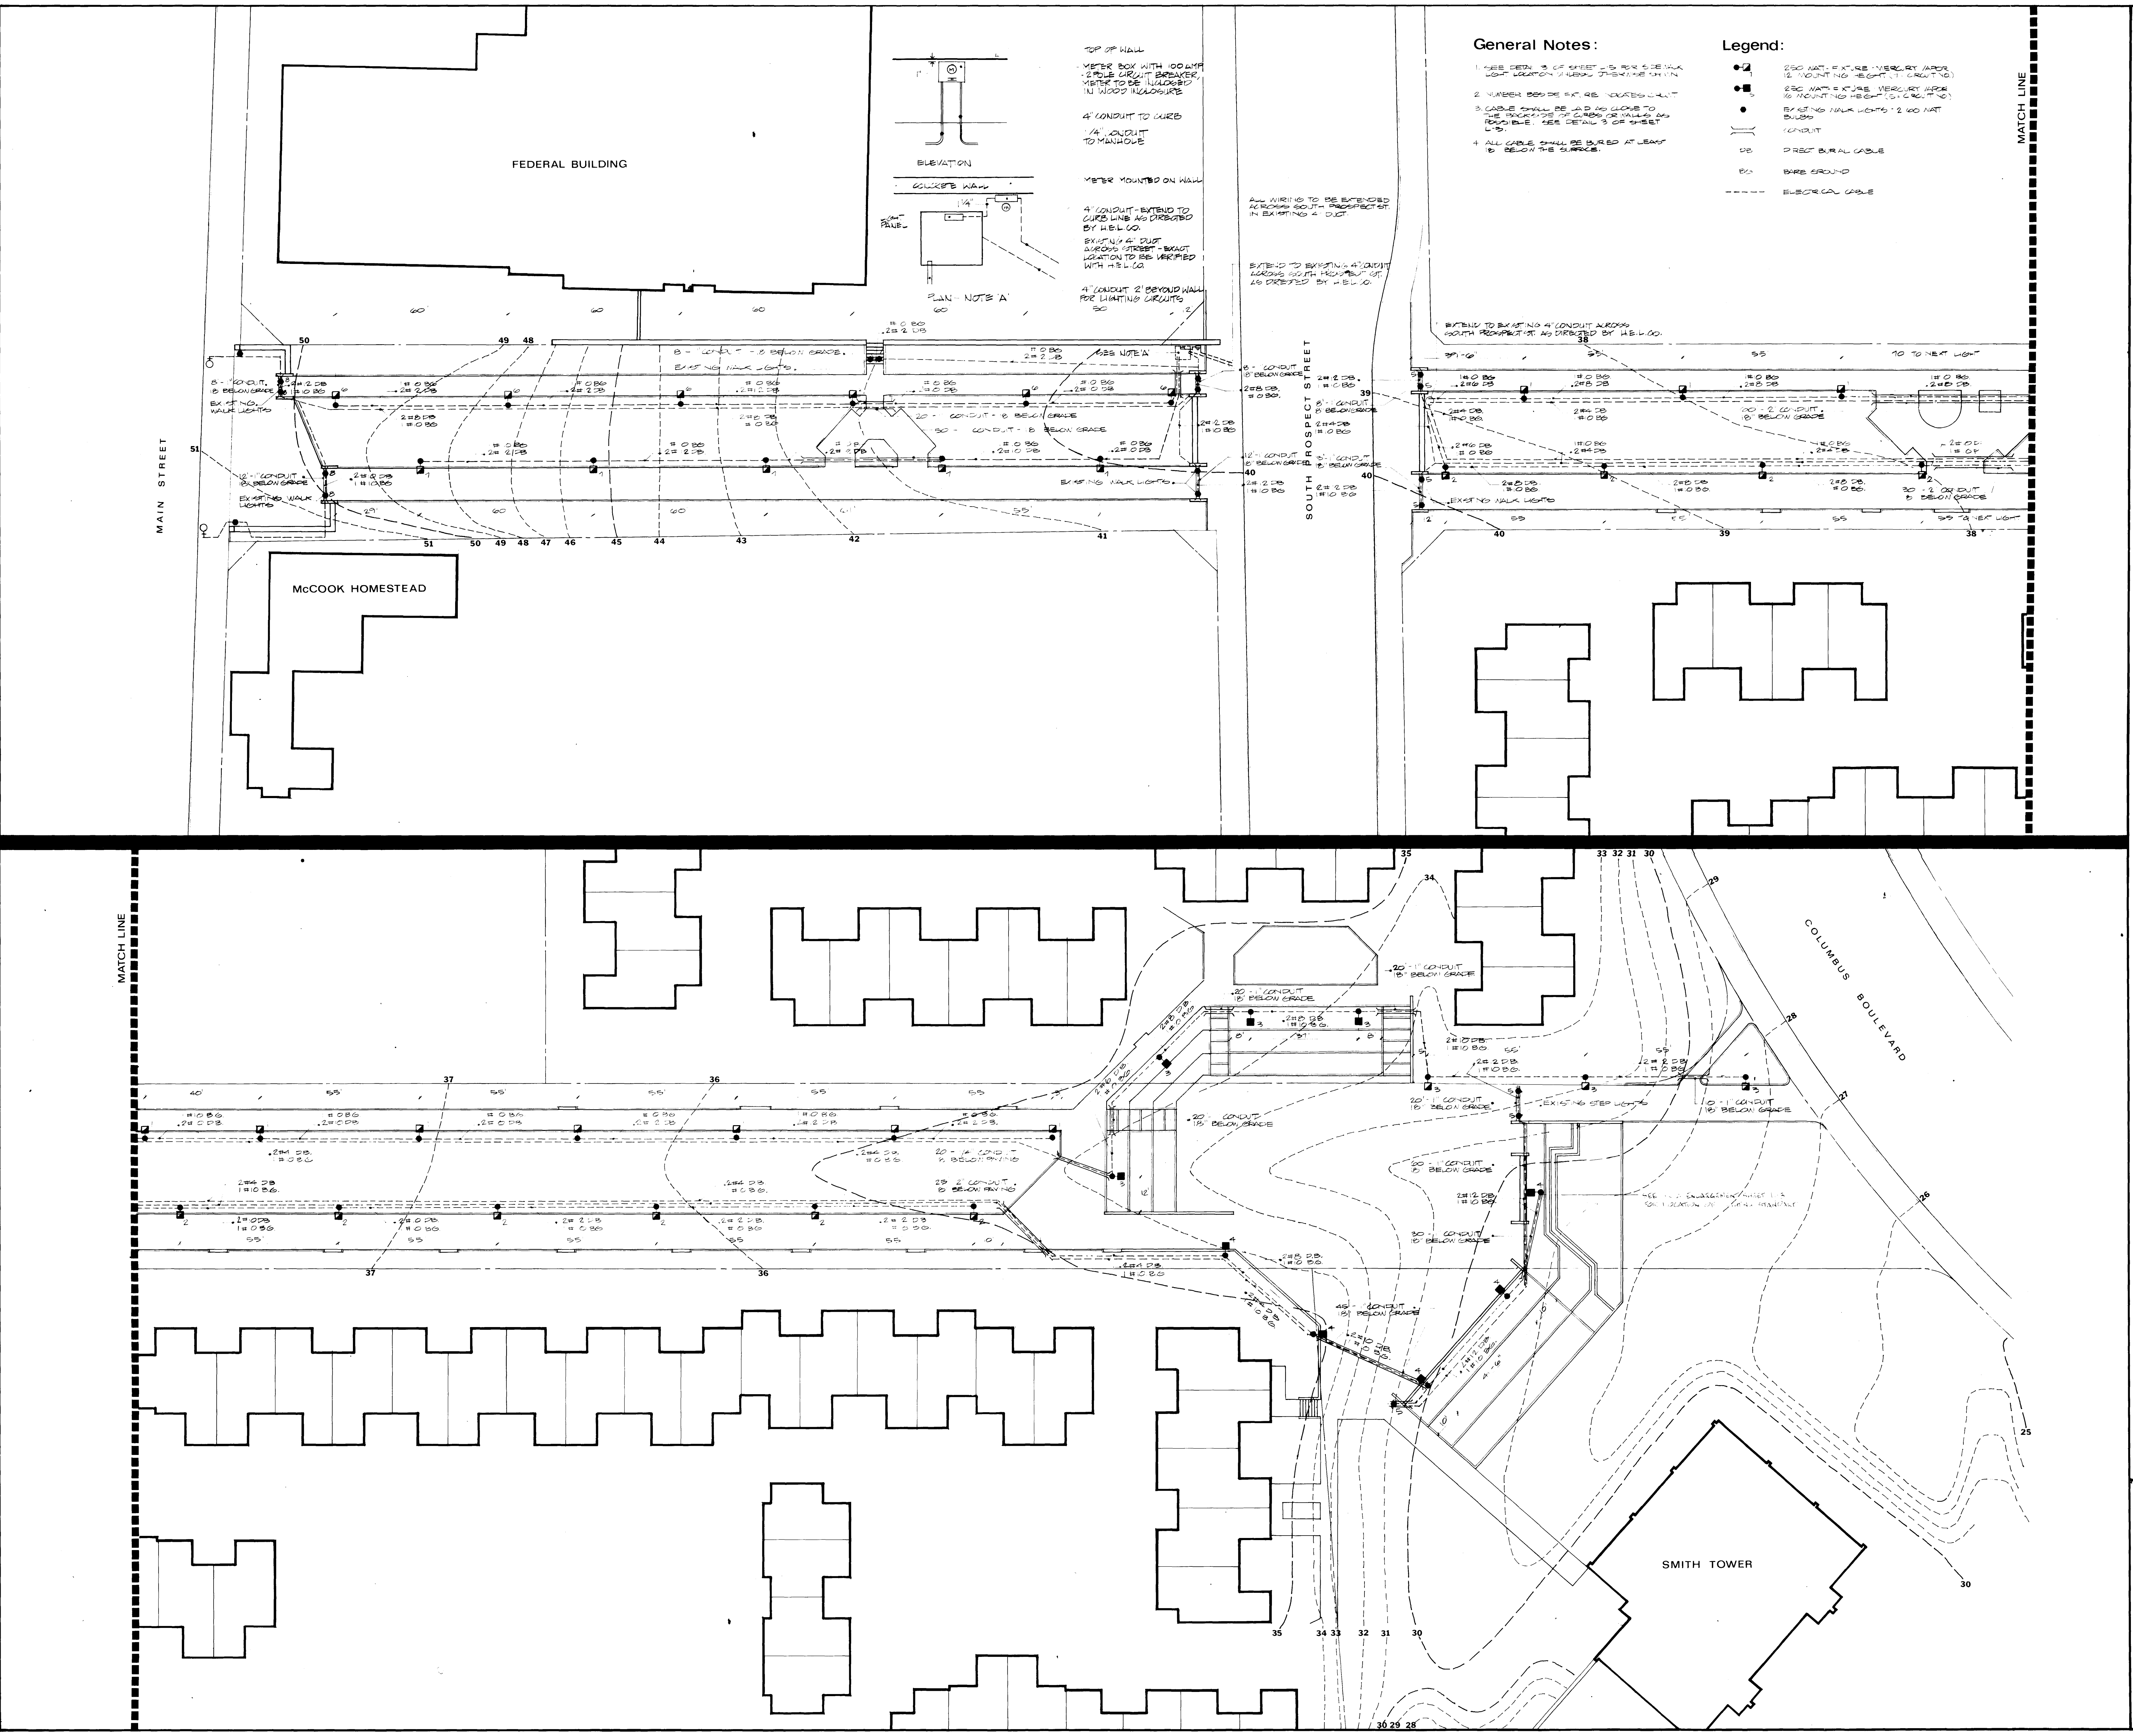


General Notes:

- 1. SEE DETAIL 3 OF SHEET 15 FOR CABLE BOX LOCATION WHEN OVER THE CURB.
- 2. NUMBER BOXES BY THE HOUSES UNIT.
- 3. CABLE SHALL BE 2" O.D. CABLE TO THE PROPERTY OF CURB OR WALKWAY. THEREAFTER, SEE DETAIL 3 OF SHEET 15.
- 4. ALL CABLE SHALL BE BURIED AT LEAST 18" BELOW THE SURFACE.


Legend:

- 250 NAT. EXT. VERT. (APR) 12" MOUNTING HEIGHT (1" CABLE TO)
- 250 NAT. EXT. VERT. (APR) 16" MOUNTING HEIGHT (1" CABLE TO)
- EXISTING WALK LIGHTS 2" O.D. NAT. BUSH
- CONDUIT
- PREC. BURIAL CABLE
- BARE GROUND
- ELECTRICAL CABLE

SCALE 1"=20'-0"
DRAWN BY: JH
DATE: 9-22-72
REV.

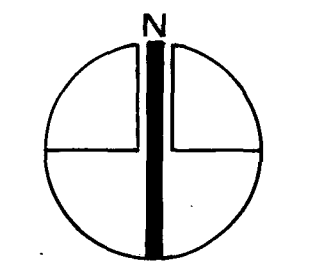

JOHNSON and DEE
LANDSCAPE ARCHITECTS
10 DESIGN LANE, AVON, CT.

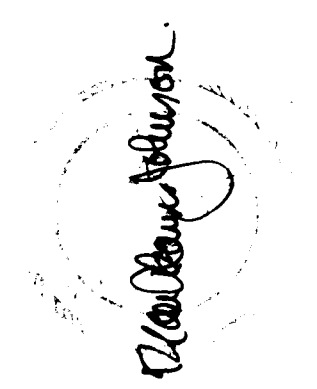

LIGHTING PLAN
SHELDON OAK MALL
HARTFORD CONNECTICUT
DAYBOOK NO. 010367-D