


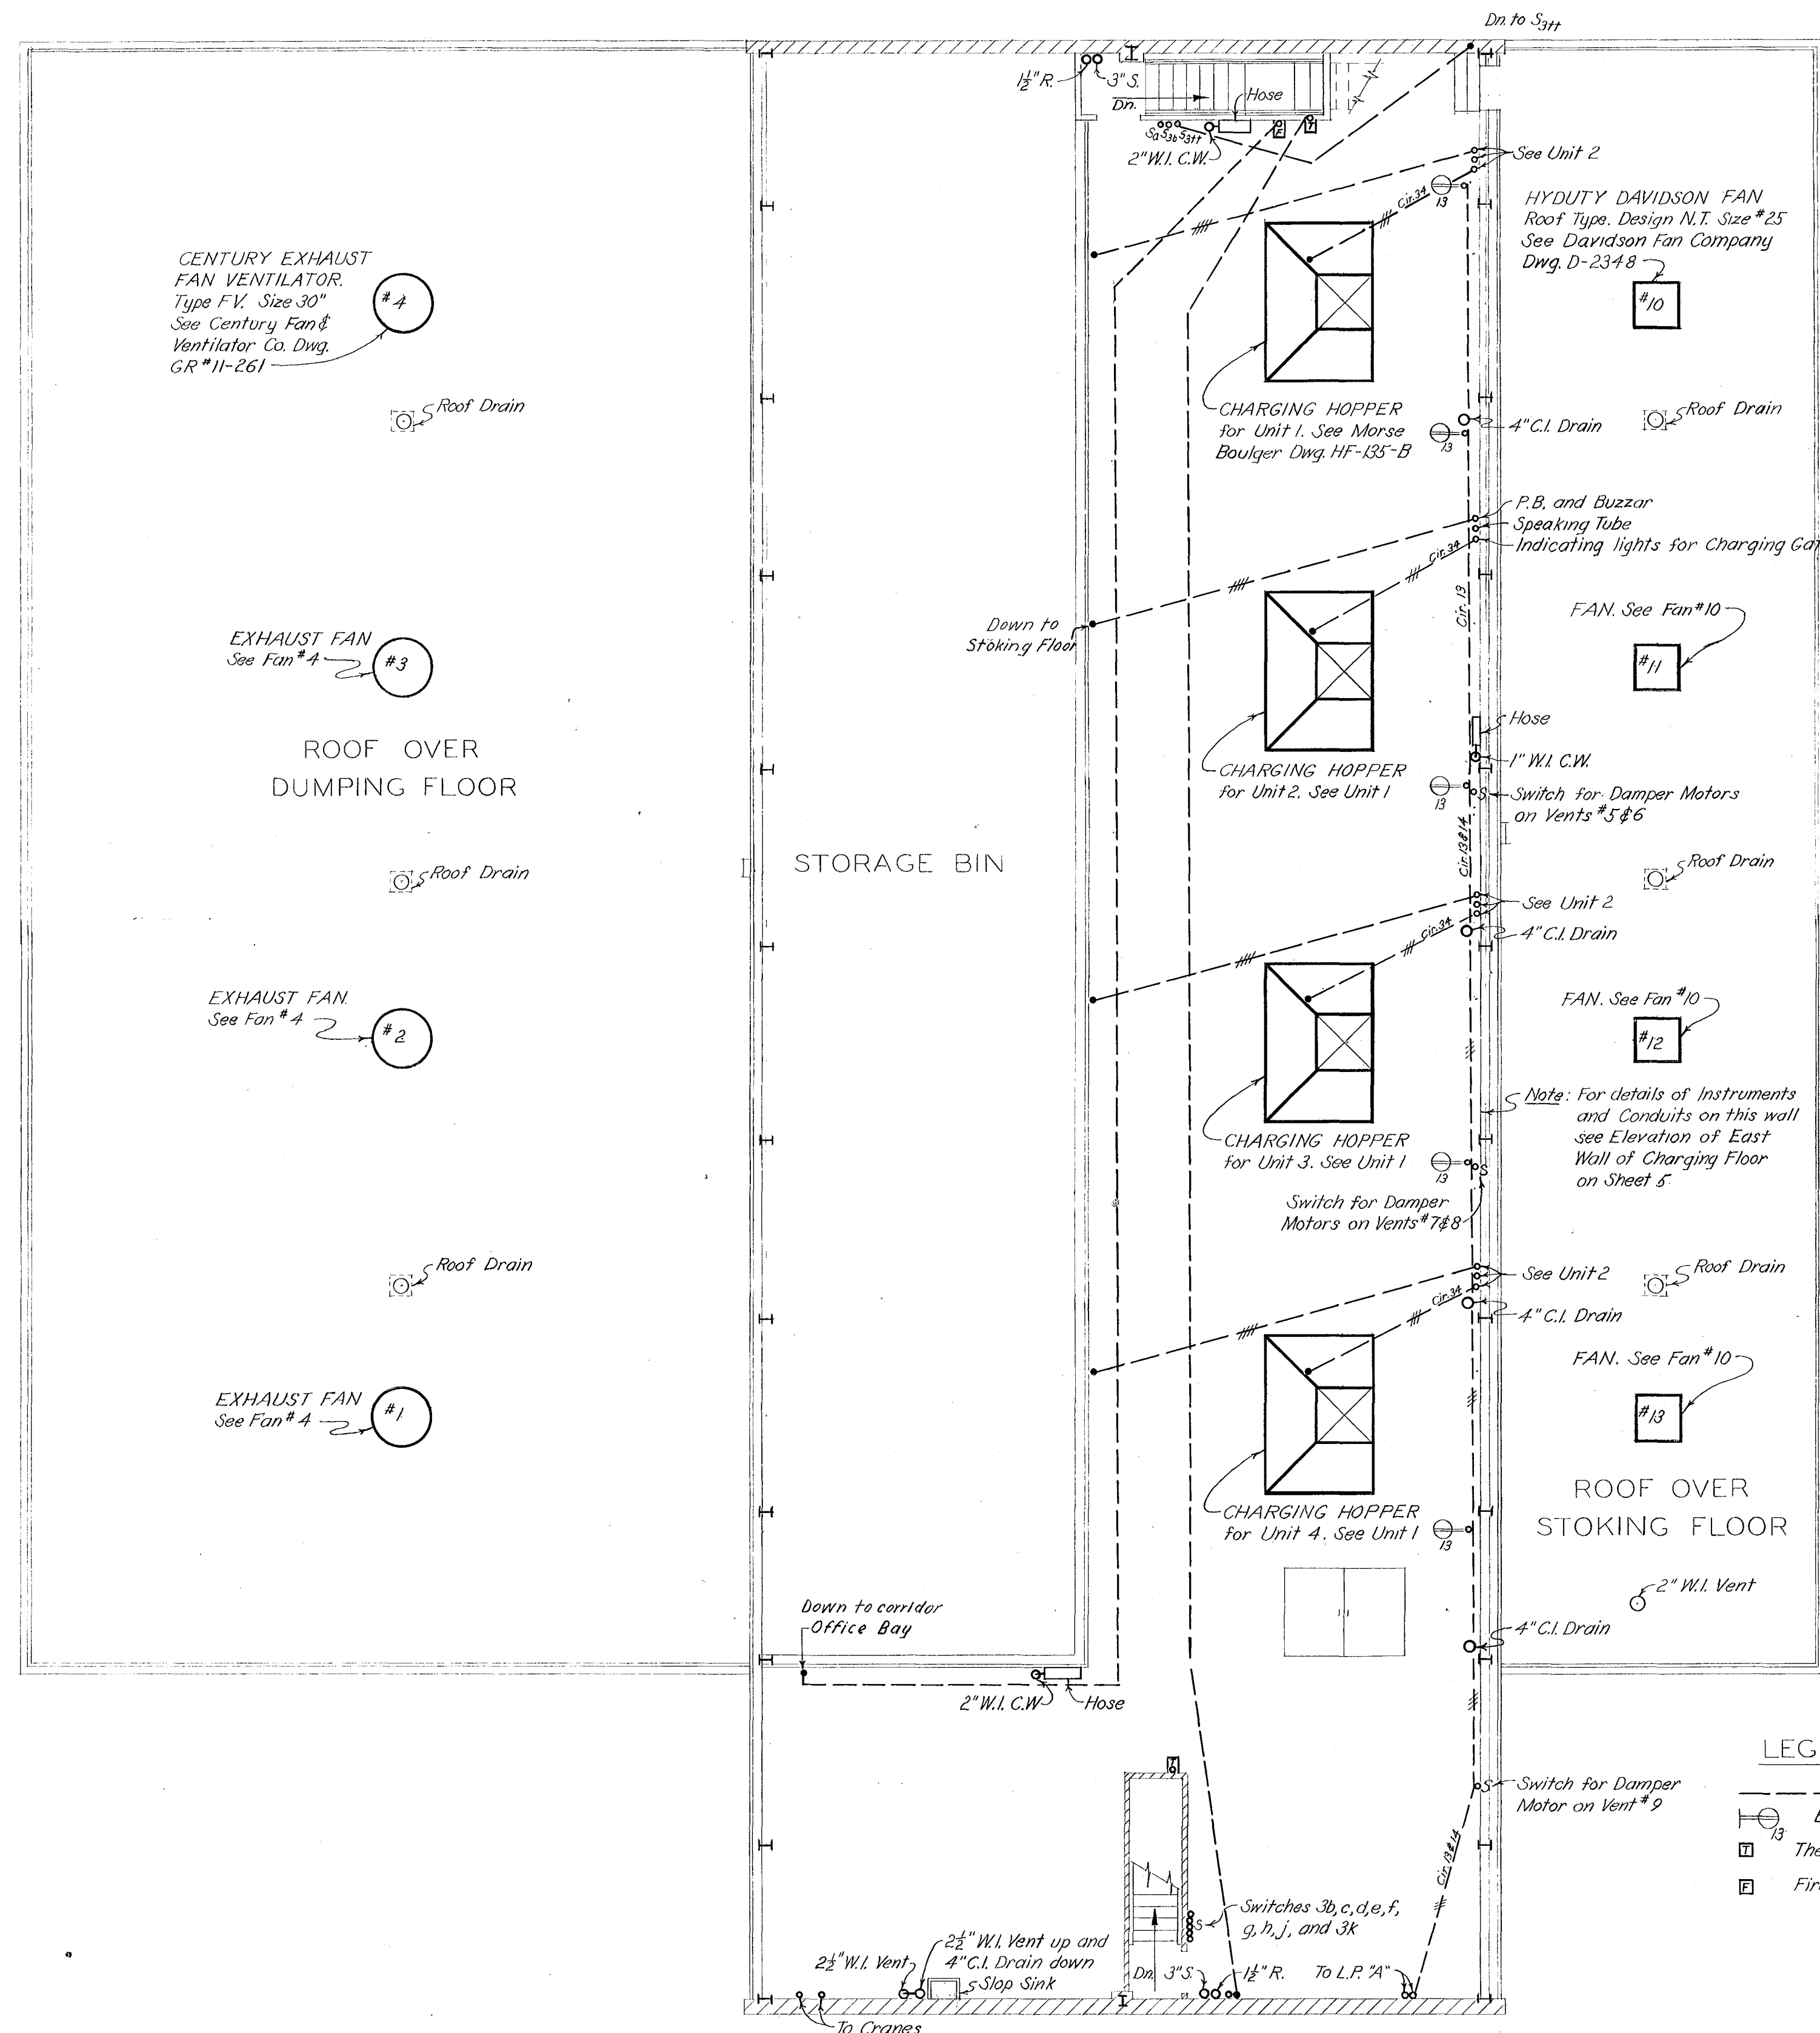

FLOOR PLAN OF CHARGING FLOOR

SCALE: 1/8"=1'-0"

DRAWN BY D.W.R.
TRACED BY D.W.R.
CHECKED BY H.C.

APPROVED
FOR METCALF & EDDY, ENGINEERS
DATE

CITY OF HARTFORD, CONN.
CARLETON F. SHARPE - CITY MANAGER
H. IRVING SKILTON - CITY ENGINEER
CHARLES W. COOKE - DIRECTOR, PUBLIC WORKS
NORTH MEADOWS INCINERATOR
RECORD DRAWINGS
CHARGING FLOOR
FLOOR PLAN
SCALE: AS SHOWN
DEC, 1954
METCALF & EDDY
ENGINEERS
BOSTON, MASS.