


EL 991
H
45862

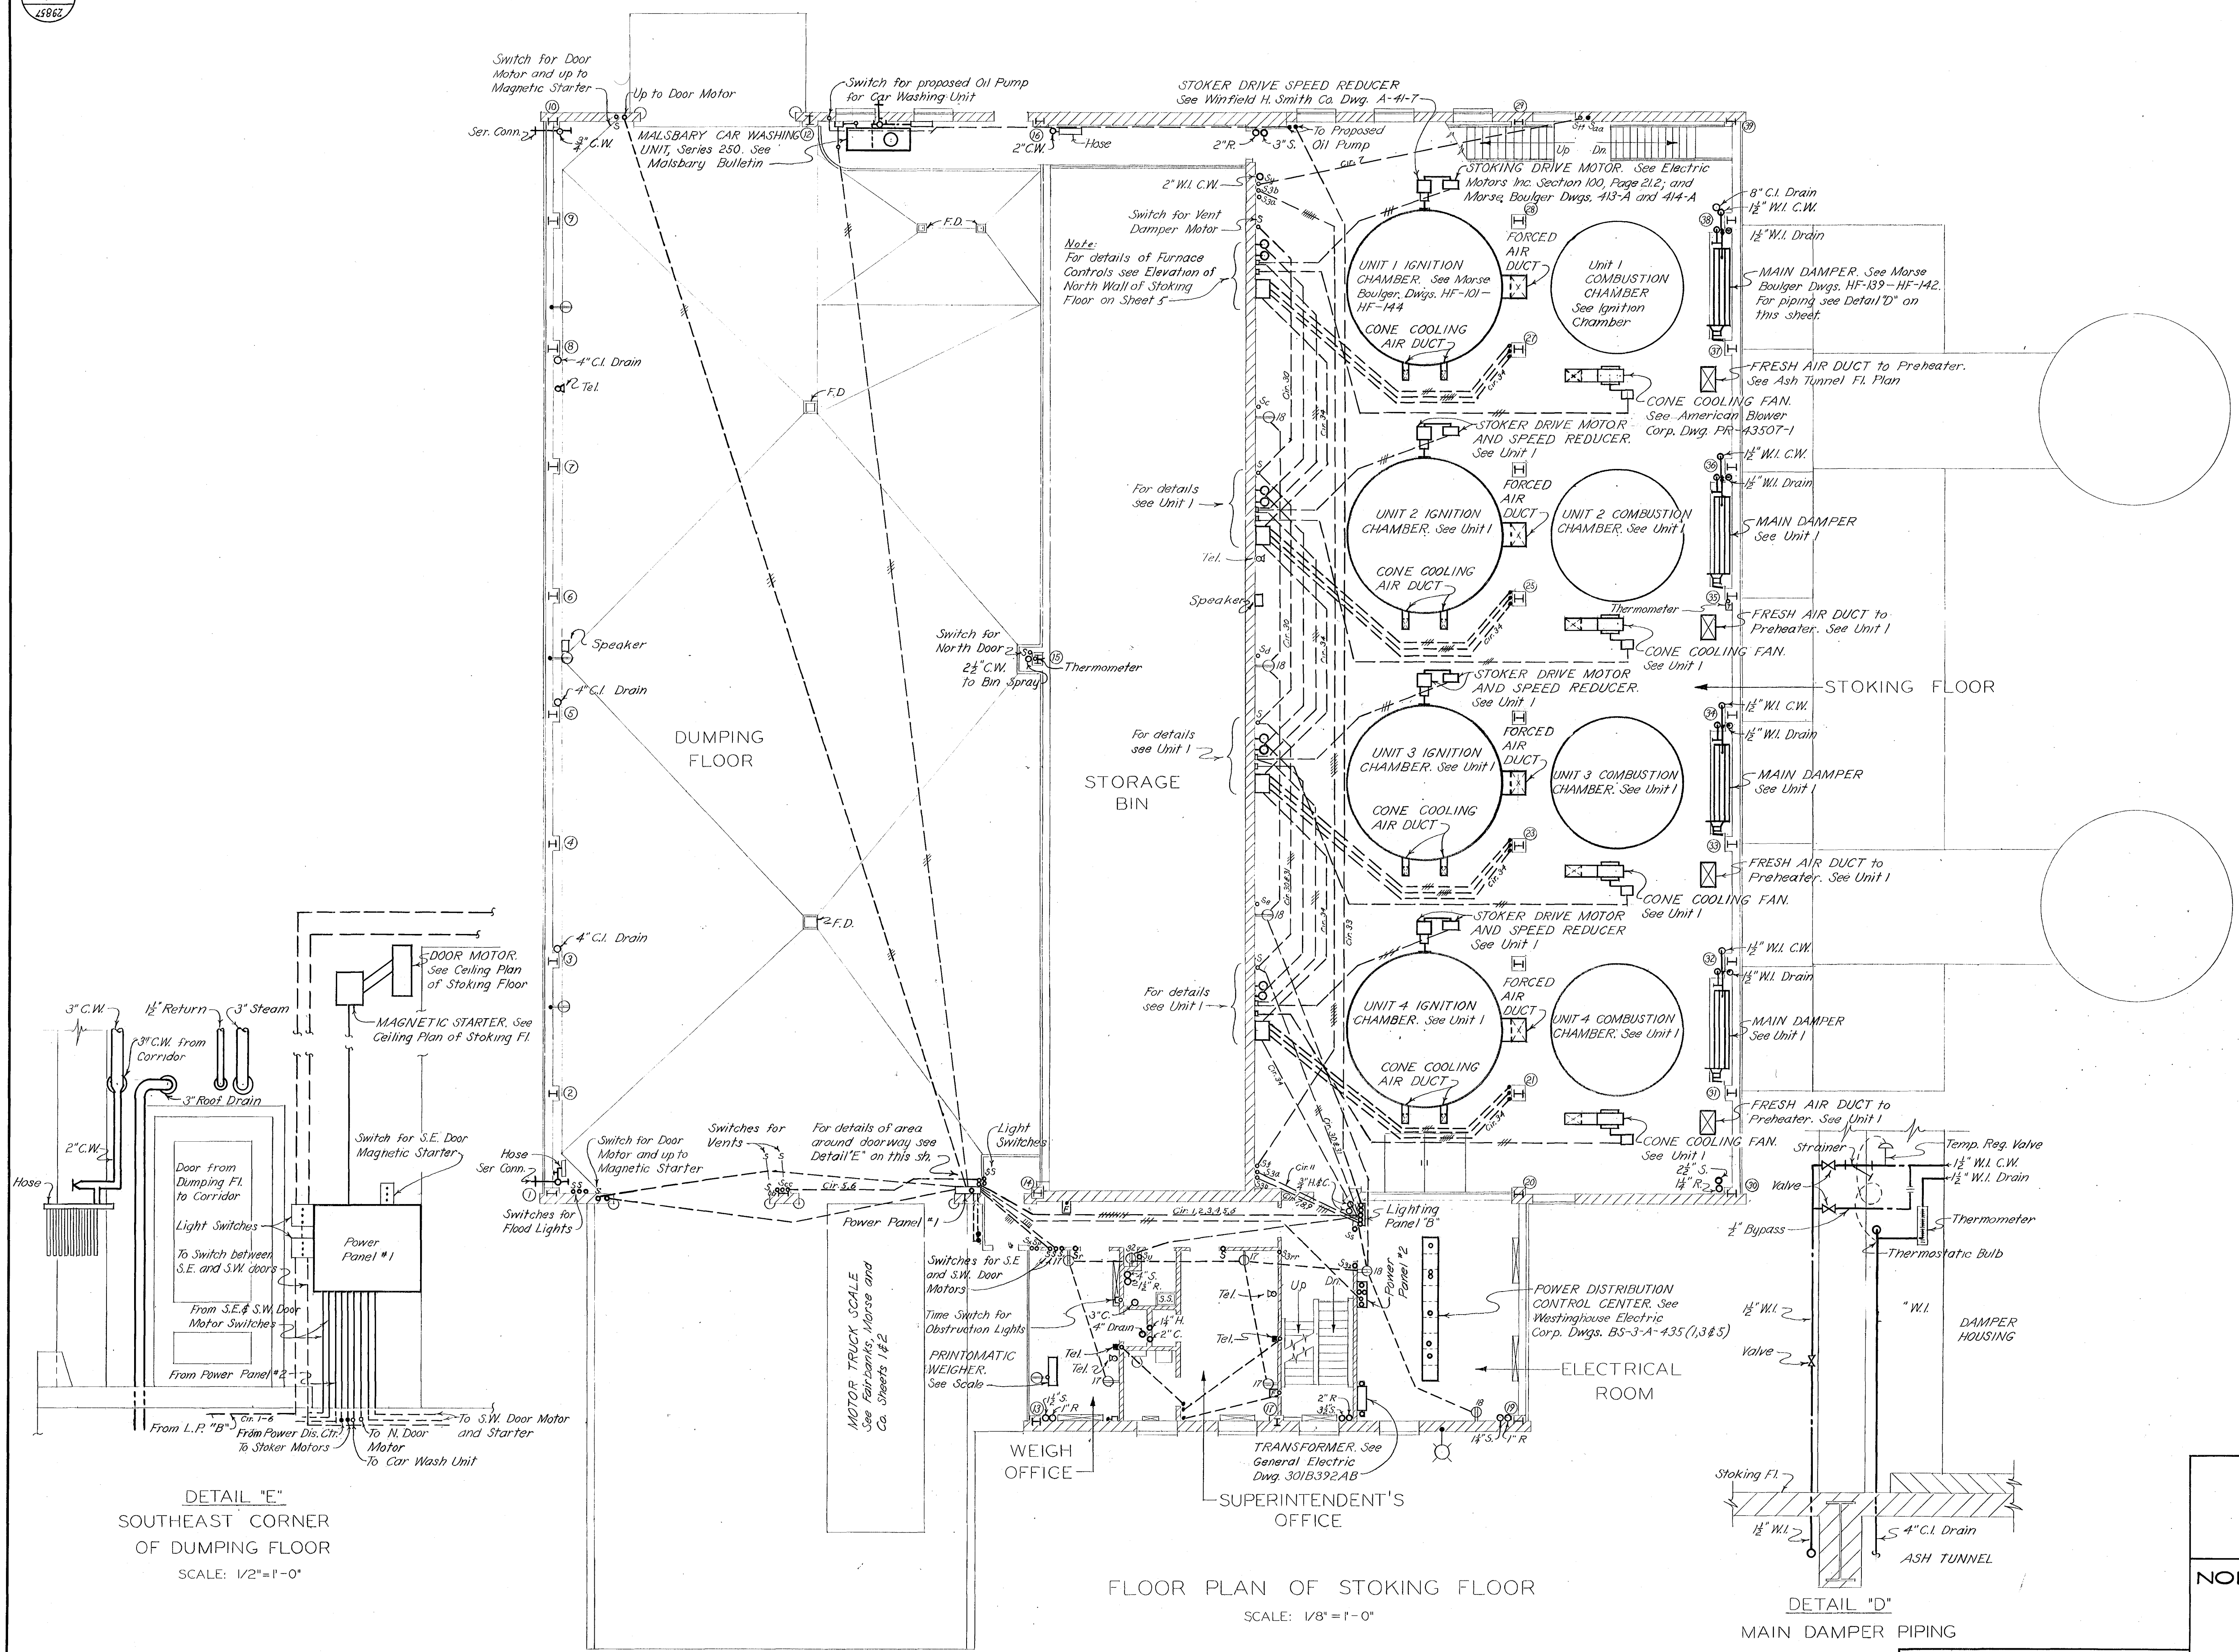

LEGEND

- Exposed conduit carrying 3 wires
- Buried conduit carrying 4 wires
- Exposed Drain
- Cold Water
- Electrical Outlet on Circuit 7
- Switch for Light "d"

CITY OF HARTFORD, CONN.

CARLETON F. SHARPE - CITY MANAGER
H. IRVING SKILTON - CITY ENGINEER
CHARLES W. COOKE - DIRECTOR, PUBLIC WORKS.

**NORTH MEADOWS INCINERATOR
RECORD DRAWINGS**

**STOKING FLOOR AREA
FLOOR PLAN**

SCALE, AS SHOWN DEC, 1954

METCALF & EDDY
ENGINEERS
BOSTON, MASS.

23837
H
15673

DRAWN BY D.W.R.
TRACED BY D.W.R.
CHECKED BY A.L.G.

APPROVED

FOR METCALF & EDDY, ENGINEERS

DATE