


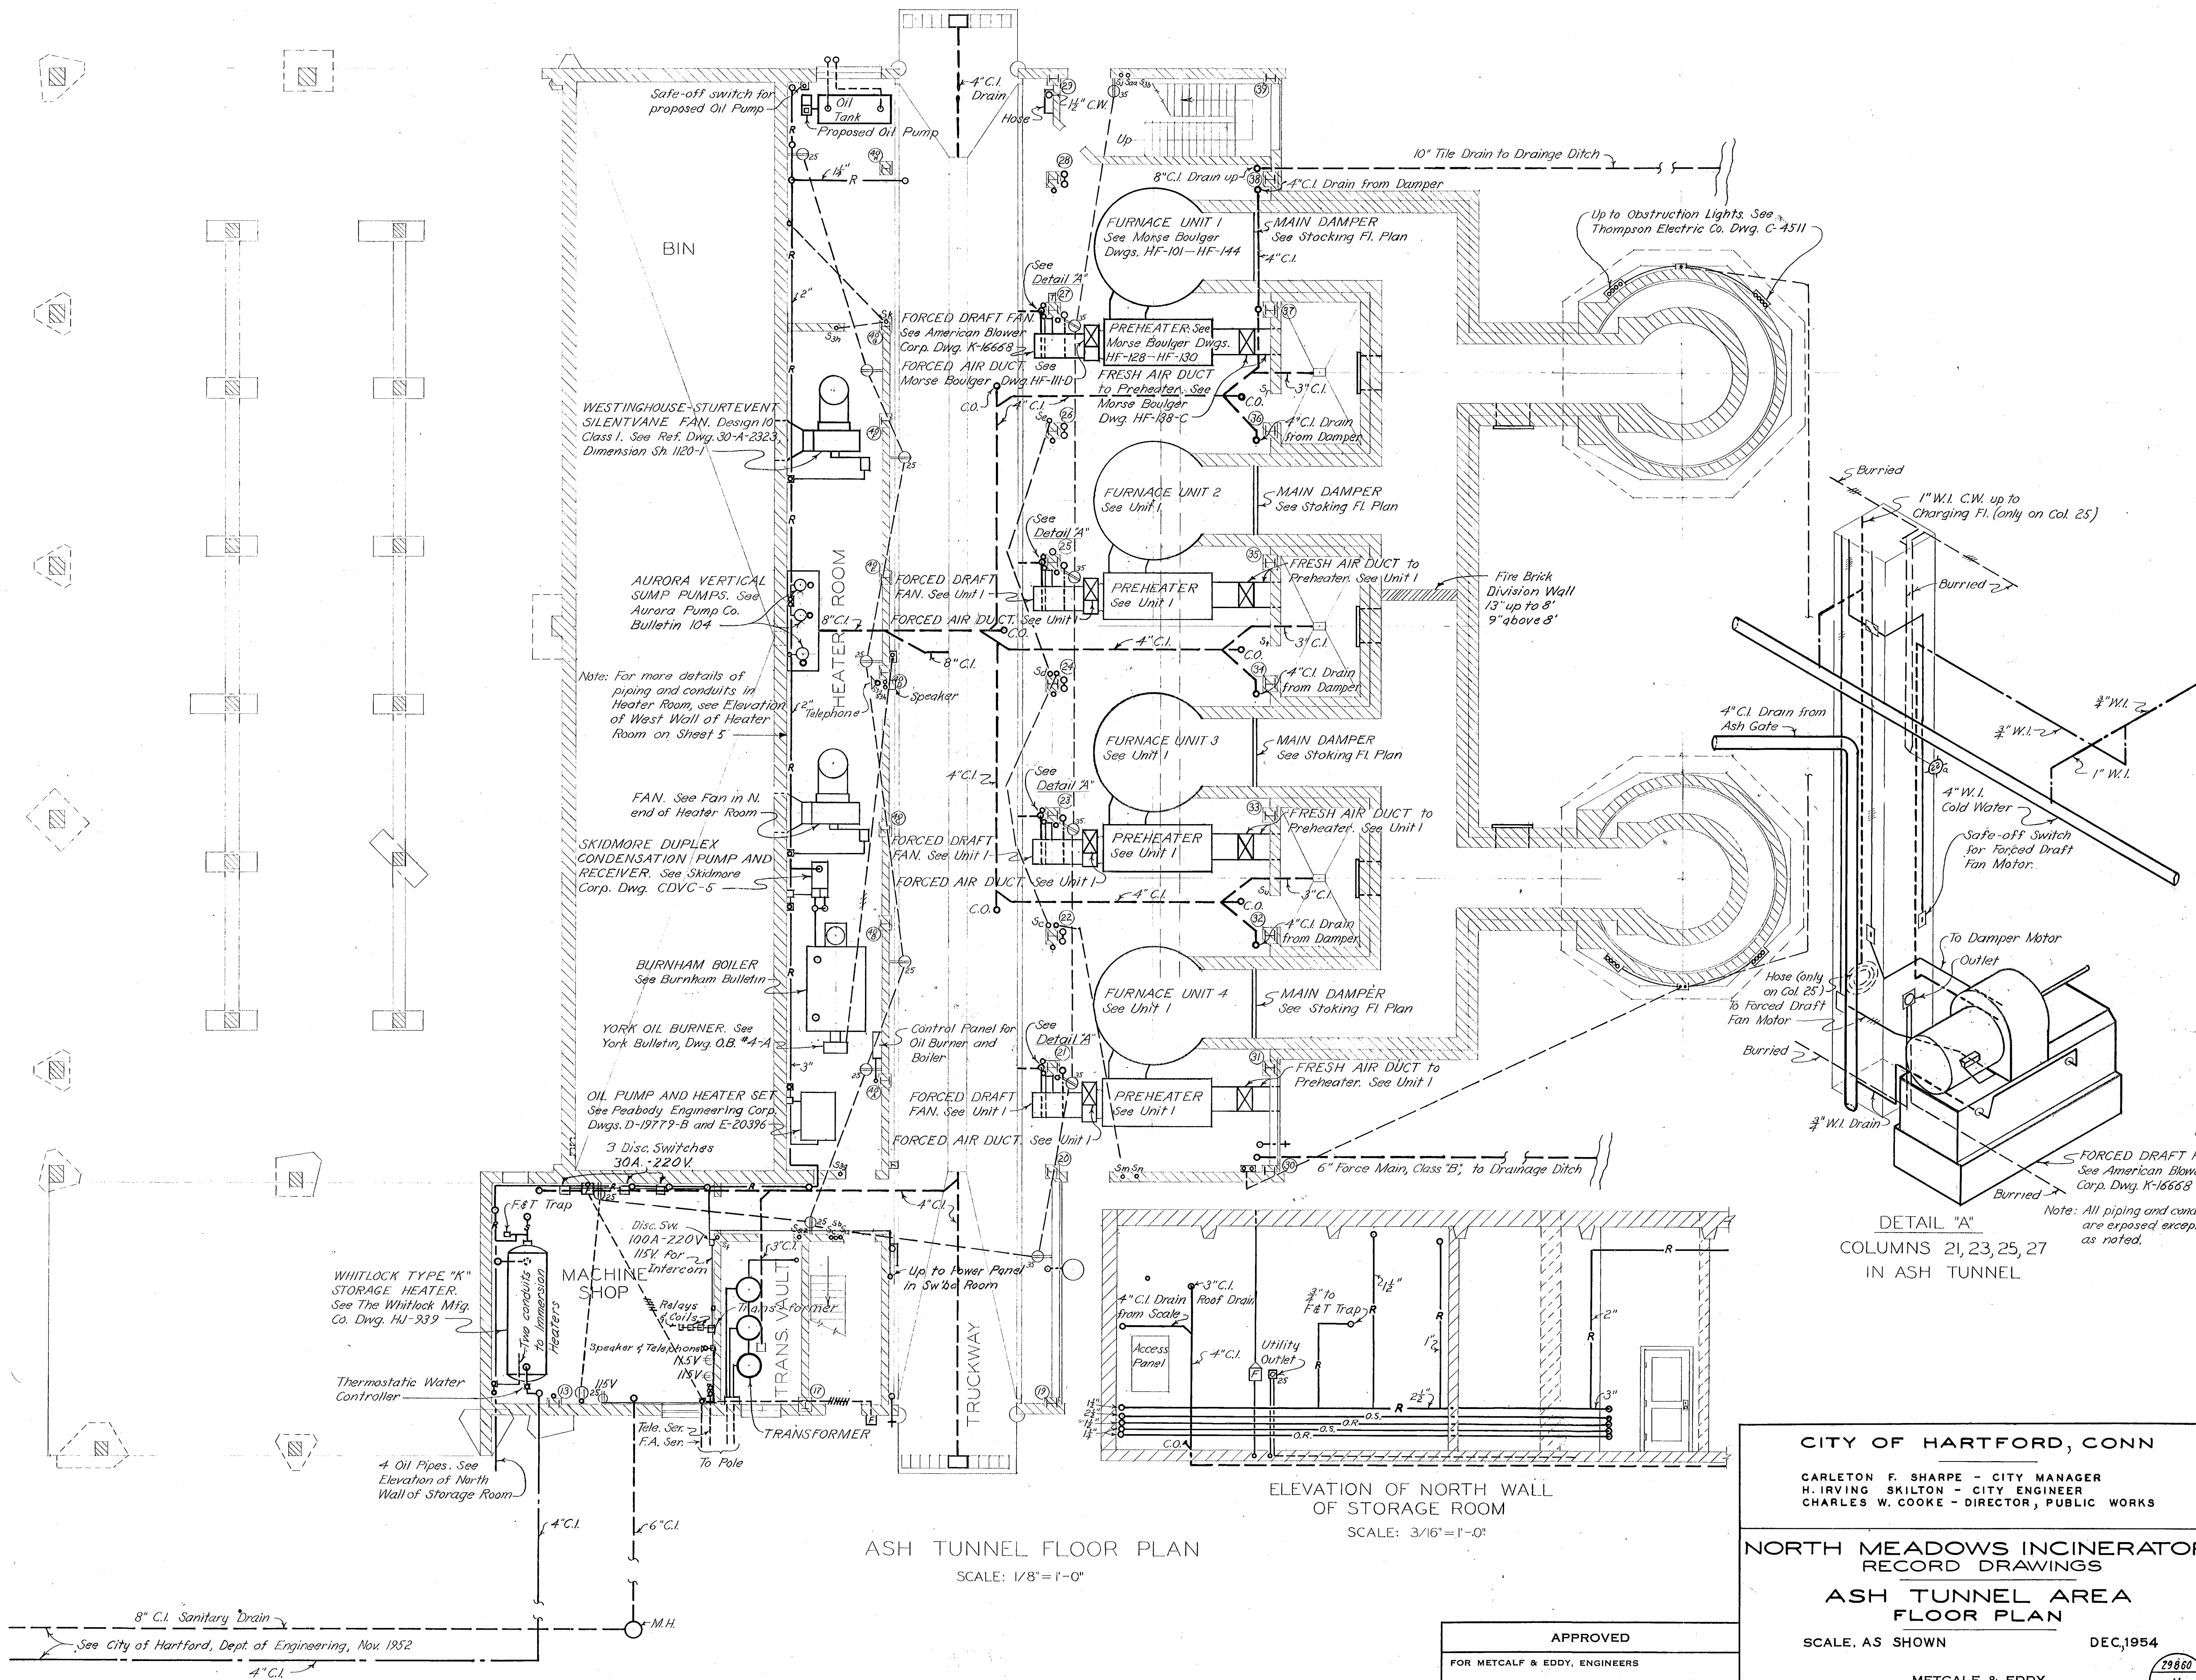

DRAWN BY DWR
TRACED BY DWR
CHECKED BY DWR

See City of Hartford, Dept. of Engineering, Nov. 1952

APPROVED
FOR METCALF & EDDY, ENGINEERS
DATE

CITY OF HARTFORD, CONN
CARLETON F. SHARPE - CITY MANAGER
H. IRVING SKILTON - CITY ENGINEER
CHARLES W. COOKE - DIRECTOR, PUBLIC WORKS

NORTH MEADOWS INCINERATOR
RECORD DRAWINGS
ASH TUNNEL AREA
FLOOR PLAN

SCALE, AS SHOWN
DEC. 1954

METCALF & EDDY
ENGINEERS
BOSTON, MASS.

22860
H
15676