




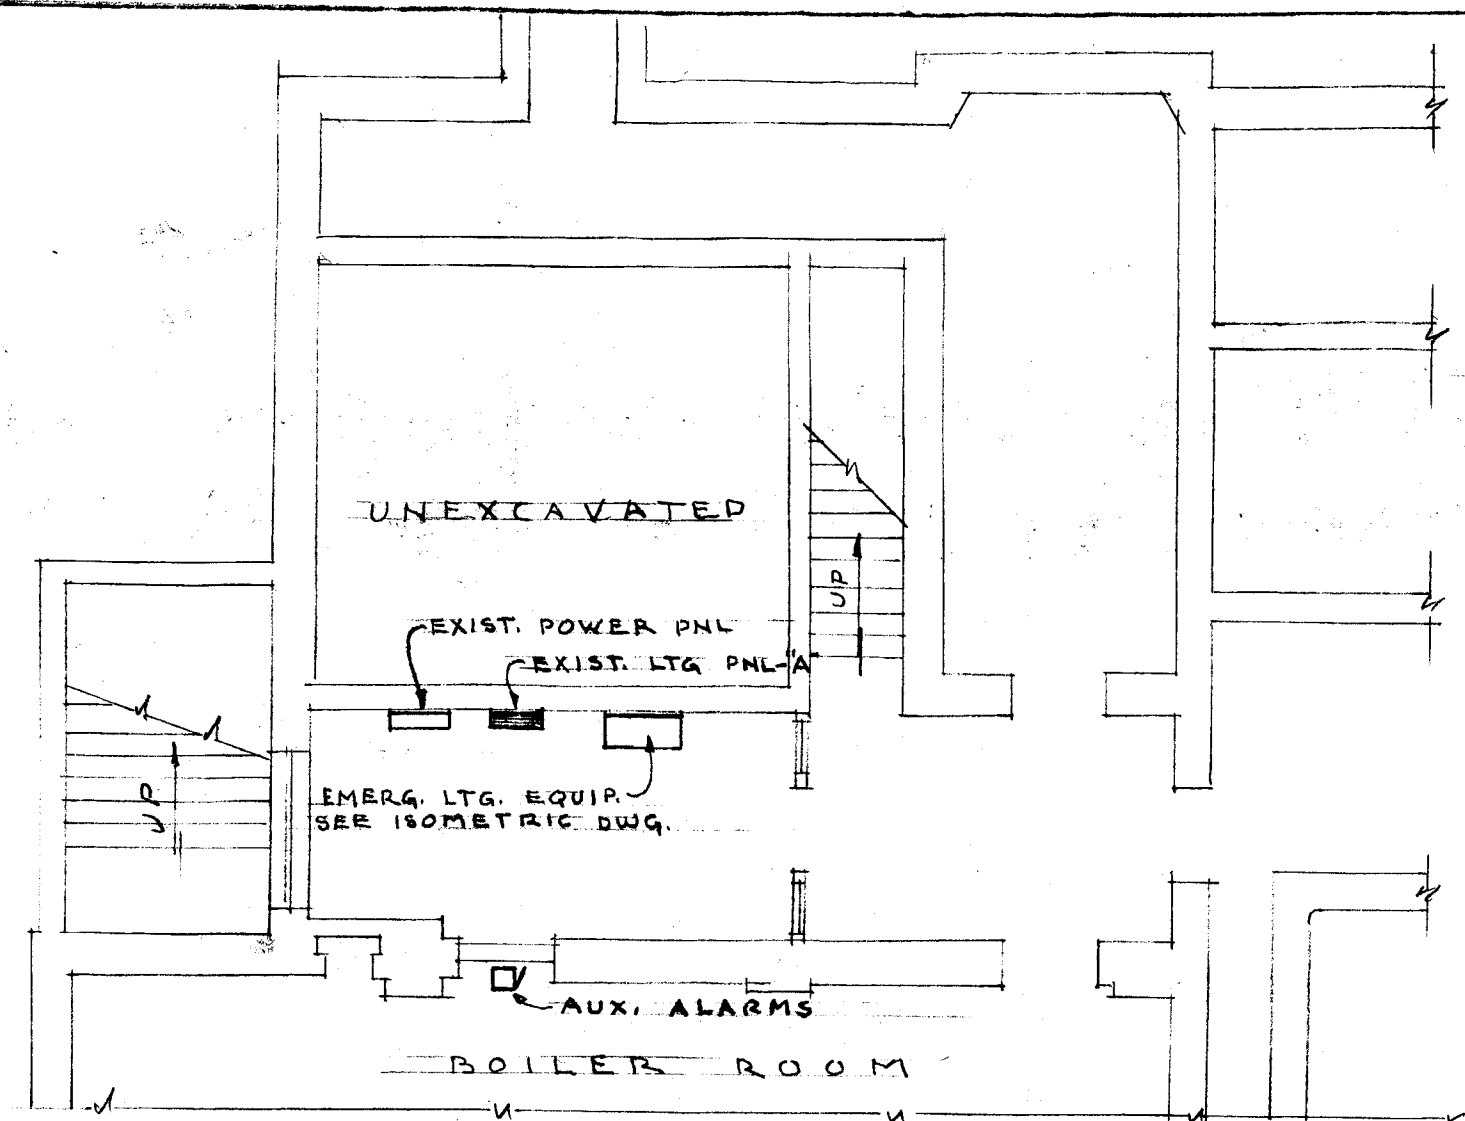


SUB-BASEMENT PARTIAL PLAN
SCALE 1/8" = 1'-0"

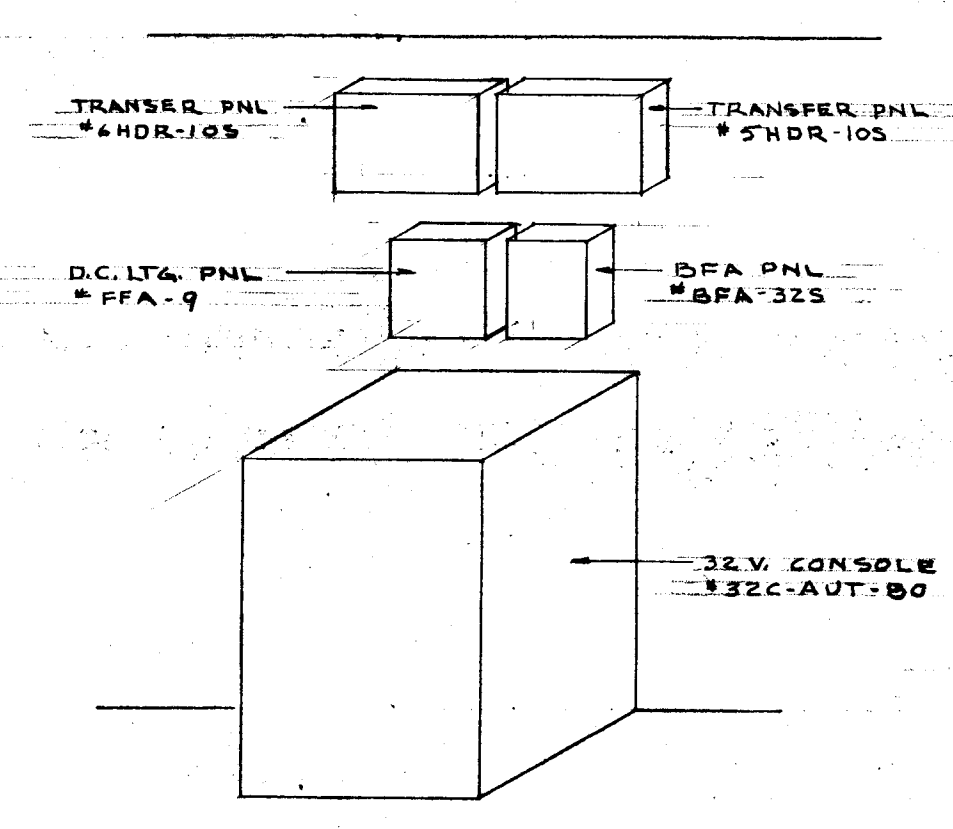


ISOMETRIC OF
EMERGENCY EQUIPMENT
NO SCALE

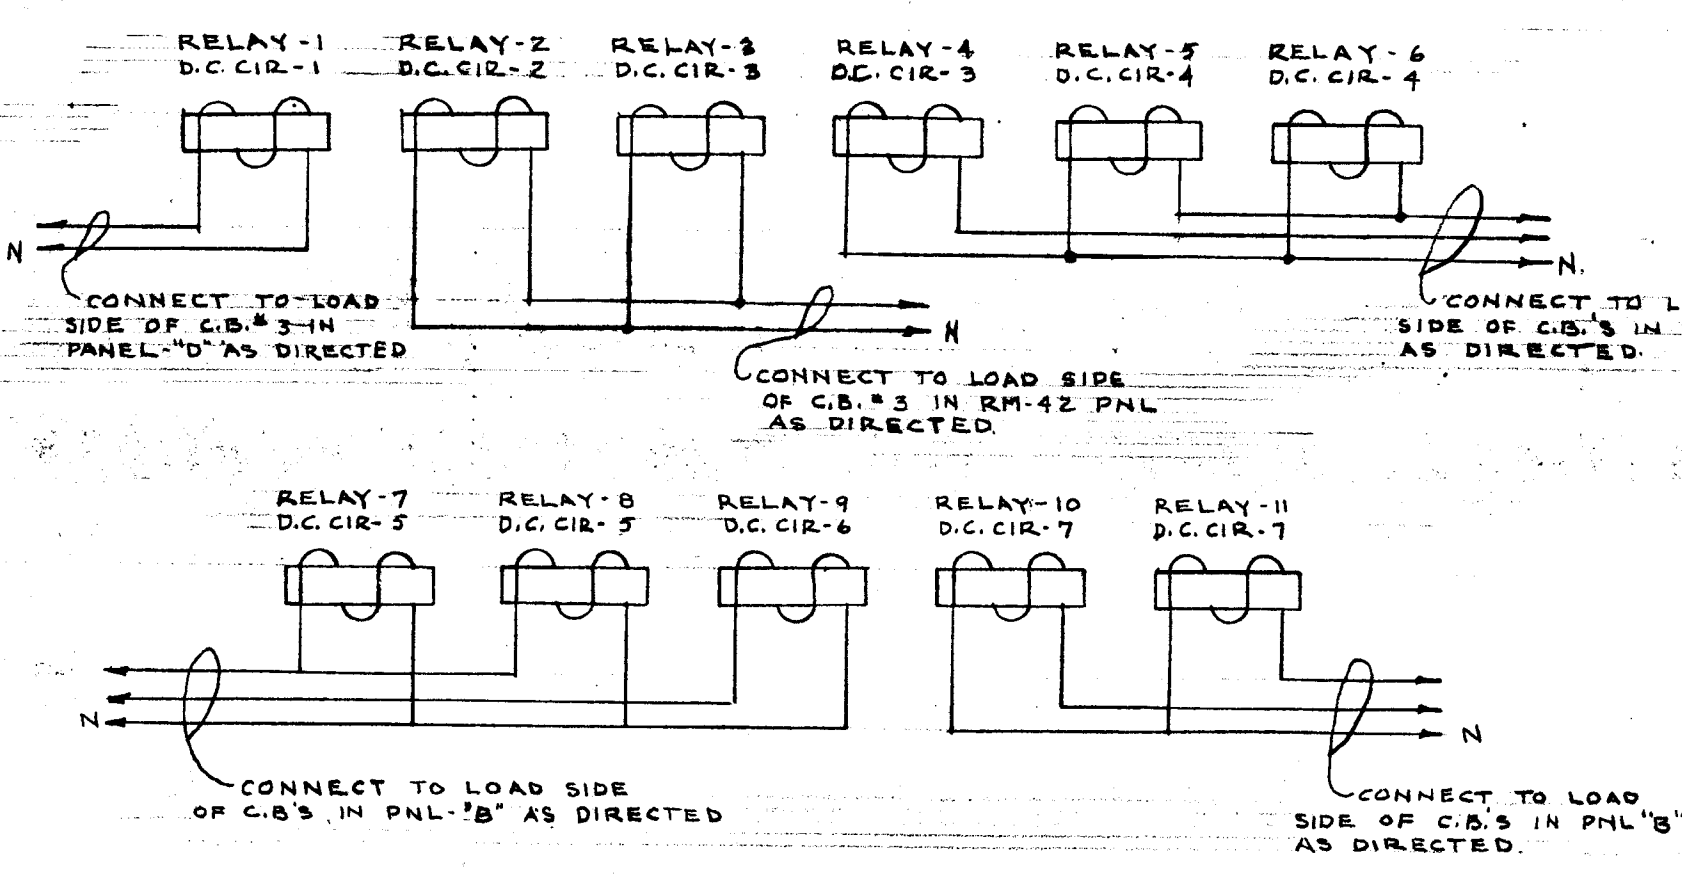


WIRING DIAGRAM FOR A.C. CONTROL
OF RELAYS IN TRANSFER PANELS
NO SCALE

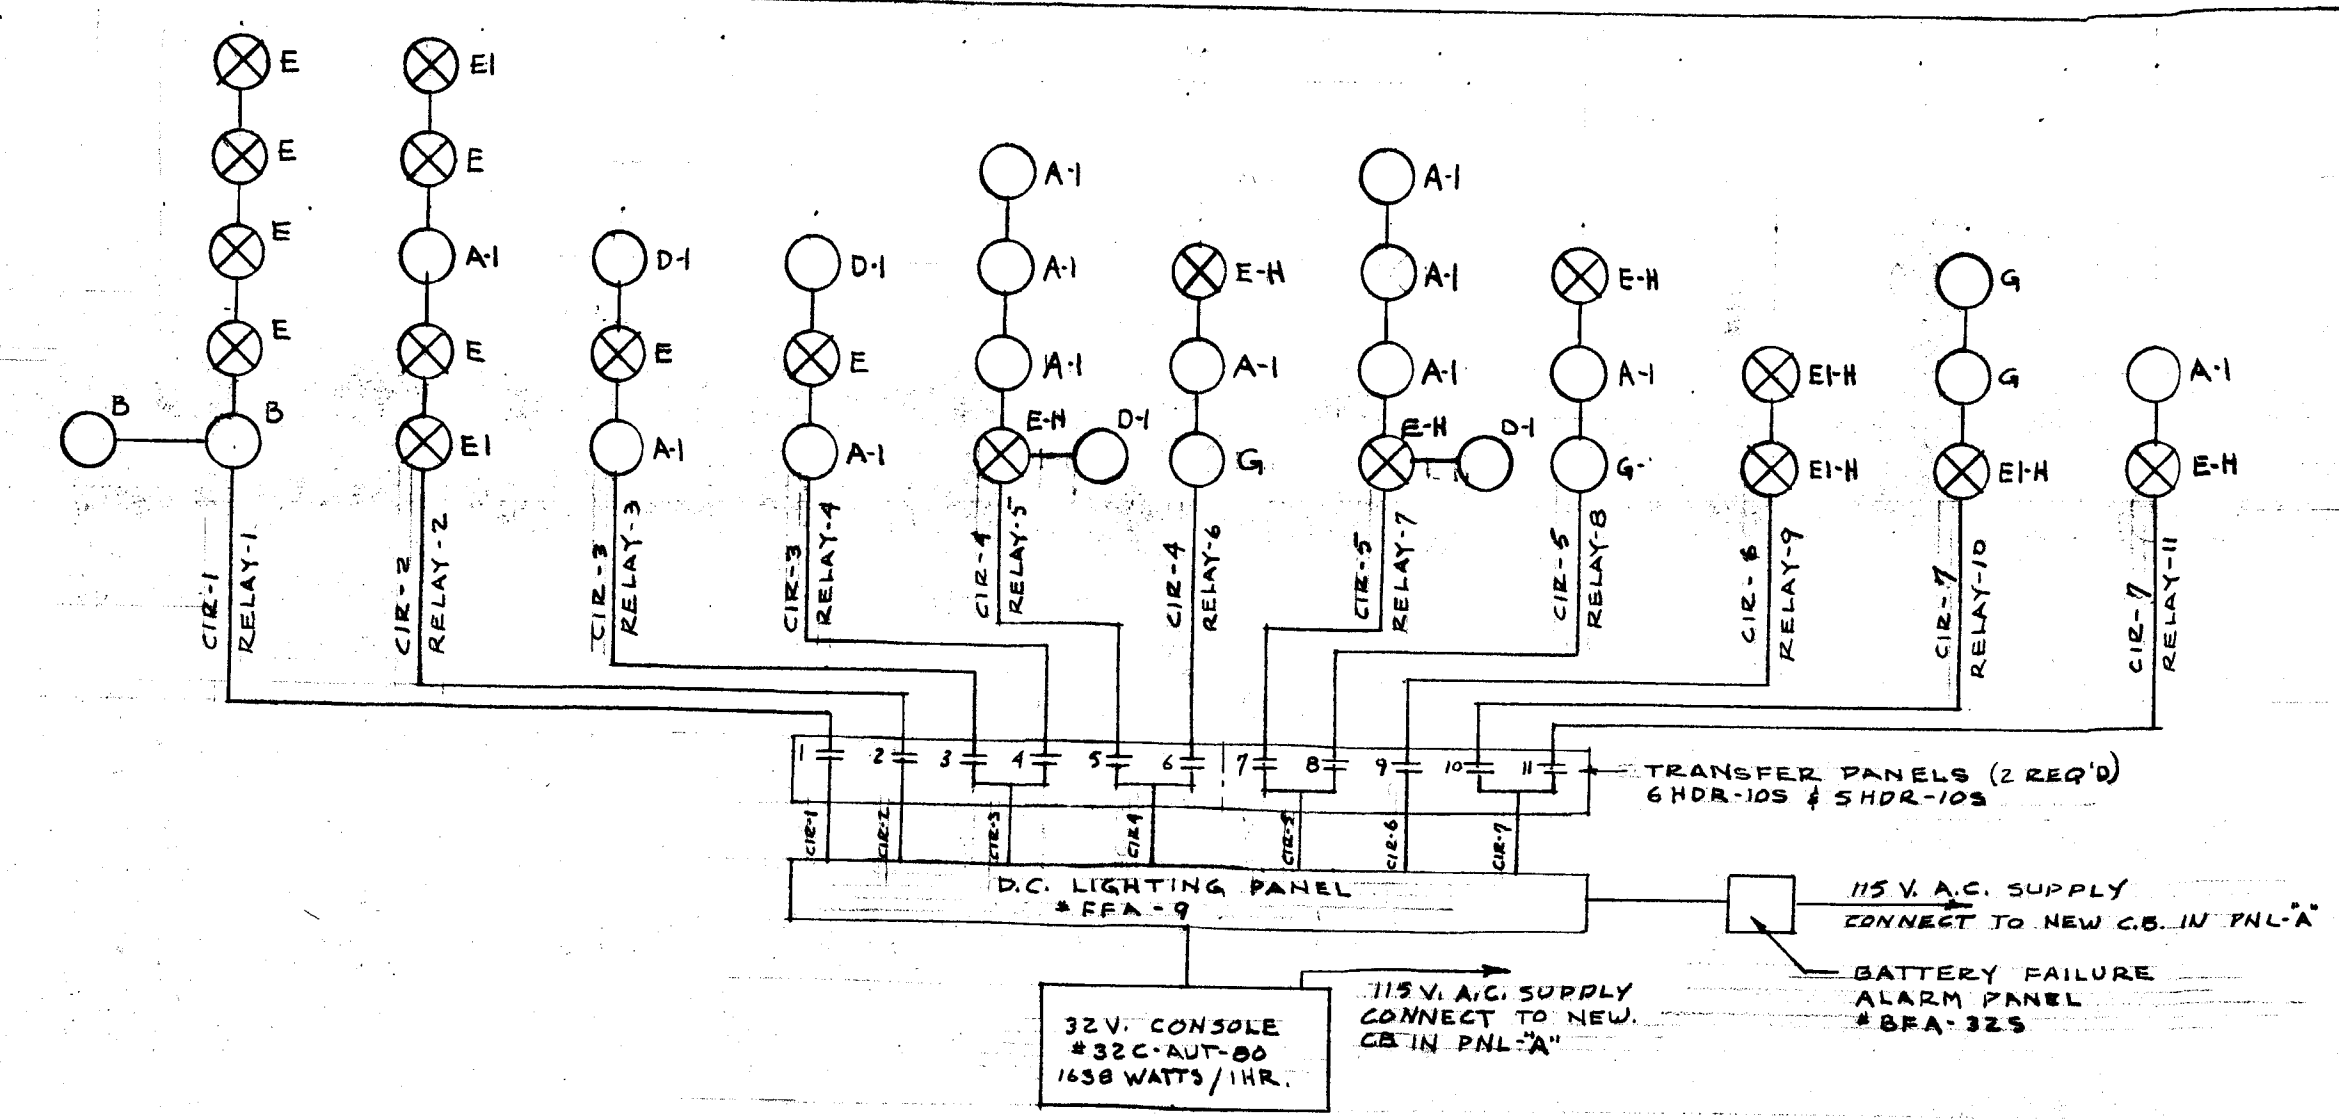

EMERGENCY LIGHTING SCHEMATIC
NO SCALE

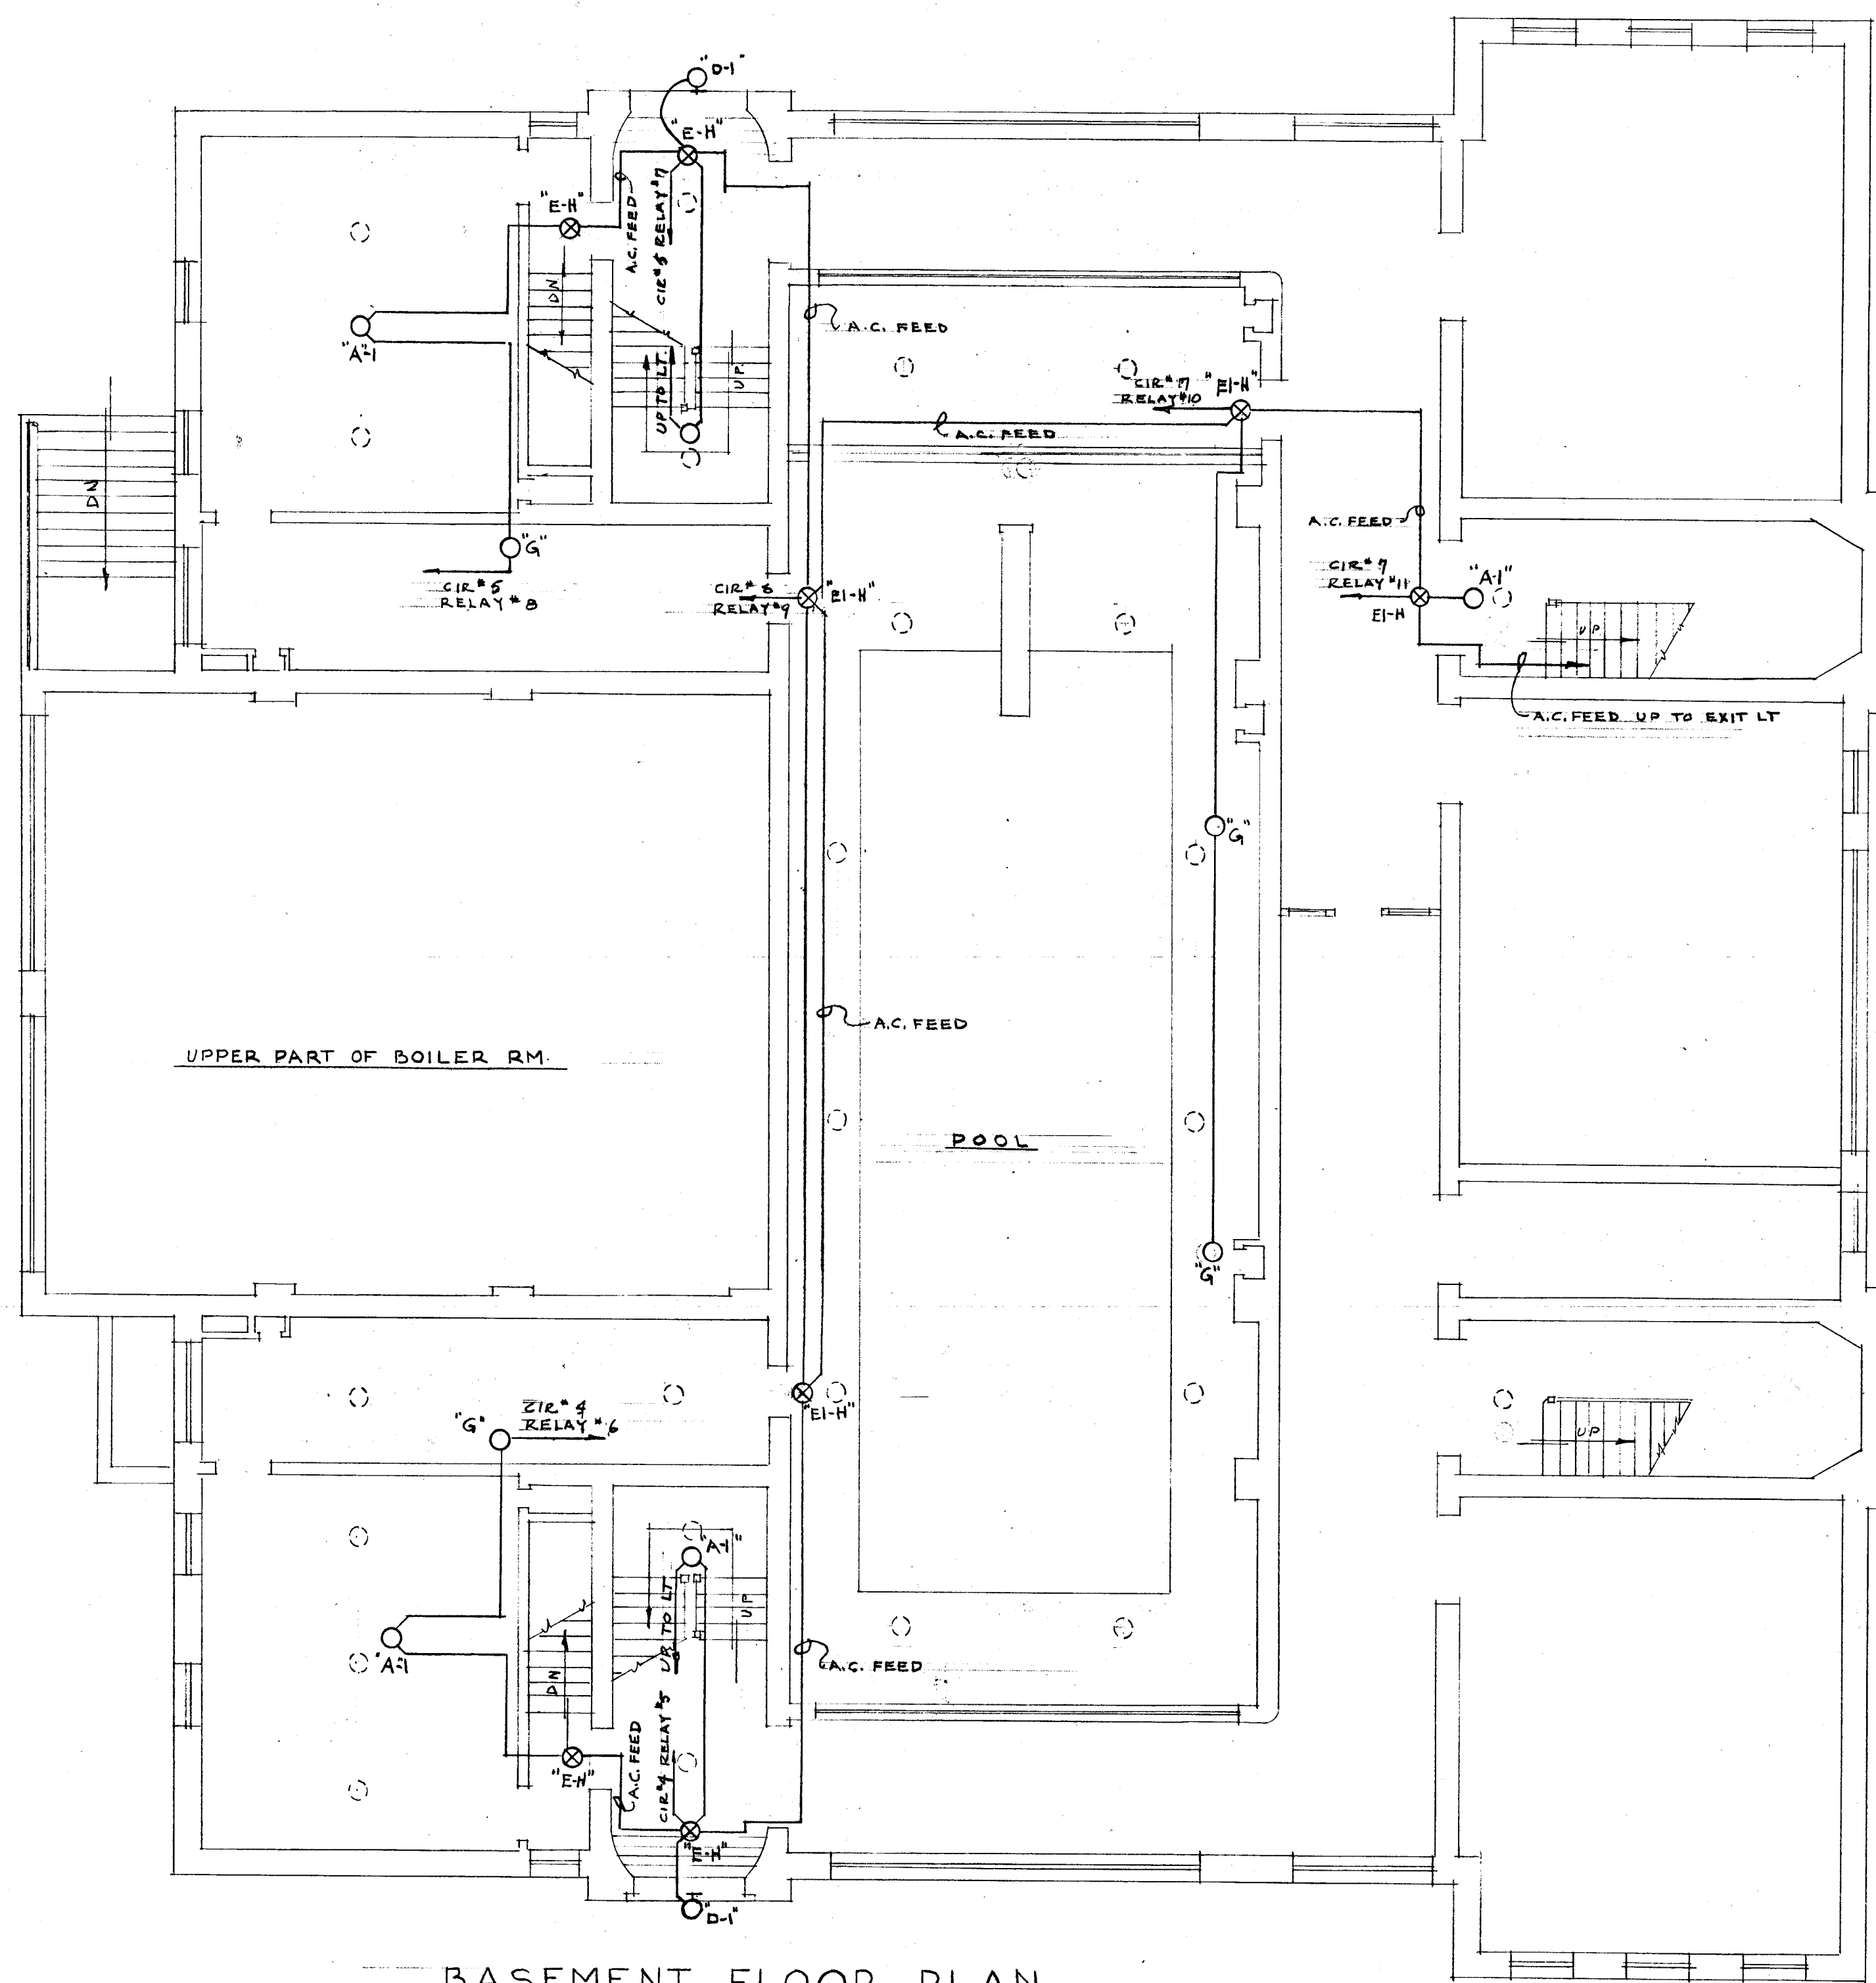

BASEMENT FLOOR PLAN
SCALE 1/8" = 1'-0"

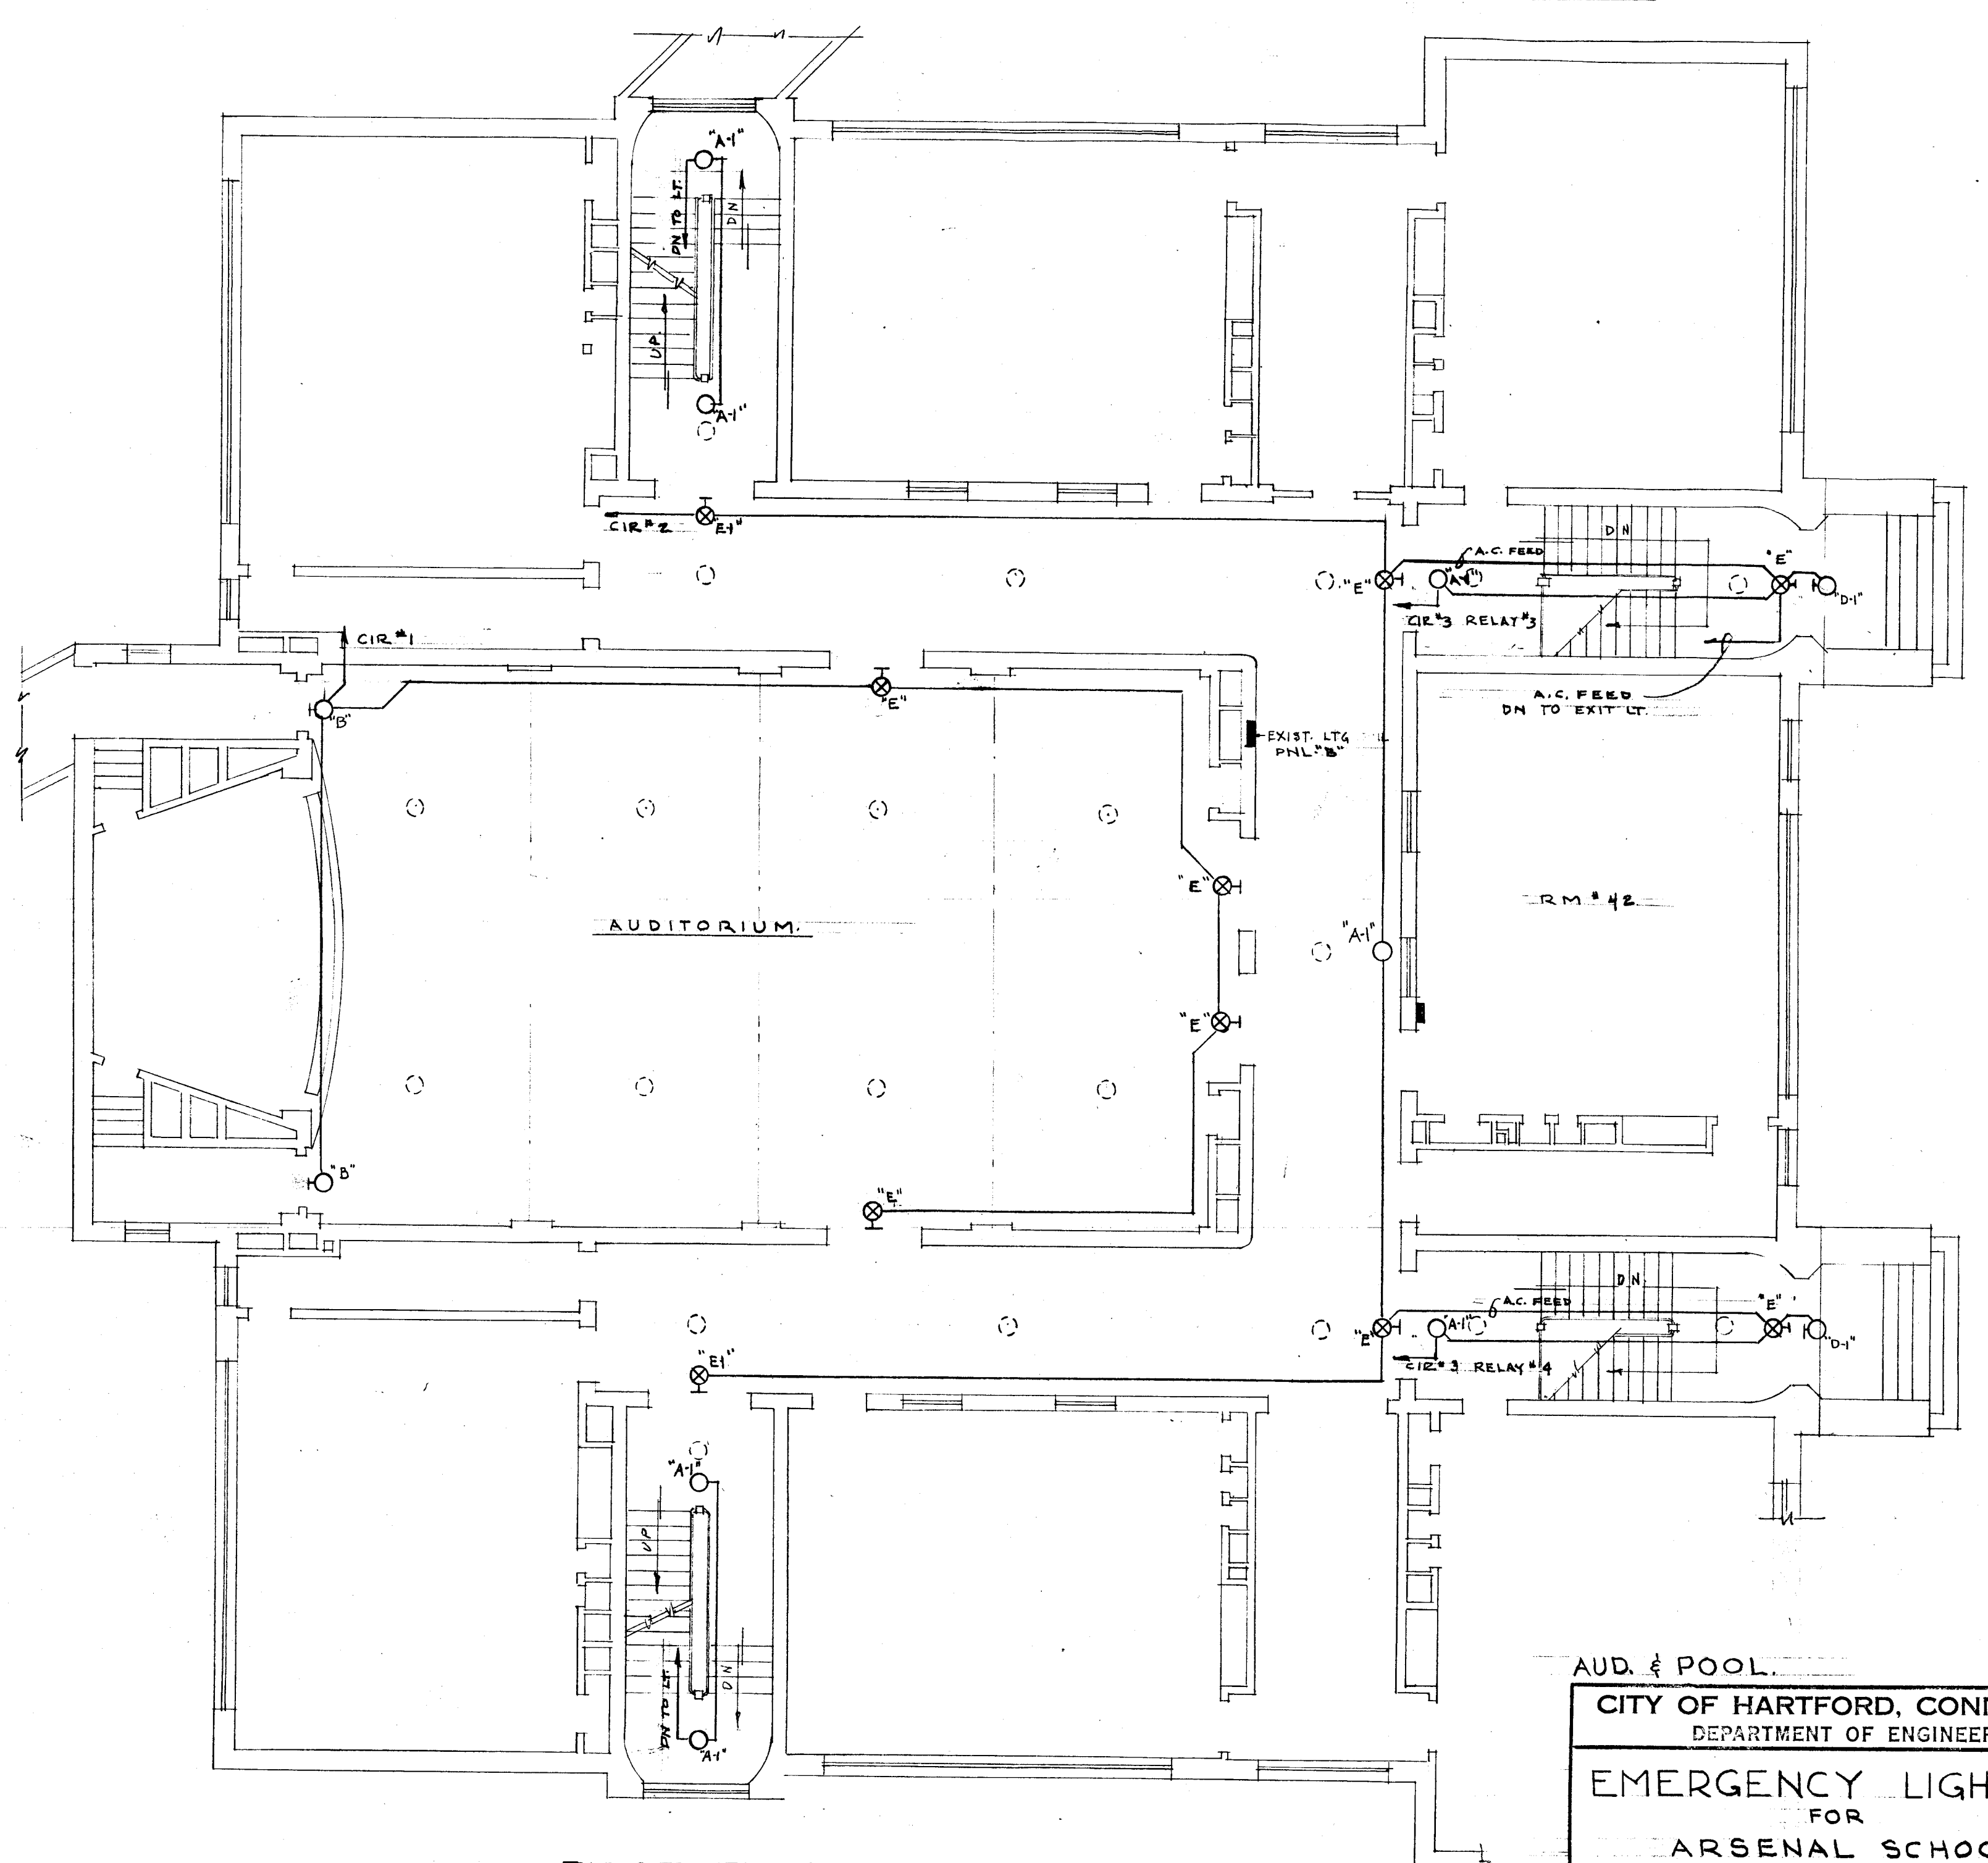

FIRST FLOOR PLAN
SCALE 1/8" = 1'-0"

VERIFY EXISTING
CONDITIONS AND
DIMENSIONS AT
BUILDING

AUD. & POOL		
CITY OF HARTFORD, CONNECTICUT DEPARTMENT OF ENGINEERING		
EMERGENCY LIGHTING FOR ARSENAL SCHOOL 1800 MAIN ST., HARTFORD CONN.		
SUBMITTED DIVISION ARCHITECT	RECOMMENDED CITY ARCHITECT	APPROVED CITY ENGINEER
DESIGN: R.G.B.	DRAWN: R.G.B.	DAYBOOK NO. 09610-A
TRACED:	CHECK:	DATE: MARCH 10, 1960