




WIRING DIAGRAM OF A.C. CONTROL FOR RELAYS IN TRANSFER PANELS
NO SCALE

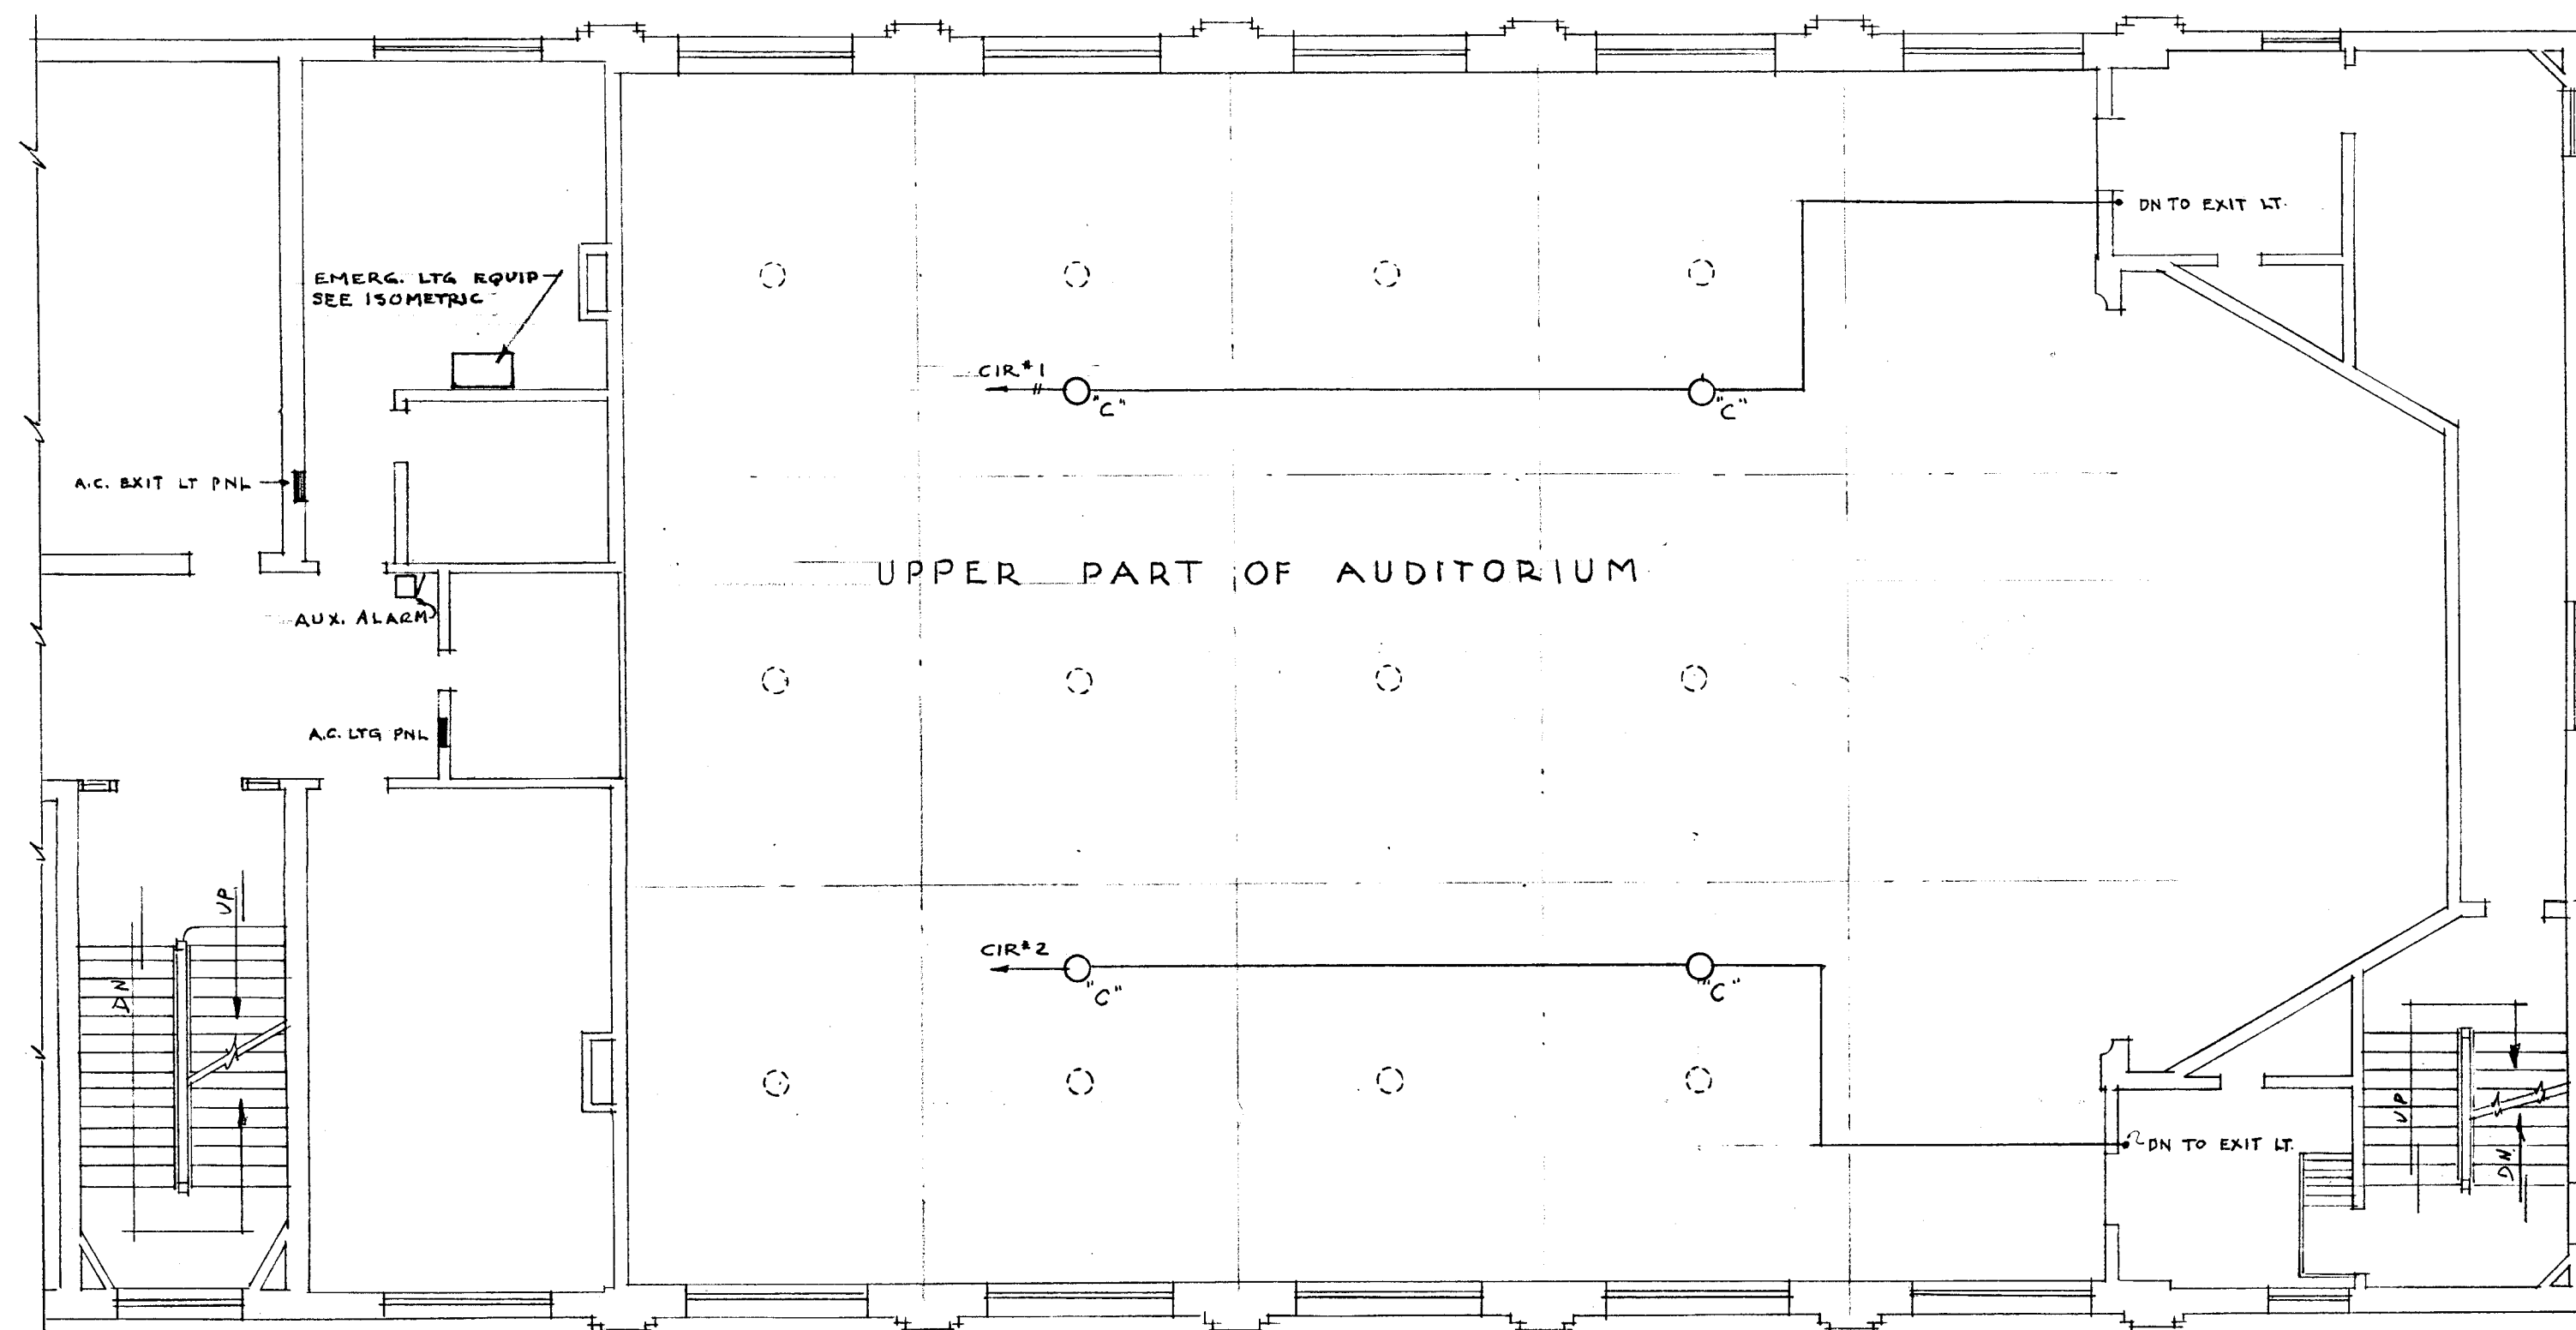


SECOND FLOOR PLAN
SCALE 1/8" = 1'-0"

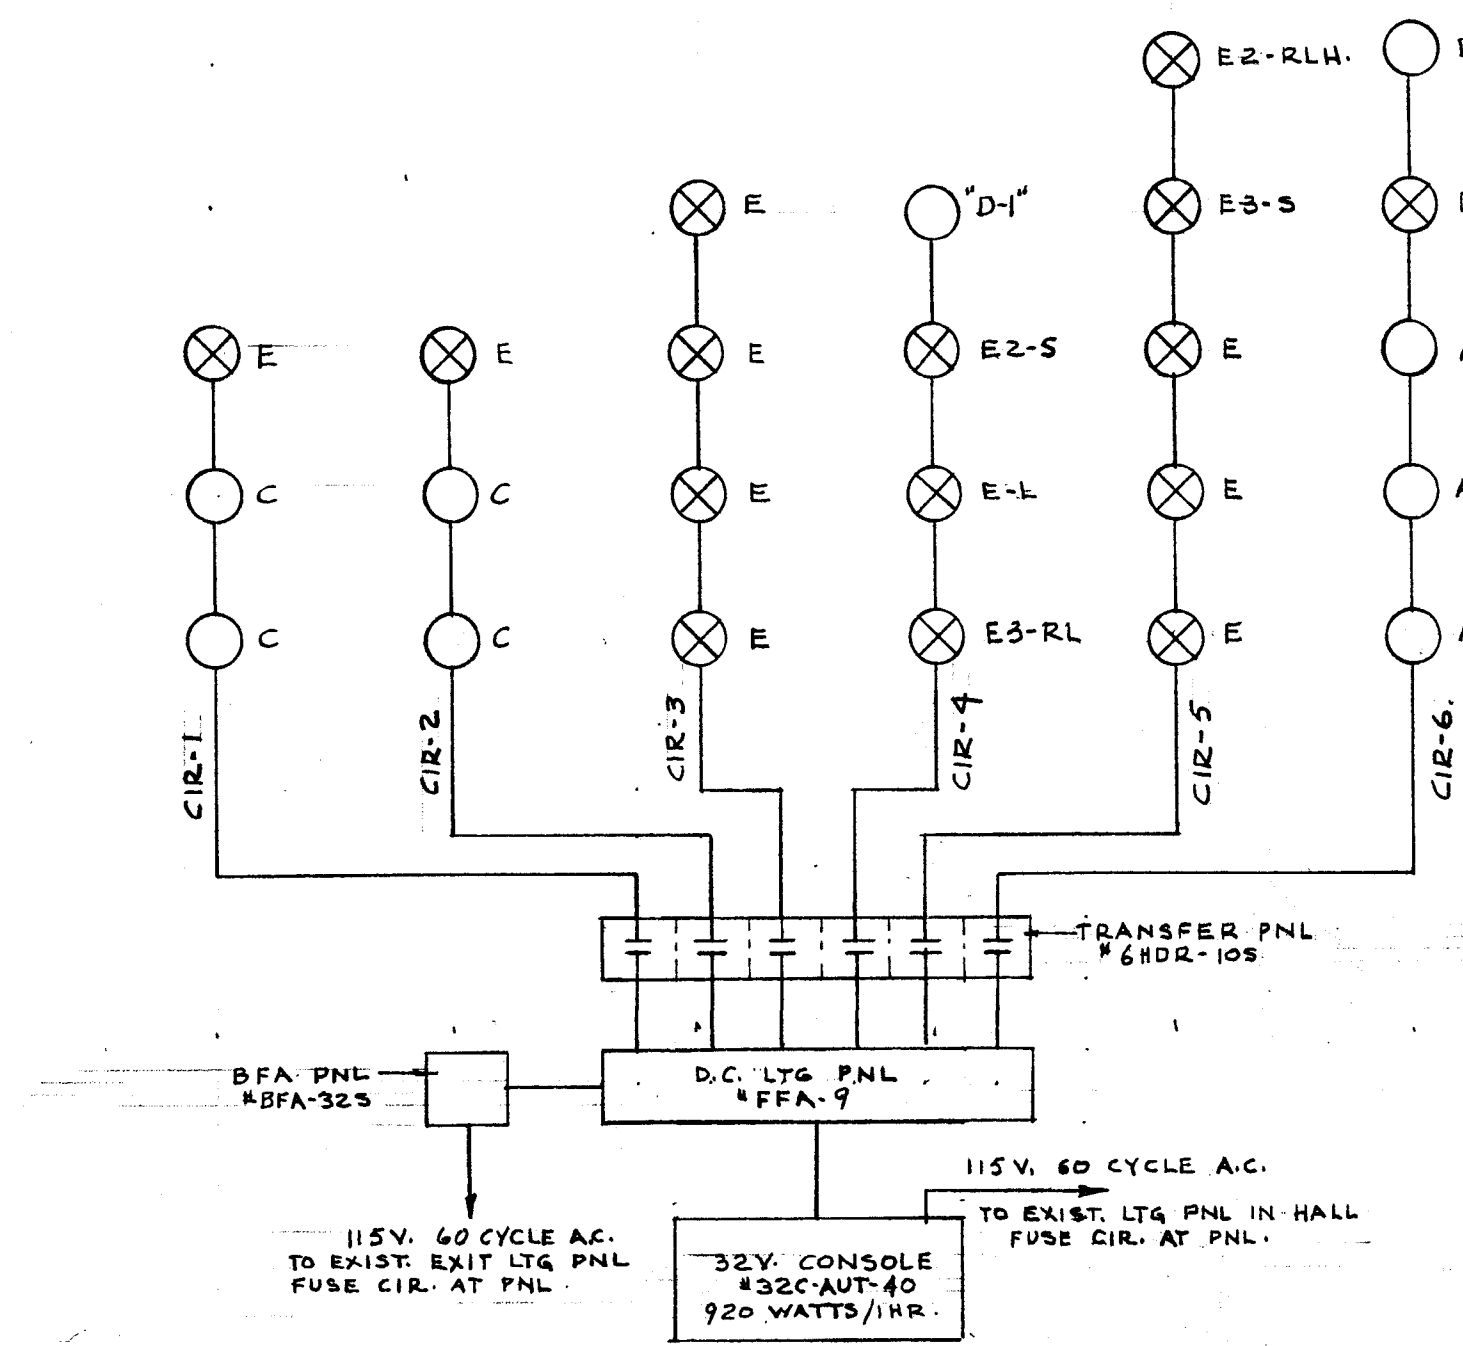


EMERGENCY LIGHTING SCHEMATIC
NO SCALE

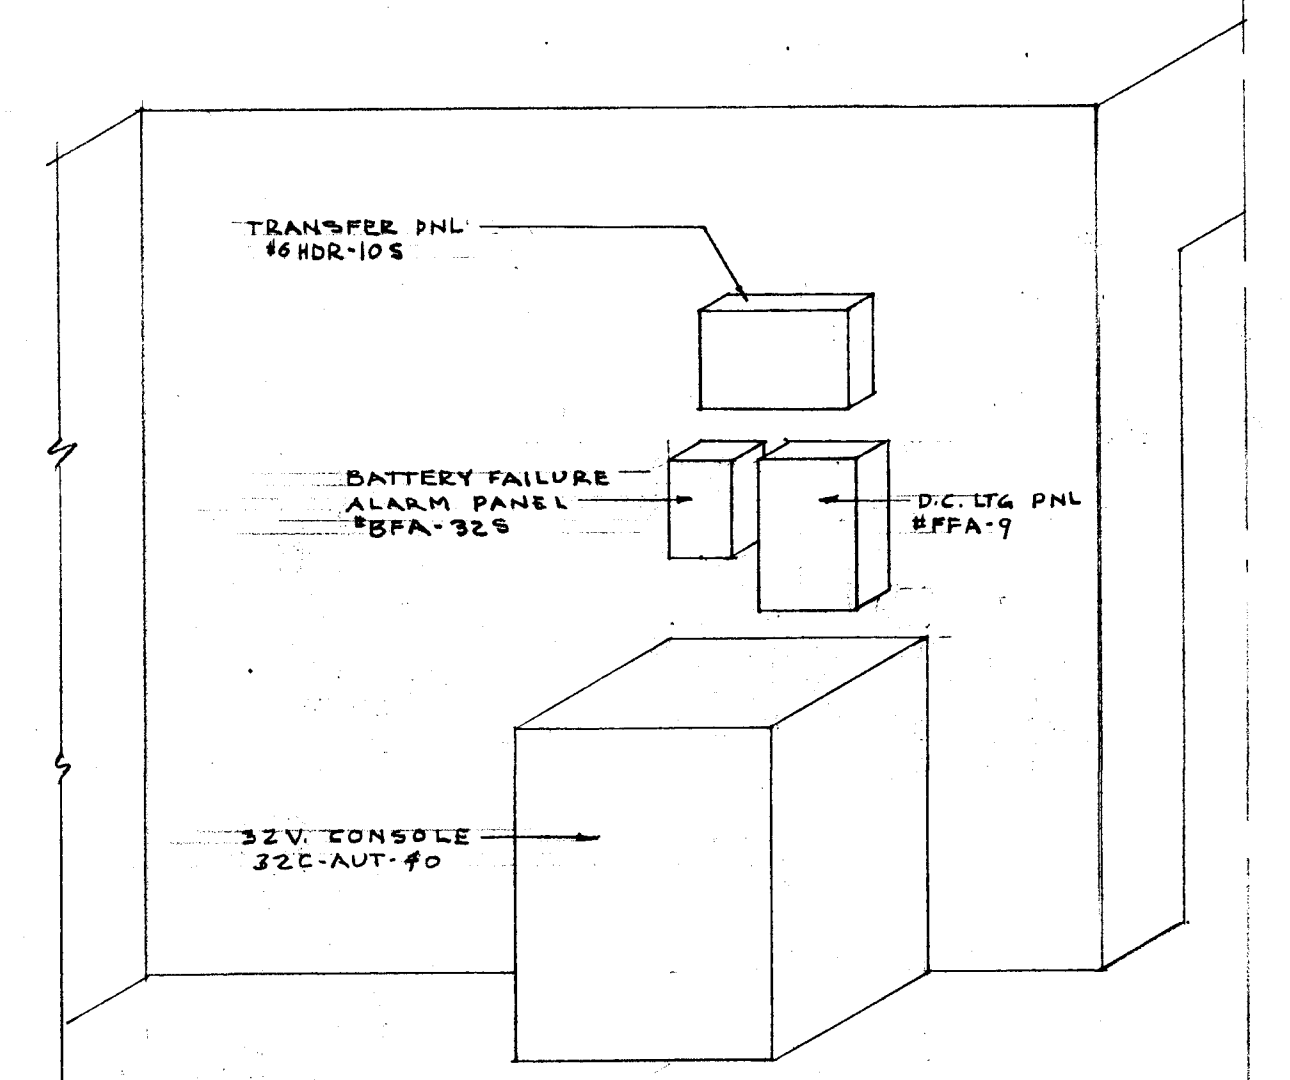


ISOMETRIC OF EMERGENCY EQUIPMENT
NO SCALE

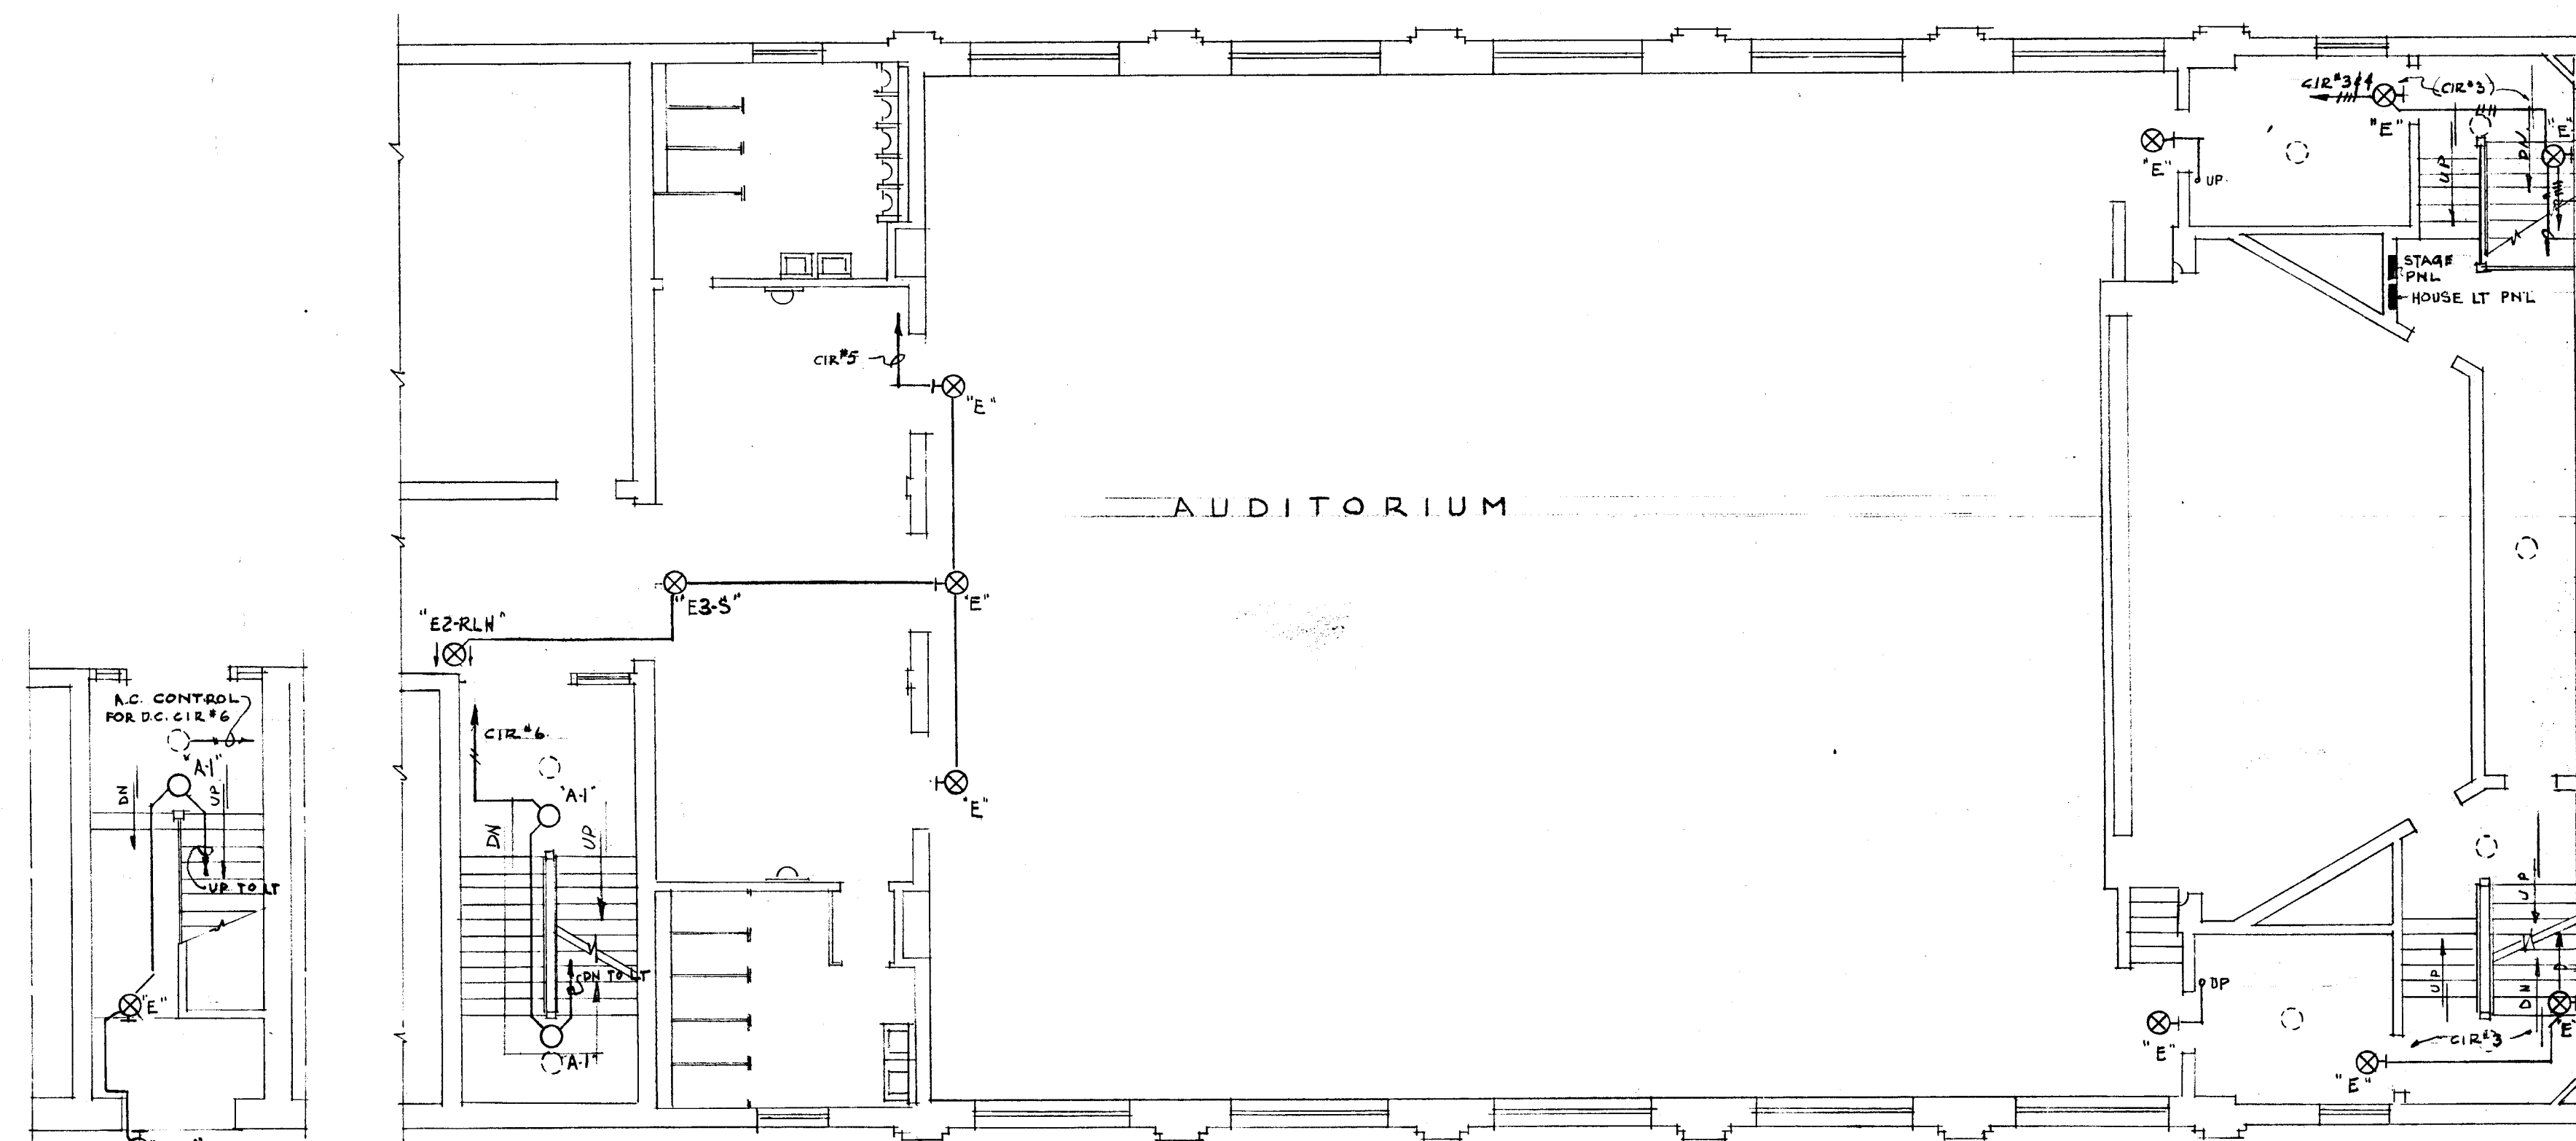

FIRST FLOOR PLAN
SCALE 1/8" = 1'-0"

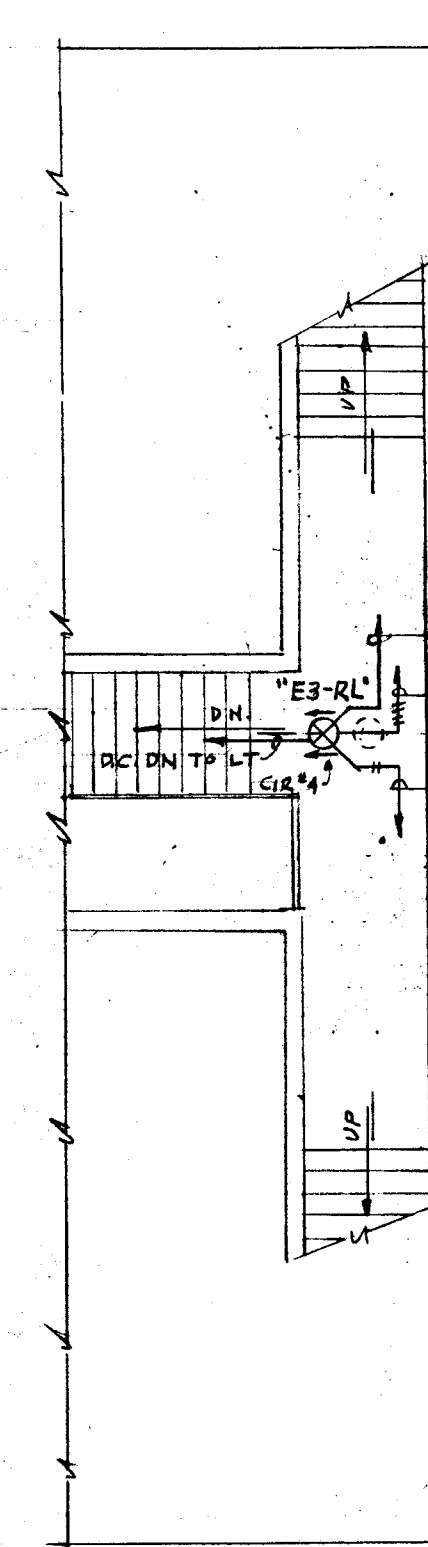

PLAN OF LANDING
BTWN 1ST FL & GROUND FL.

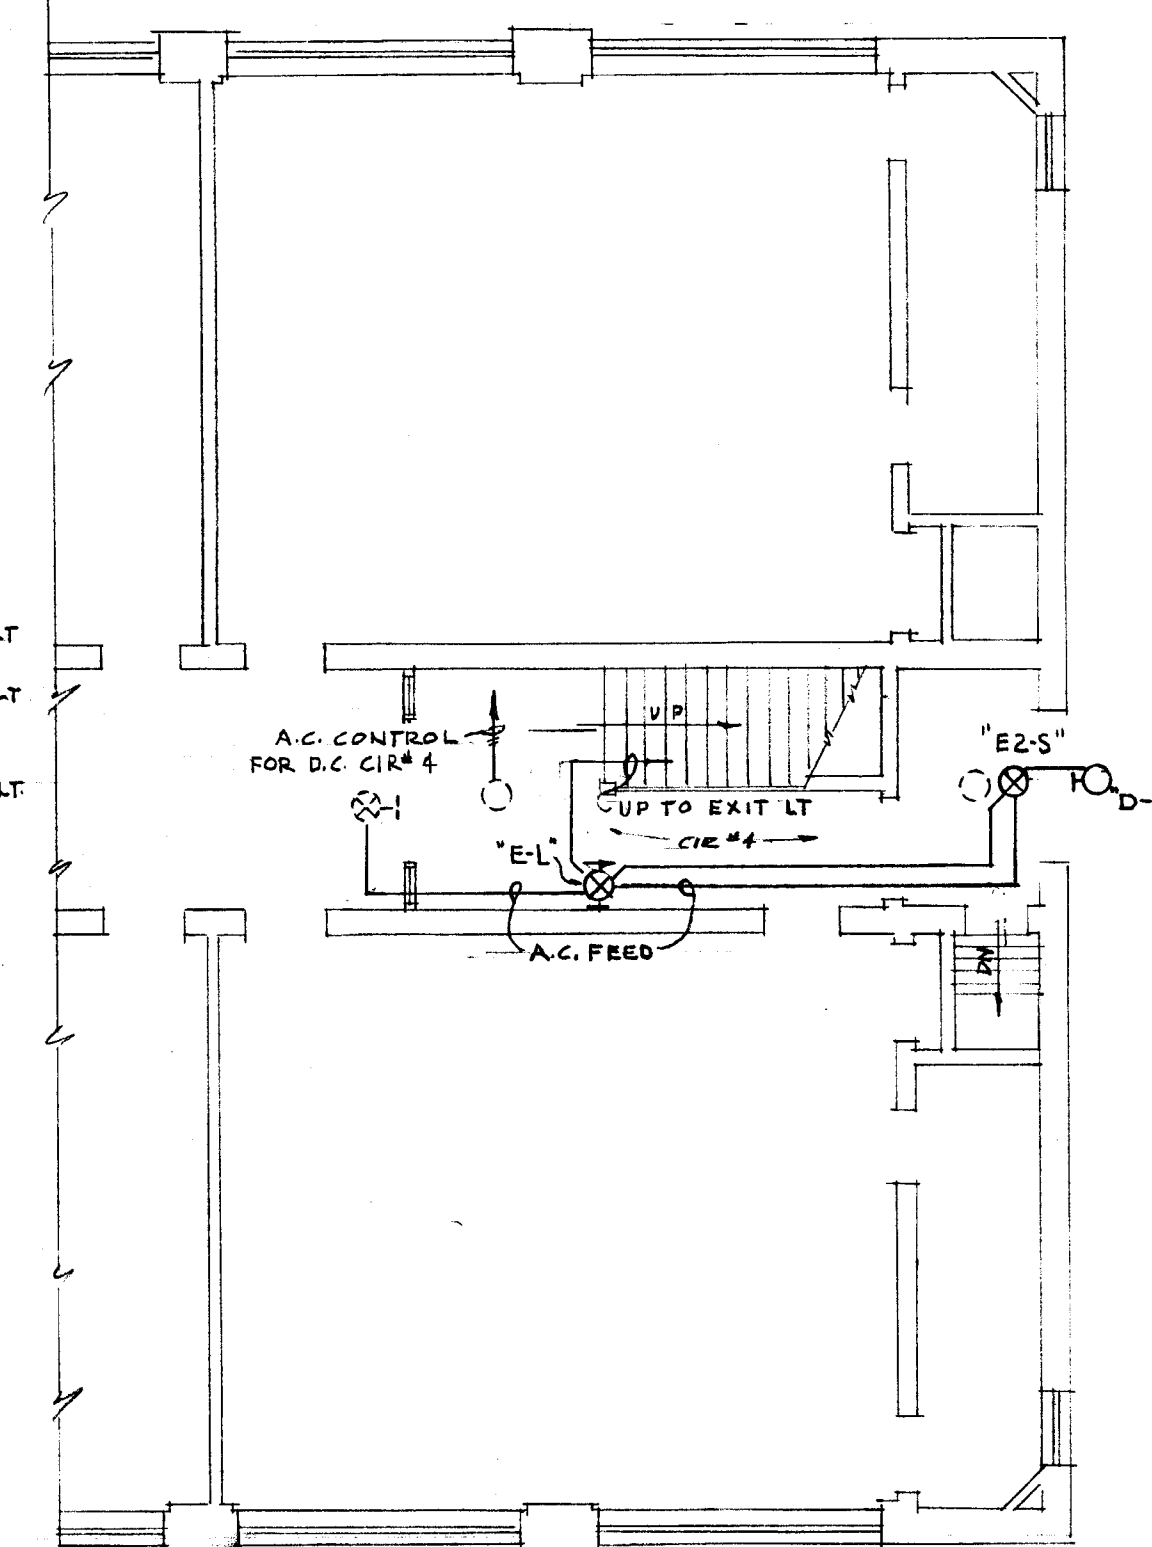

GROUND FLOOR PLAN

GROUND FL. PLAN

VERIFY EXISTING
CONDITIONS AND
DIMENSIONS AT
BUILDING

AUDITORIUM		
CITY OF HARTFORD, CONNECTICUT		
DEPARTMENT OF ENGINEERING		
EMERGENCY LIGHTING.		
FOR		
HENRY BARNARD SCHOOL		
1304 MAIN ST., HARTFORD CONN		
SUBMITTED	RECOMMENDED	APPROVED
DESIGN R.G.B.	DRAWN E.G.B.	DATE MARCH 10, 1960
TRACED	CHECK	