




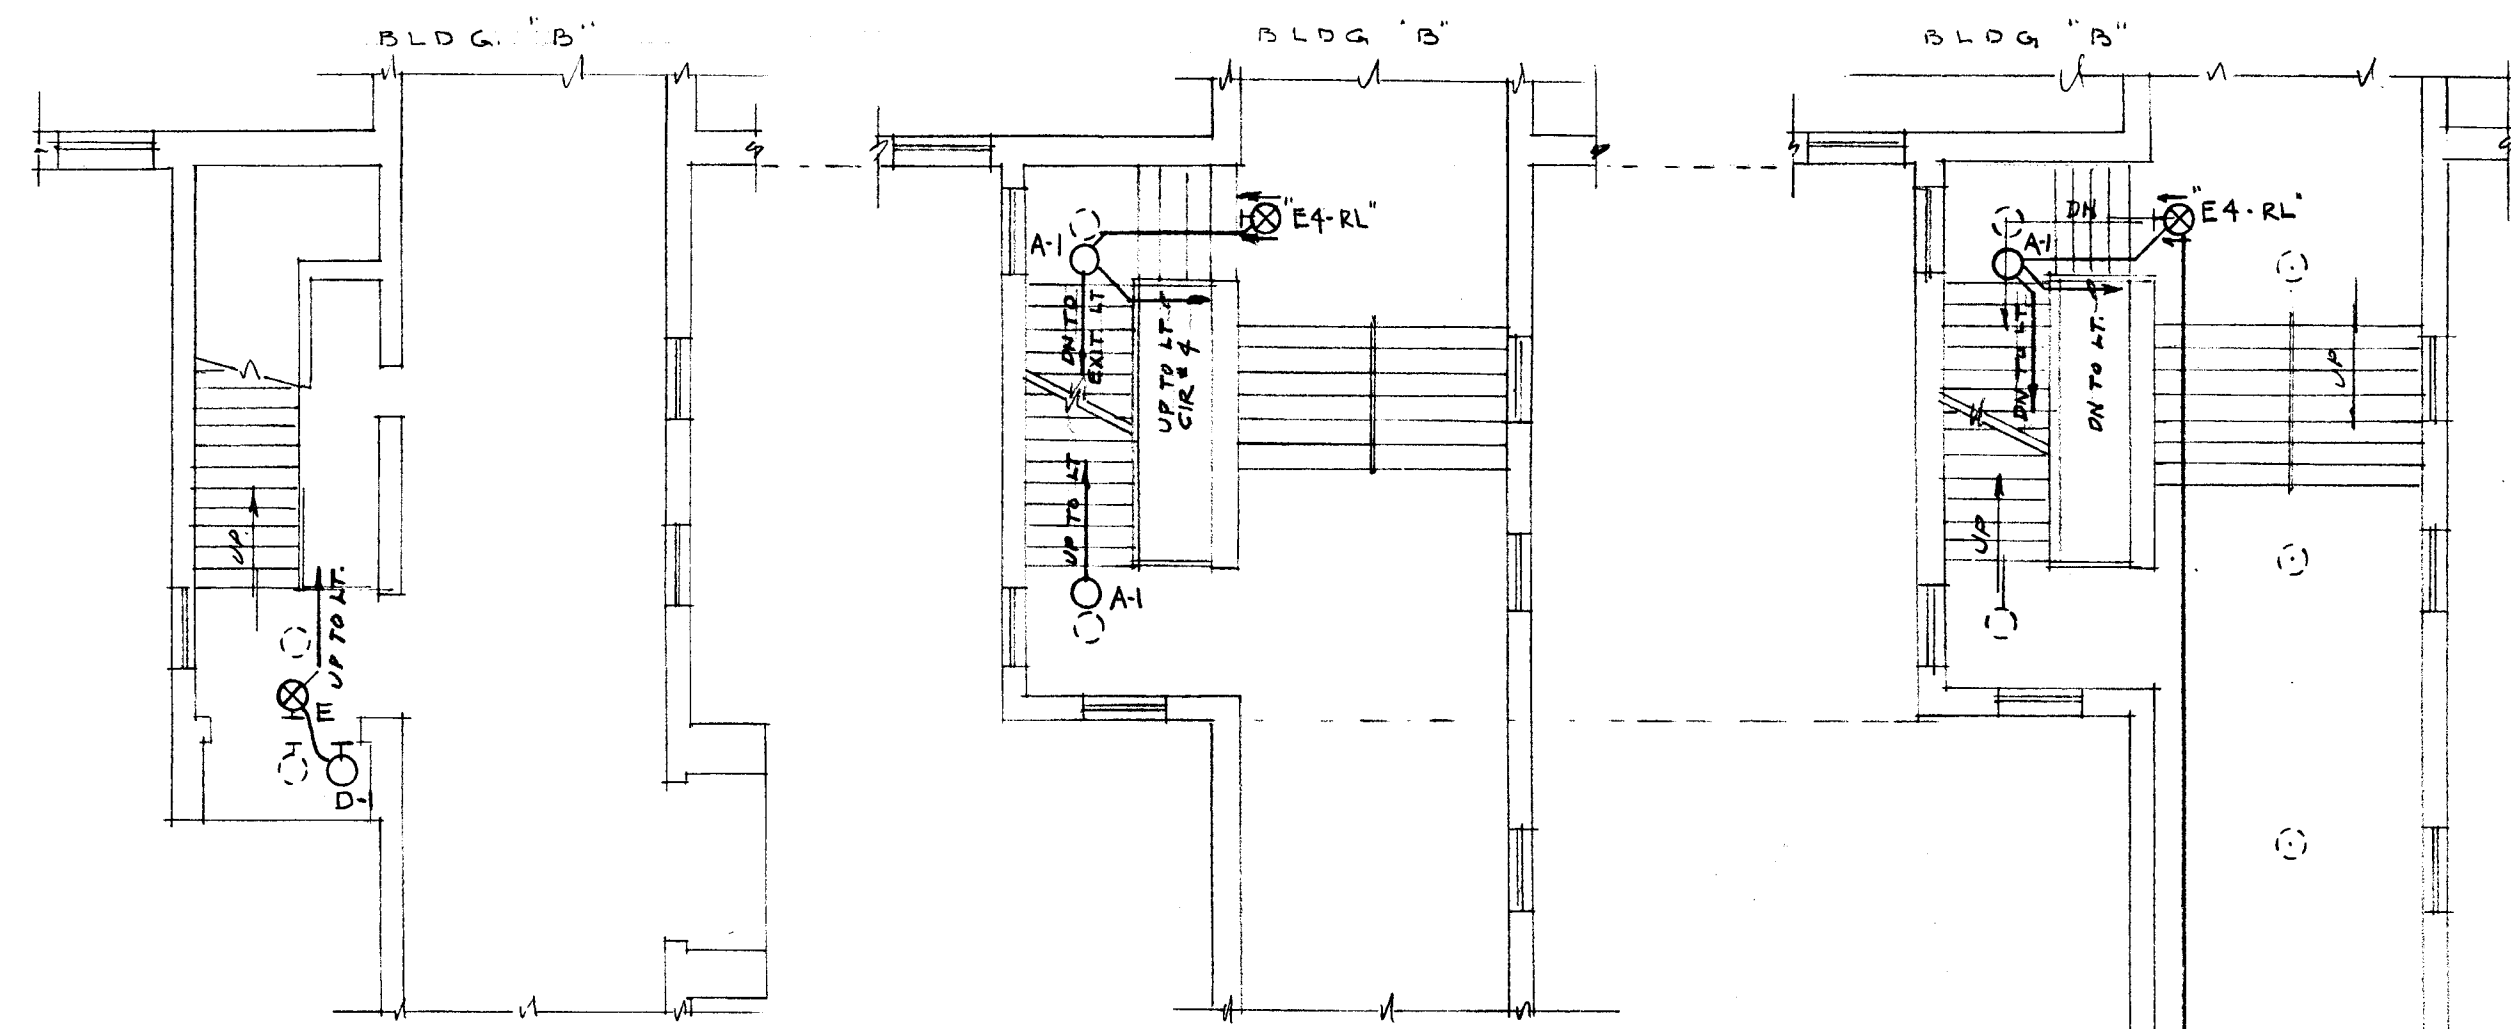


BSM'T STAIRWELL PLAN 1/8" = 1'-0"
1ST FL STAIRWELL PLAN 1/8" = 1'-0"

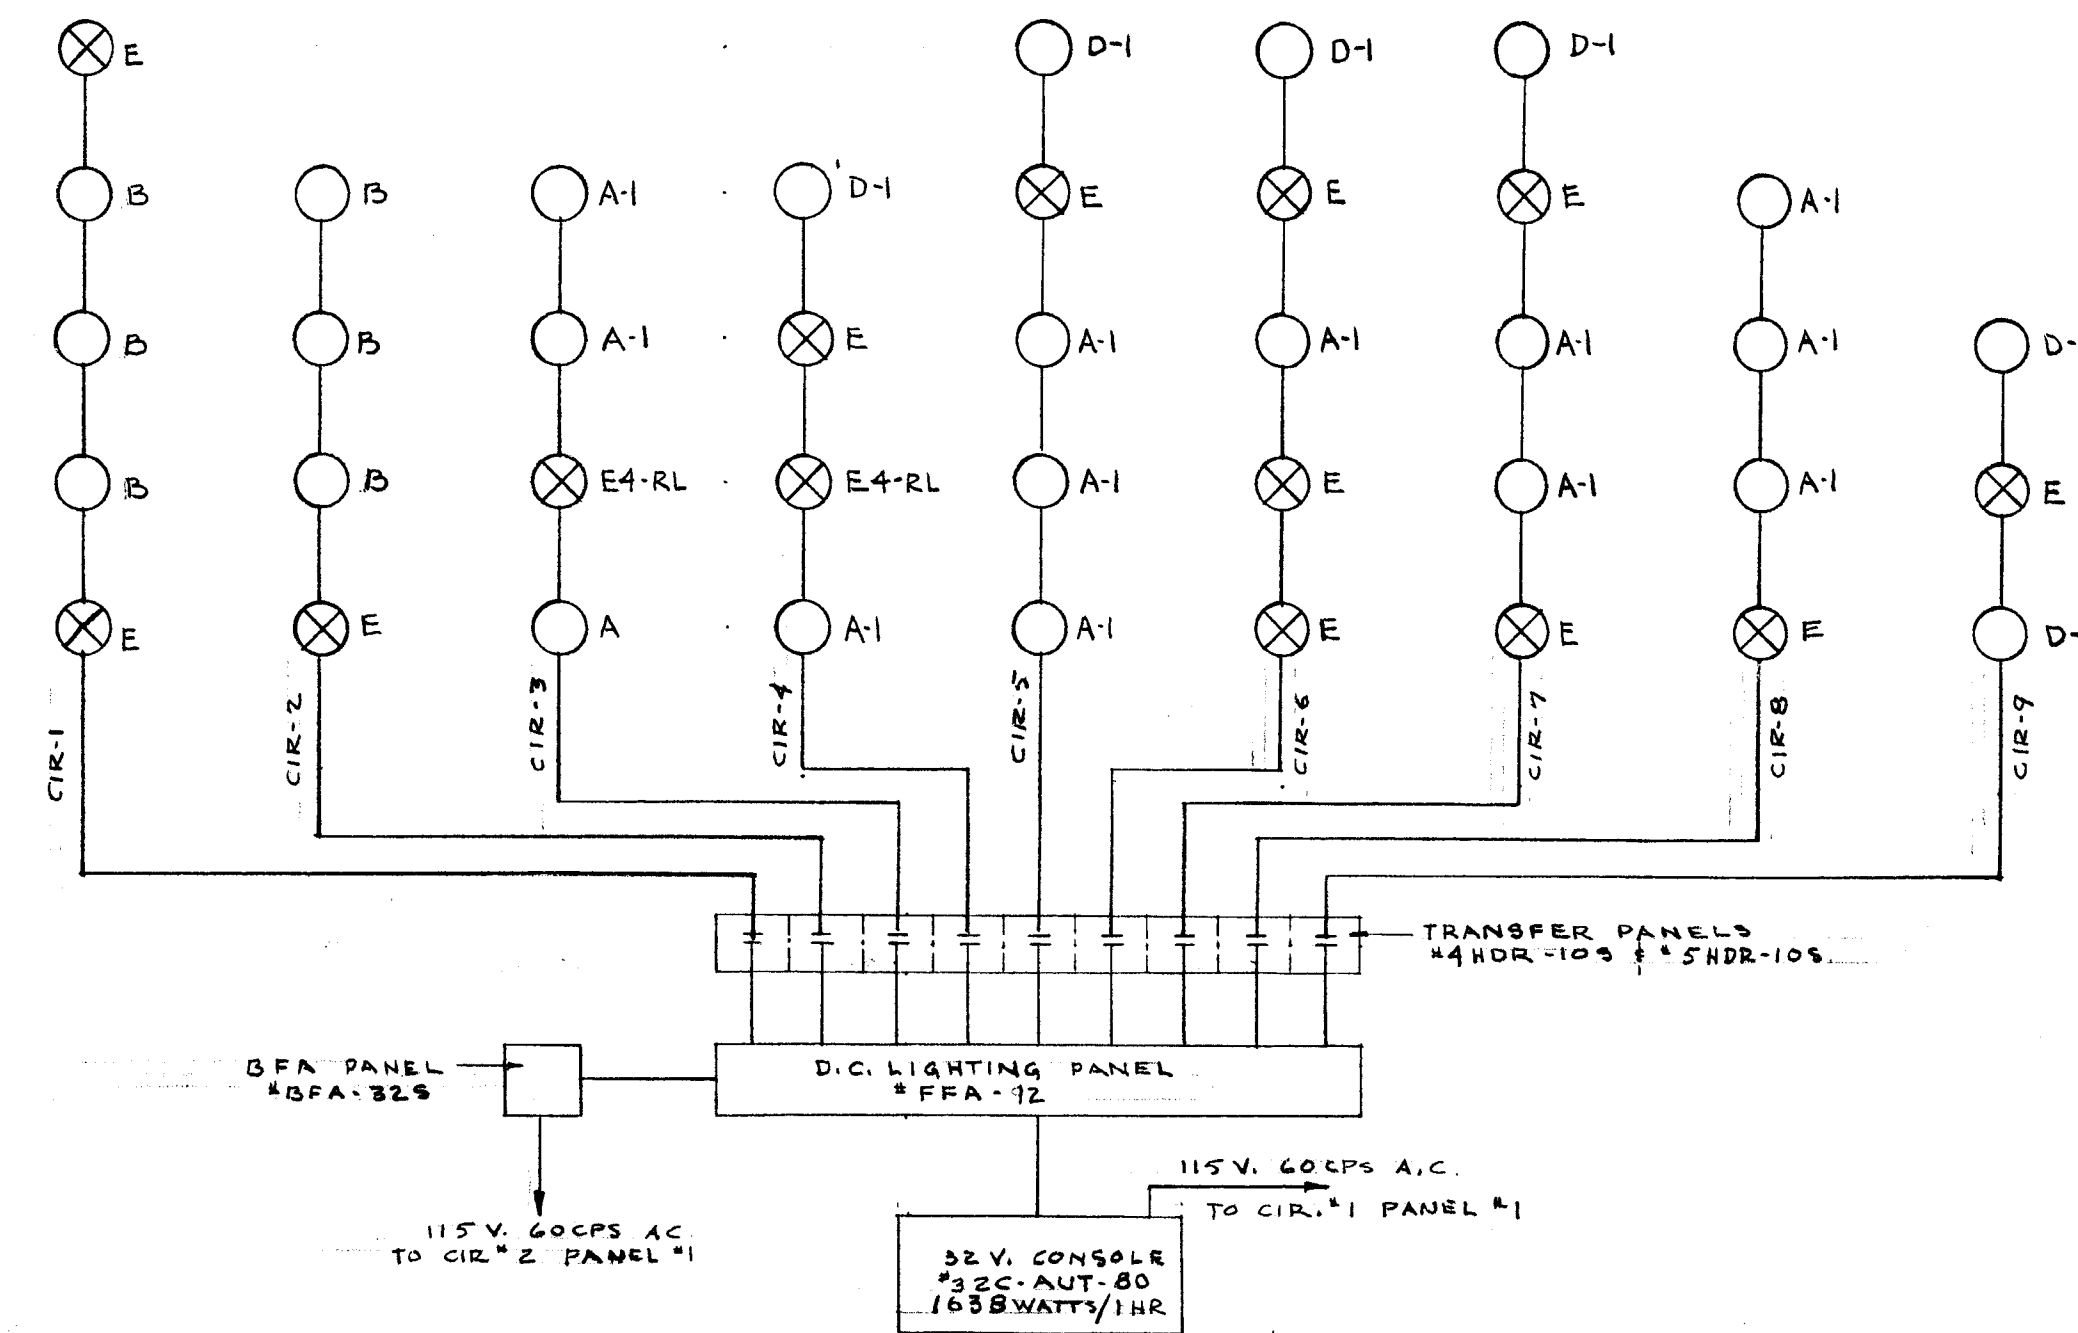


EMERGENCY LIGHTING SCHEMATIC
NO SCALE

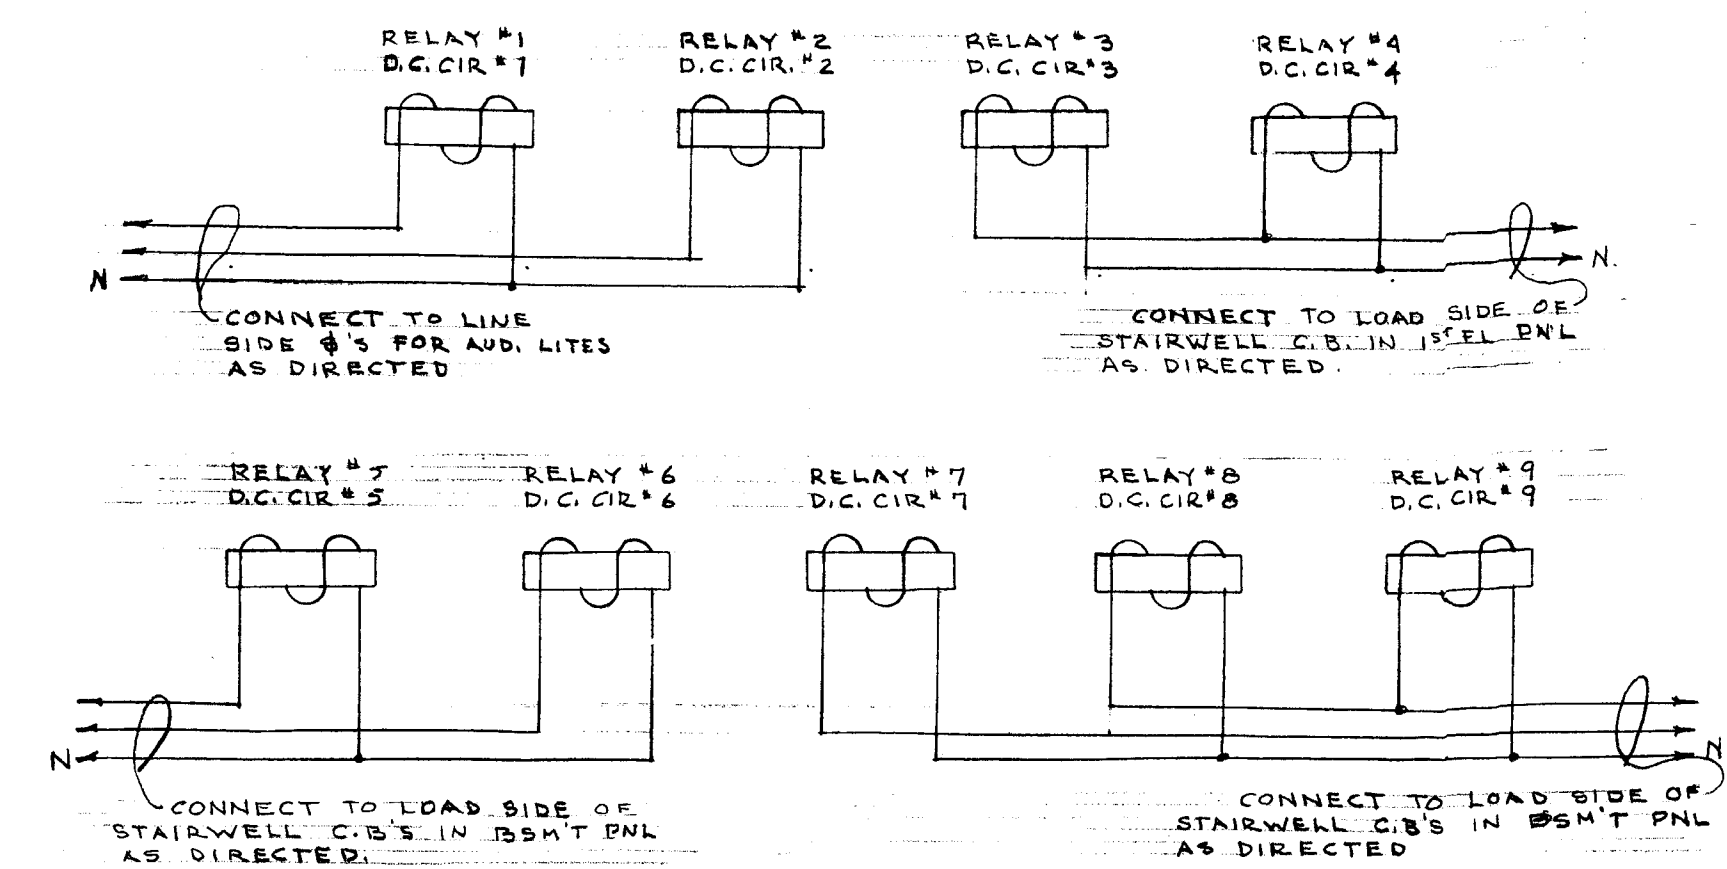


WIRING DIAGRAM OF A.C. CONTROL
FOR RELAYS IN TRANSFER PANELS
NO SCALE

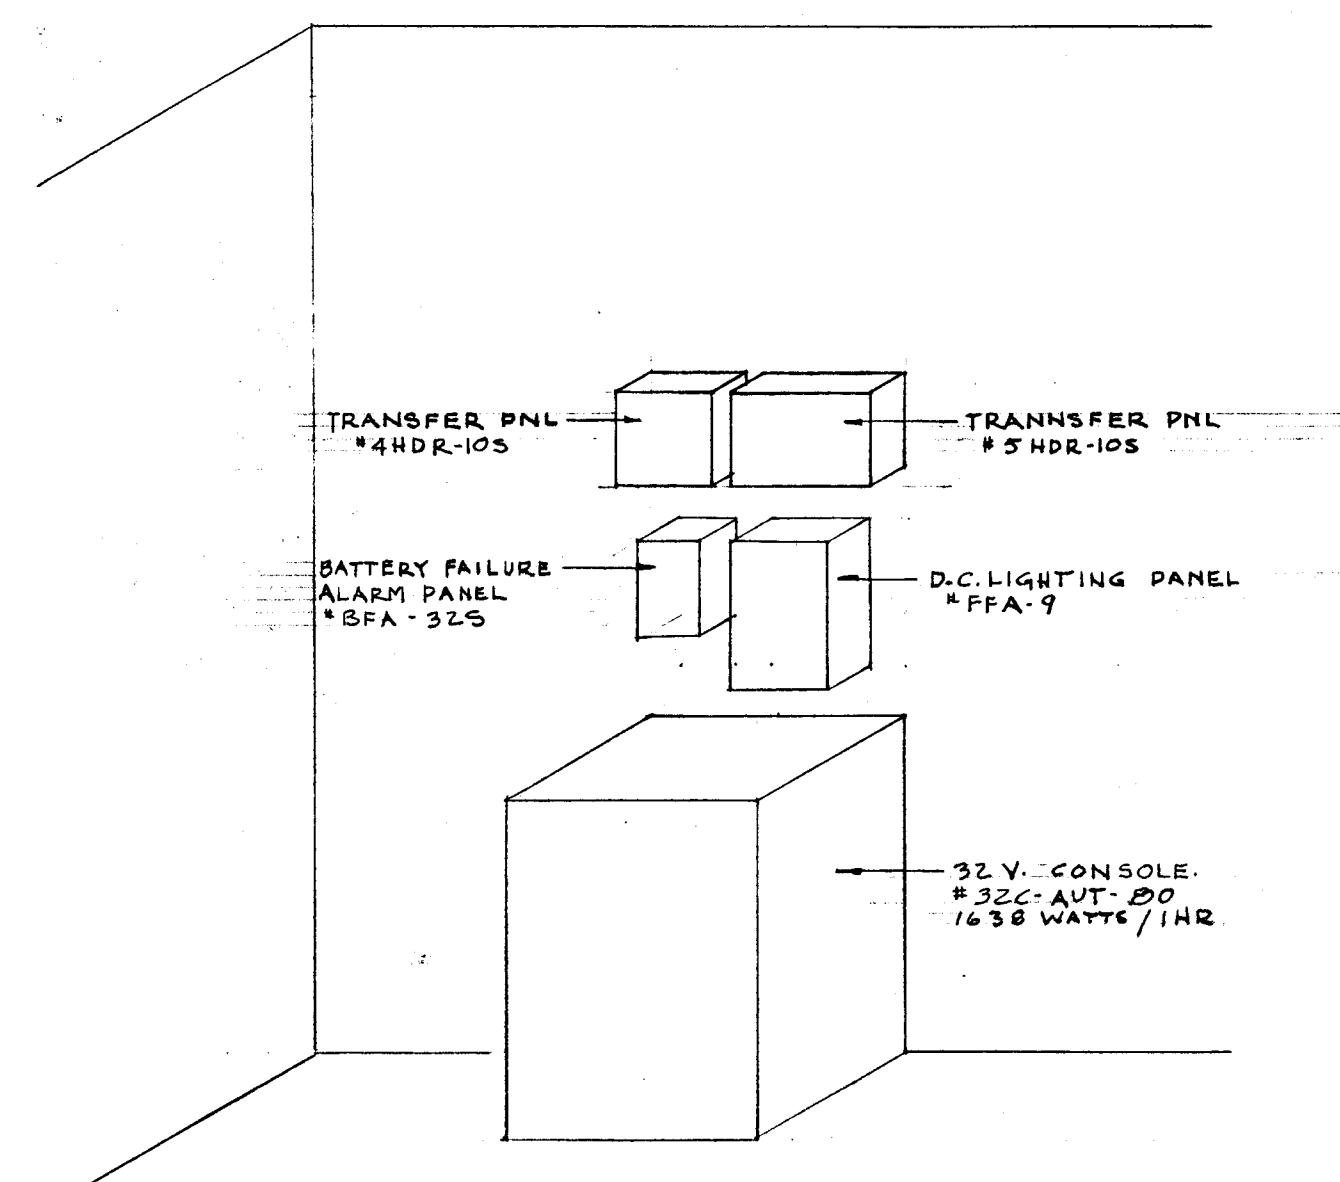

ISOMETRIC OF EMERGENCY EQUIPMENT
NO SCALE

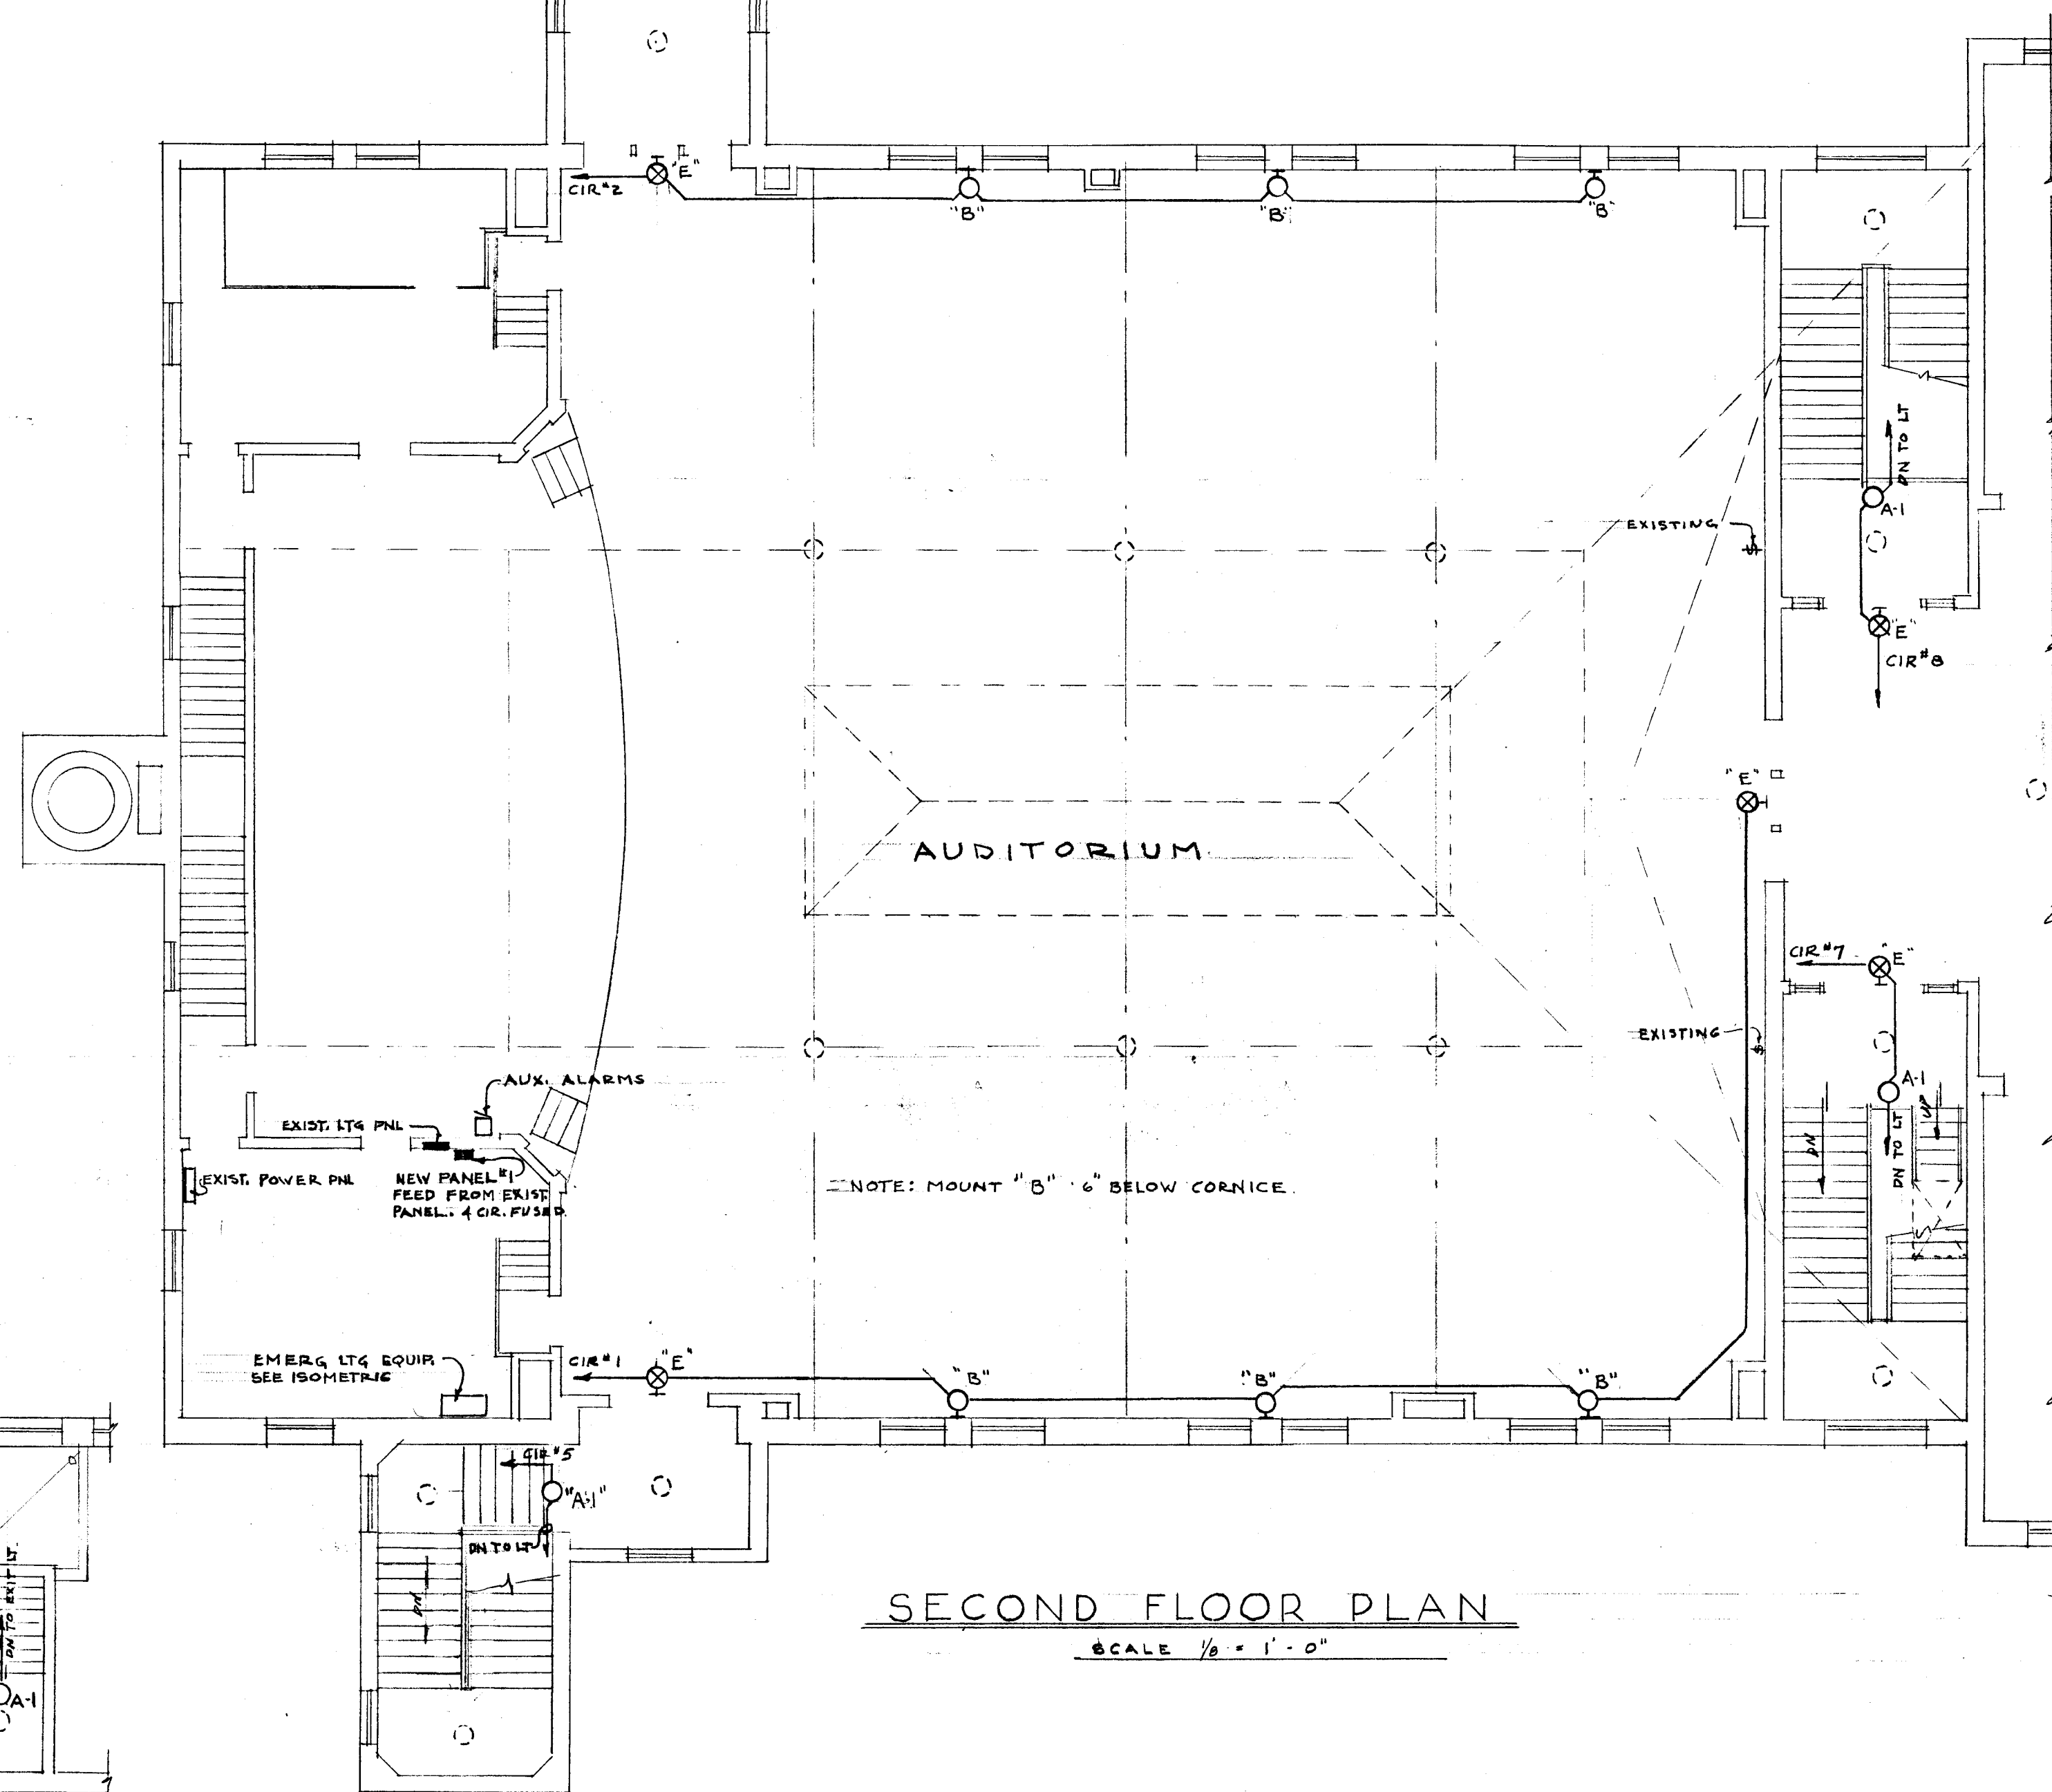


SECOND FLOOR PLAN
SCALE 1/8" = 1'-0"

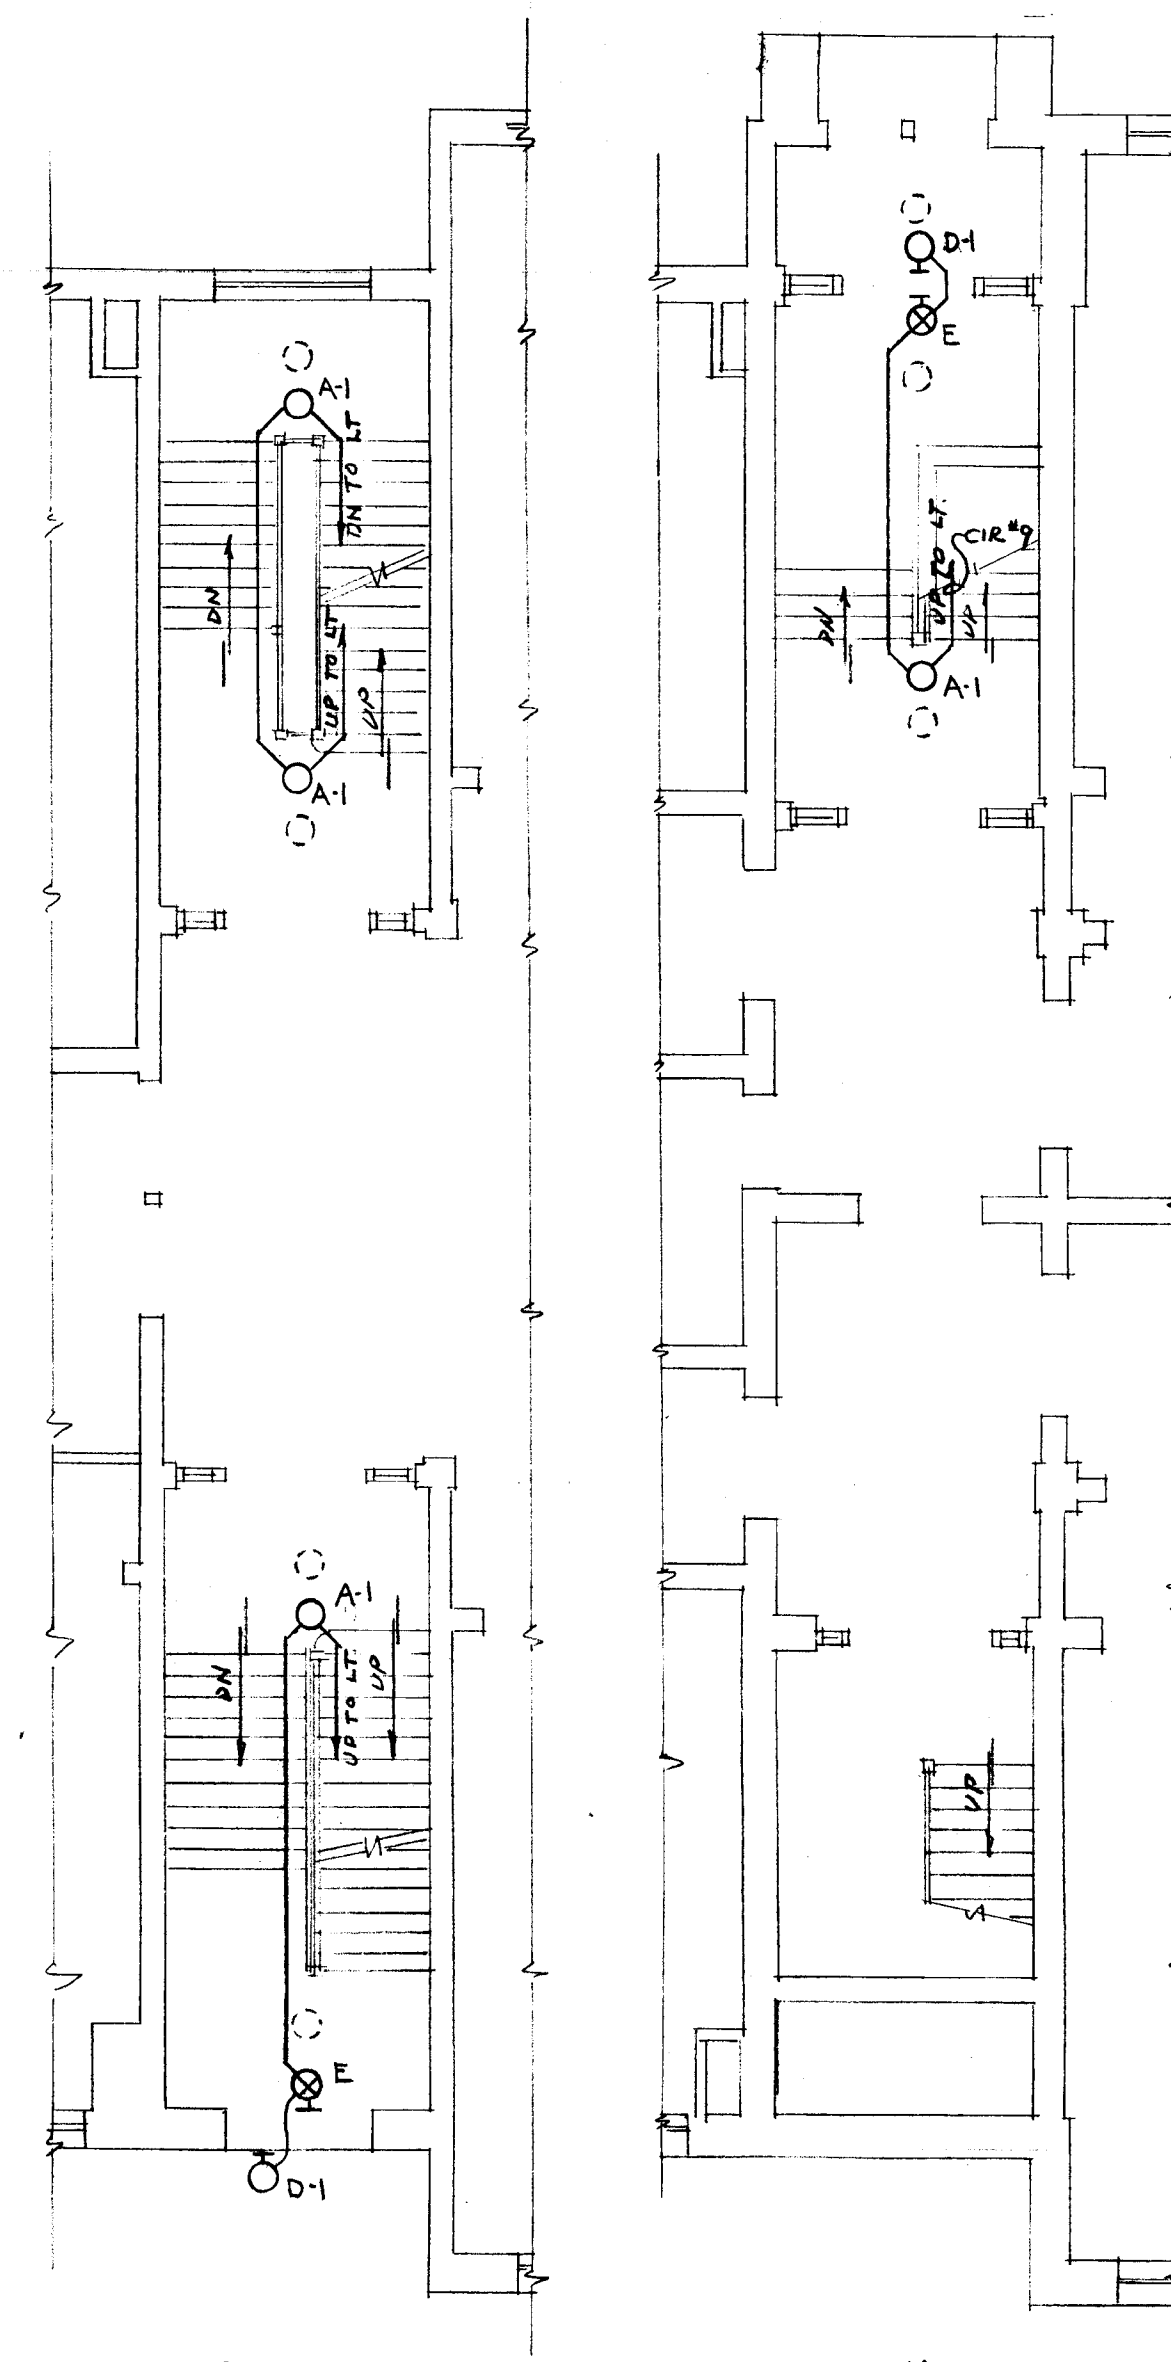

1ST FL STAIRWELL PLAN 1/8" = 1'-0"

BSM'T STAIRWELL PLAN 1/8" = 1'-0"

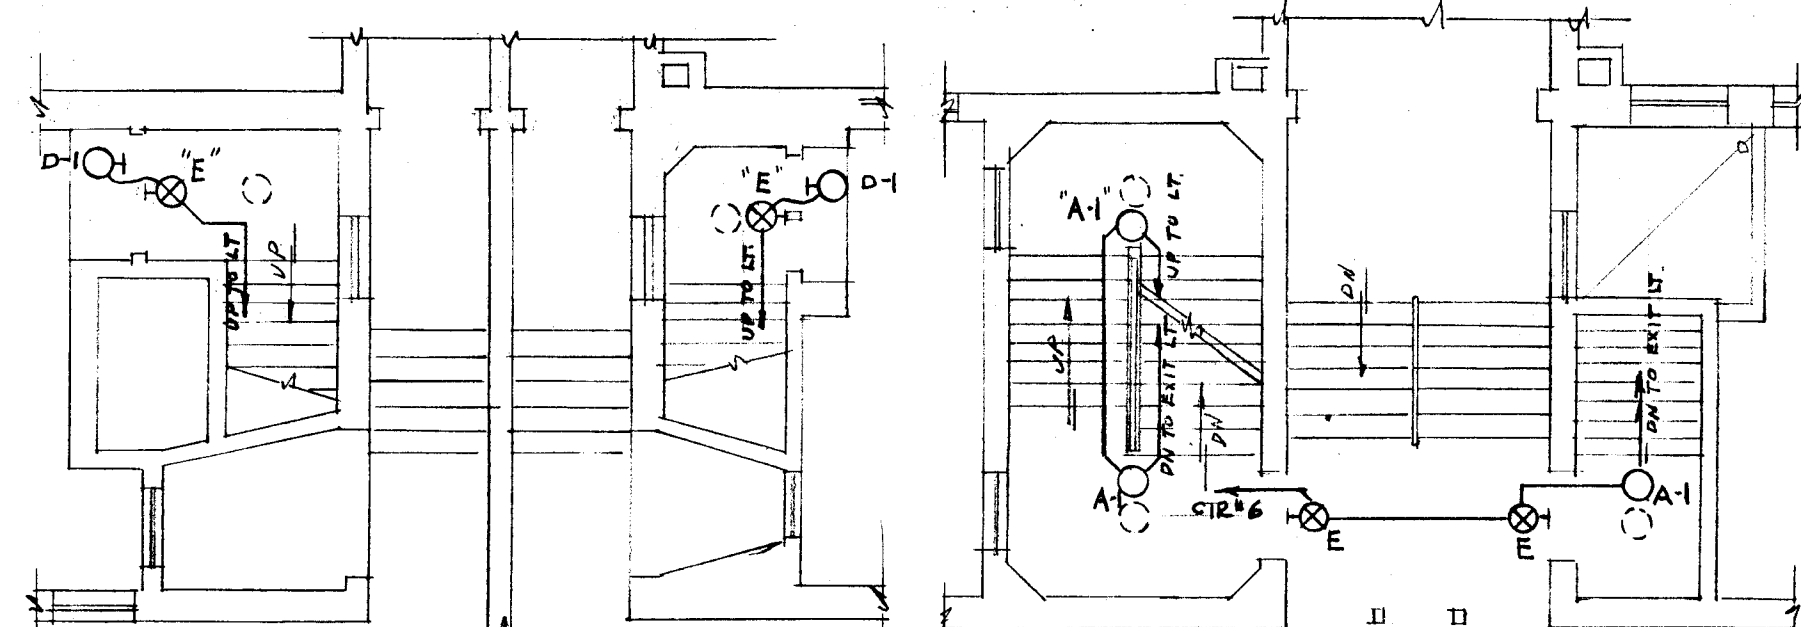

BSM'T STAIRWELL PLAN 1/8" = 1'-0"
1ST FL STAIRWELL PLAN 1/8" = 1'-0"

AUDITORIUM (BLDG-C)
CITY OF HARTFORD, CONNECTICUT
DEPARTMENT OF ENGINEERING

EMERGENCY LIGHTING
FOR
FRANK A. BRACKETT SCHOOL.
54 WESTLAND ST., HARTFORD CONN.

SUBMITTED Daniel G. Gorman DIVISION ARCHITECT	RECOMMENDED Daniel G. Gorman CITY ARCHITECT	APPROVED [Signature] CITY ENGINEER
DESIGN R.G.B.	DRAWN R.G.B.	DAYBOOK NO. 09610-F
TRACED	CHECK	DATE MARCH 10, 1960

VERIFY EXISTING
CONDITIONS AND
DIMENSIONS AT
BUILDING