




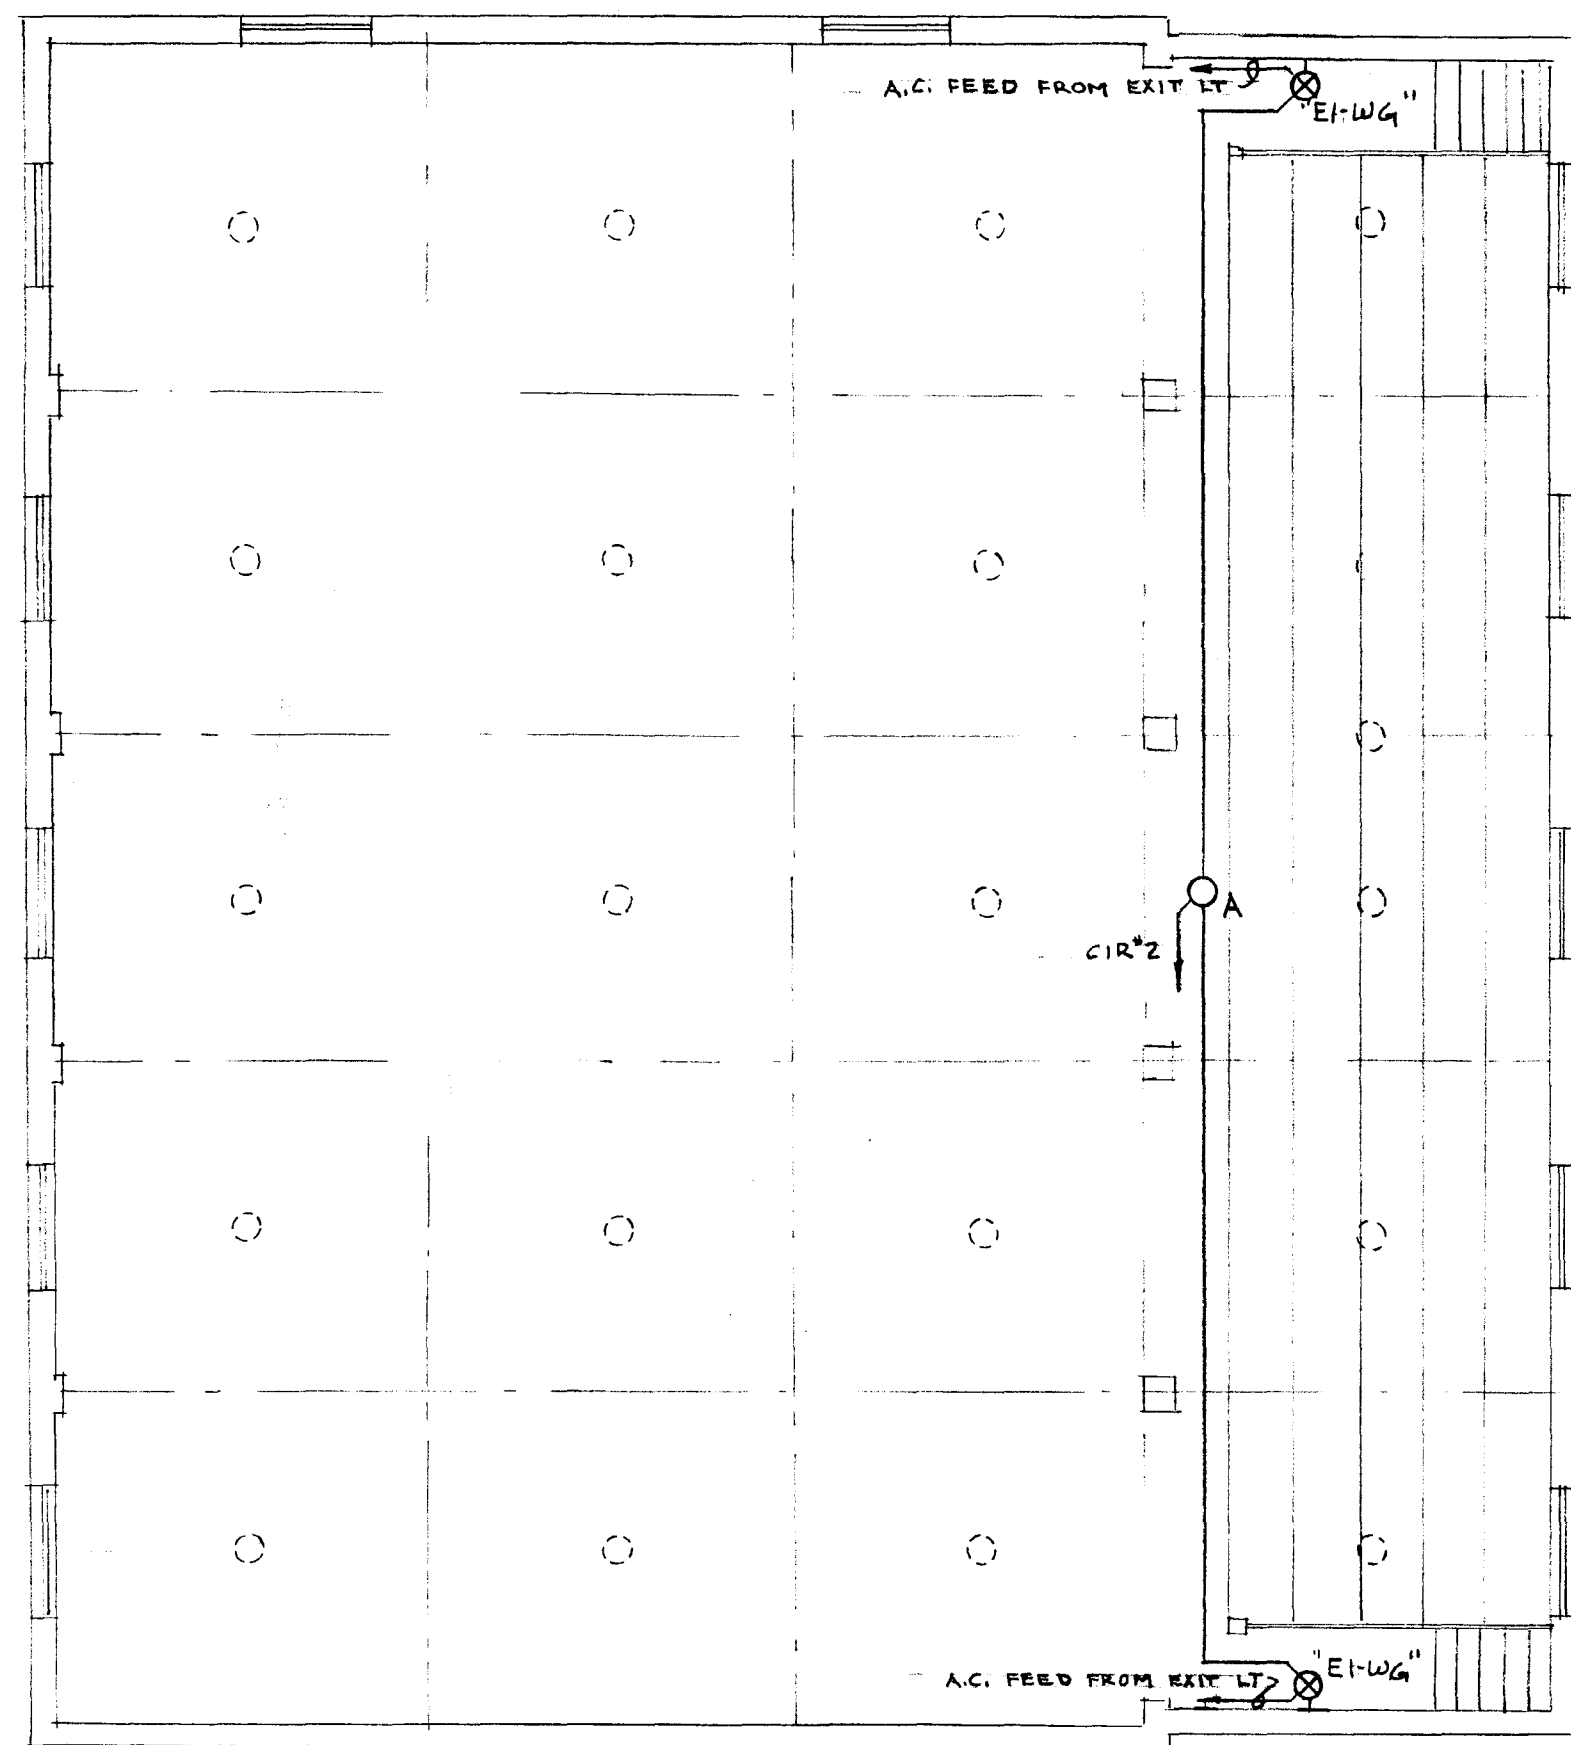


GALLERY PLAN
SCALE 1/8" = 1'-0"

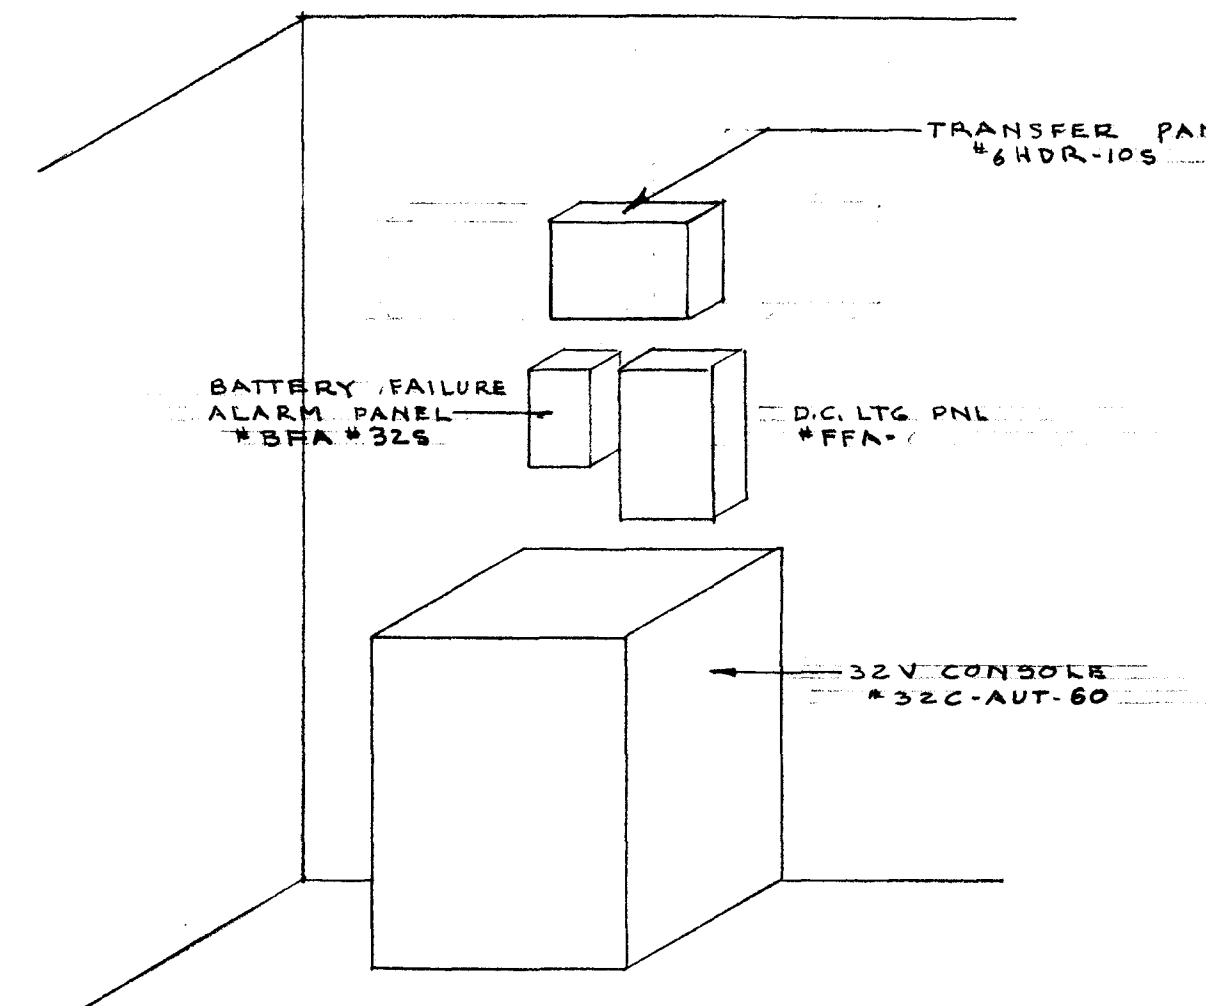


ISOMETRIC OF EMERGENCY EQUIPMENT
NO SCALE

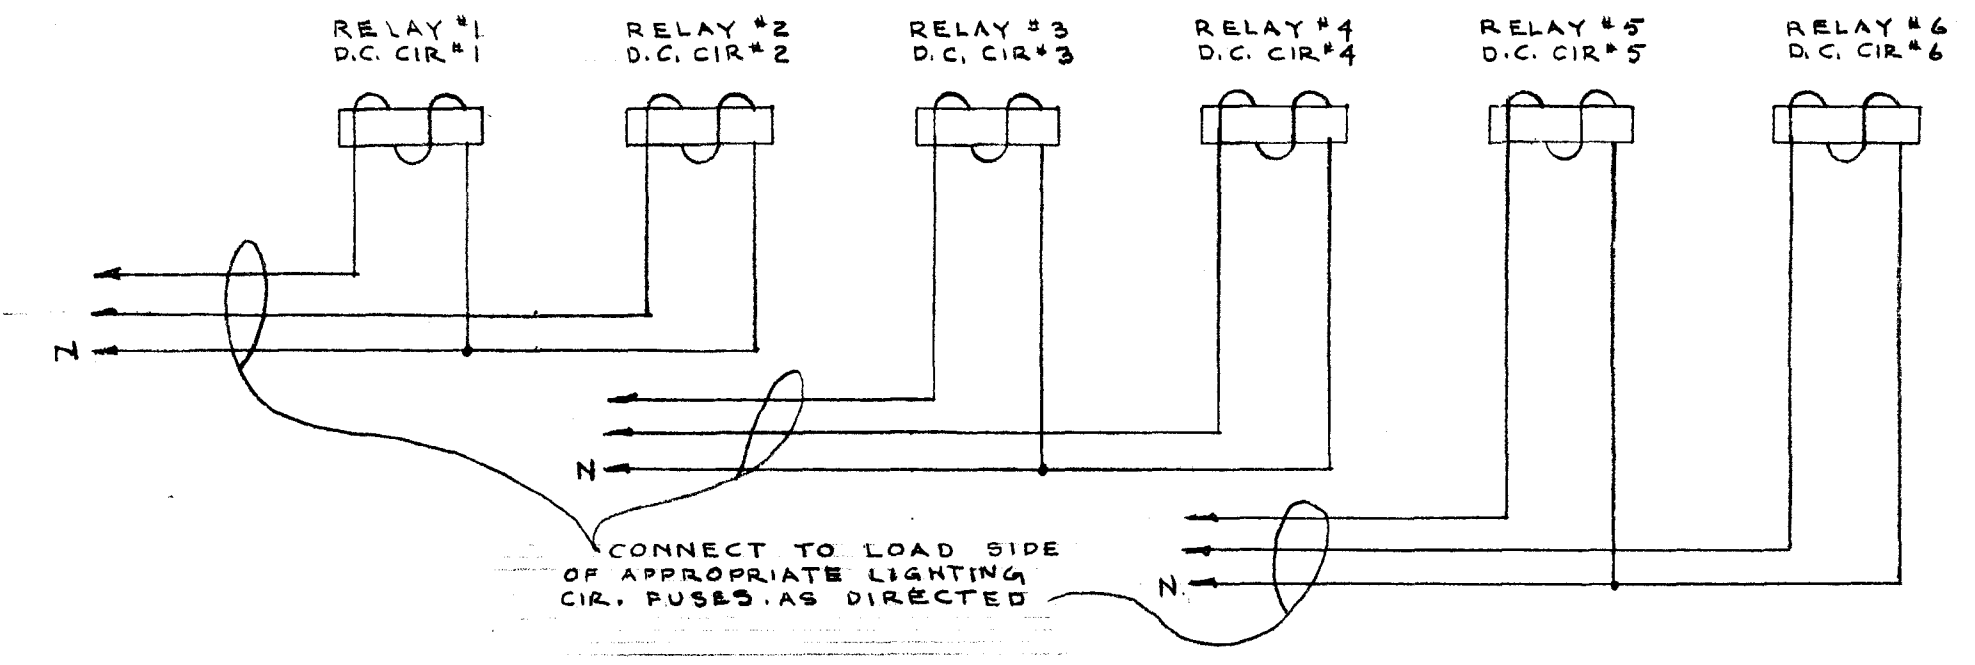


WIRING DIAGRAM OF A.C. CONTROL FOR RELAYS IN TRANSFER PANELS
NO SCALE

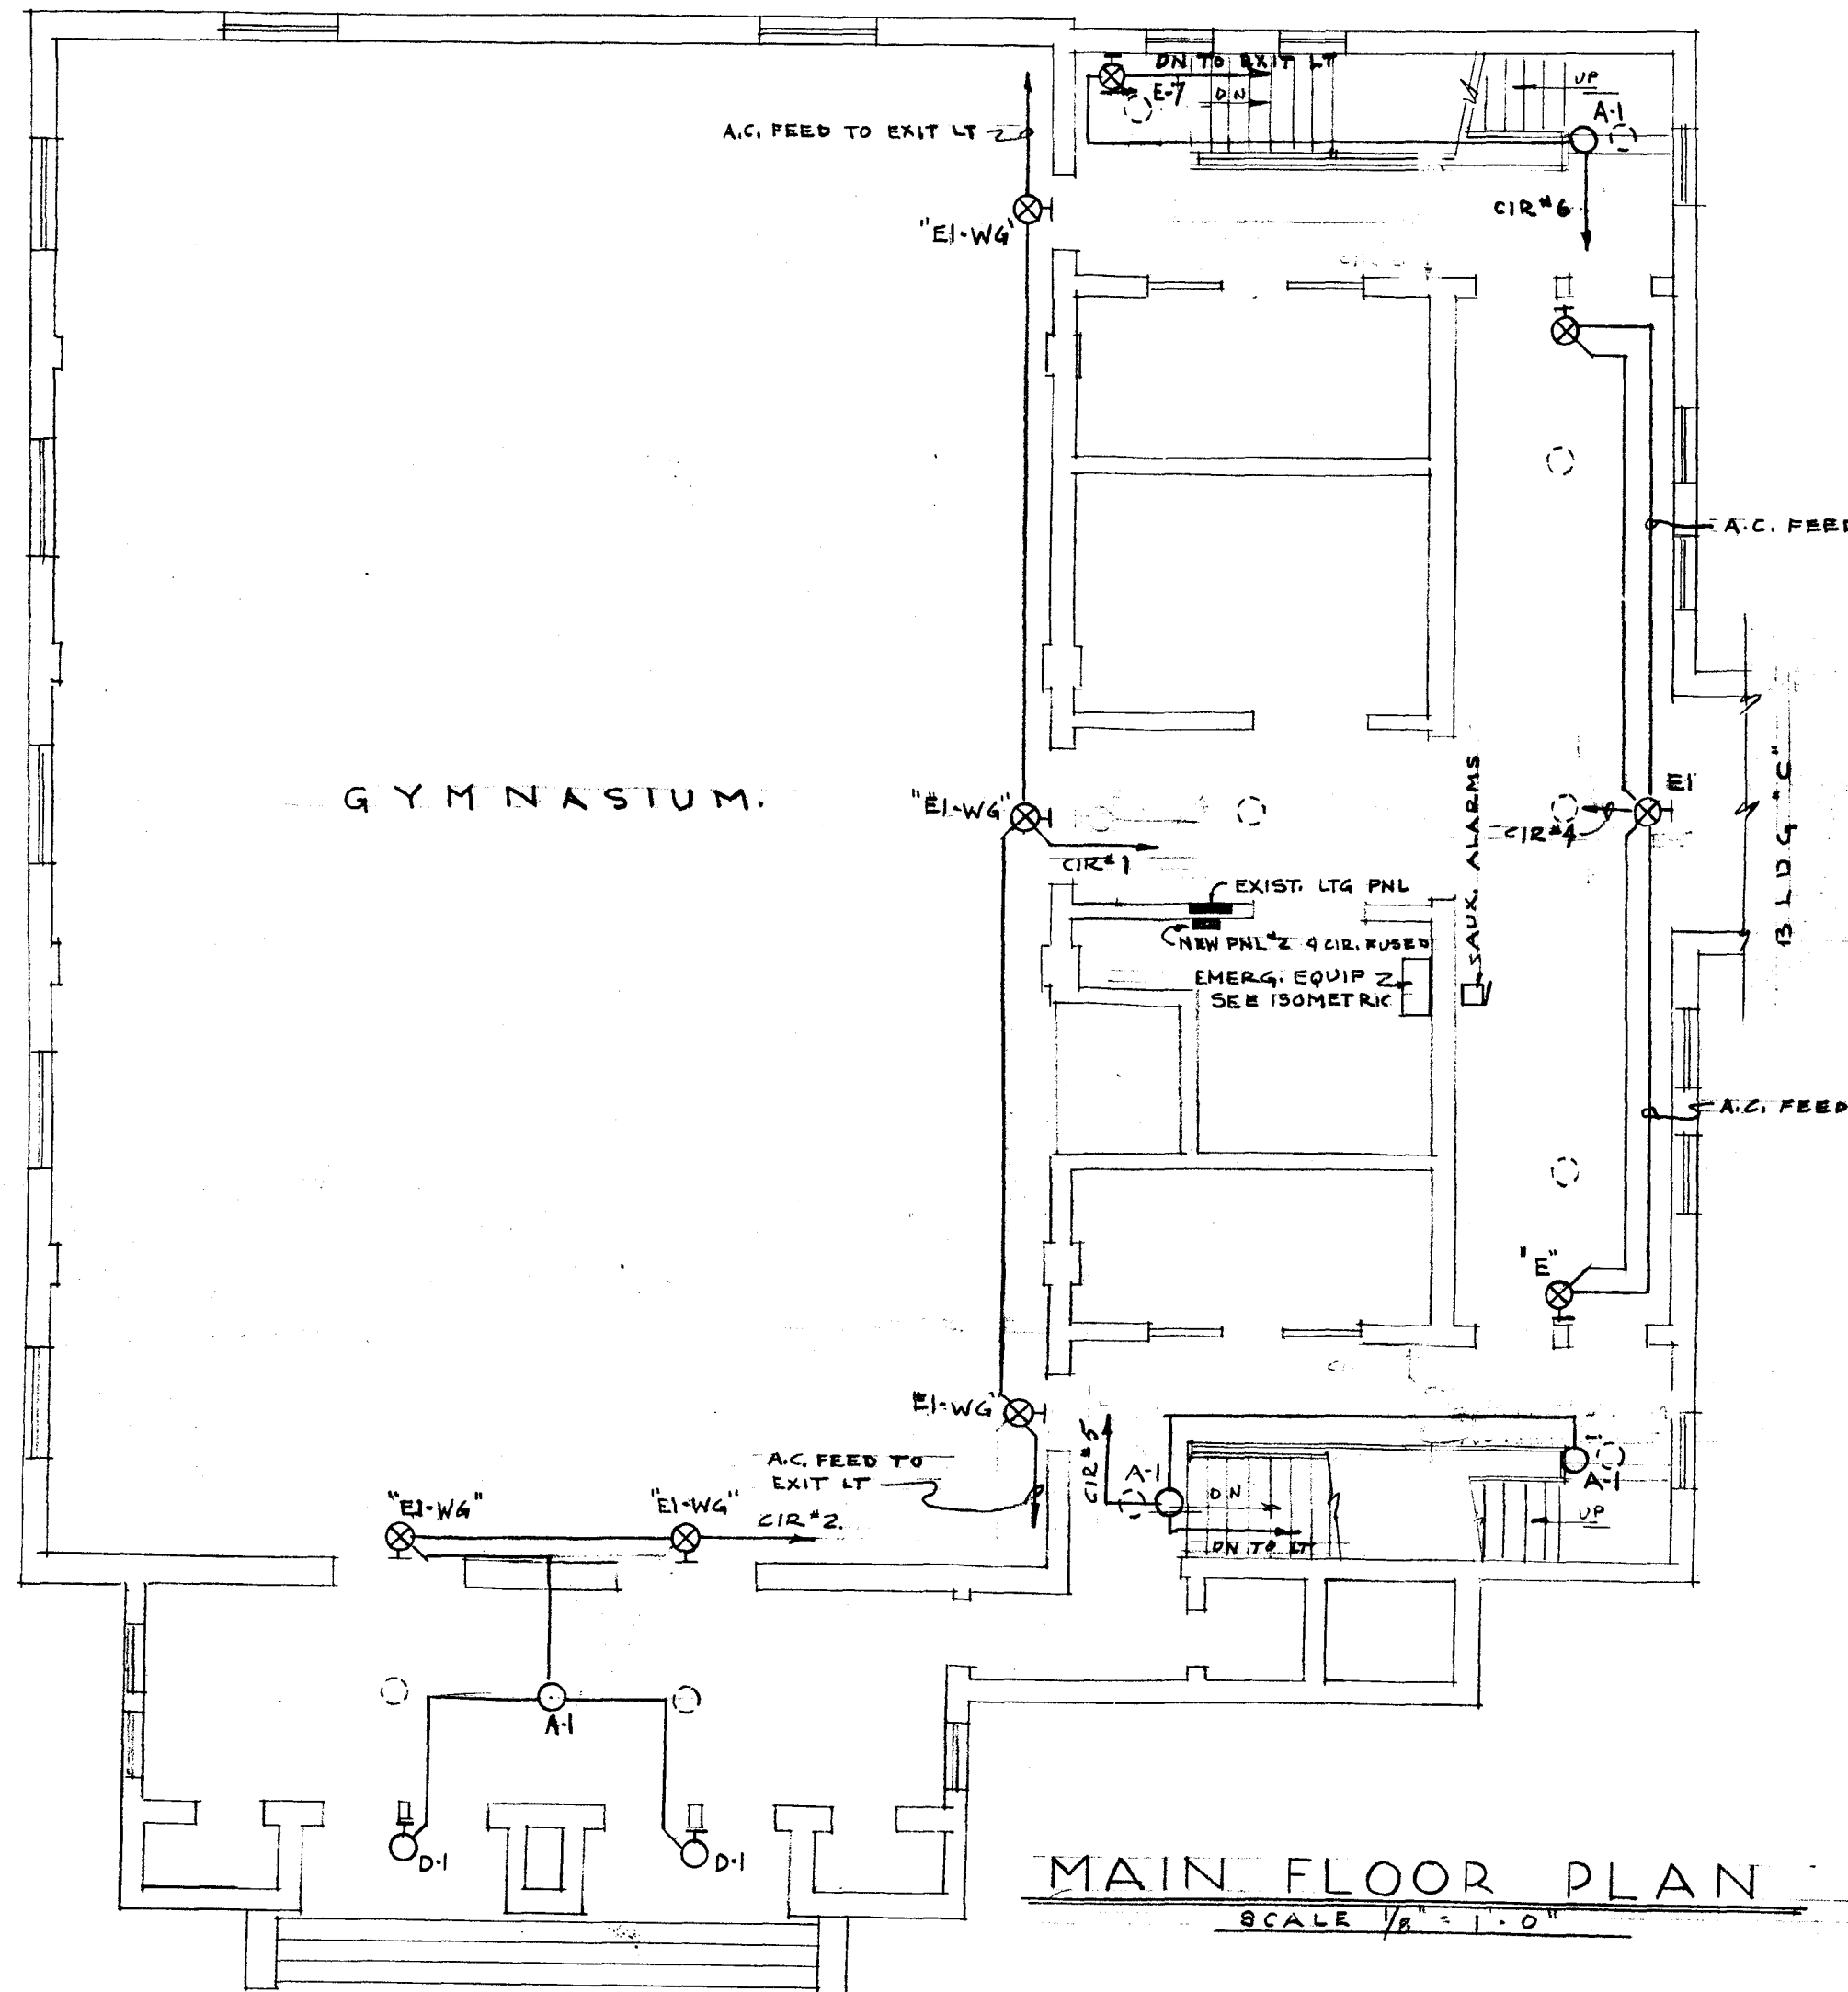

MAIN FLOOR PLAN
SCALE 1/8" = 1'-0"

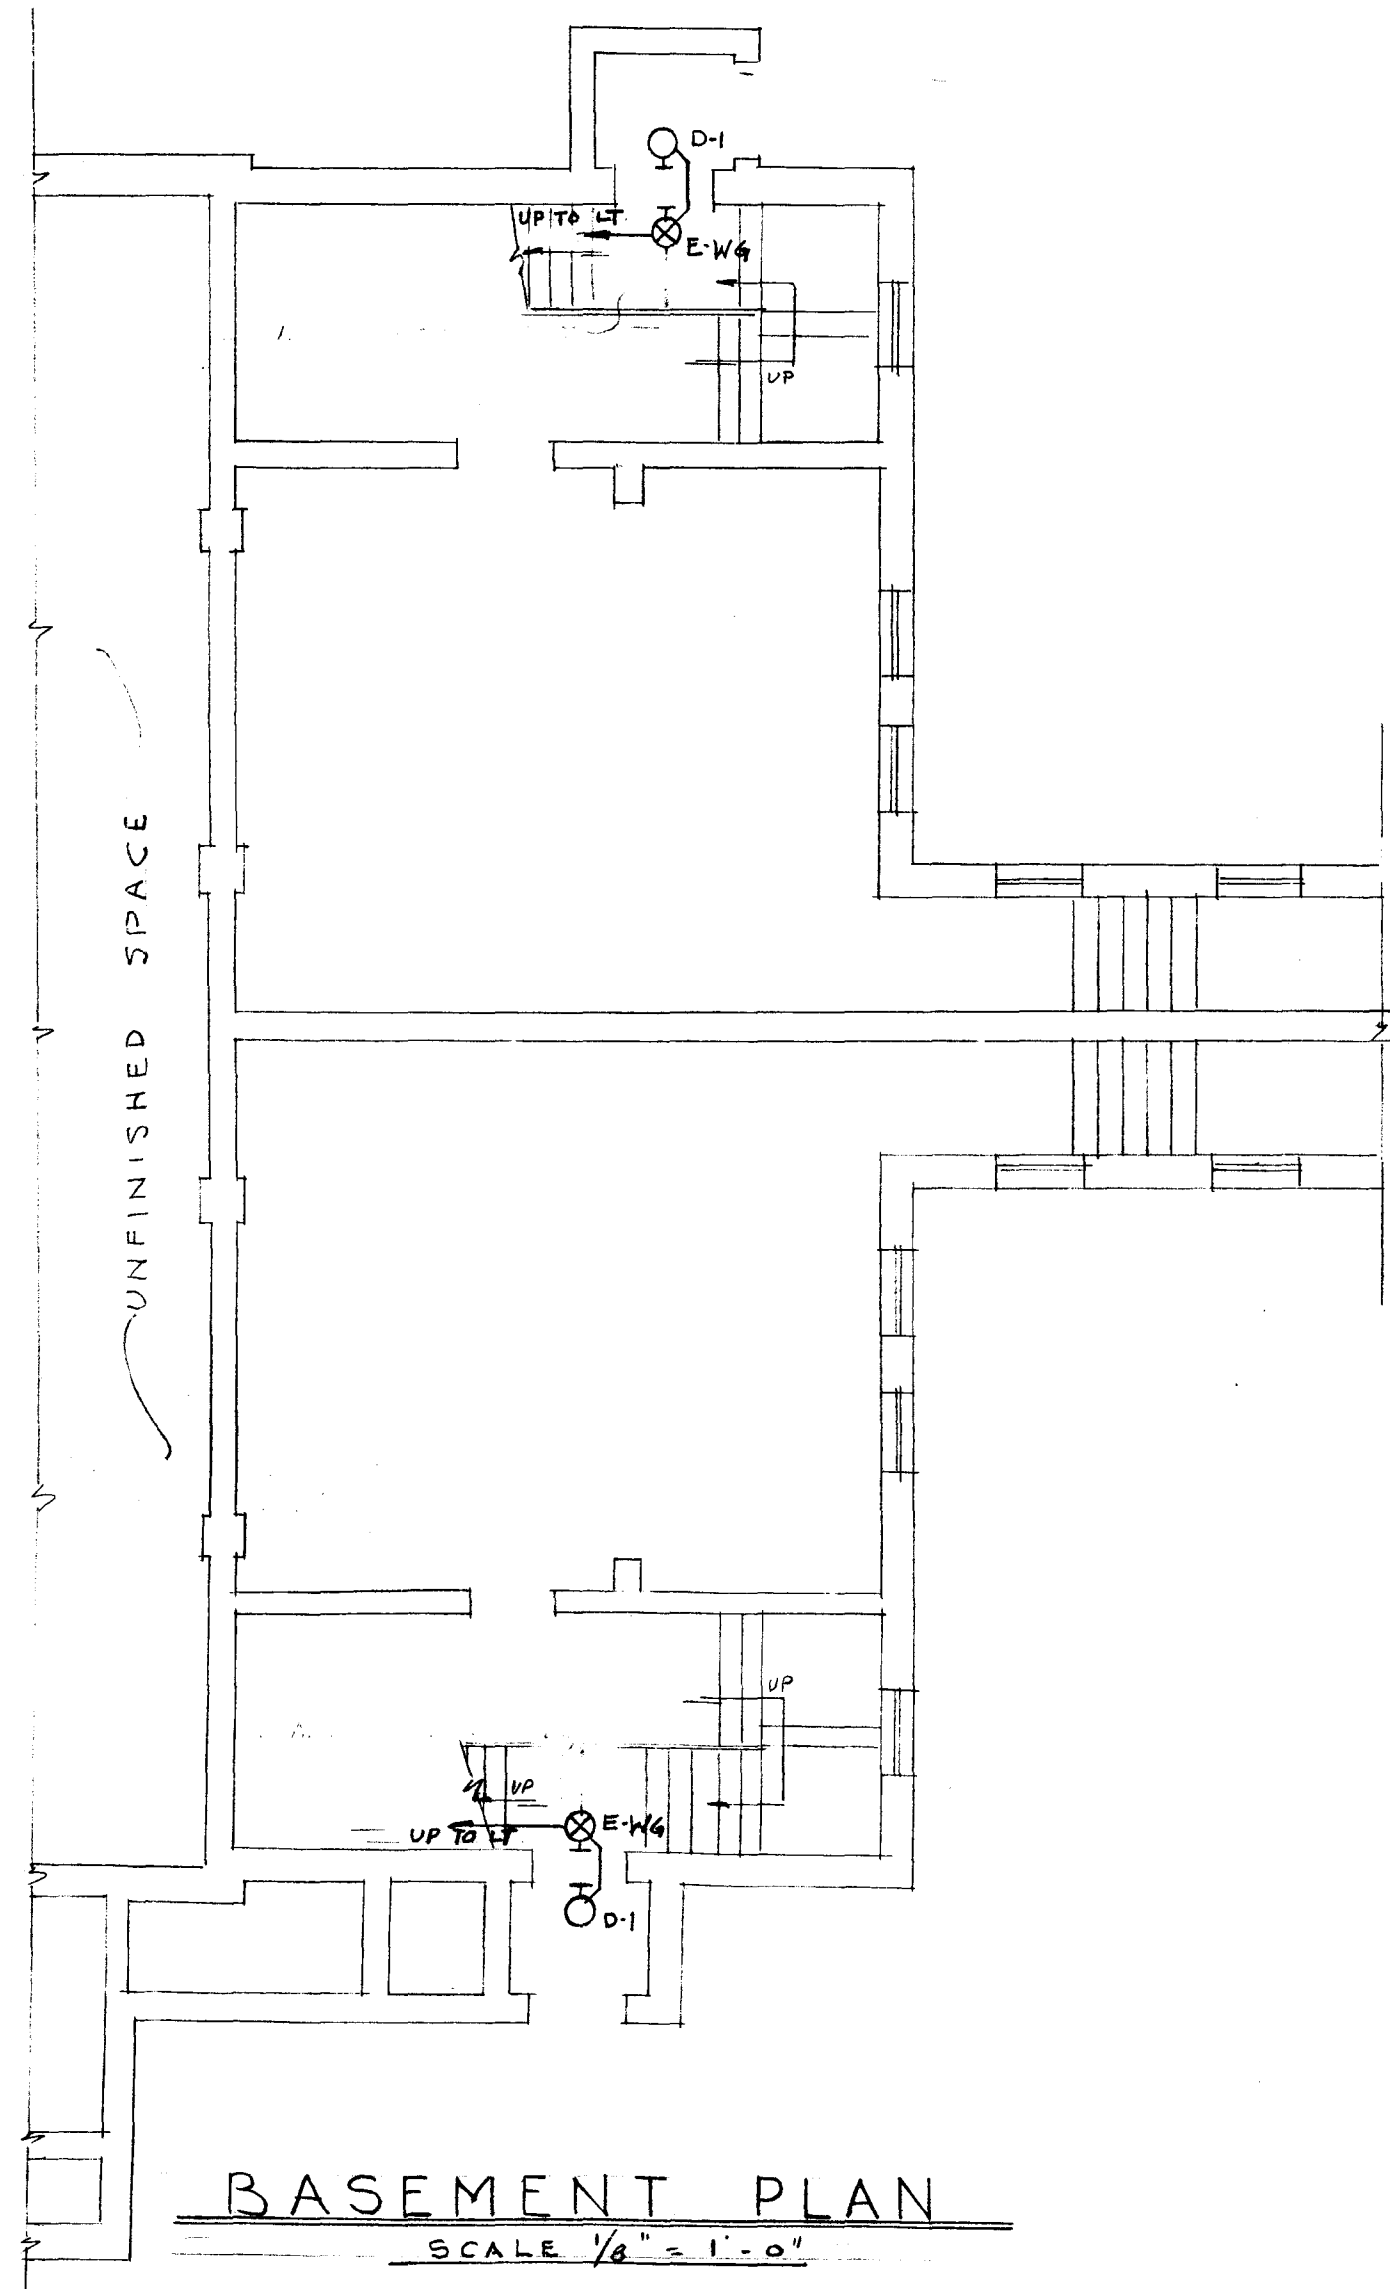

BASEMENT PLAN
SCALE 1/8" = 1'-0"

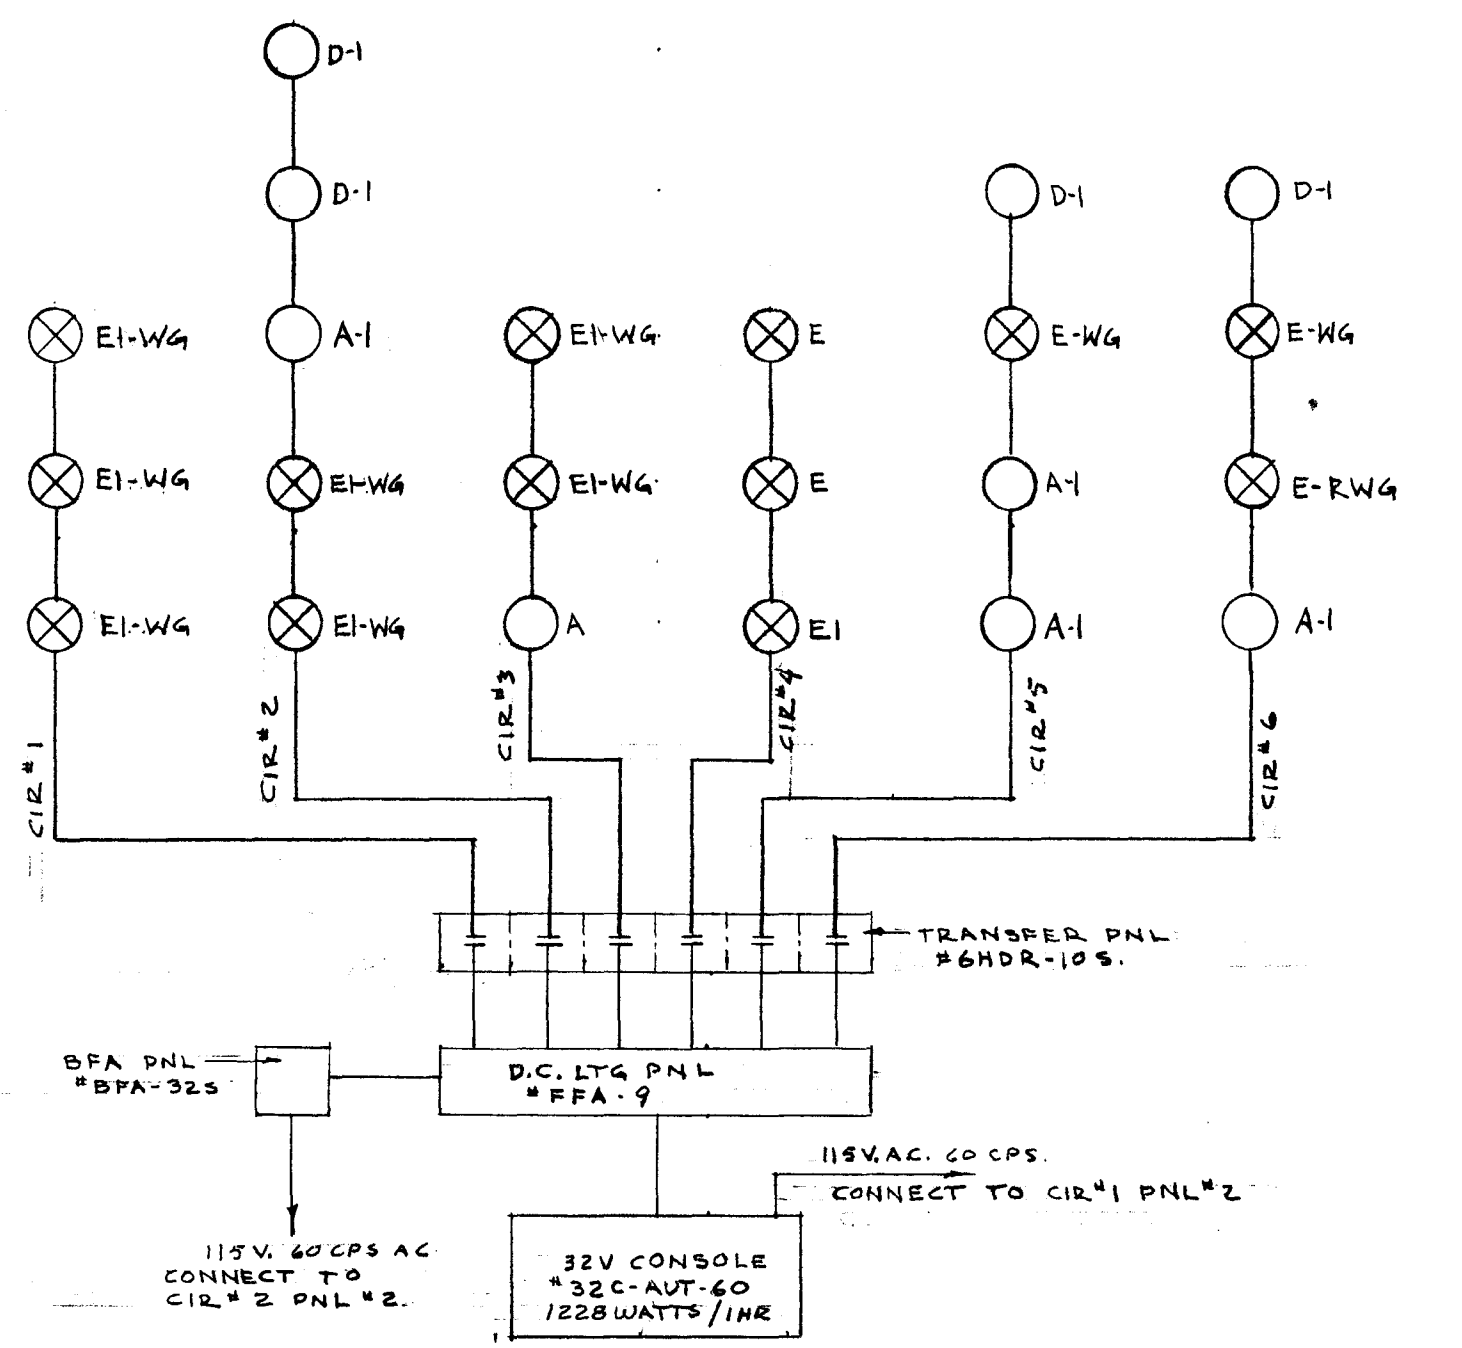

EMERGENCY LIGHTING SCHEMATIC
NO SCALE

GYMNASIUM (BLDG-D)

CITY OF HARTFORD, CONNECTICUT
DEPARTMENT OF ENGINEERING

EMERGENCY LIGHTING
FOR
FRANK A. BRACKETT SCHOOL
54 WESTLAND ST., HARTFORD CONN.

SUBMITTED DIVISION ARCHITECT DATE 10/1/60	RECOMMENDED CITY ARCHITECT DATE 10/1/60	APPROVED CITY ENGINEER DATE 10/1/60
DESIGN R.G.B.	DRAWN R.G.B.	DAYBOOK NO. 09610-G
TRACED	CHECK	DATE MARCH 10, 1960

VERIFY EXISTING
CONDITIONS AND
DIMENSIONS AT
BUILDING