


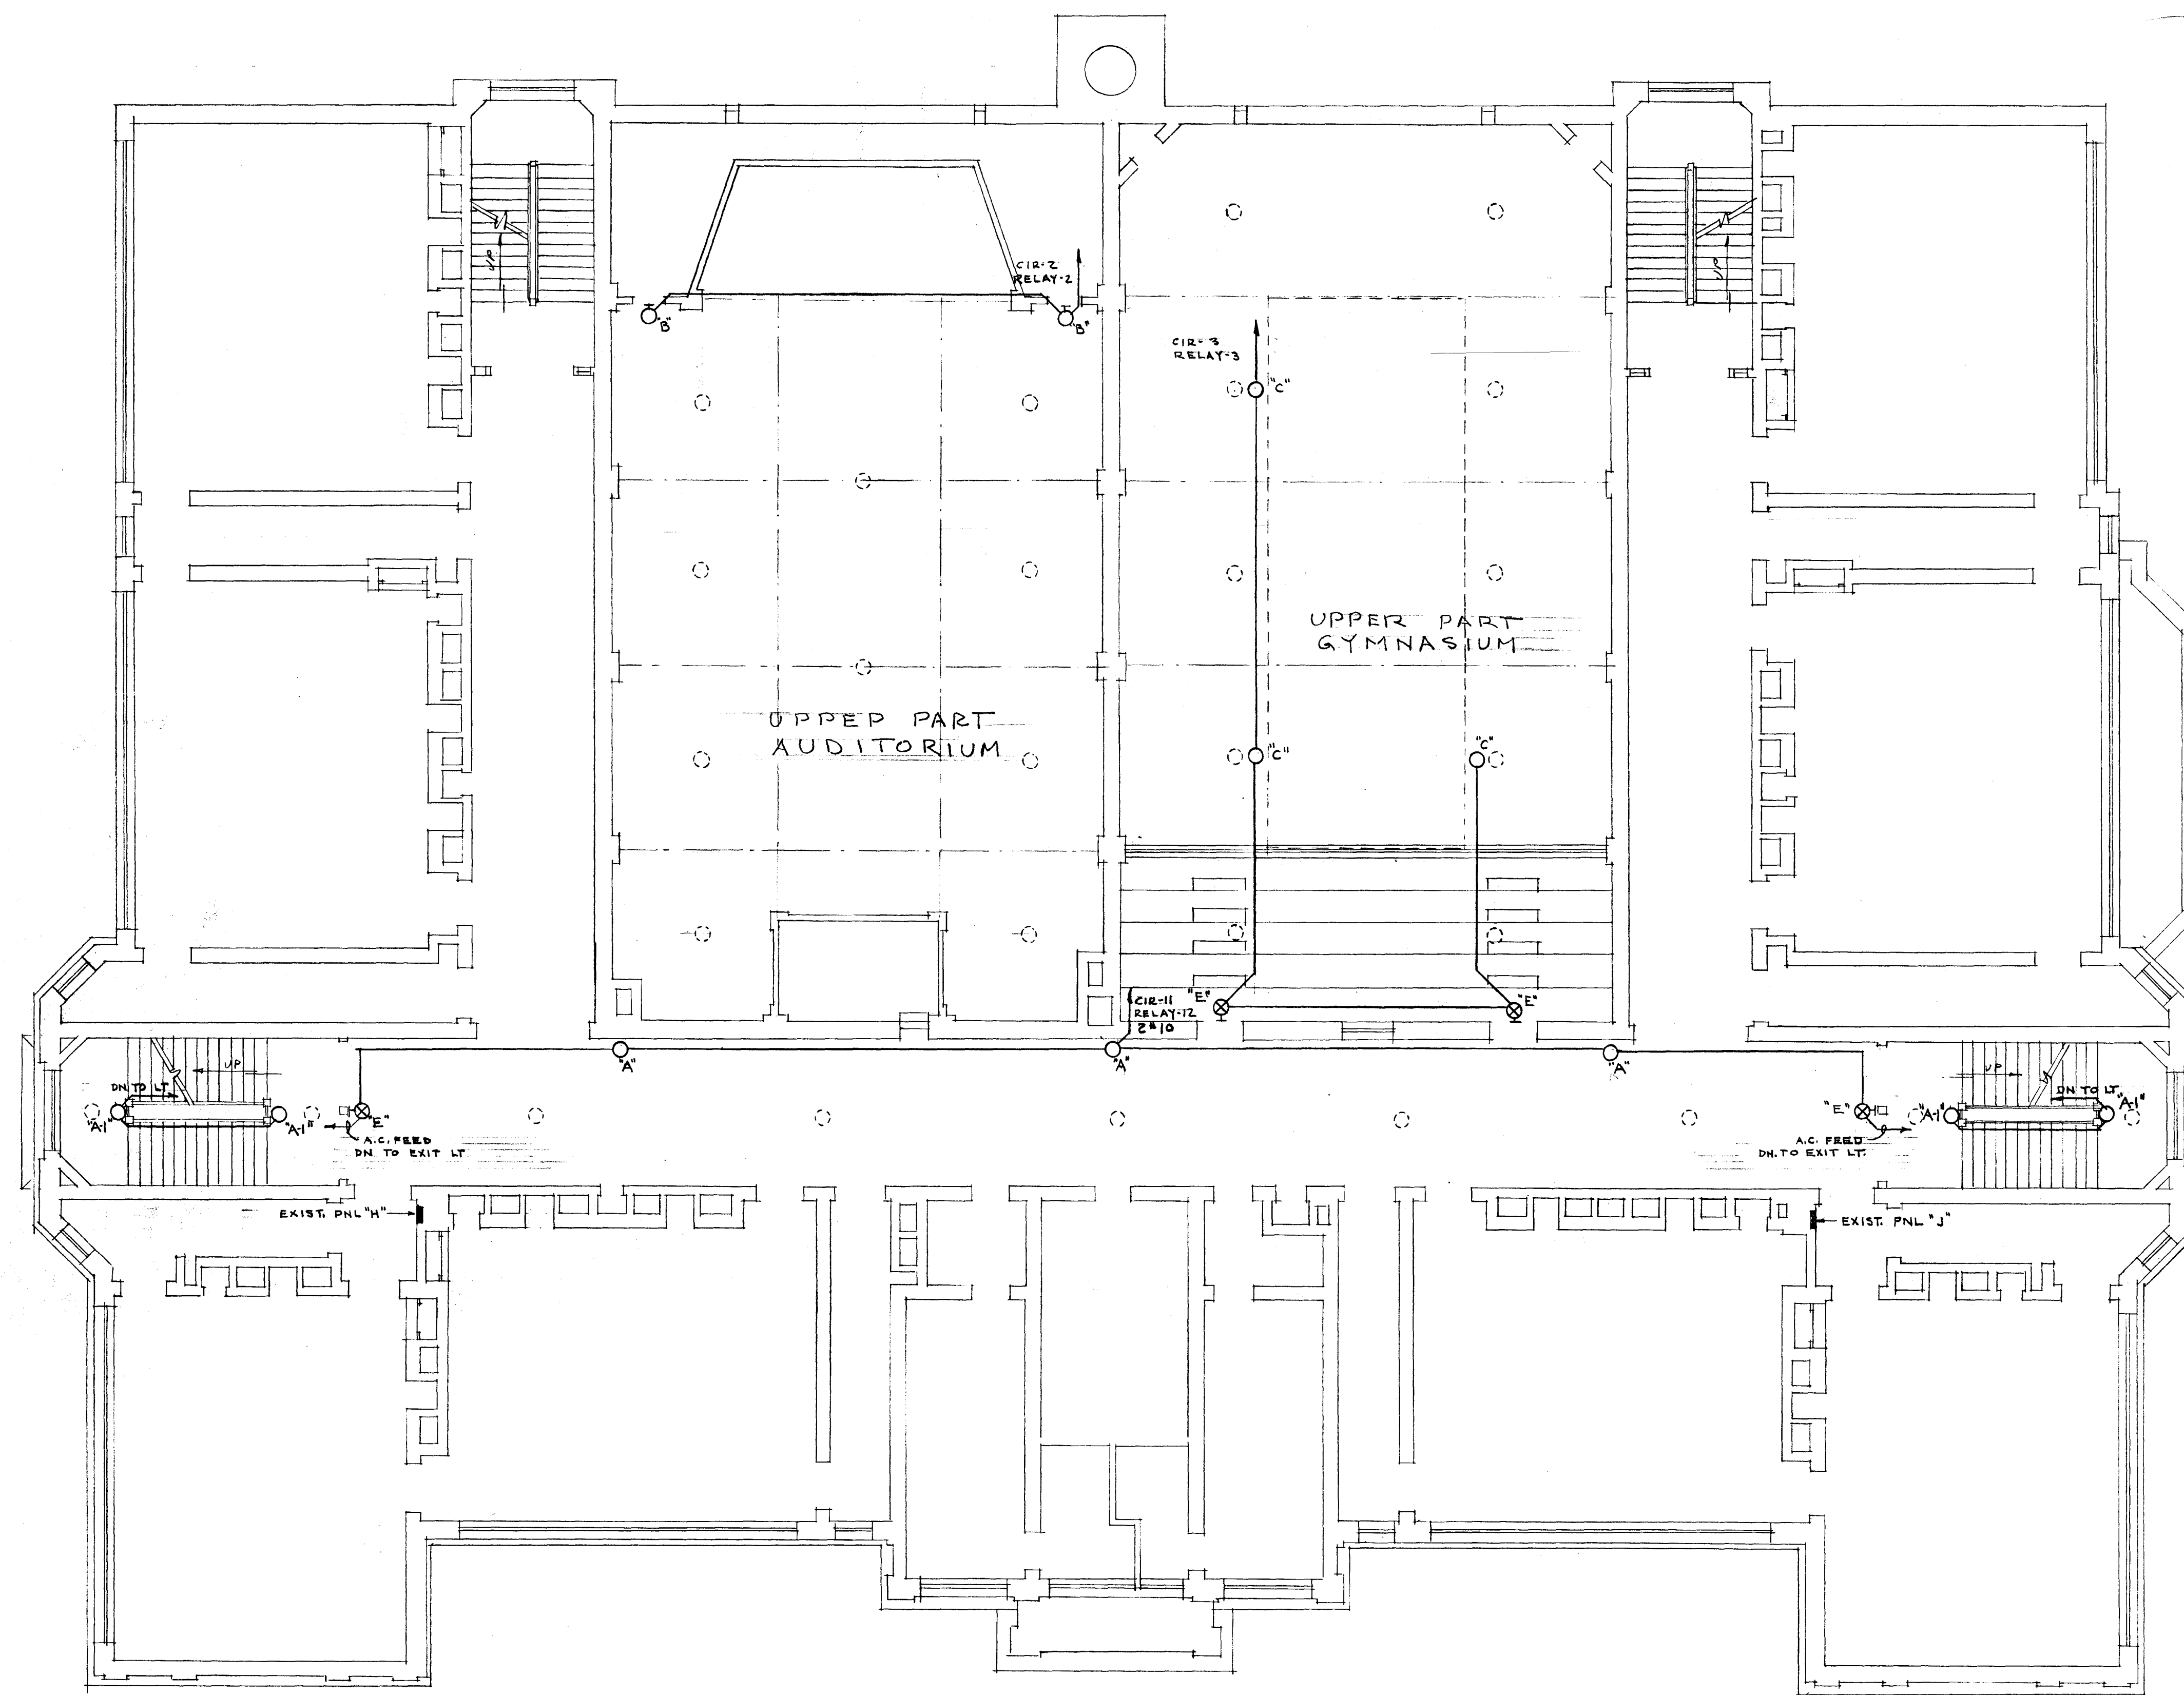

FIXTURE		SCHEDULE
TYPE	MANUFACTURER & CATALOG NO.	LAMPS
A	DUAL-LITE #EXT-124S	2-32 CP
A-1	" #EXT-124S	2-15 CP
B	" #EXT-121	1-50 CP
C	" #EXT-124R	2-32 CP
D	" #EXT-05	2-32 CP
D-1	" #EXT-05	2-15 CP
E	" #EXT-125	2-25 WATT A.C. & 3-15CP
E-WG.	" #EXT-125	2-25 WATT A.C. & 3-15CP

SYMBOL LIST	
SYMBOL	DESCRIPTION
○	EXISTING OUTLET OR FIXTURE
○	CEILING FIXTURE
⊙	WALL BRACKET
⊗	EXIT LIGHT
■	PANELBOARD
□	AUX. ALARMS FOR SFA. & D.C. LTG. PNLS.

SECOND FLOOR PLAN
SCALE 1/8" = 1'-0"

CITY OF HARTFORD, CONNECTICUT
DEPARTMENT OF ENGINEERING

EMERGENCY LIGHTING
FOR
RICHARD J. KINSELLA SCHOOL
42 CHARTER OAK AV. HARTFORD CONN.

VERIFY EXISTING
CONDITIONS AND
DIMENSIONS AT
BUILDING

SUBMITTED: *David J. Kinney*
DIVISION ARCHITECT
RECOMMENDED: *David J. Kinney*
CITY ARCHITECT
APPROVED: *David J. Kinney*
CITY ENGINEER
DESIGN: *R.G.B.* DRAWN: *R.G.B.* DAYBOOK NO. 09610-1
TRACED: _____ CHECK: _____ DATE: MARCH 10, 1960