


SYMBOL LIST	
○	EXISTING FIXTURE
○	CEILING OUTLET
⊙	WALL BRACKET
⊗	EXIT LIGHT
■	PANEL BOARD
□	AUX. ALARMS FOR BFA & D.C. LTG. PNLS

FIXTURE SCHEDULE		
TYPE	MANUFACTURER & CATALOG NO.	LAMPS
A-1	DUAL-LITE #EXT-1245	2-15 CP.
B	" #EXT-121	1-50 CP.
E	" #EXT-125	2-25 WATT A.C. & 3-15 CP
E-H	" #EXT-125H	" "
E-L	" #EXT-125L	" "
E-R	" #EXT-125R	" "
E1	" #EXT-125	2-25 WATT A.C. & 1-15CP & 2-32CP
E1WQ	" #EXT-125WQ	" " "
E1-R	" #EXT-125R	" " "
E2-H	" #EXT-127H	2-25 WATT A.C. & 3-15 CP

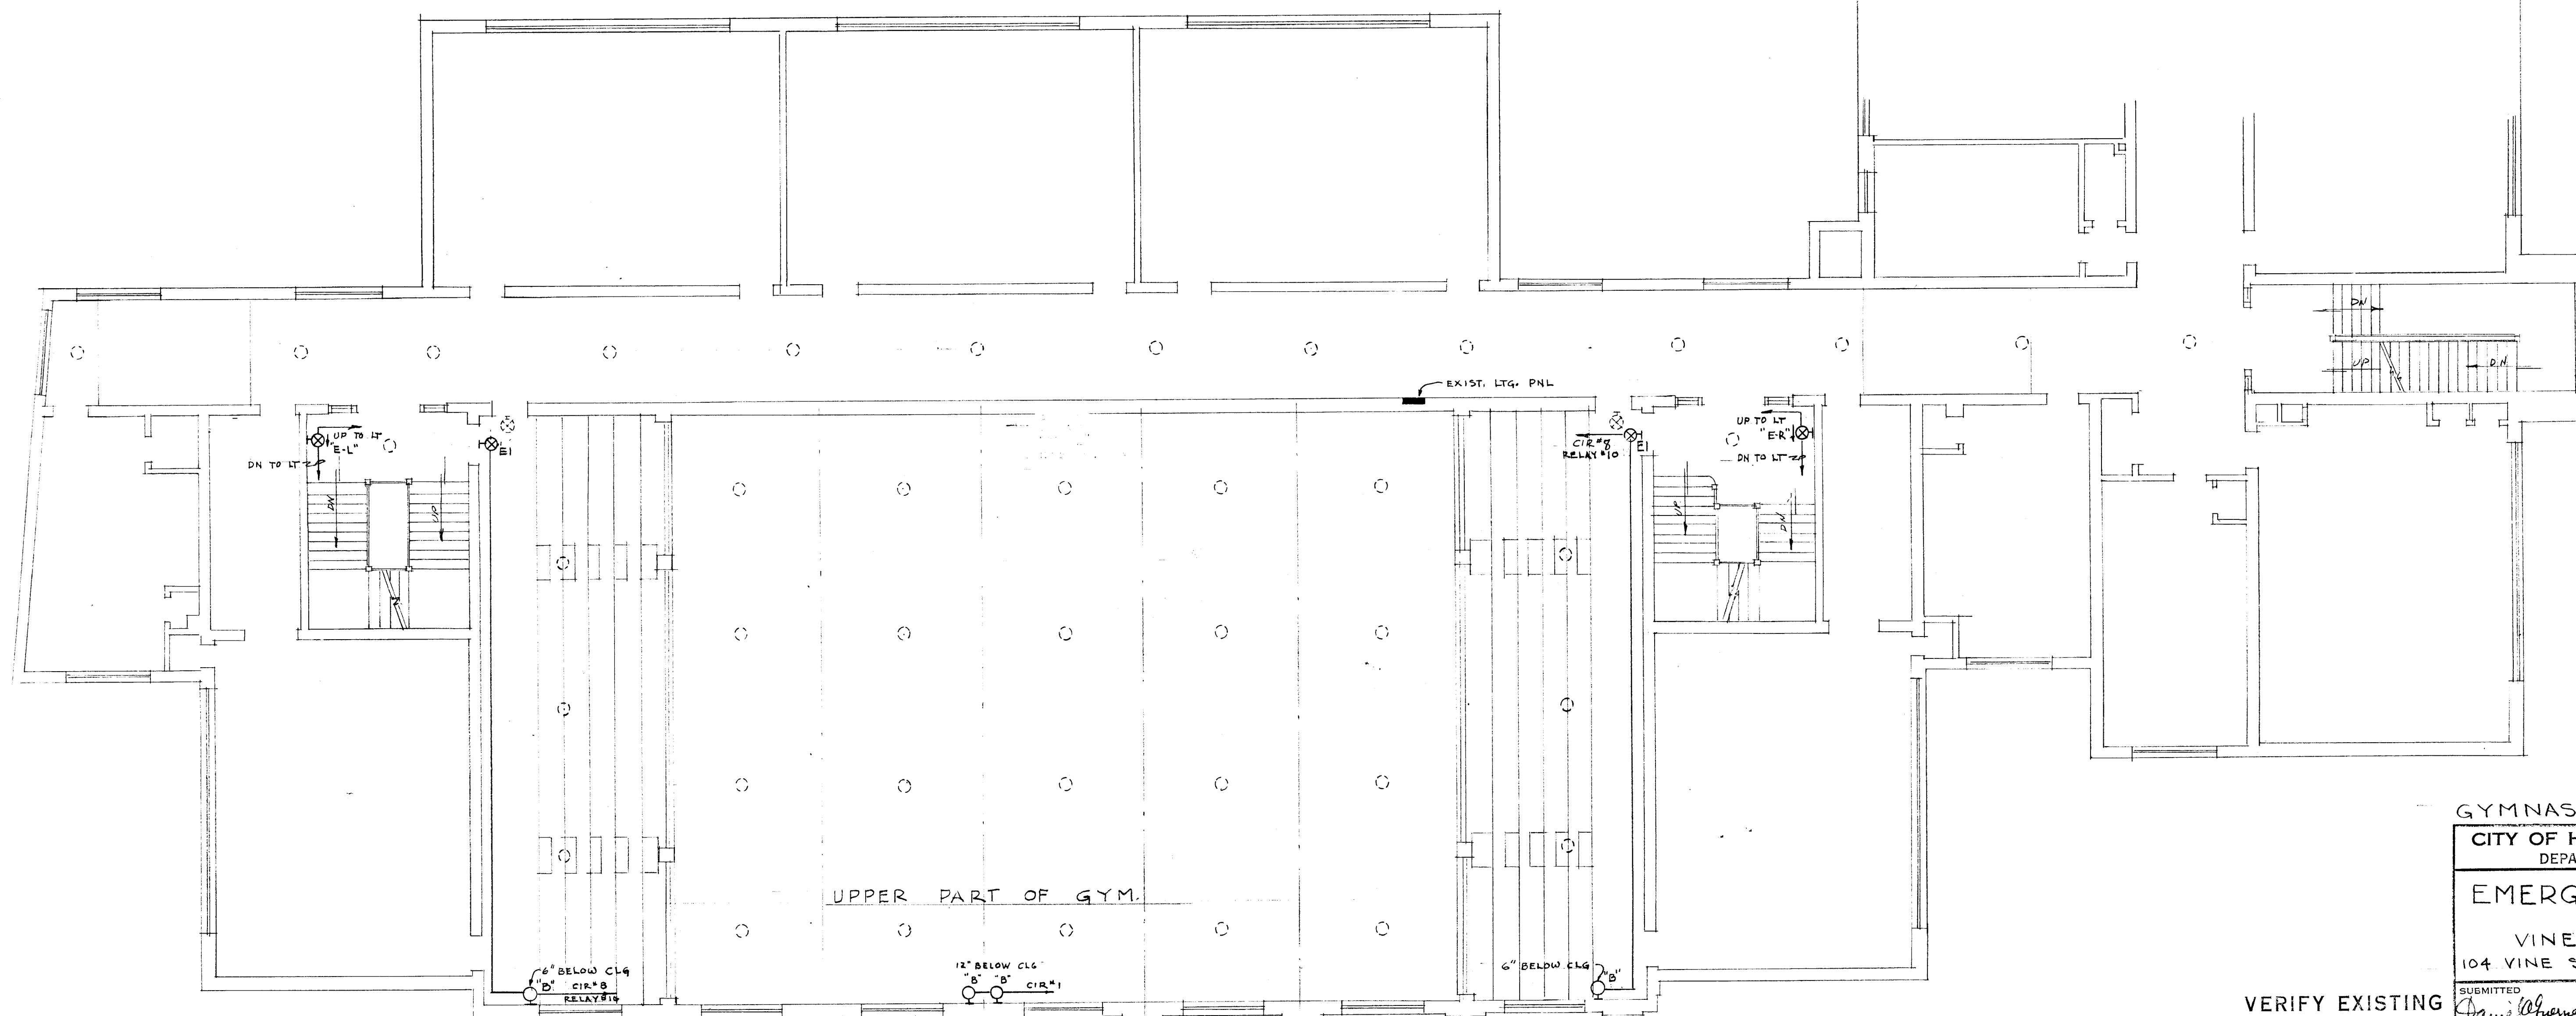

SECOND FLOOR PLAN
SCALE 1/8" = 1'-0"

GYMNASIUM CITY OF HARTFORD, CONNECTICUT DEPARTMENT OF ENGINEERING		
EMERGENCY LIGHTING FOR VINE STREET SCHOOL 104 VINE ST., HARTFORD CONN.		
SUBMITTED DIVISION ARCHITECT <i>James A. Thomas</i>	RECOMMENDED CITY ARCHITECT <i>Daniel J. Turrel</i>	APPROVED CITY ENGINEER <i>William J. May</i>
DESIGN <i>R.G.B.</i> TRACED _____	DRAWN <i>R.G.B.</i> CHECK _____	DAYBOOK NO. 09611-H DATE MARCH 10, 1960

VERIFY EXISTING
CONDITIONS AND
DIMENSIONS AT
BUILDING

88

88
H.S.