




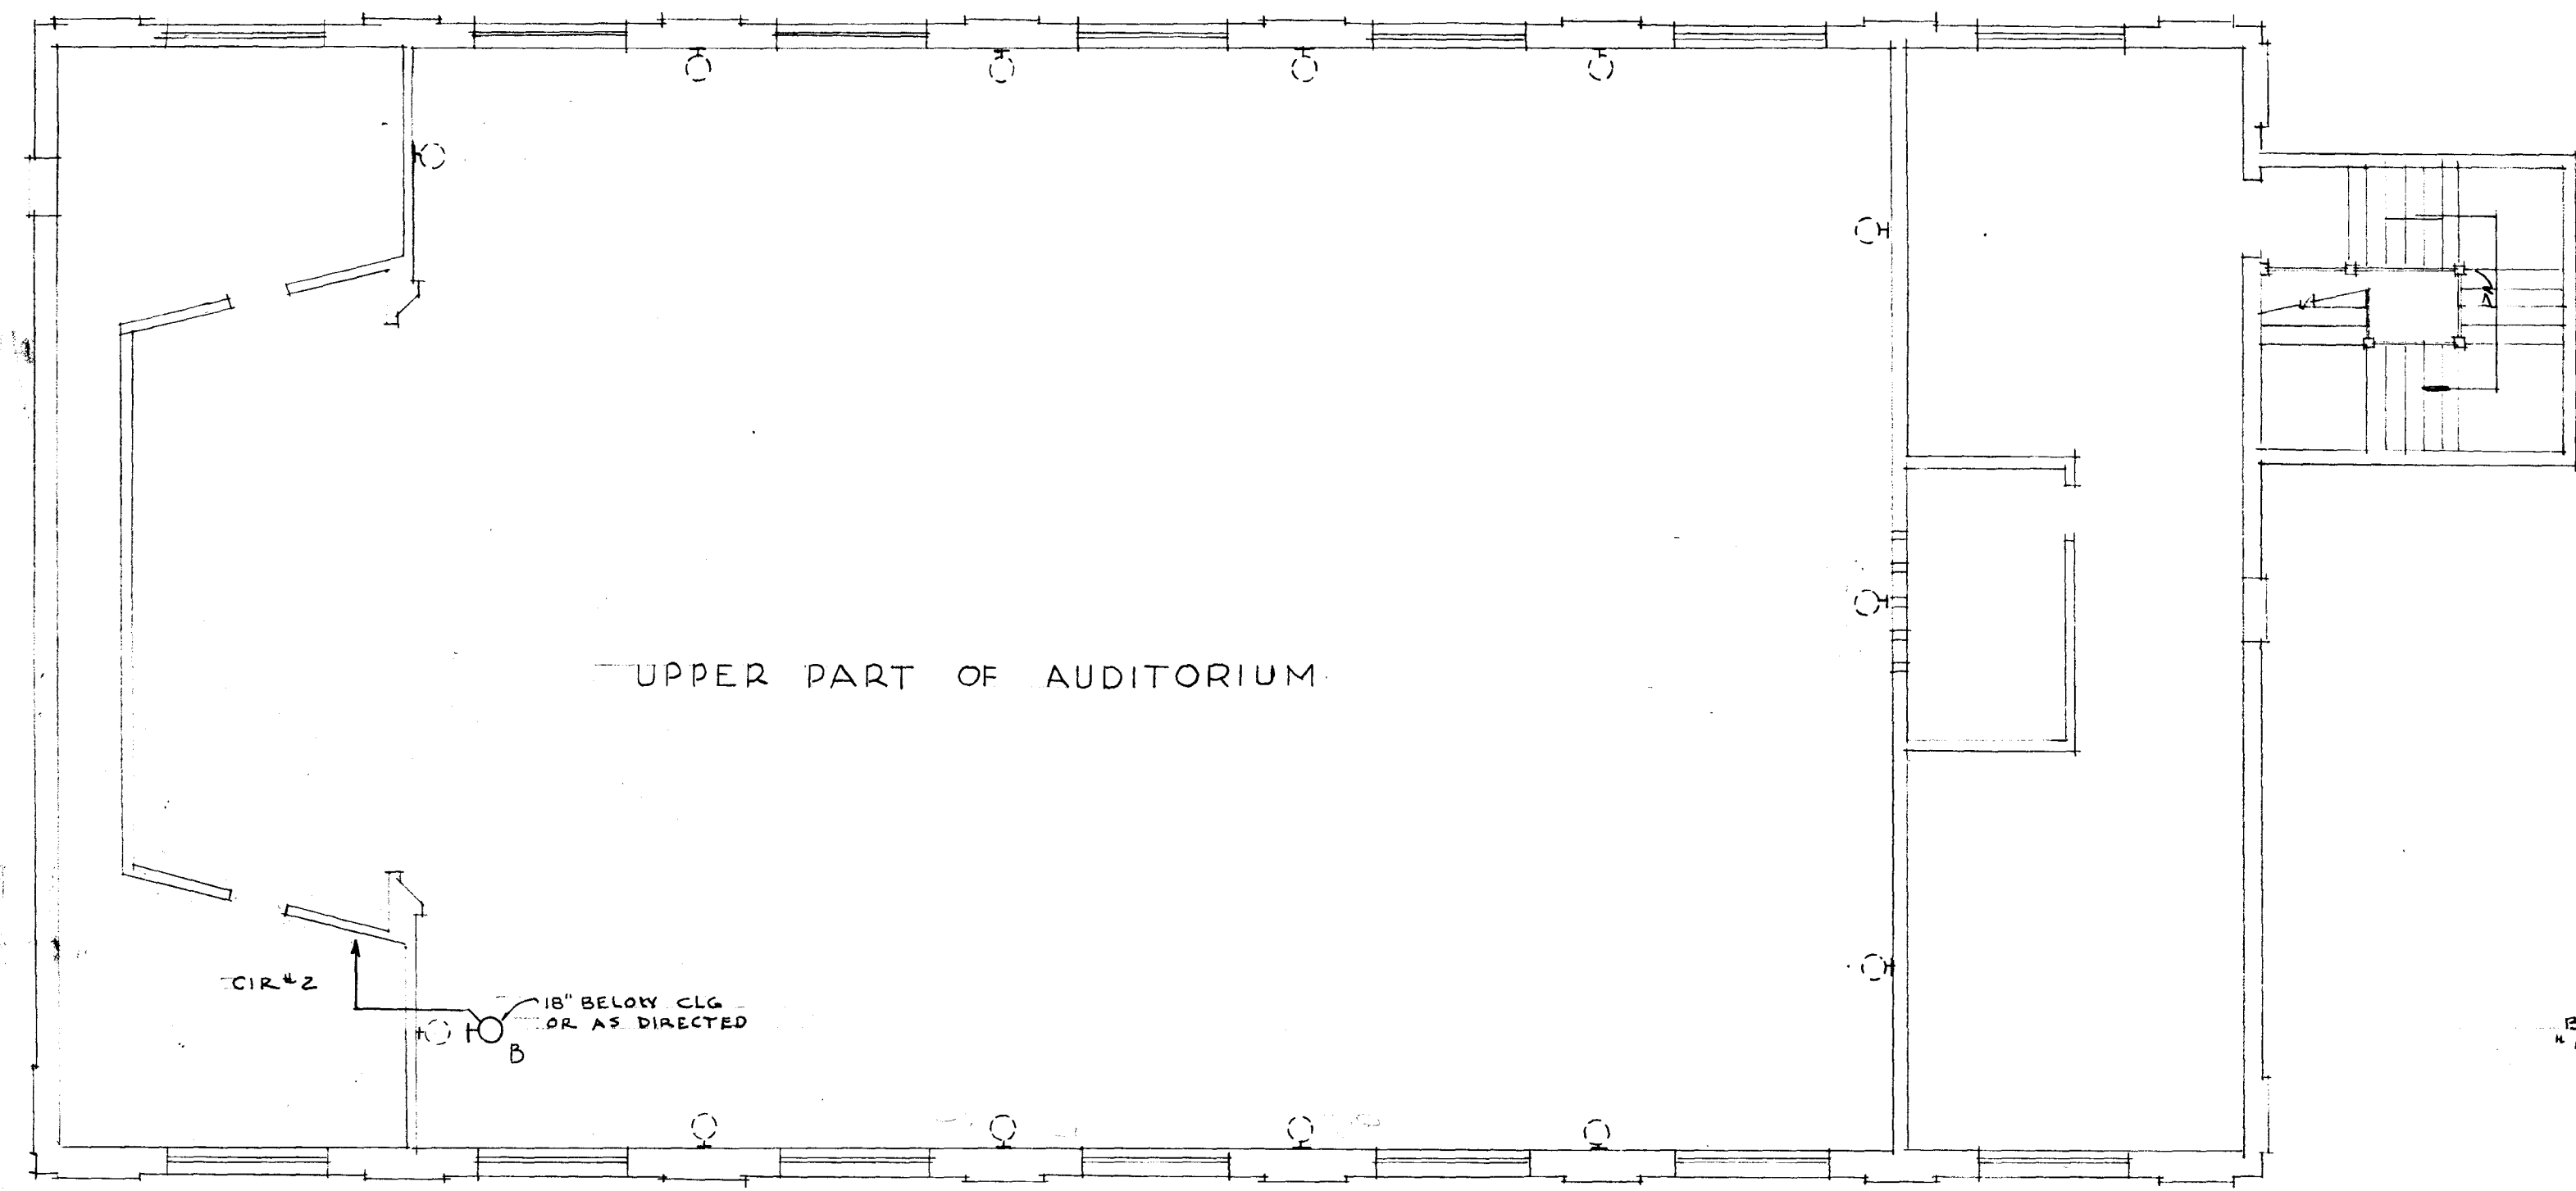


FOURTH FLOOR PLAN
SCALE 1/8" = 1'-0"

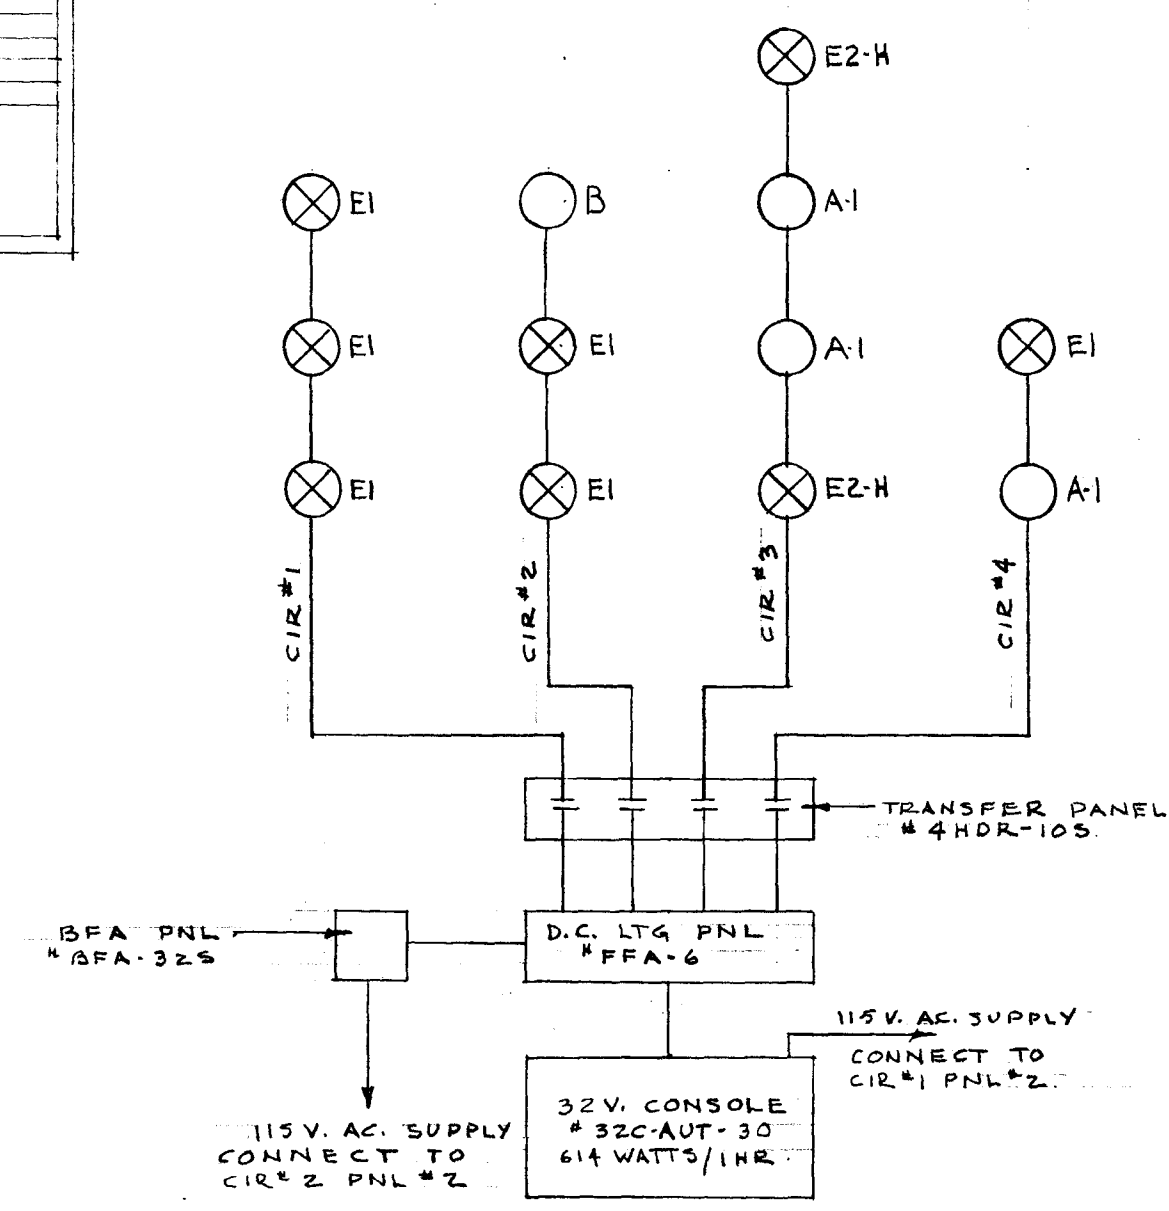


EMERGENCY LIGHTING SCHEMATIC (AUD)
NO SCALE

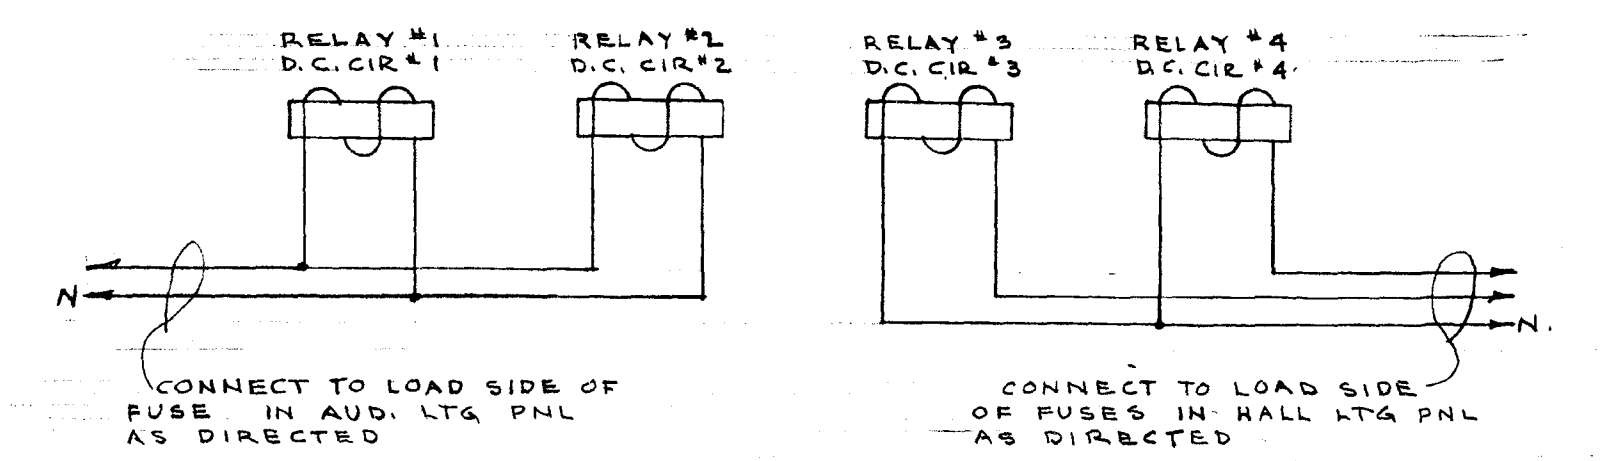

WIRING DIAGRAM OF A.C. CONTROL FOR RELAYS IN TRANSFER PANEL
NO SCALE

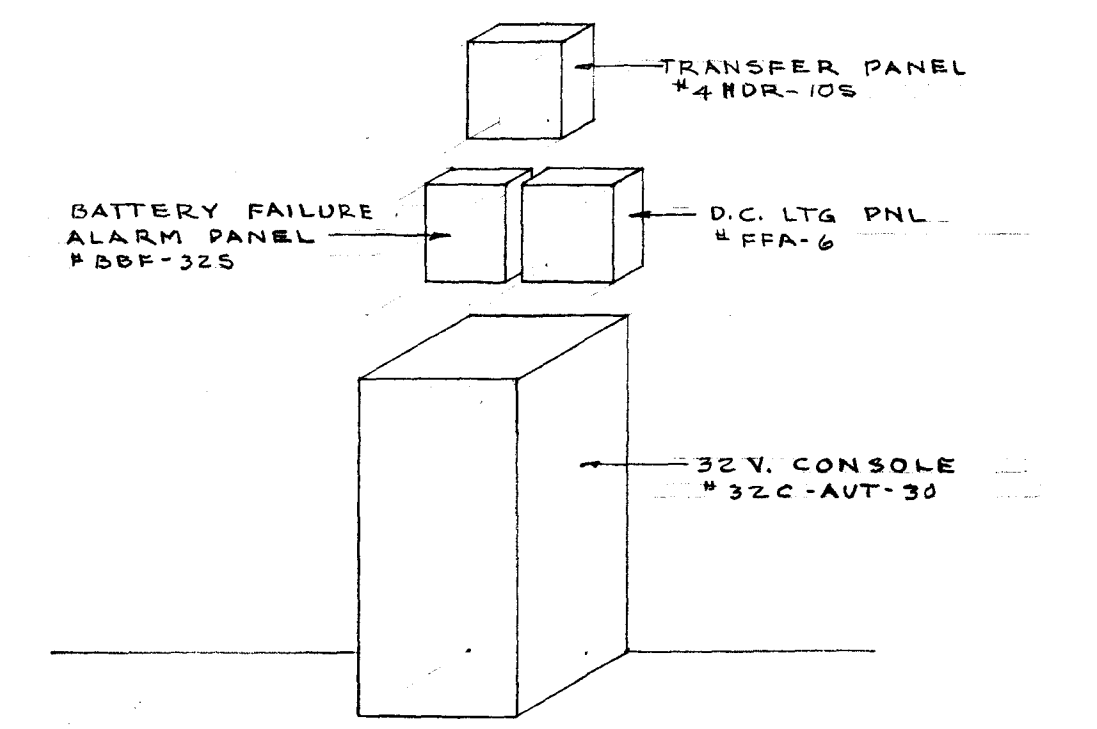

ISOMETRIC OF EMERGENCY EQUIPMENT
NO SCALE

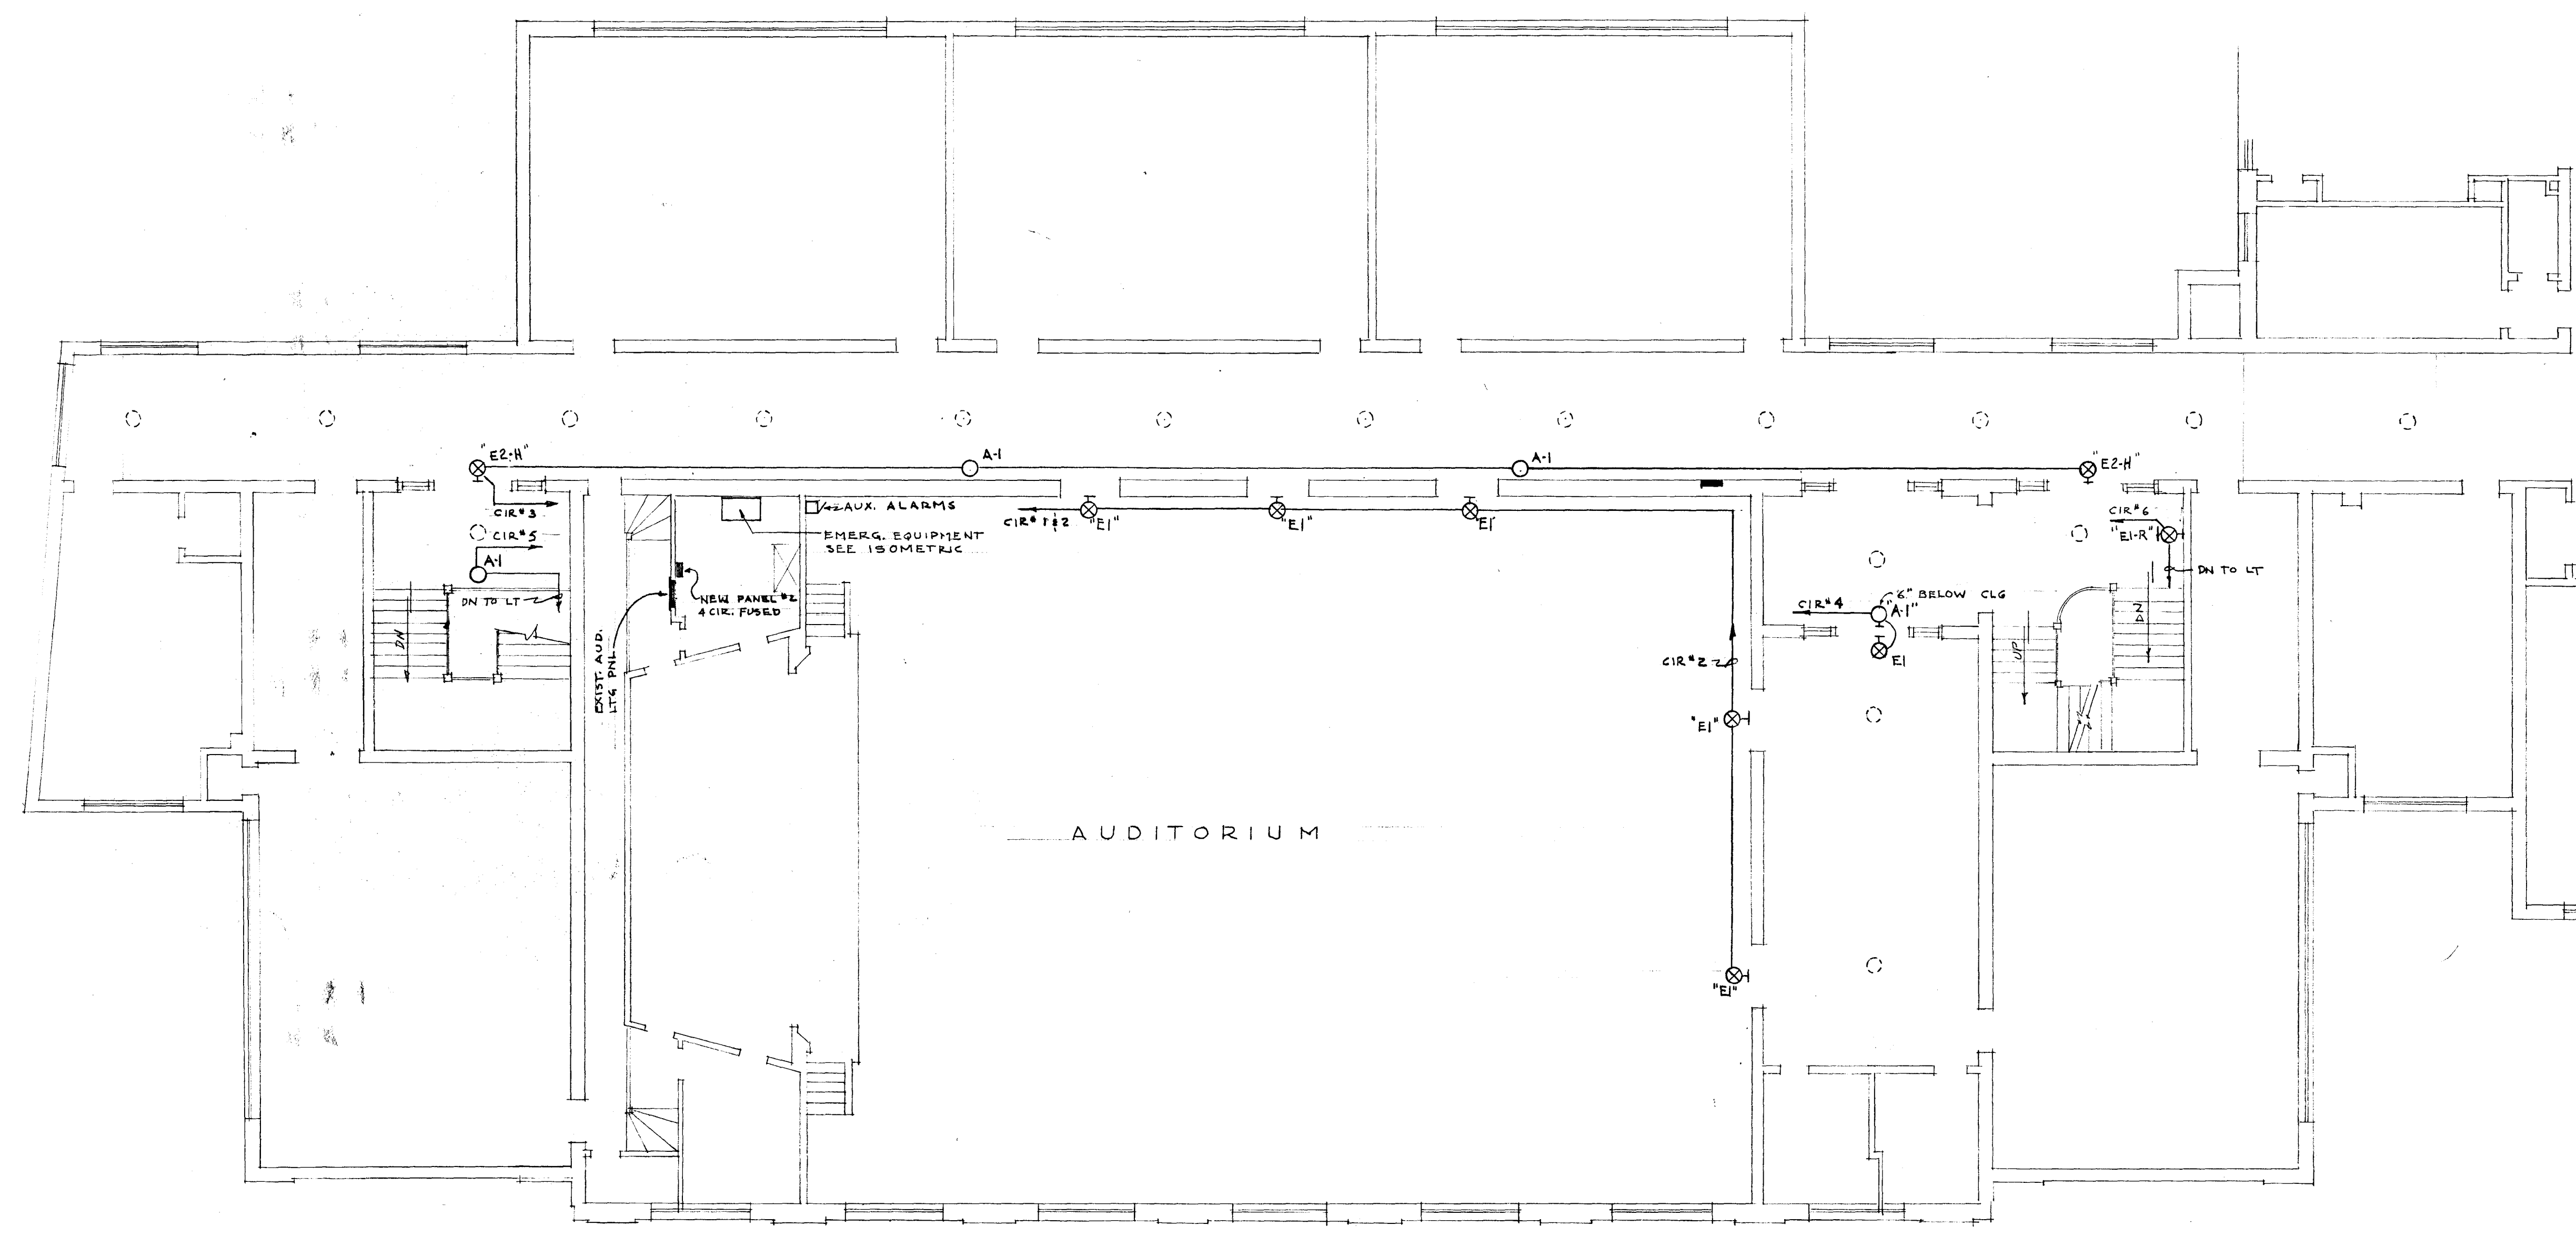

THIRD FLOOR PLAN
SCALE 1/8" = 1'-0"

VERIFY EXISTING
CONDITIONS AND
DIMENSIONS AT
BUILDING

AUDITORIUM		
CITY OF HARTFORD, CONNECTICUT DEPARTMENT OF ENGINEERING		
EMERGENCY LIGHTING FOR VINE STREET SCHOOL 104 VINE ST., HARTFORD CONN.		
SUBMITTED DIVISION ARCHITECT	RECOMMENDED CITY ARCHITECT	APPROVED CITY ENGINEER
DESIGN R.G.B.	DRAWN R.G.B.	DAYBOOK NO. 09611-1
TRACED	CHECK	DATE MARCH 10, 1960