
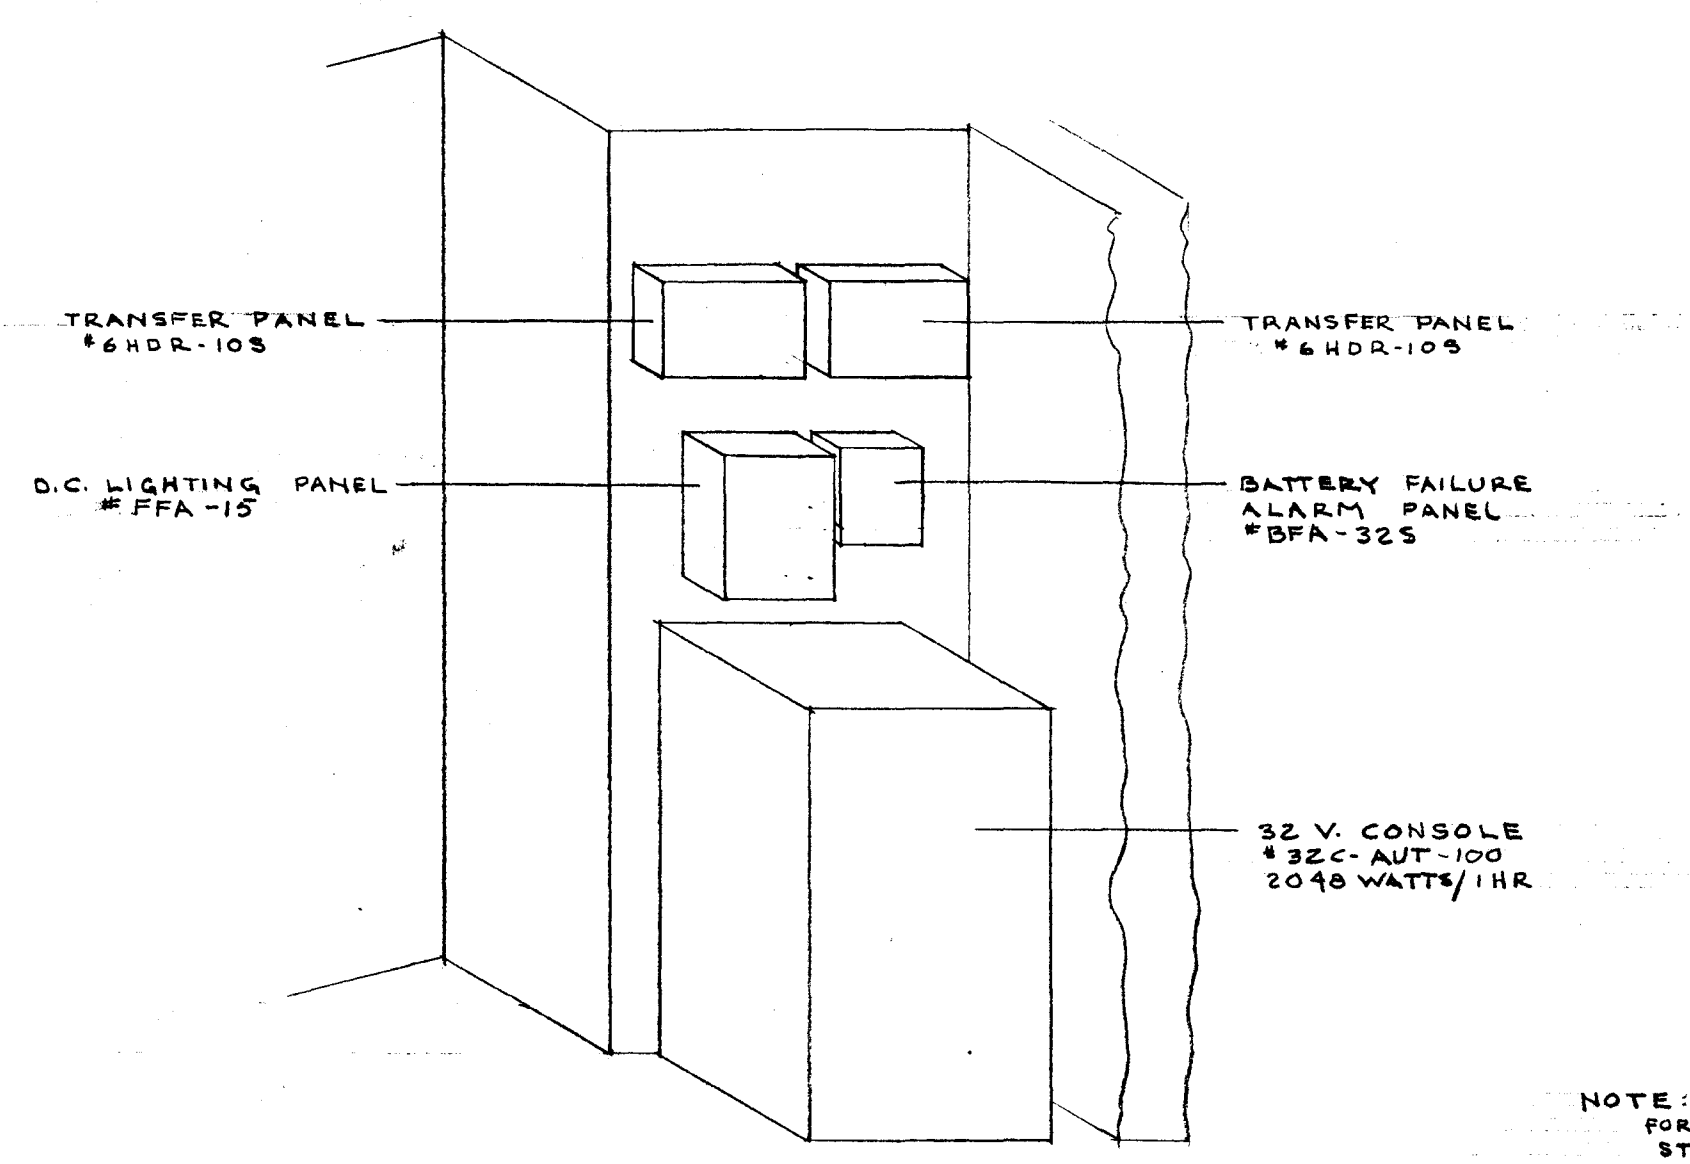


8/10

8/10

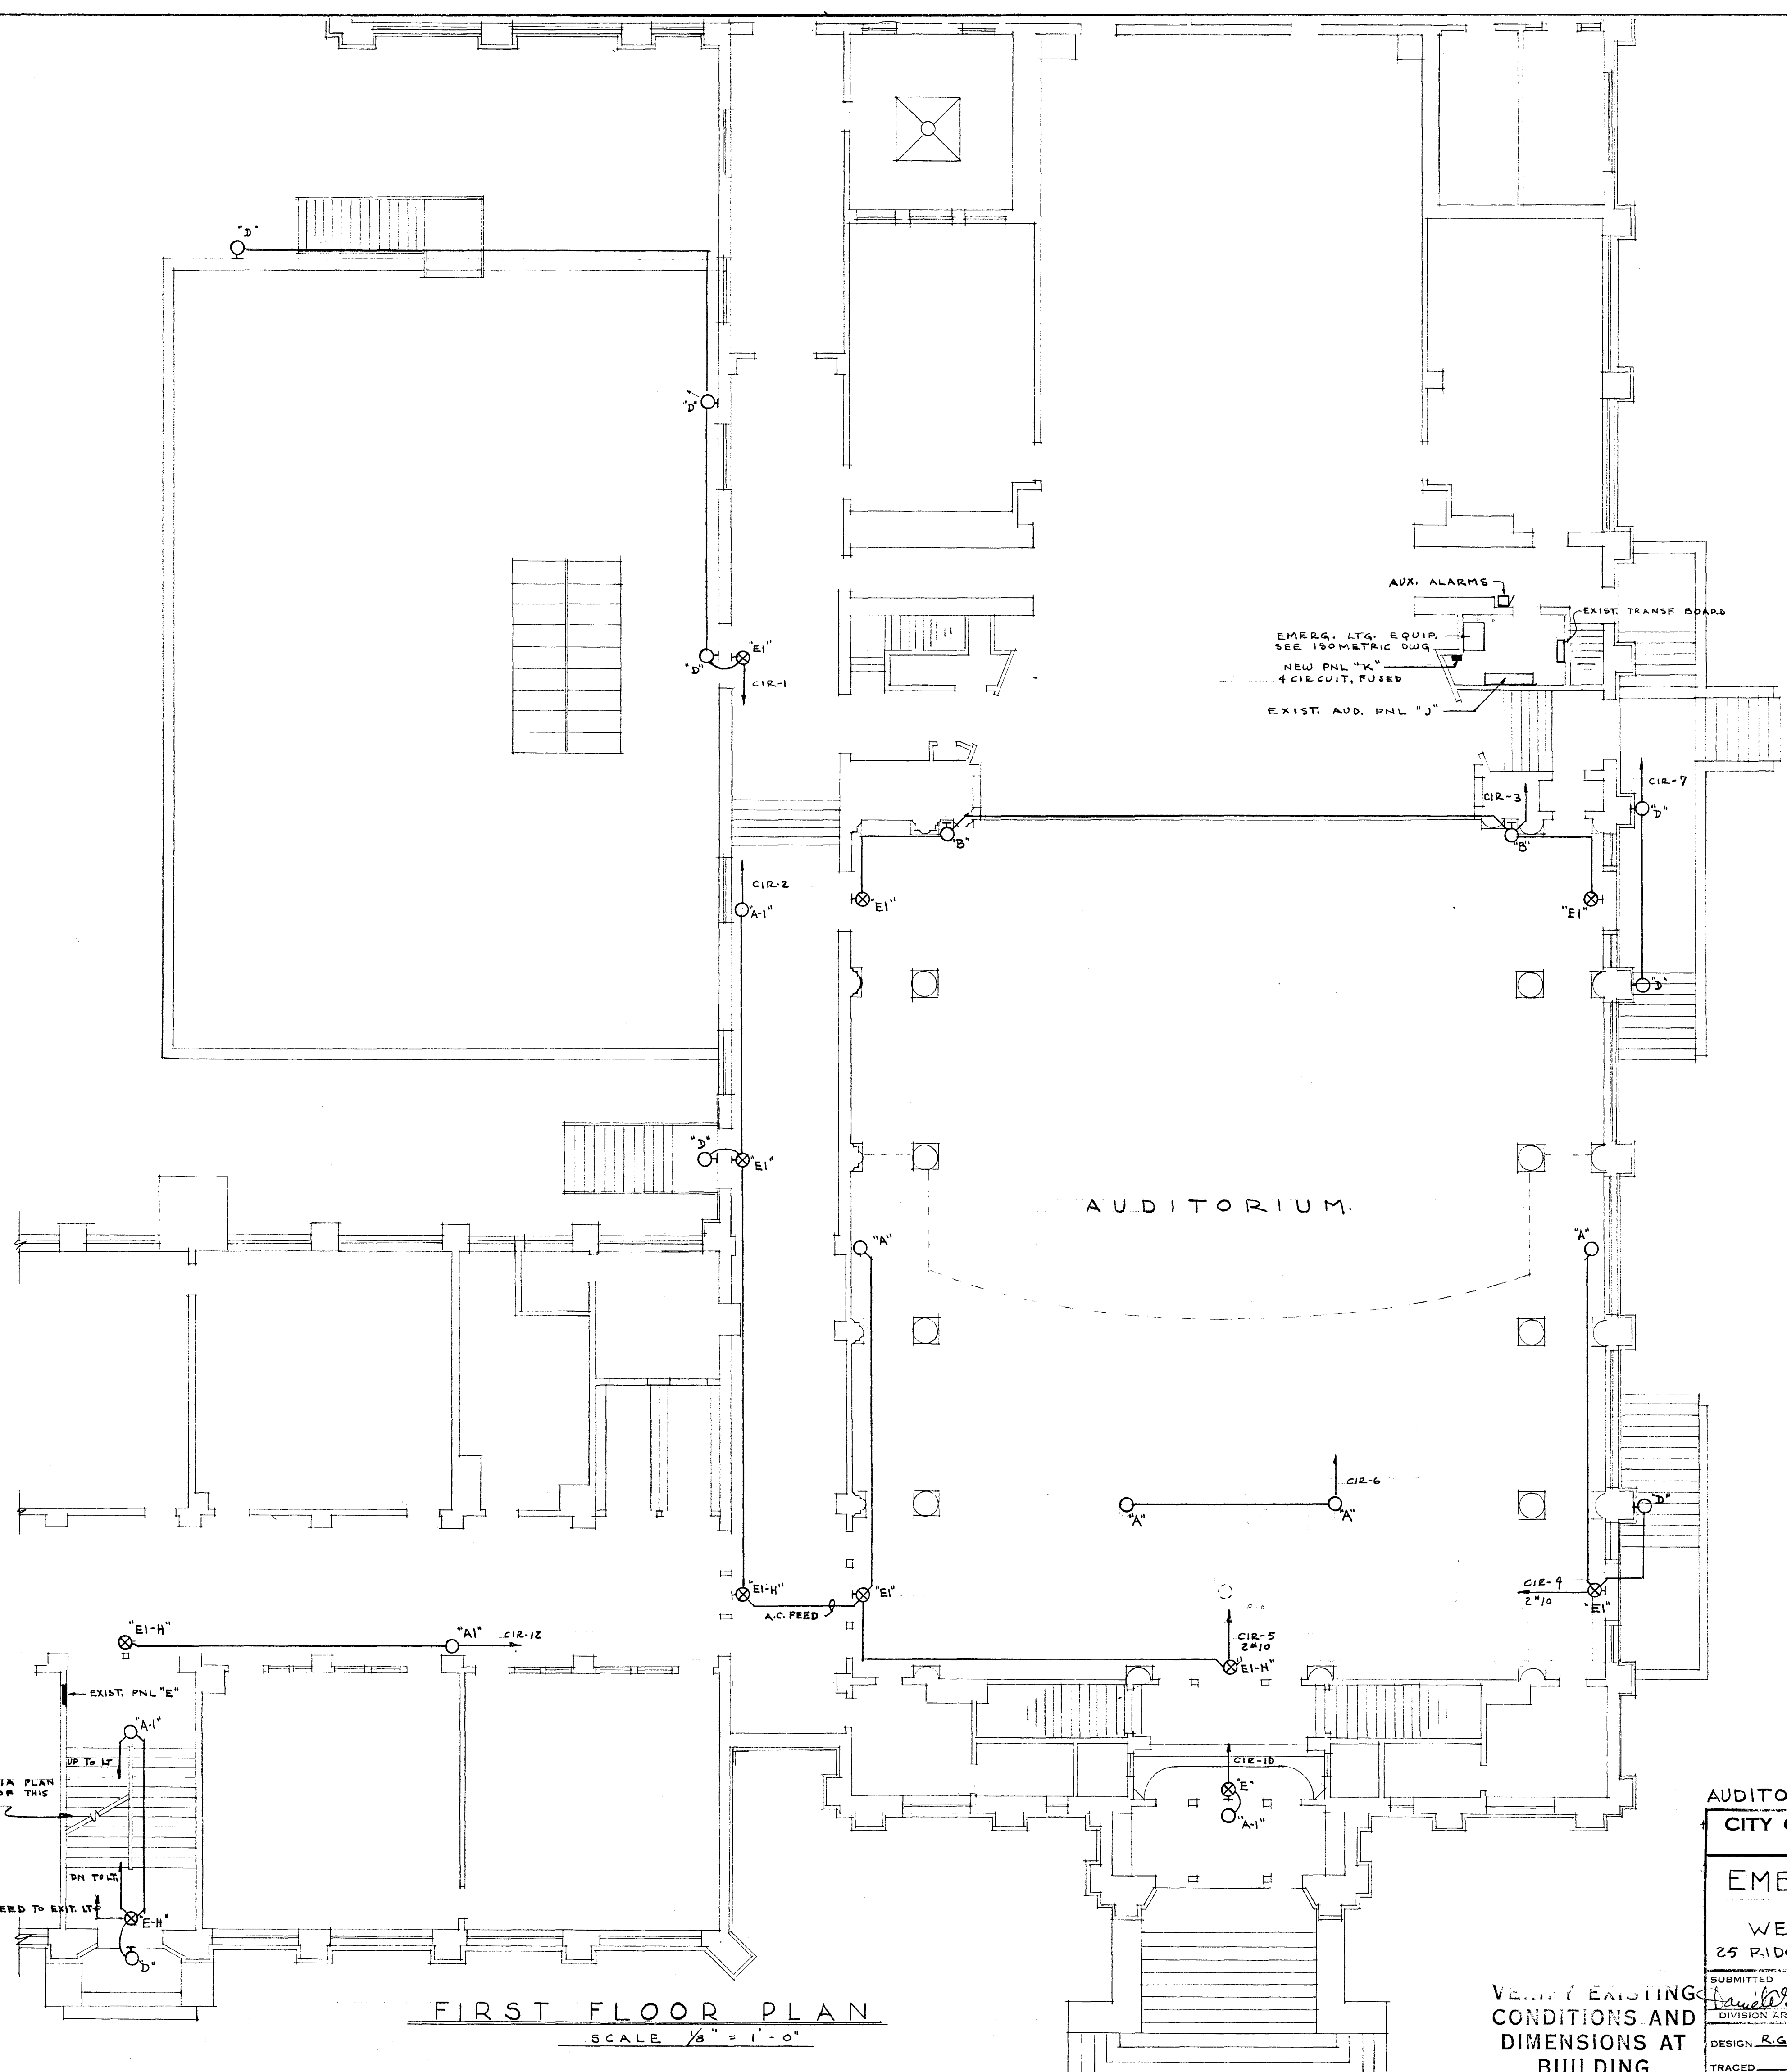

ISOMETRIC OF EMERGENCY EQUIPMENT
NO SCALE

NOTE: SEE CAFETERIA PLAN
FOR SSMT PLAN OF THIS
STAIRWELL

FIRST FLOOR PLAN
SCALE 1/8" = 1'-0"

VERIFY EXISTING
CONDITIONS AND
DIMENSIONS AT
BUILDING

AUDITORIUM		
CITY OF HARTFORD, CONNECTICUT DEPARTMENT OF ENGINEERING		
EMERGENCY LIGHTING FOR WEAVER HIGH SCHOOL 25 RIDGEFIELD ST., HARTFORD CONN.		
SUBMITTED DIVISION ARCHITECT DESIGN R.G.B.	RECOMMENDED CITY ARCHITECT DRAWN R.G.B.	APPROVED CITY ENGINEER DAYBOOK NO. 09611-K DATE MARCH 10, 1960