




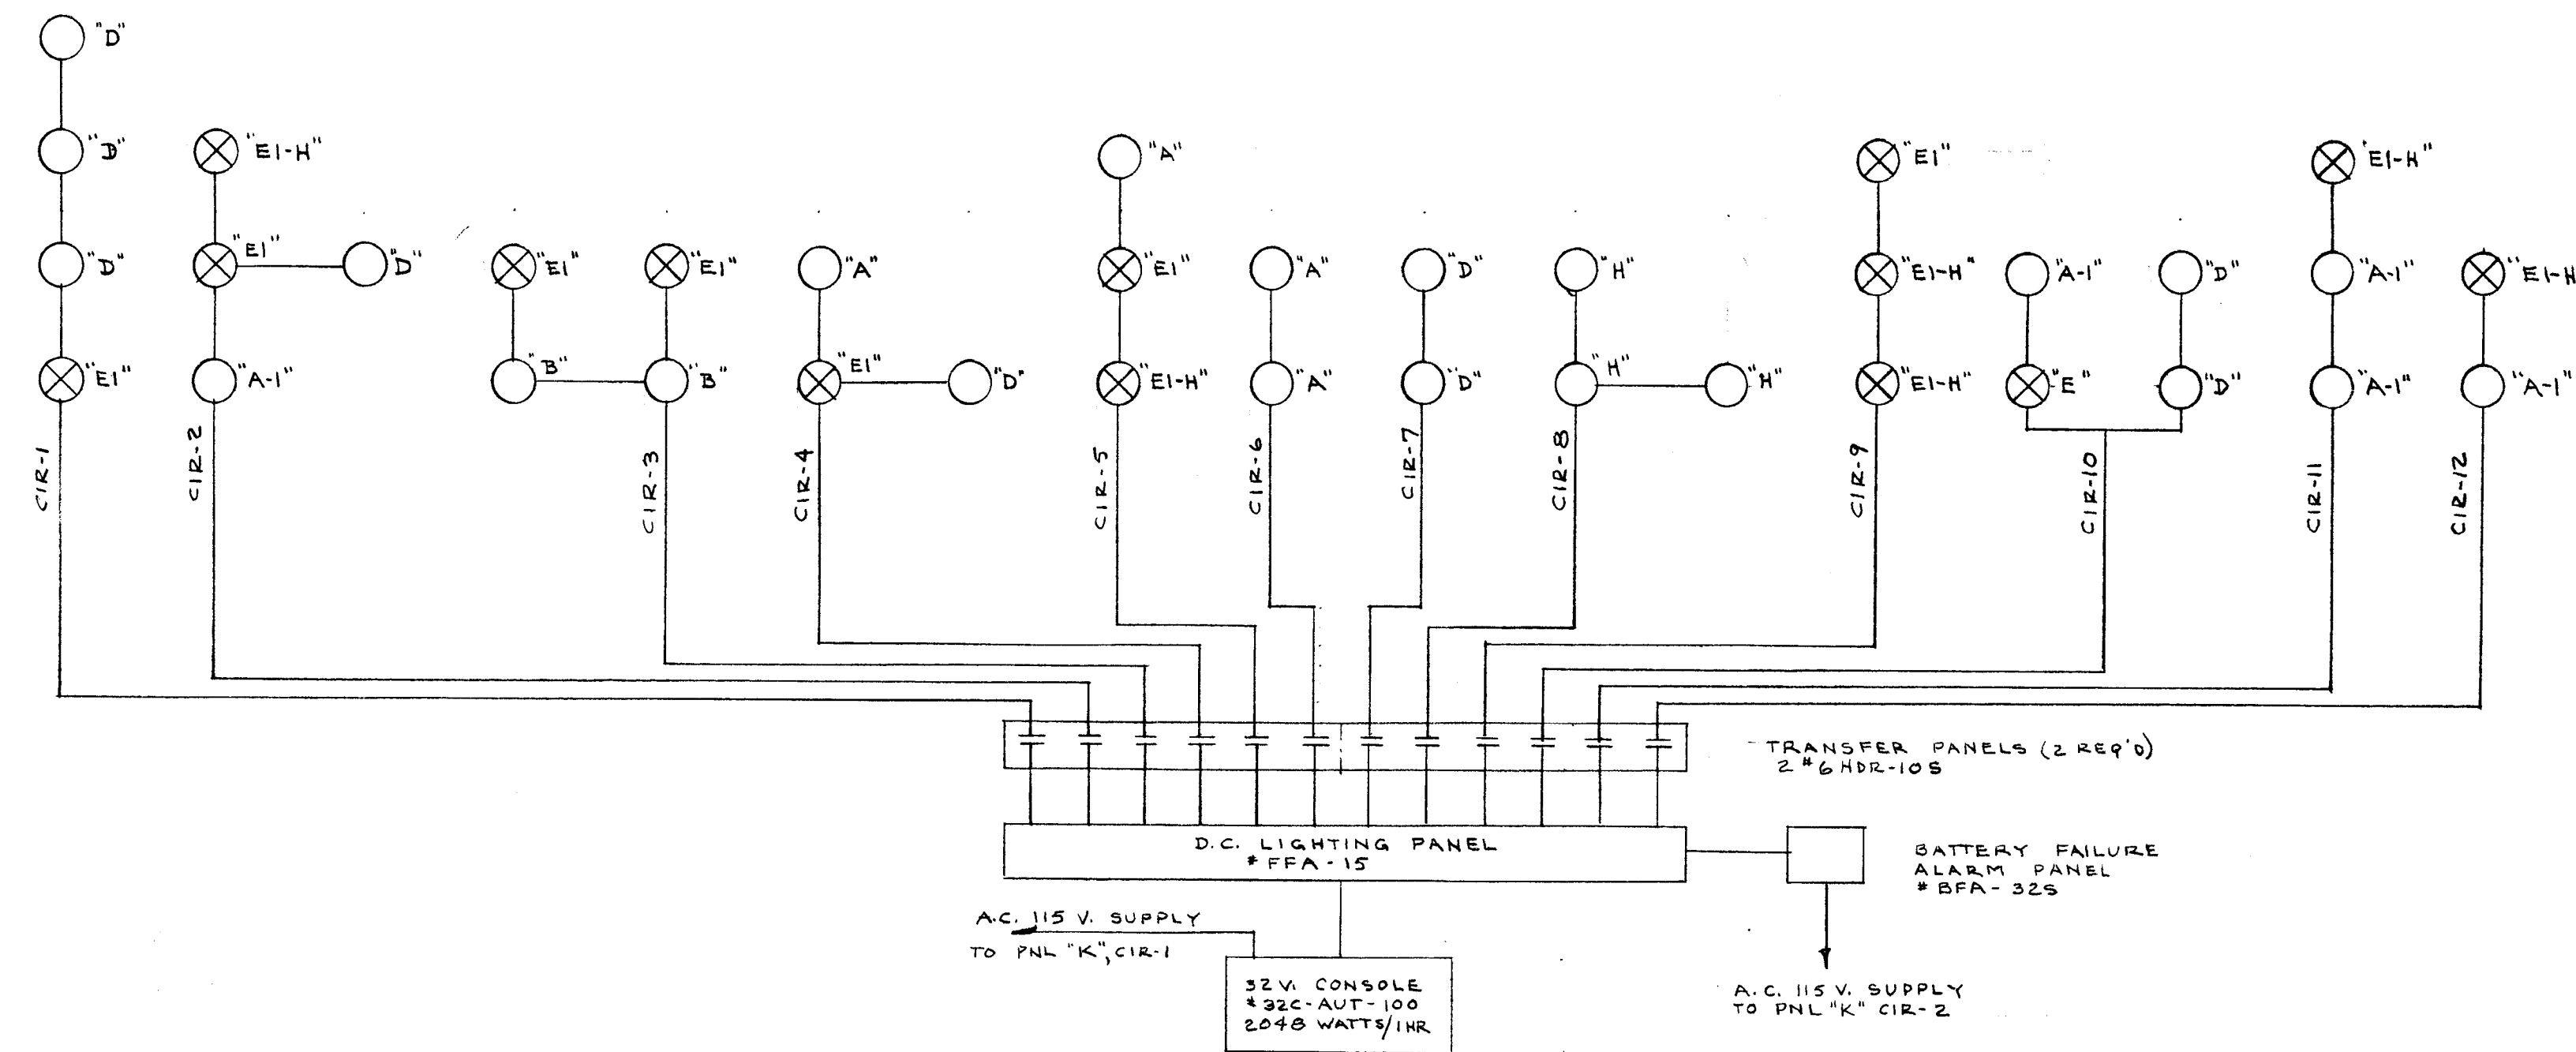


EMERGENCY LIGHTING SCHEMATIC
NO SCALE

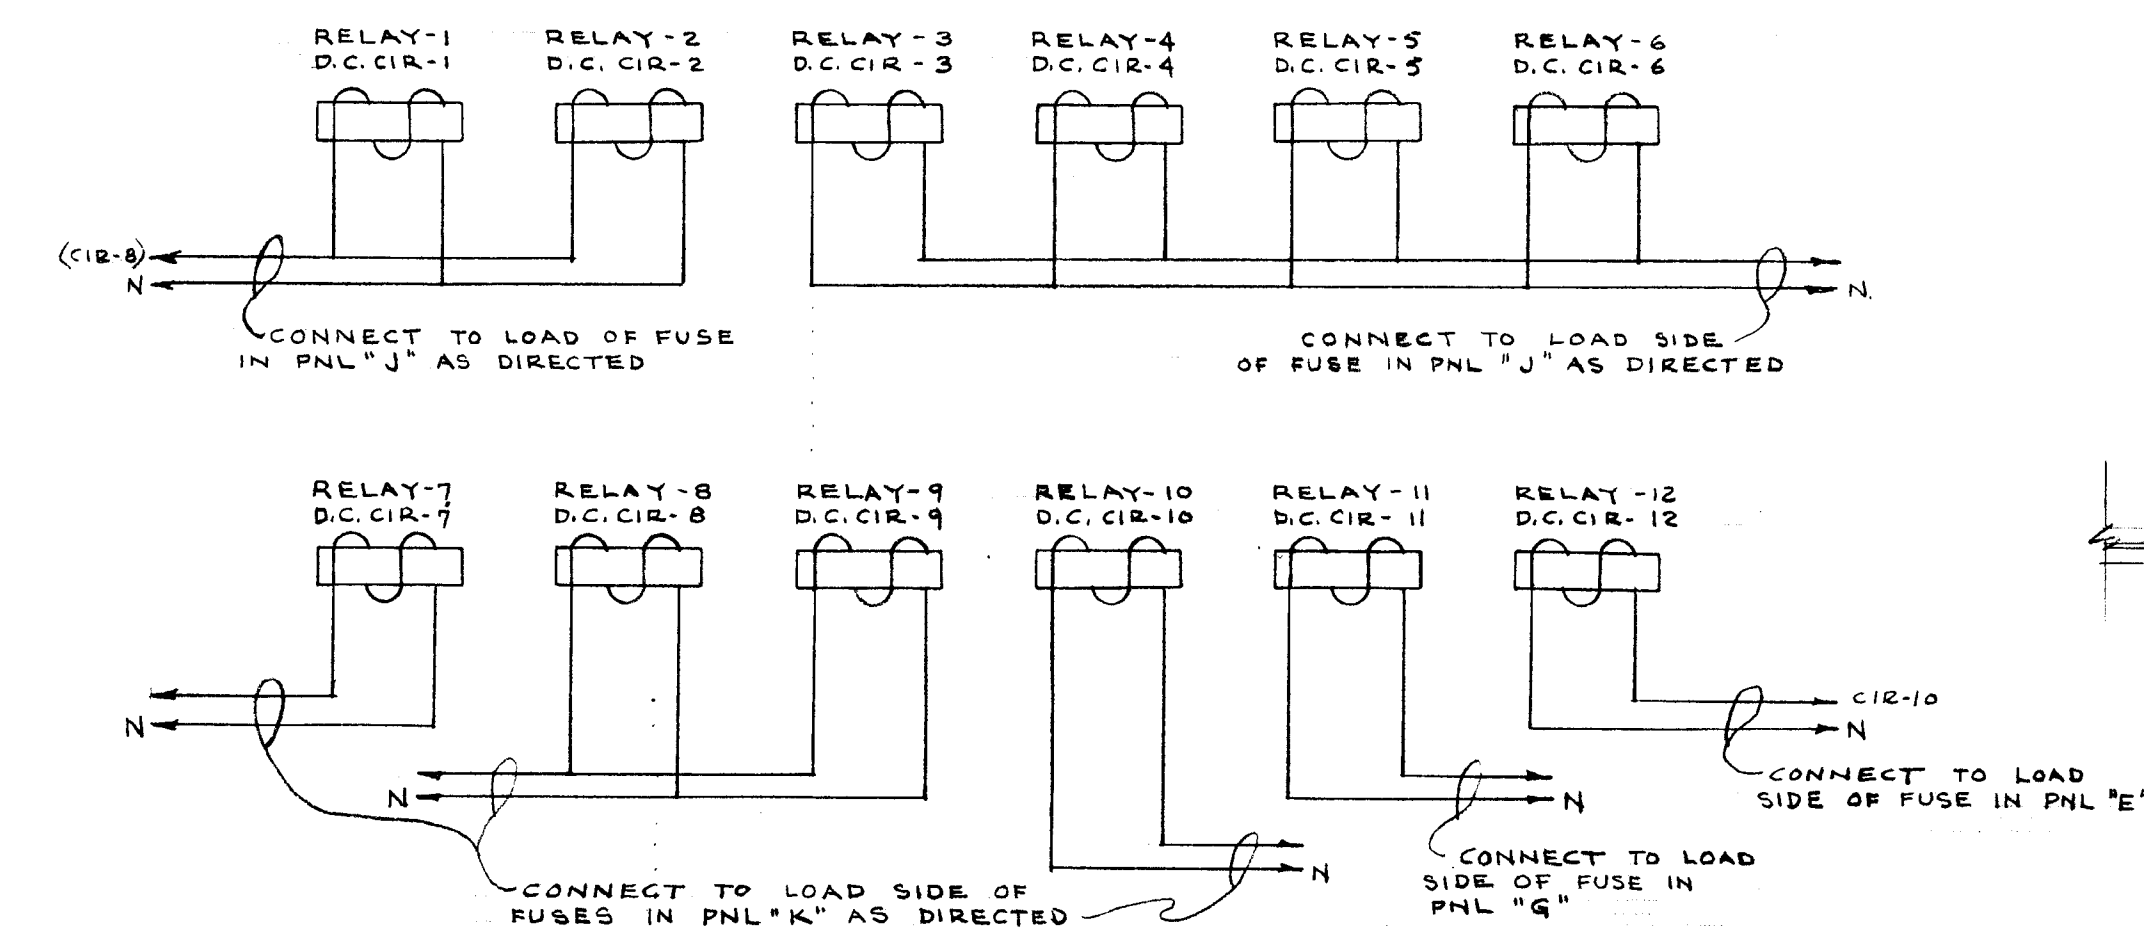

WIRING DIAGRAM OF A.C. CONTROL
FOR RELAYS IN TRANSFER PANELS
NO SCALE

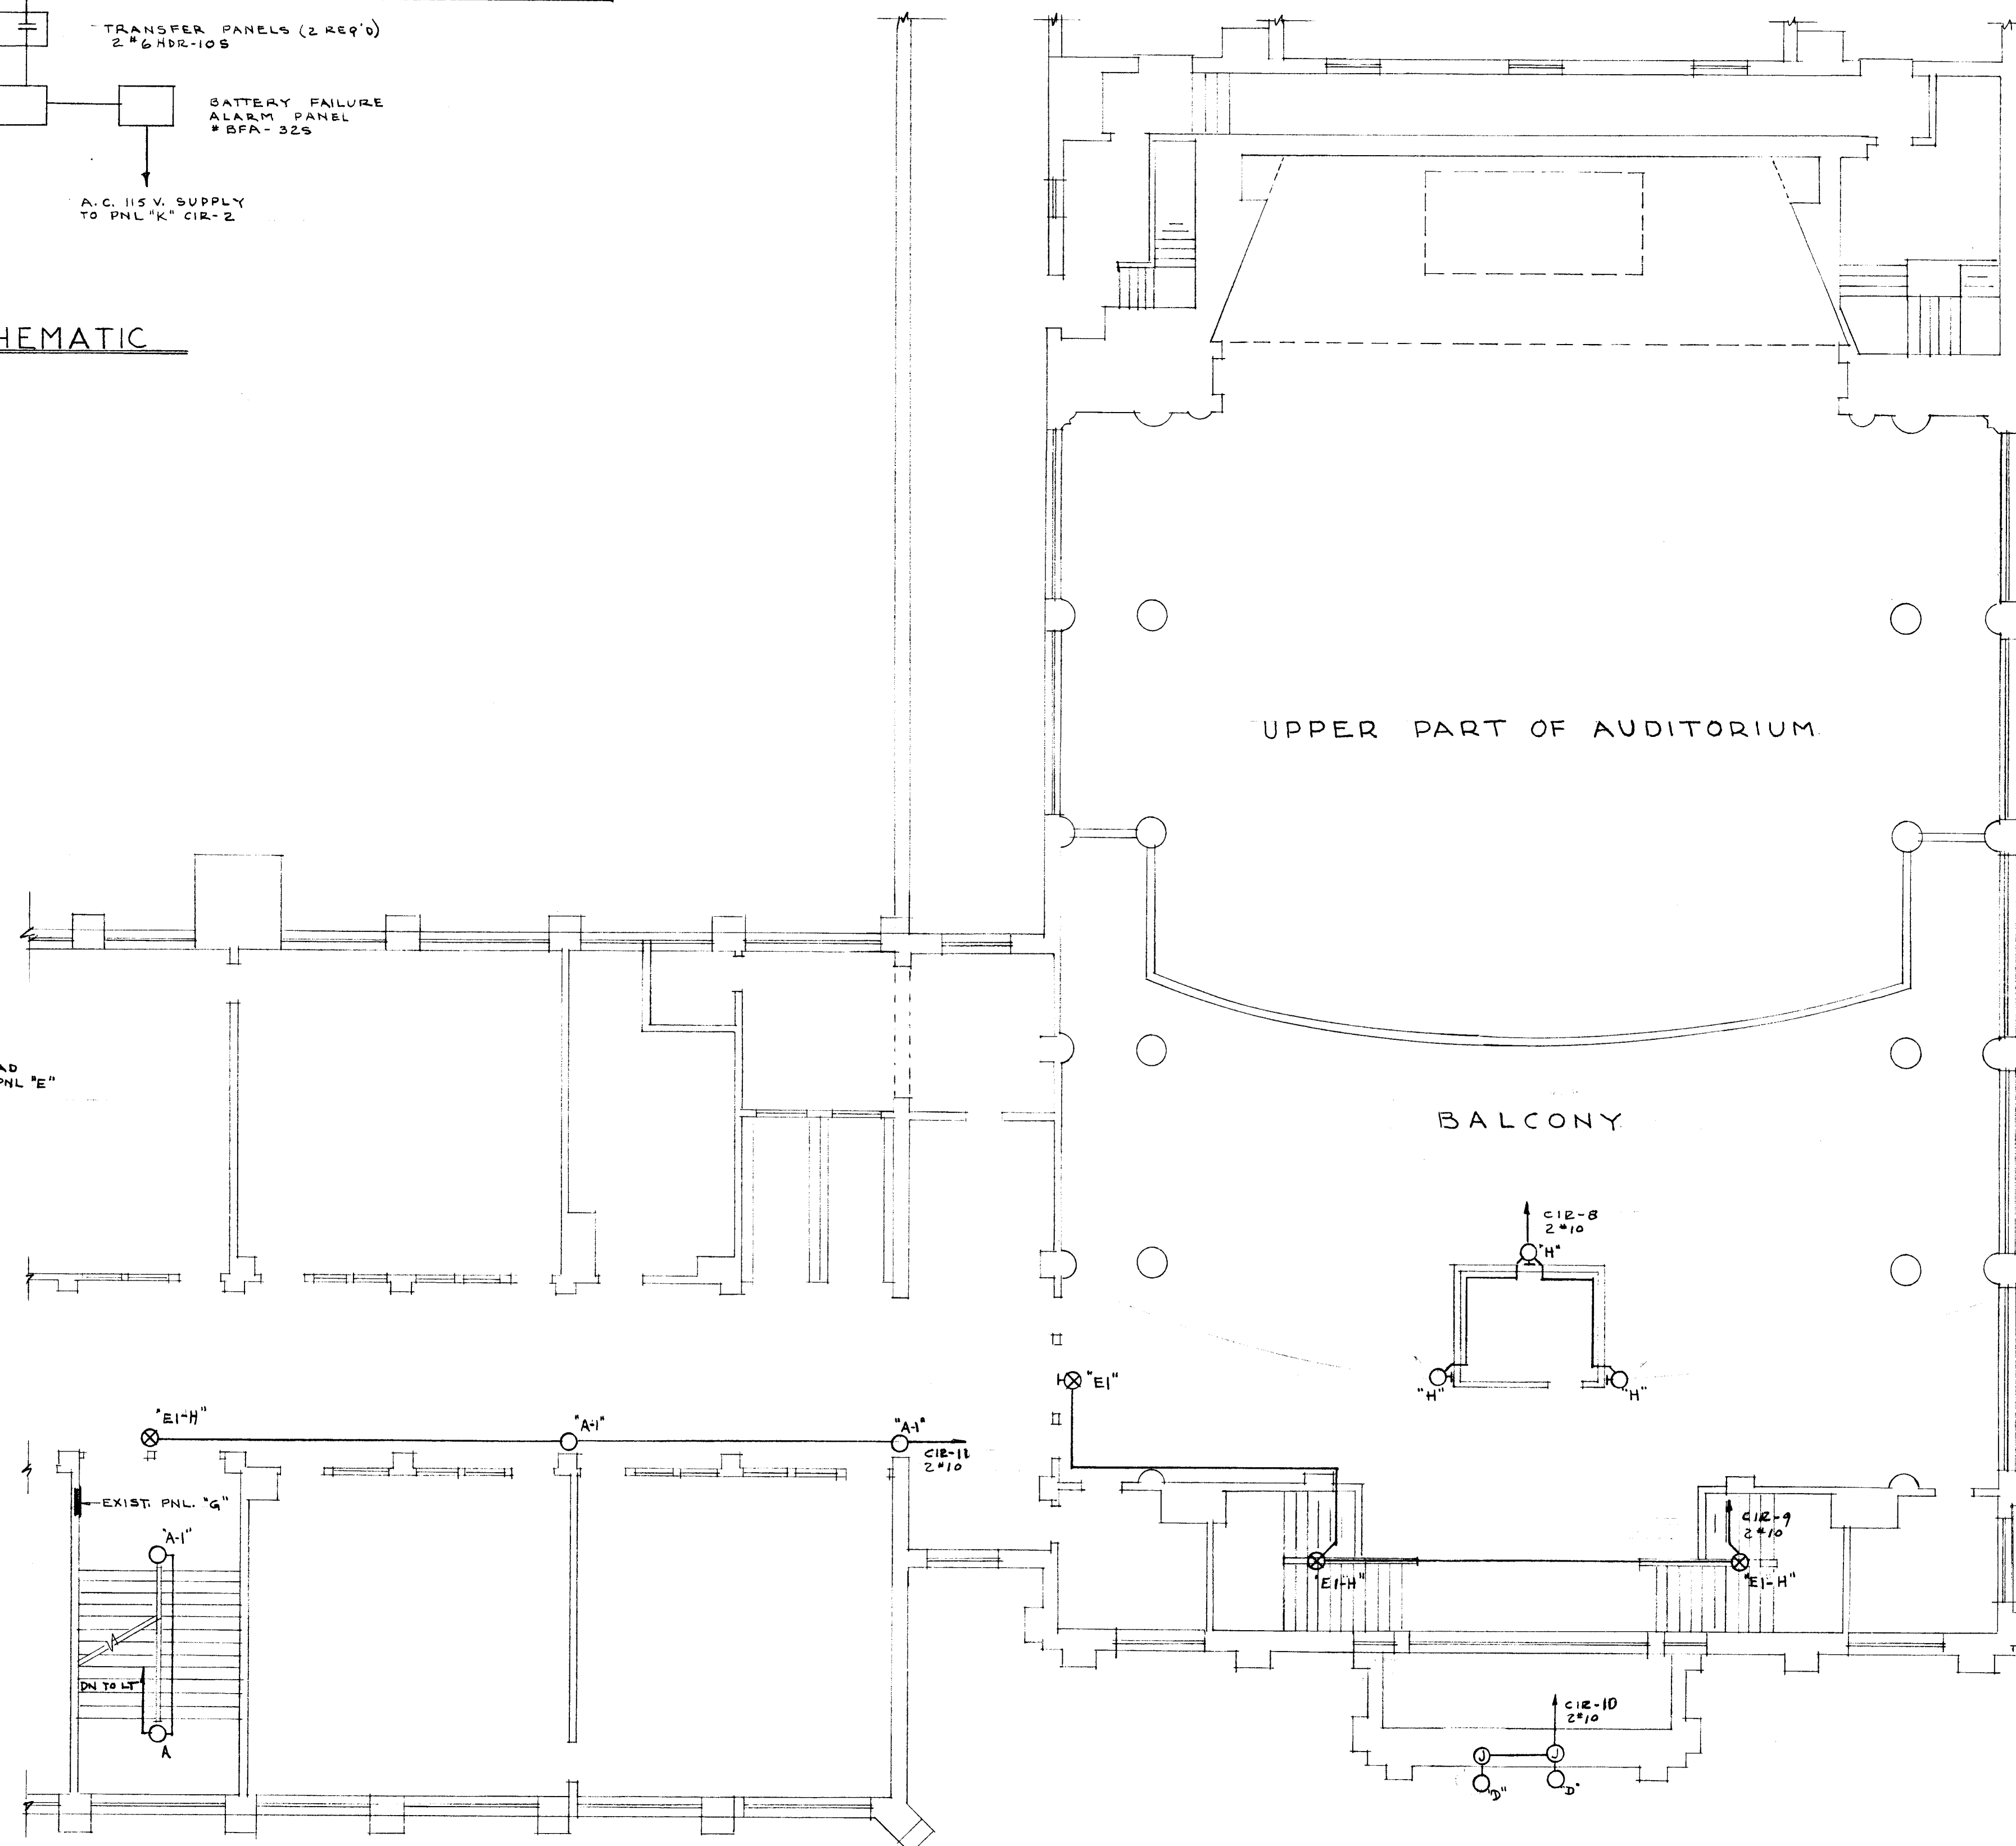

SECOND FLOOR PLAN
SCALE 1/8" = 1'-0"

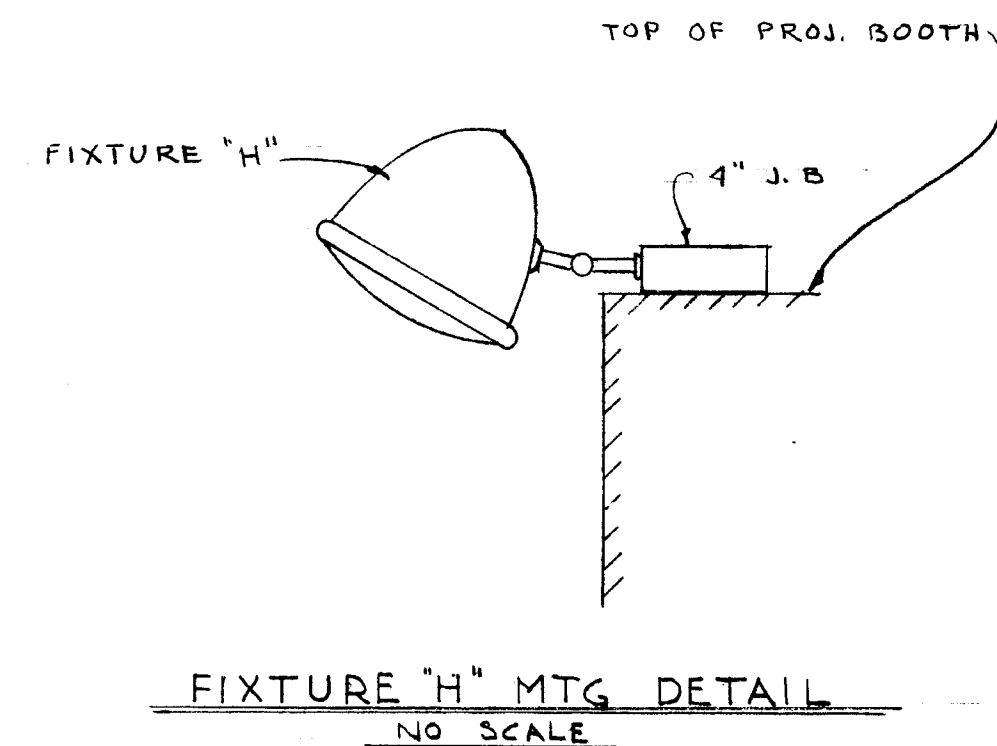

FIXTURE "H" MTG. DETAIL
NO SCALE

AUDITORIUM		
CITY OF HARTFORD, CONNECTICUT DEPARTMENT OF ENGINEERING		
EMERGENCY LIGHTING FOR WEAVER HIGH SCHOOL 25 RIDGEFIELD ST., HARTFORD CONN.		
SUBMITTED DIVISION ARCHITECT	RECOMMENDED CITY ARCHITECT	APPROVED CITY ENGINEER
DESIGN R.G.B.	DRAWN R.G.B.	DAYBOOK NO. 09611-L
TRACED	CHECK	DATE MARCH 10, 1960

VERIFY EXISTING
CONDITIONS AND
DIMENSIONS AT
BUILDING