




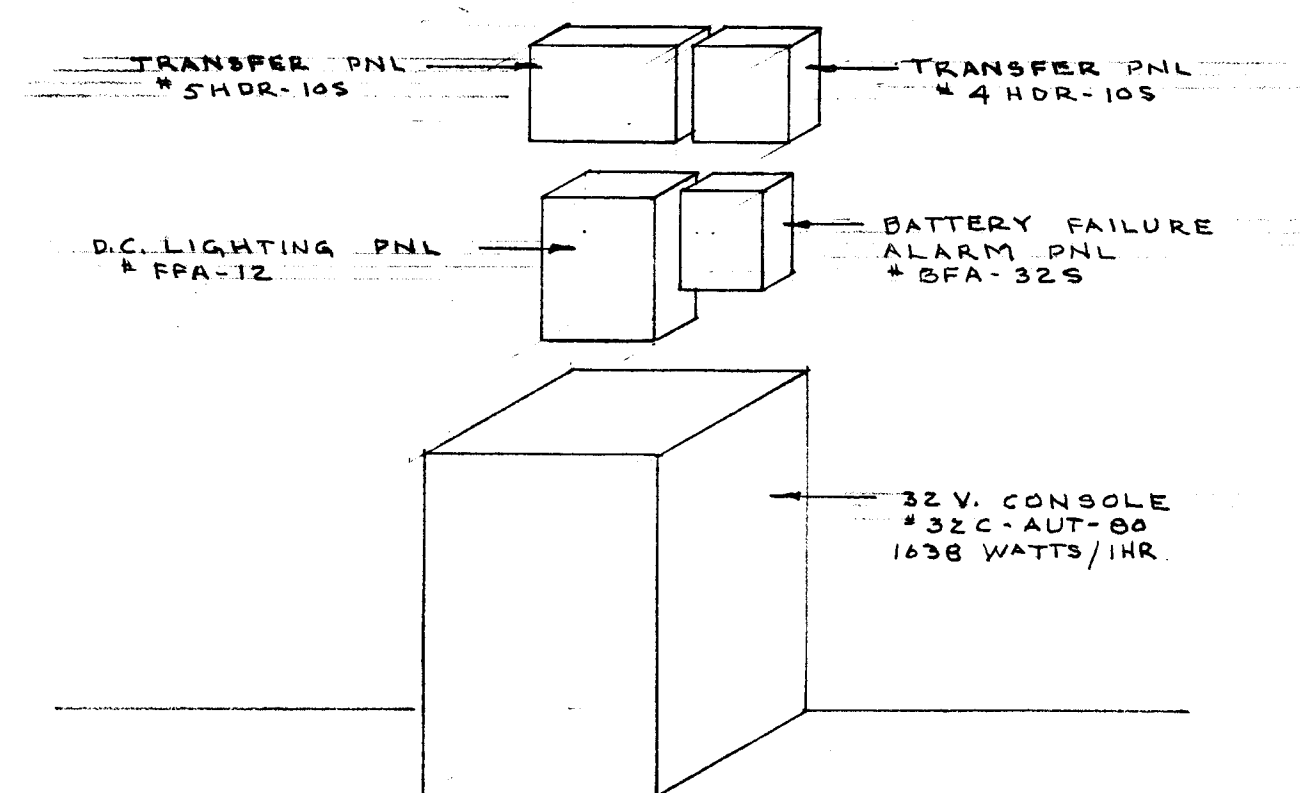


ISOMETRIC OF EMERGENCY EQUIPMENT
NO SCALE

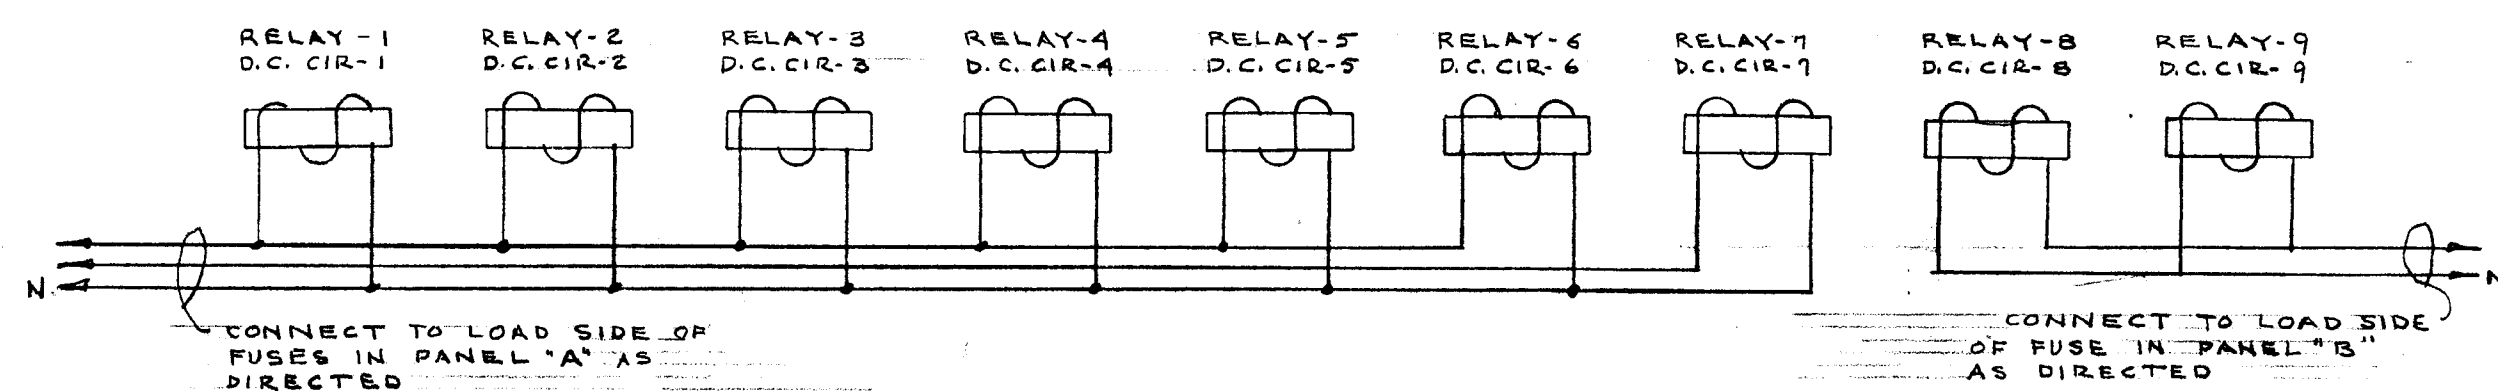


WIRING DIAGRAM OF A.C. CONTROL FOR RELAYS IN TRANSFER PANELS
NO SCALE

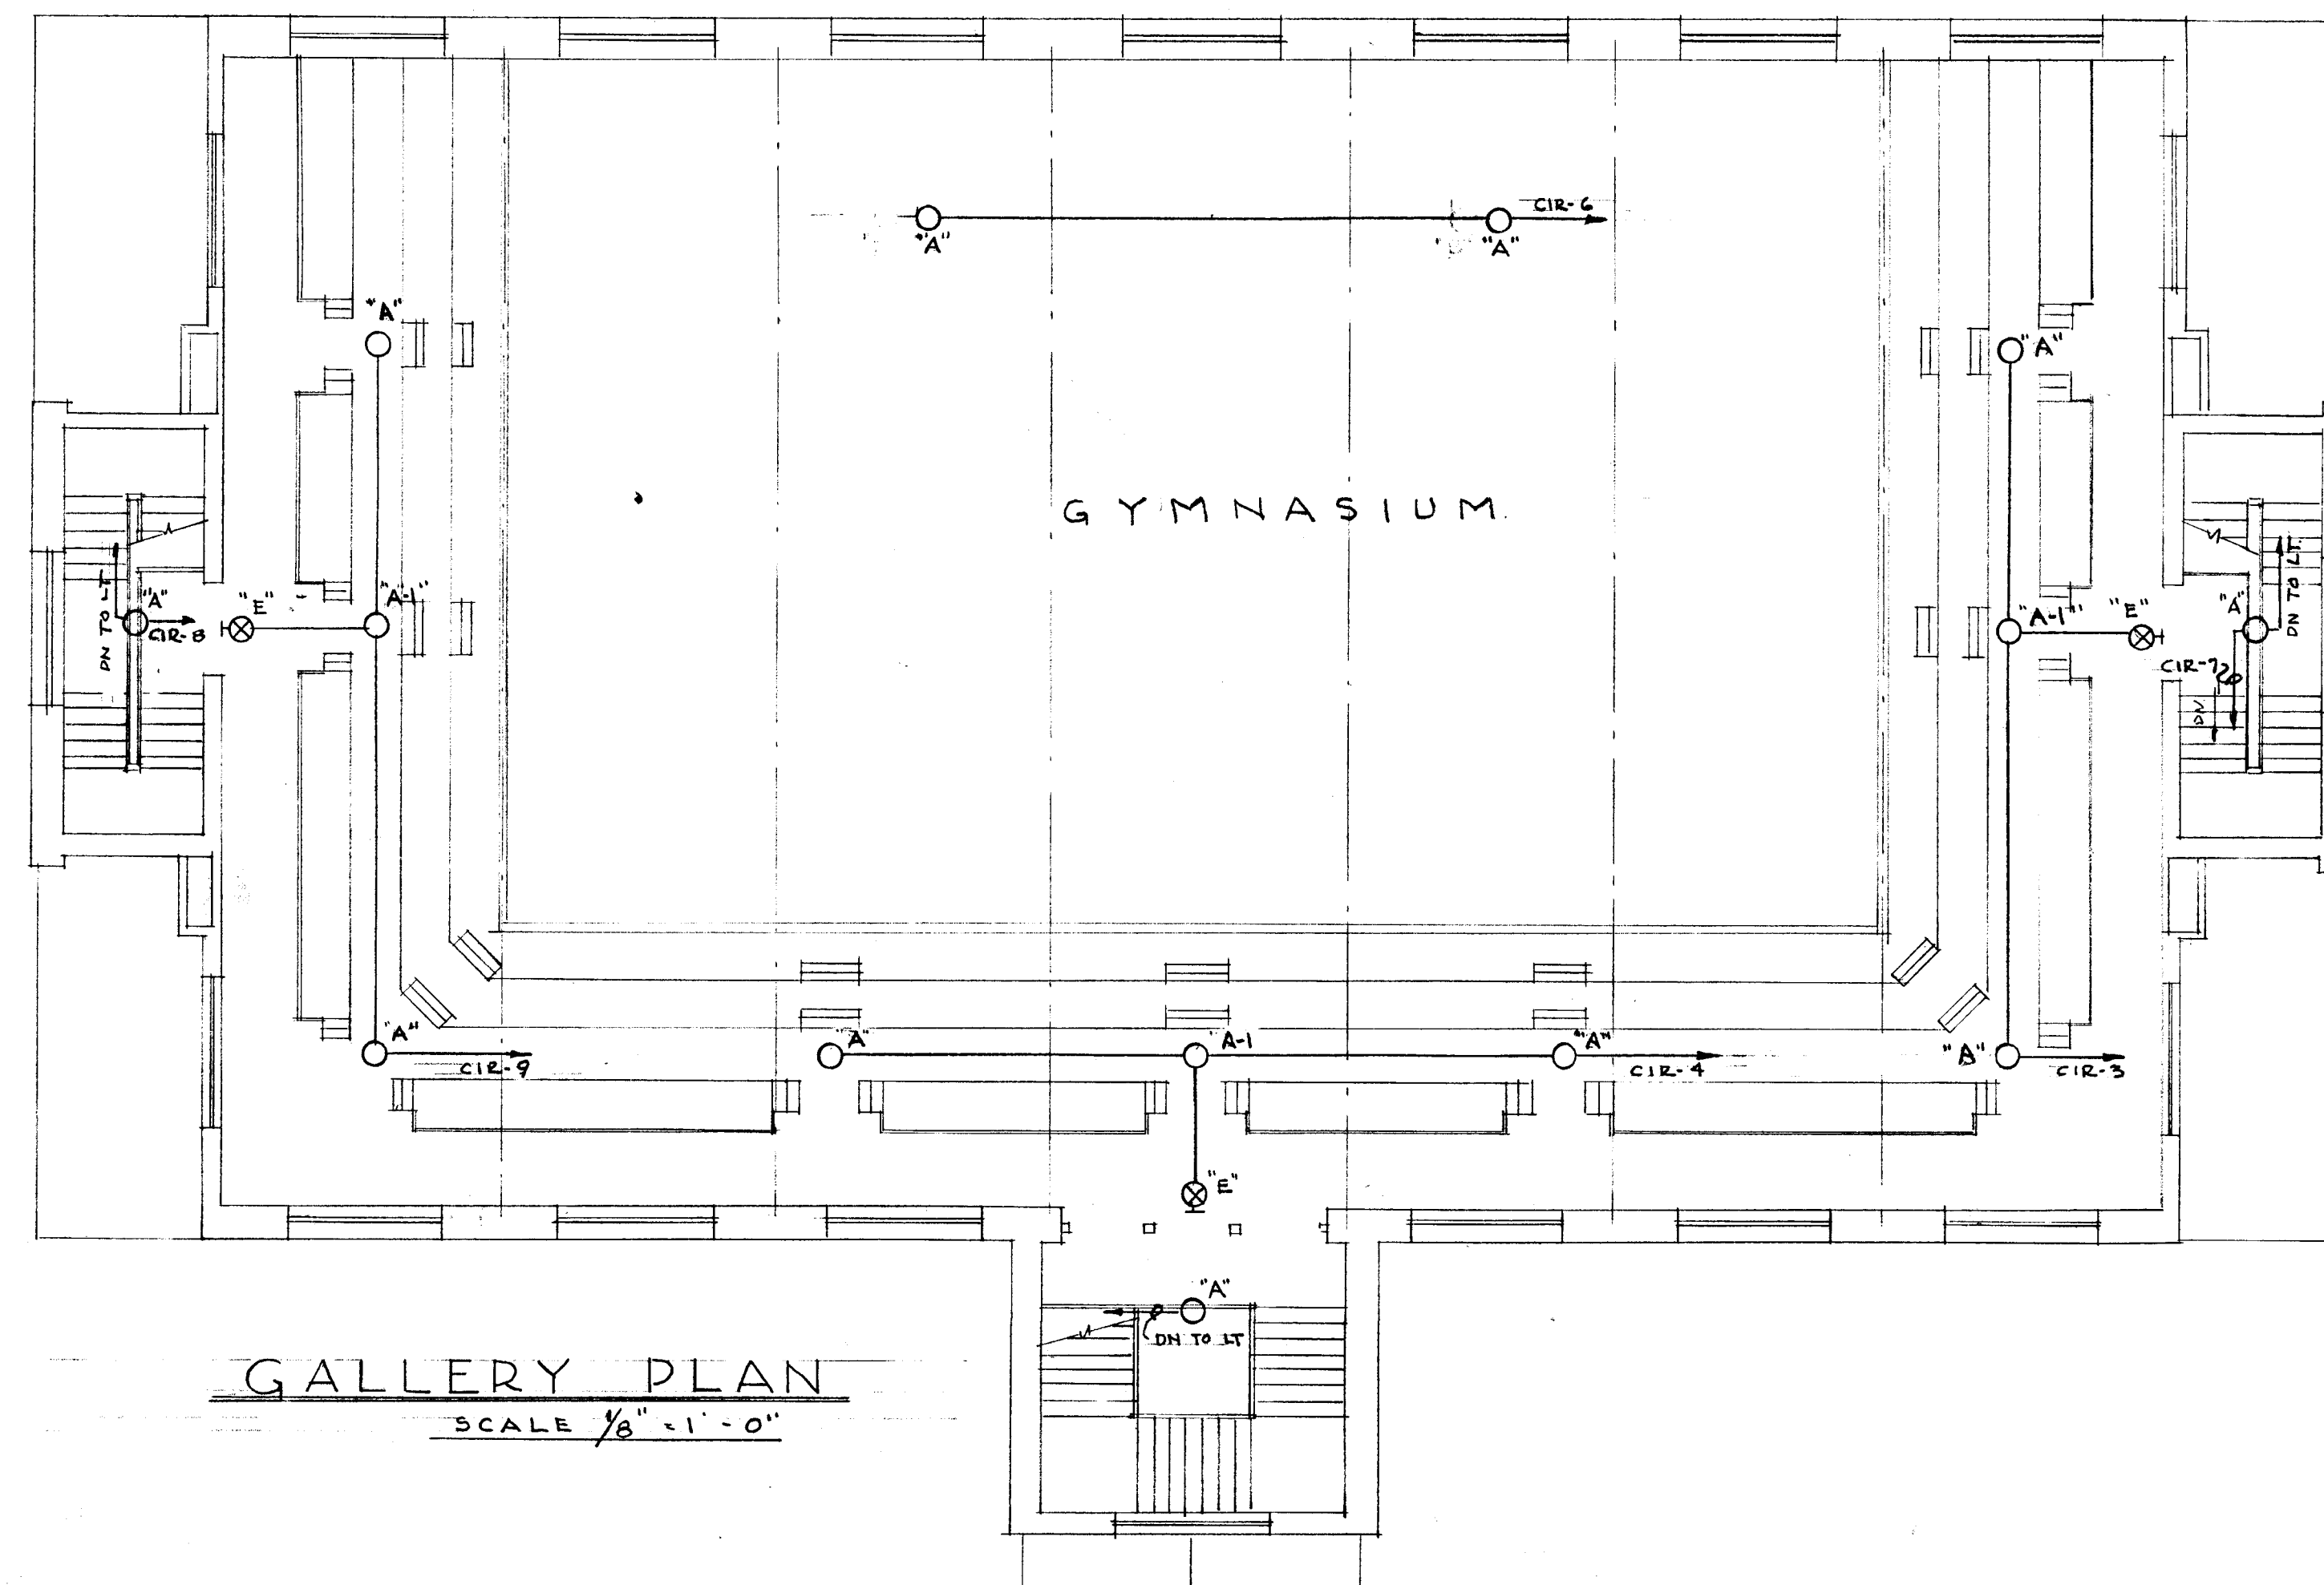

GALLERY PLAN
SCALE 1/8" = 1'-0"

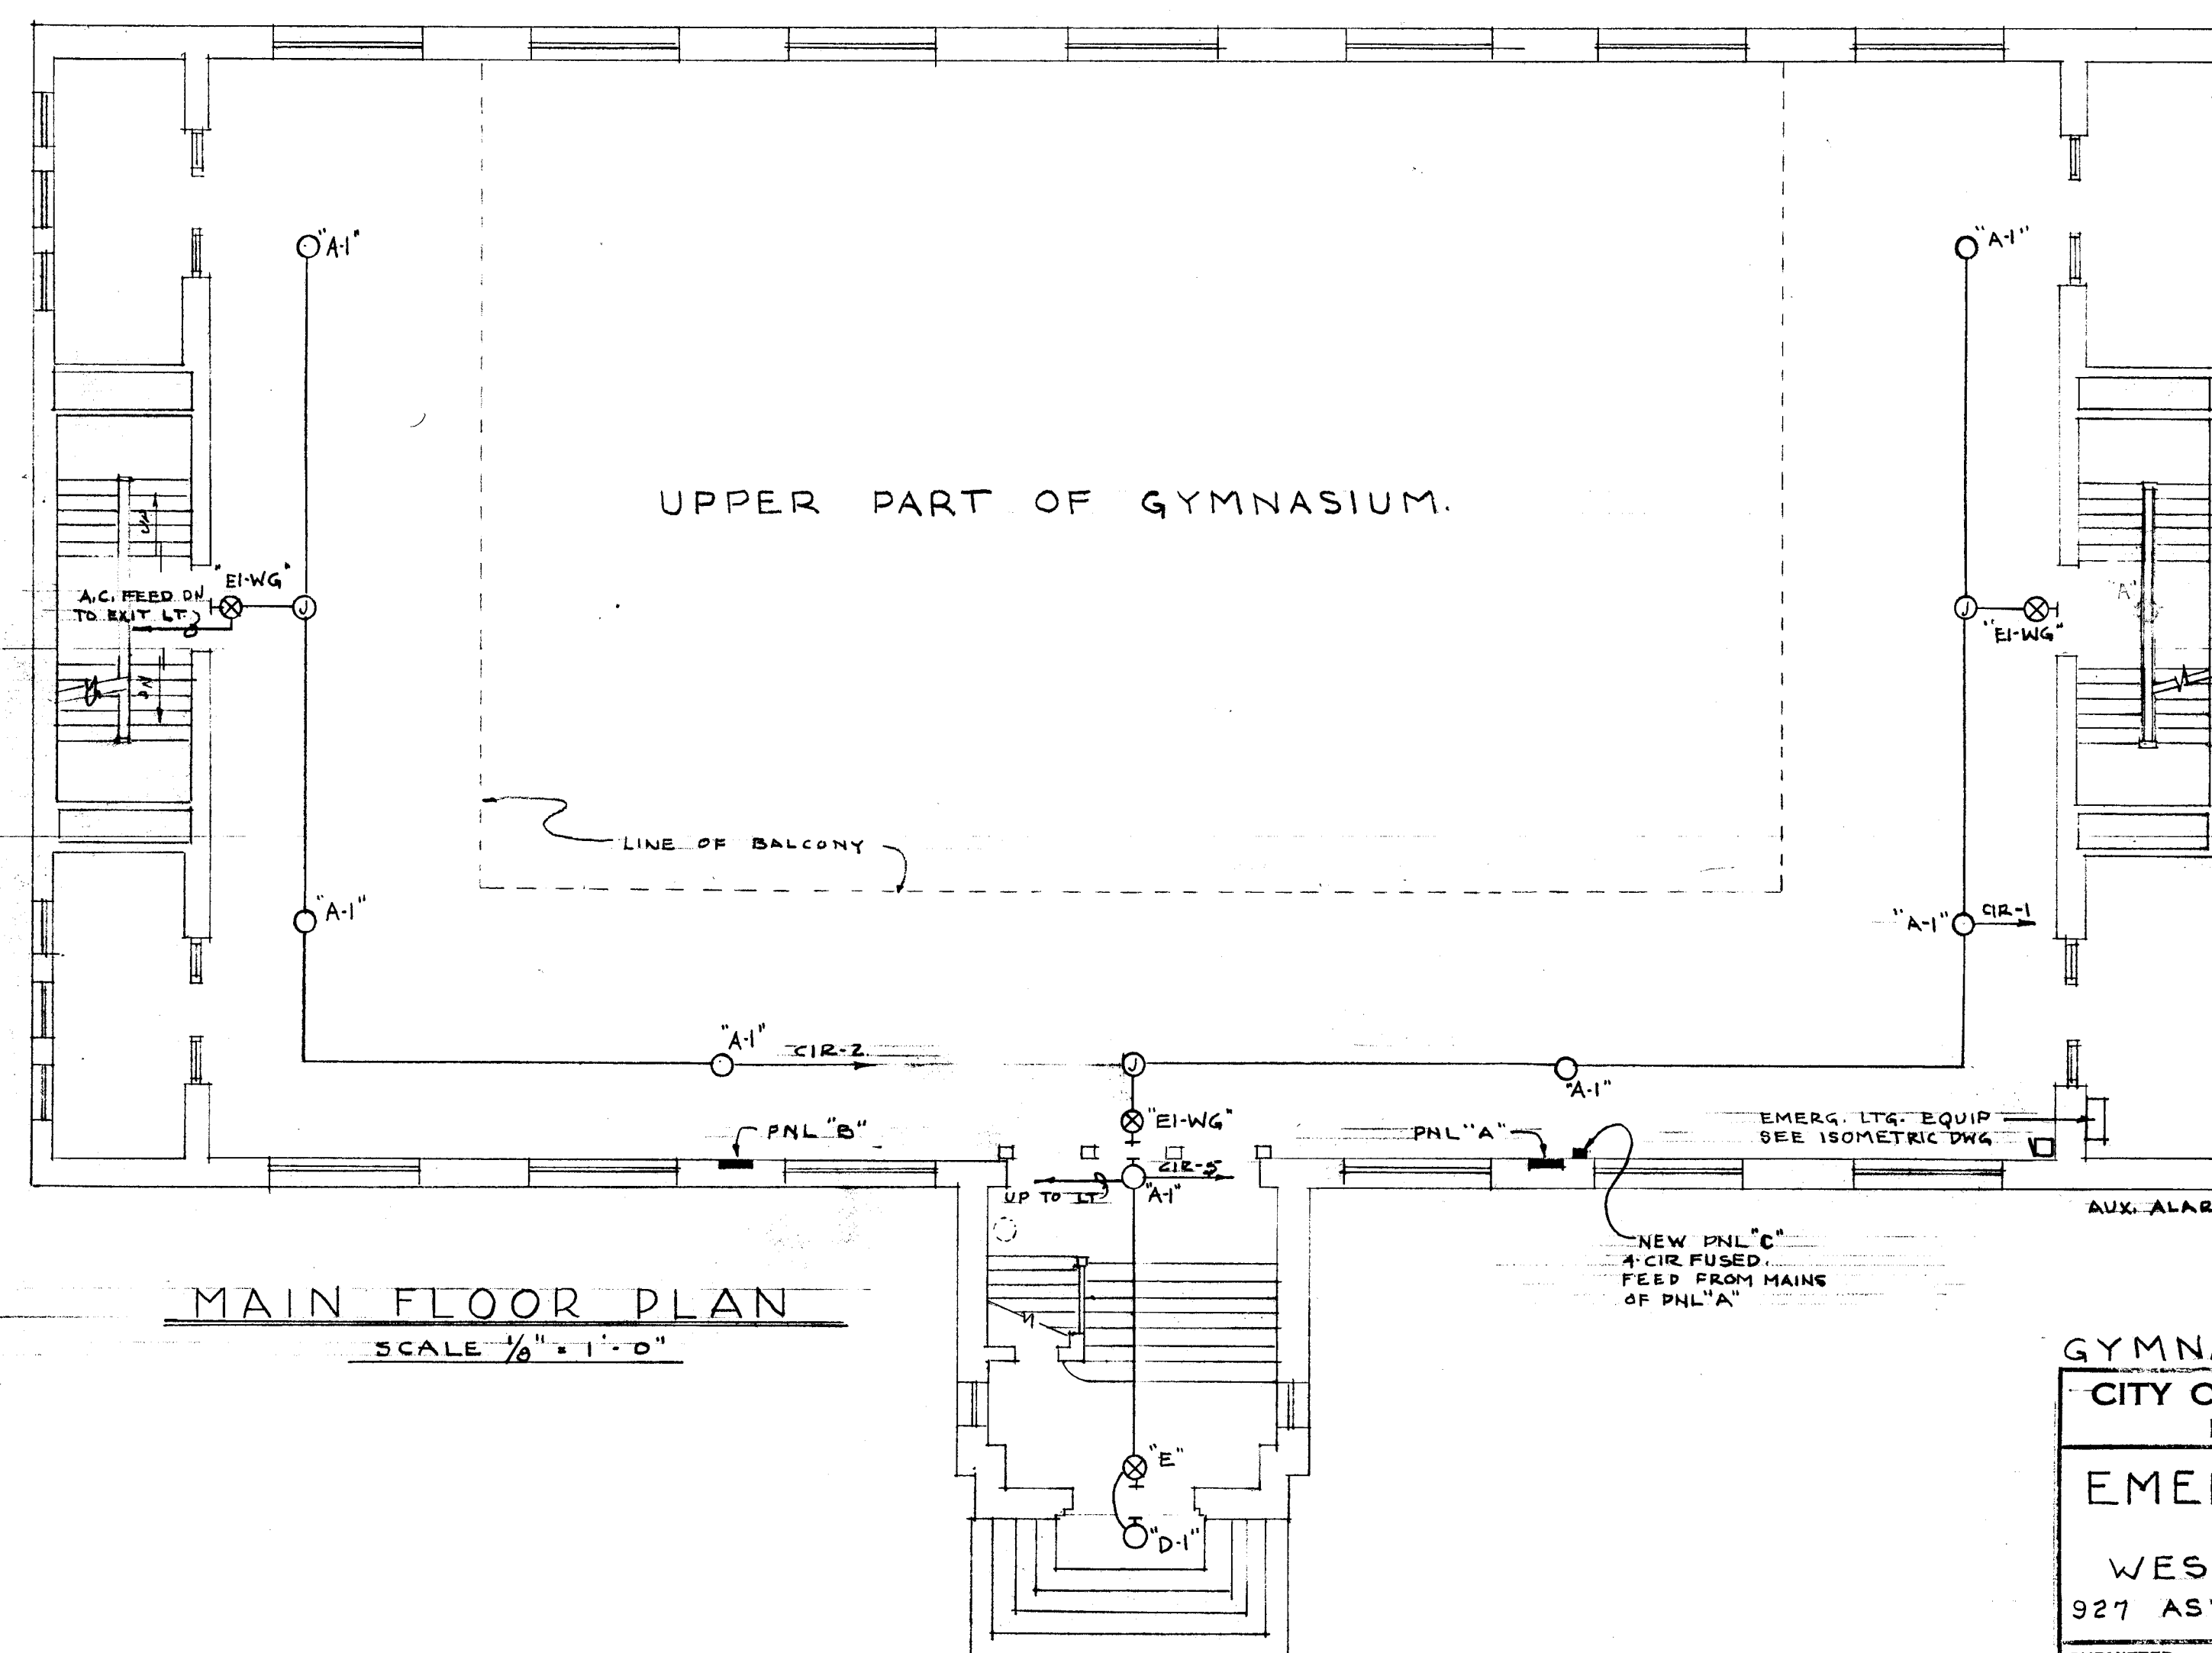


MAIN FLOOR PLAN
SCALE 1/8" = 1'-0"

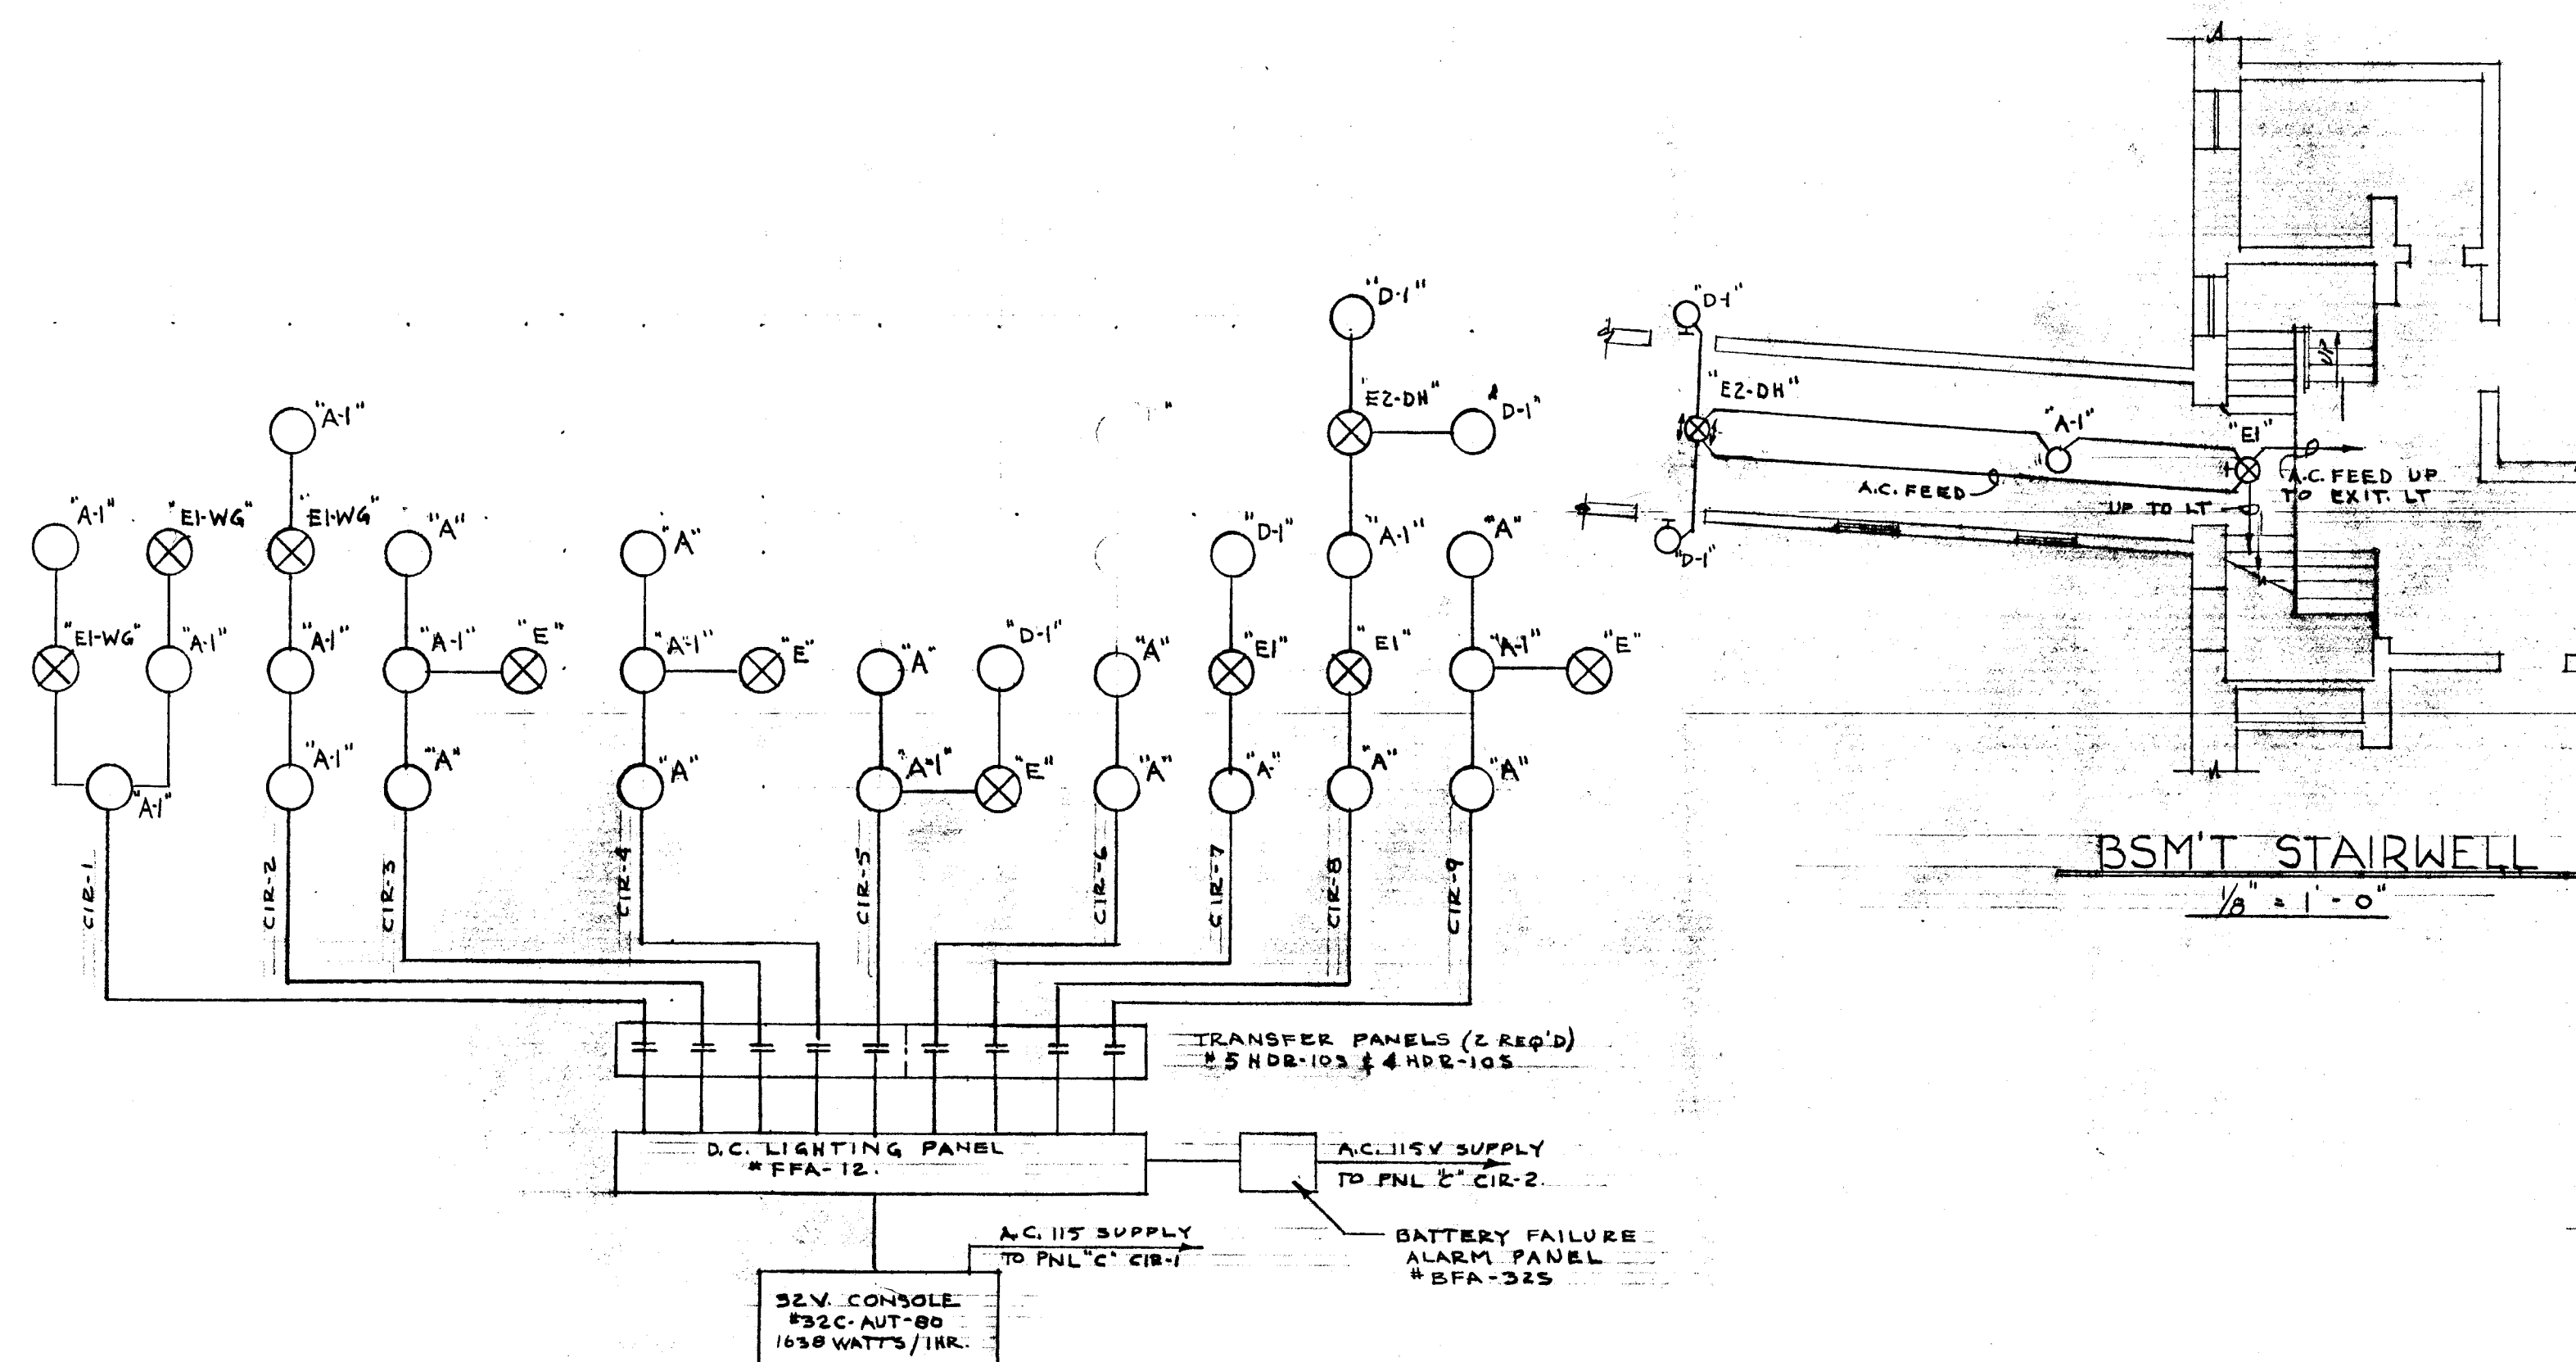

EMERGENCY LIGHTING SCHEMATIC
NO SCALE

BSM'T STAIRWELL
1/8" = 1'-0"

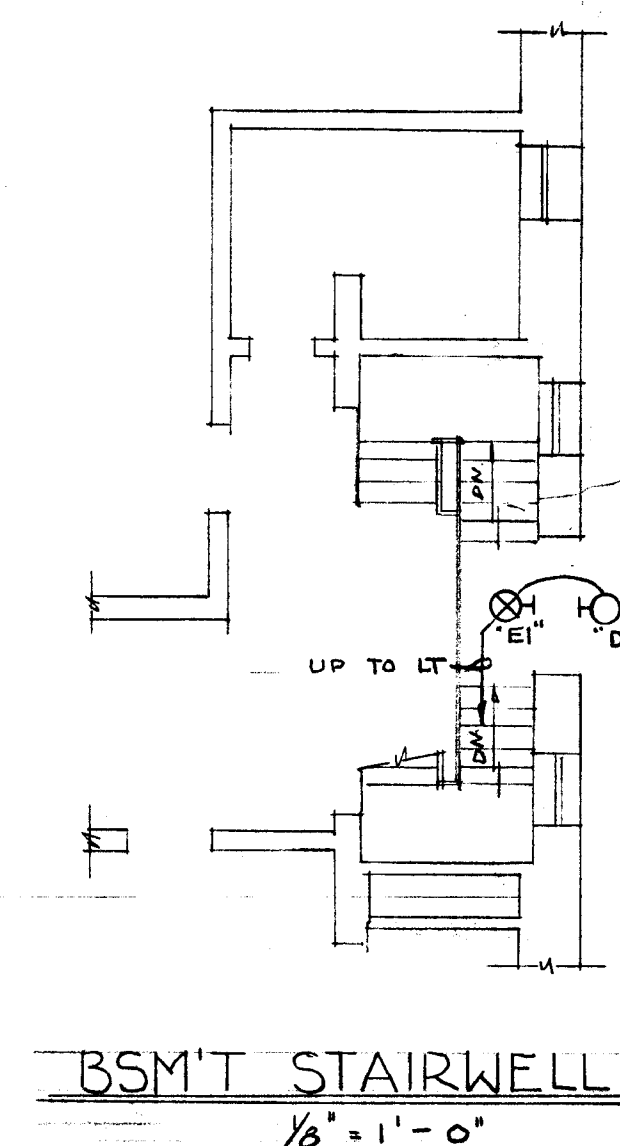

BSM'T STAIRWELL
1/8" = 1'-0"

GYMNASIUM. CITY OF HARTFORD, CONNECTICUT DEPARTMENT OF ENGINEERING EMERGENCY LIGHTING FOR WEST MIDDLE SCHOOL. 927 ASYLUM AV., HARTFORD CONN.		
SUBMITTED	RECOMMENDED	APPROVED
<i>Donald A. Brown</i>	<i>James O. Tassell</i>	<i>William J. Dillay</i>
DIVISION ARCHITECT	CITY ARCHITECT	CITY ENGINEER
DESIGN R.G.B.	DRAWN R.G.B.	DAYBOOK NO. 09612-J
TRACED	CHECK	DATE MARCH 10, 1960

VERIFY EXISTING
CONDITIONS AND
DIMENSIONS AT
BUILDING

10

SB
VE