



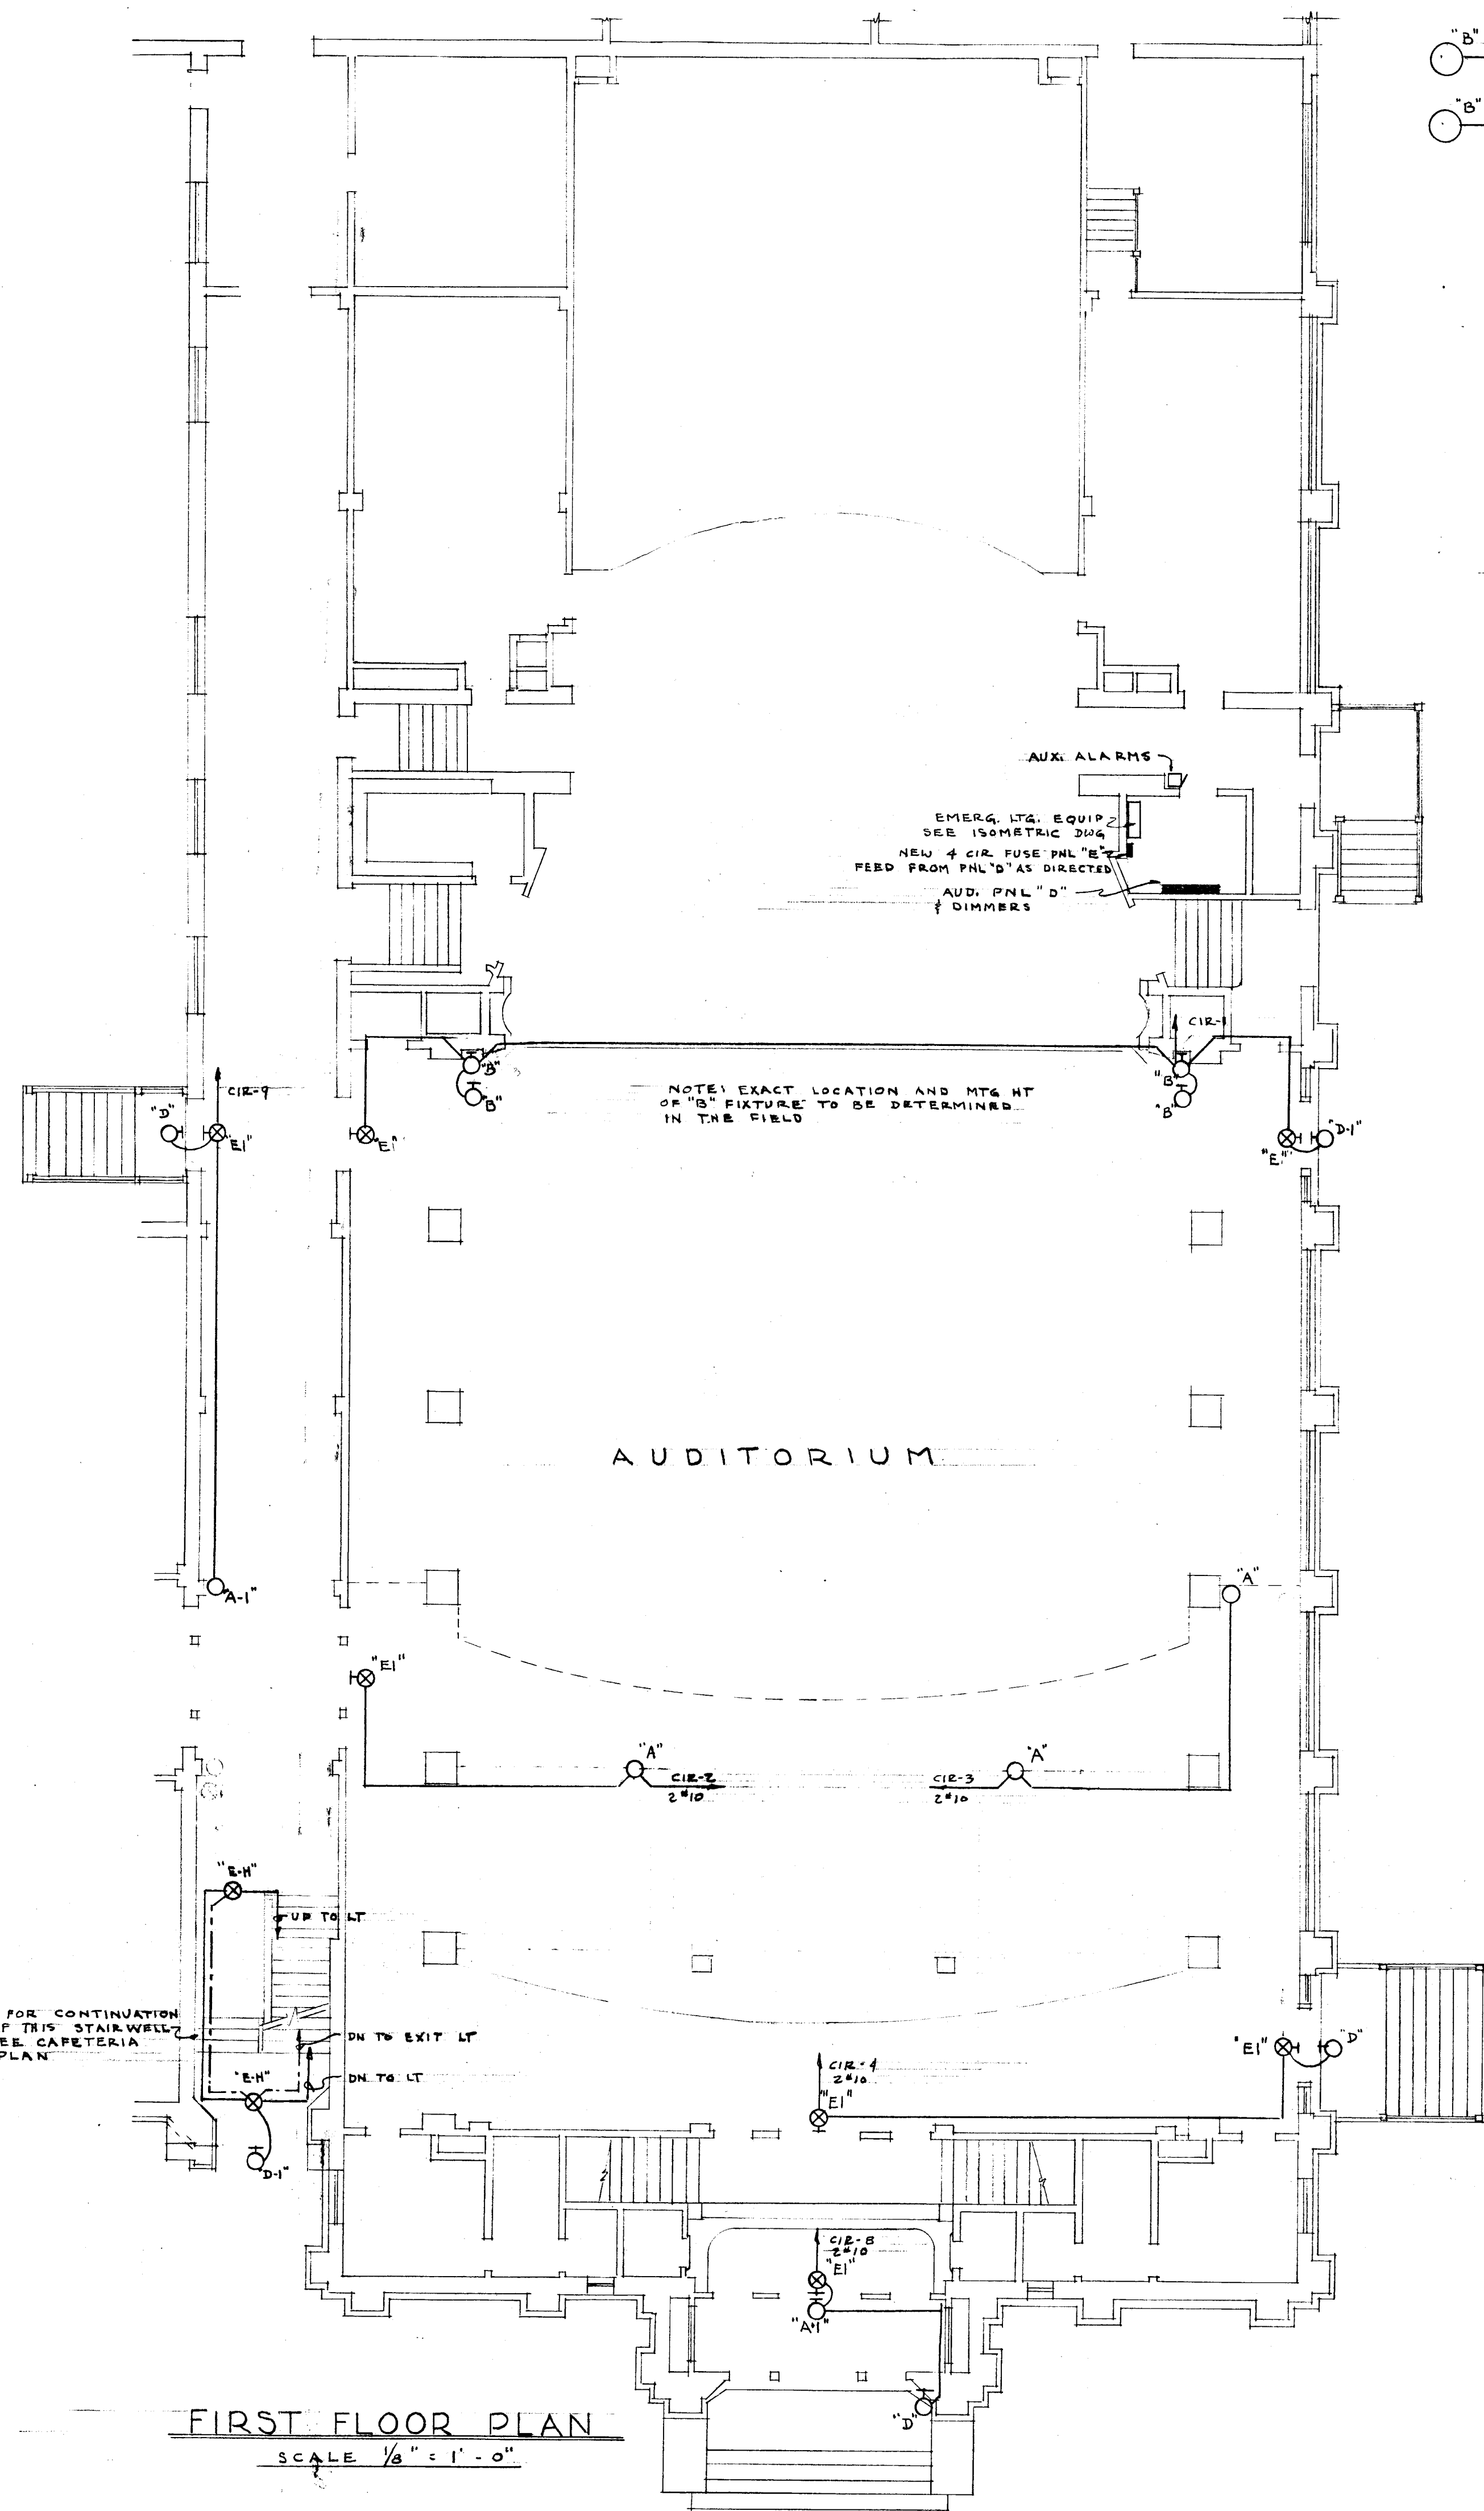


FIRST FLOOR PLAN

SCALE 1/8" = 1'-0"

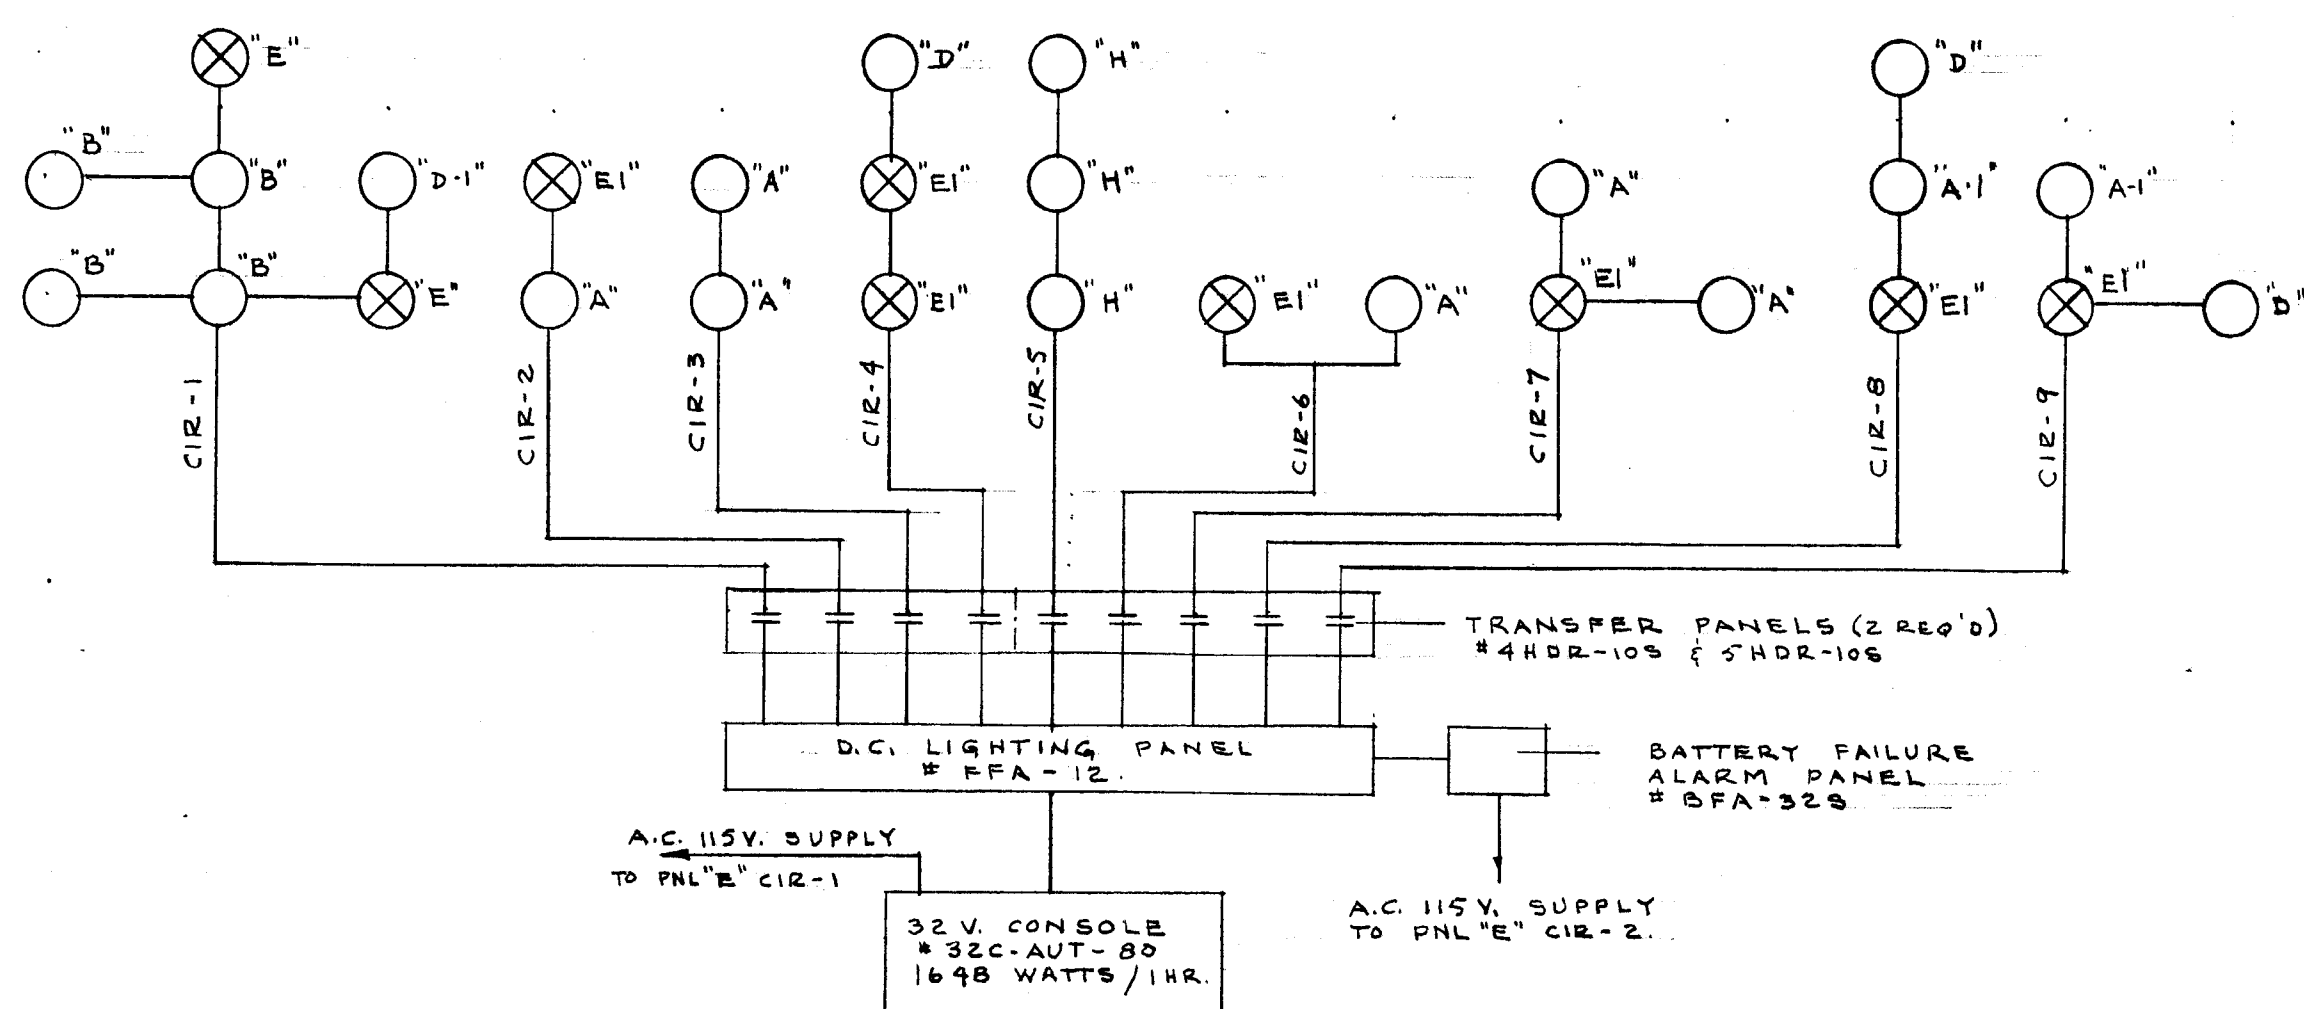


EMERGENCY LIGHTING SCHEMATIC

NO SCALE

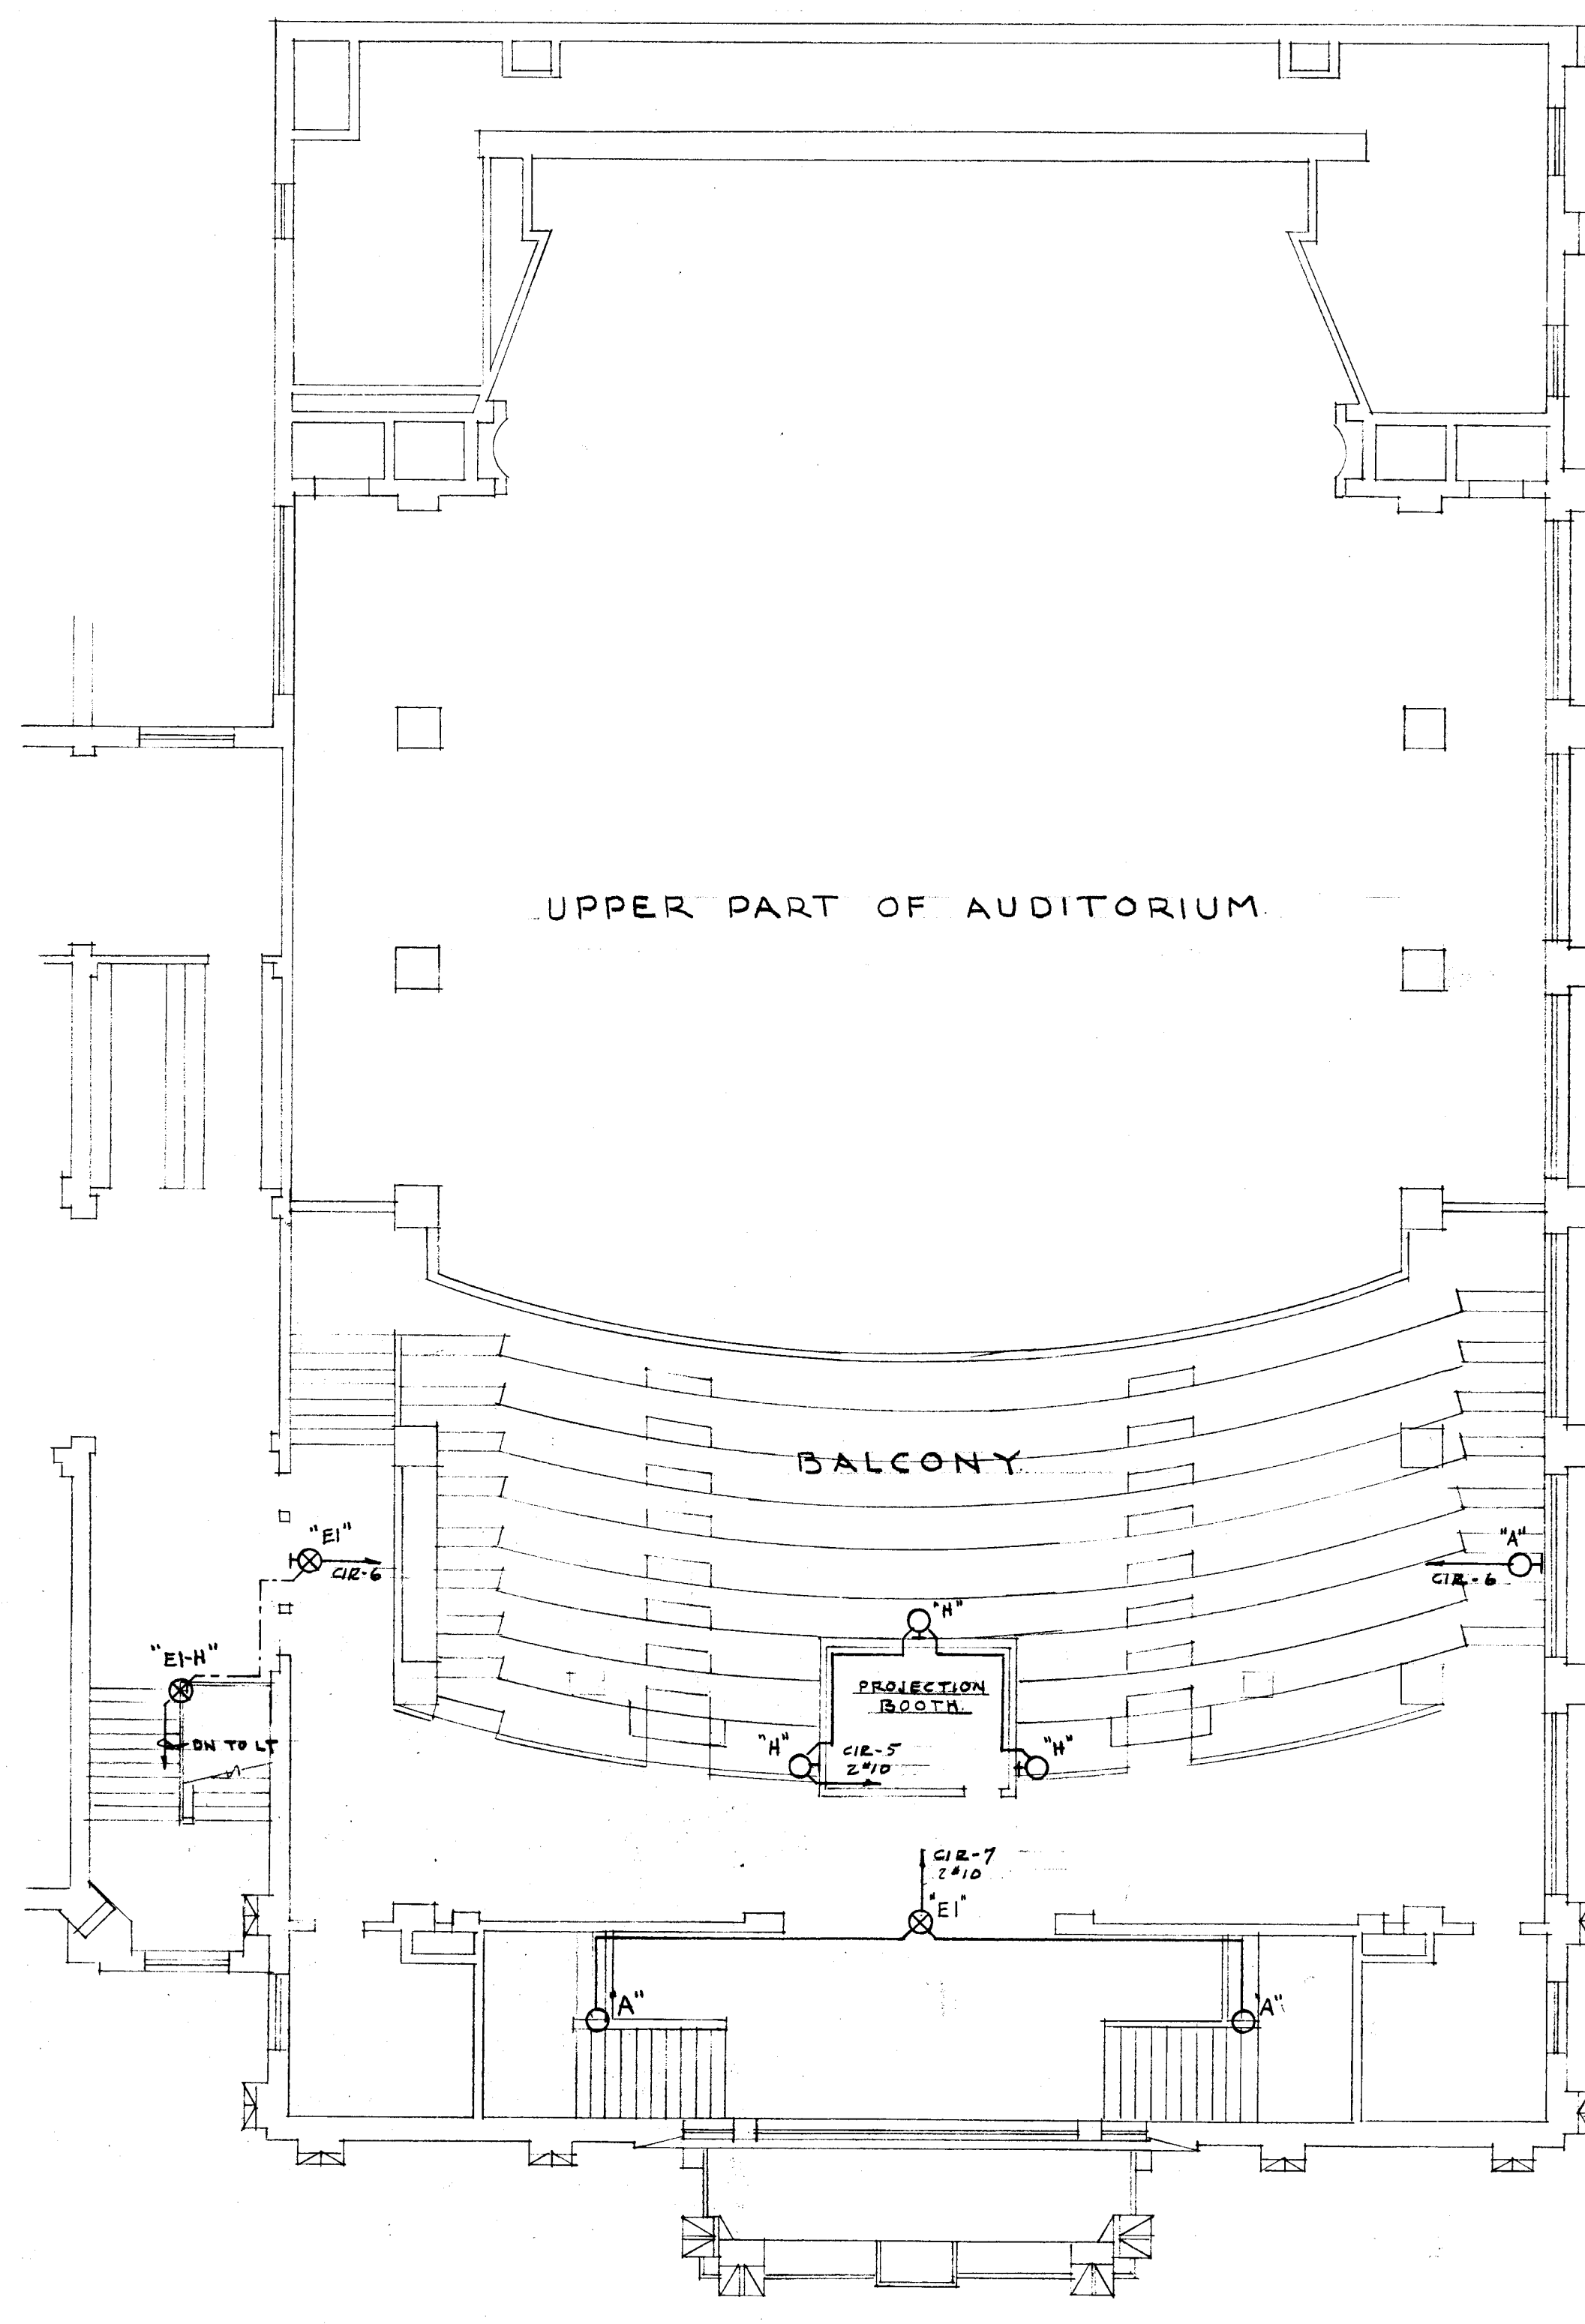


BALCONY (2ND FL.) PLAN

SCALE 1/8" = 1'-0"

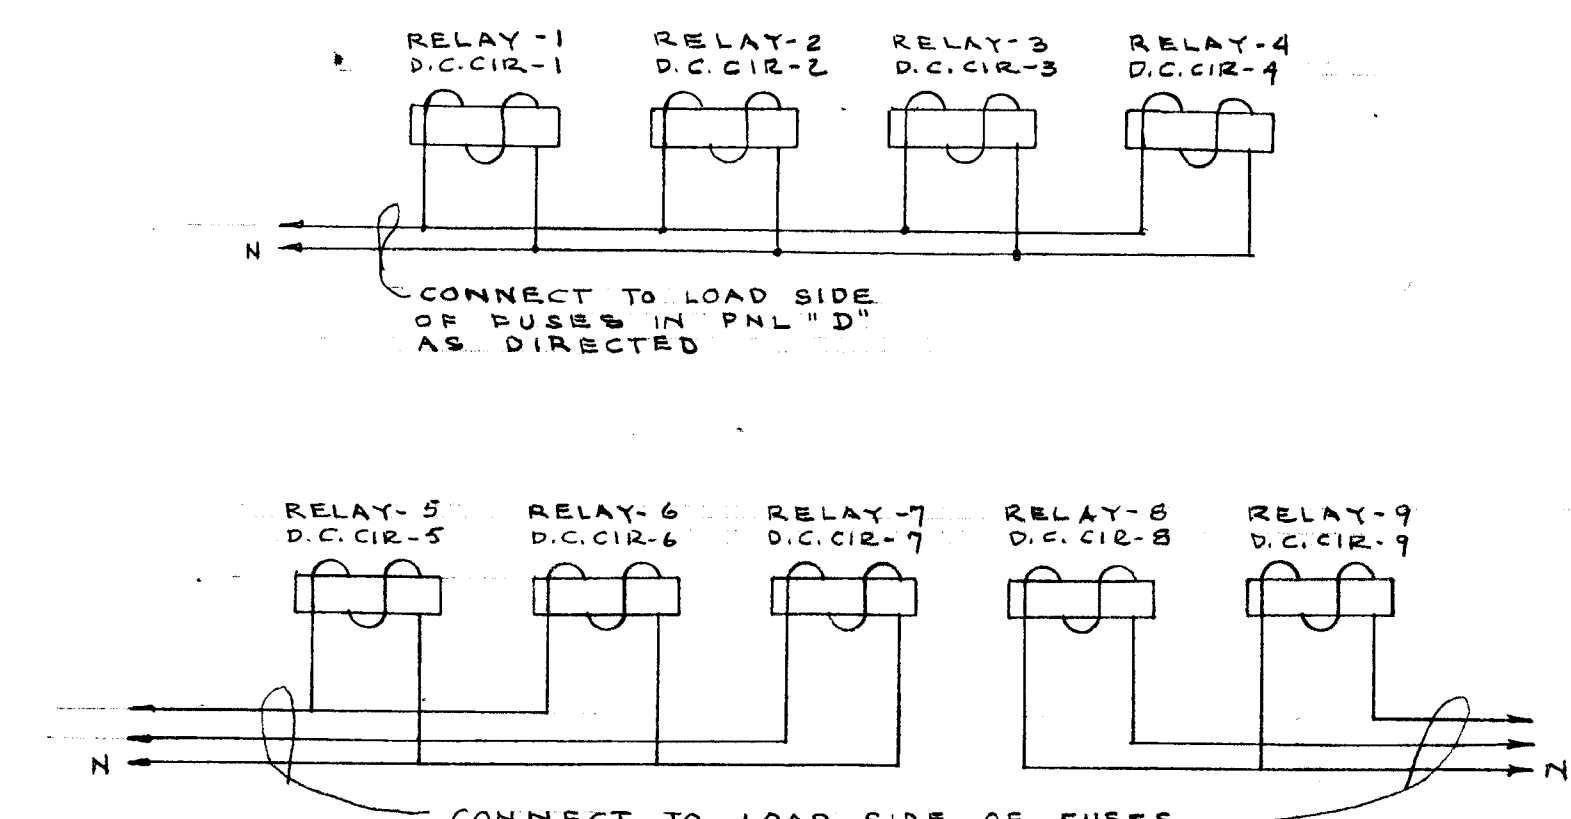


WIRING DIAGRAM OF A.C. CONTROL
FOR RELAYS IN TRANSFER PANELS

NO SCALE

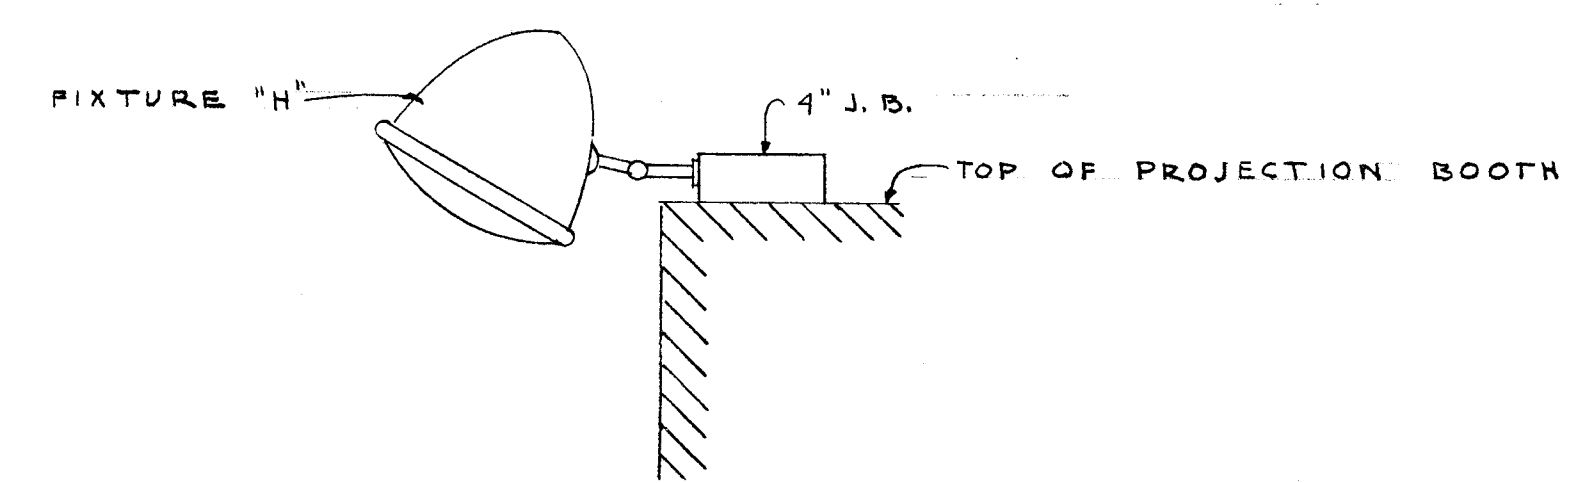

FIXTURE "H" MTG. DETAIL

NO SCALE

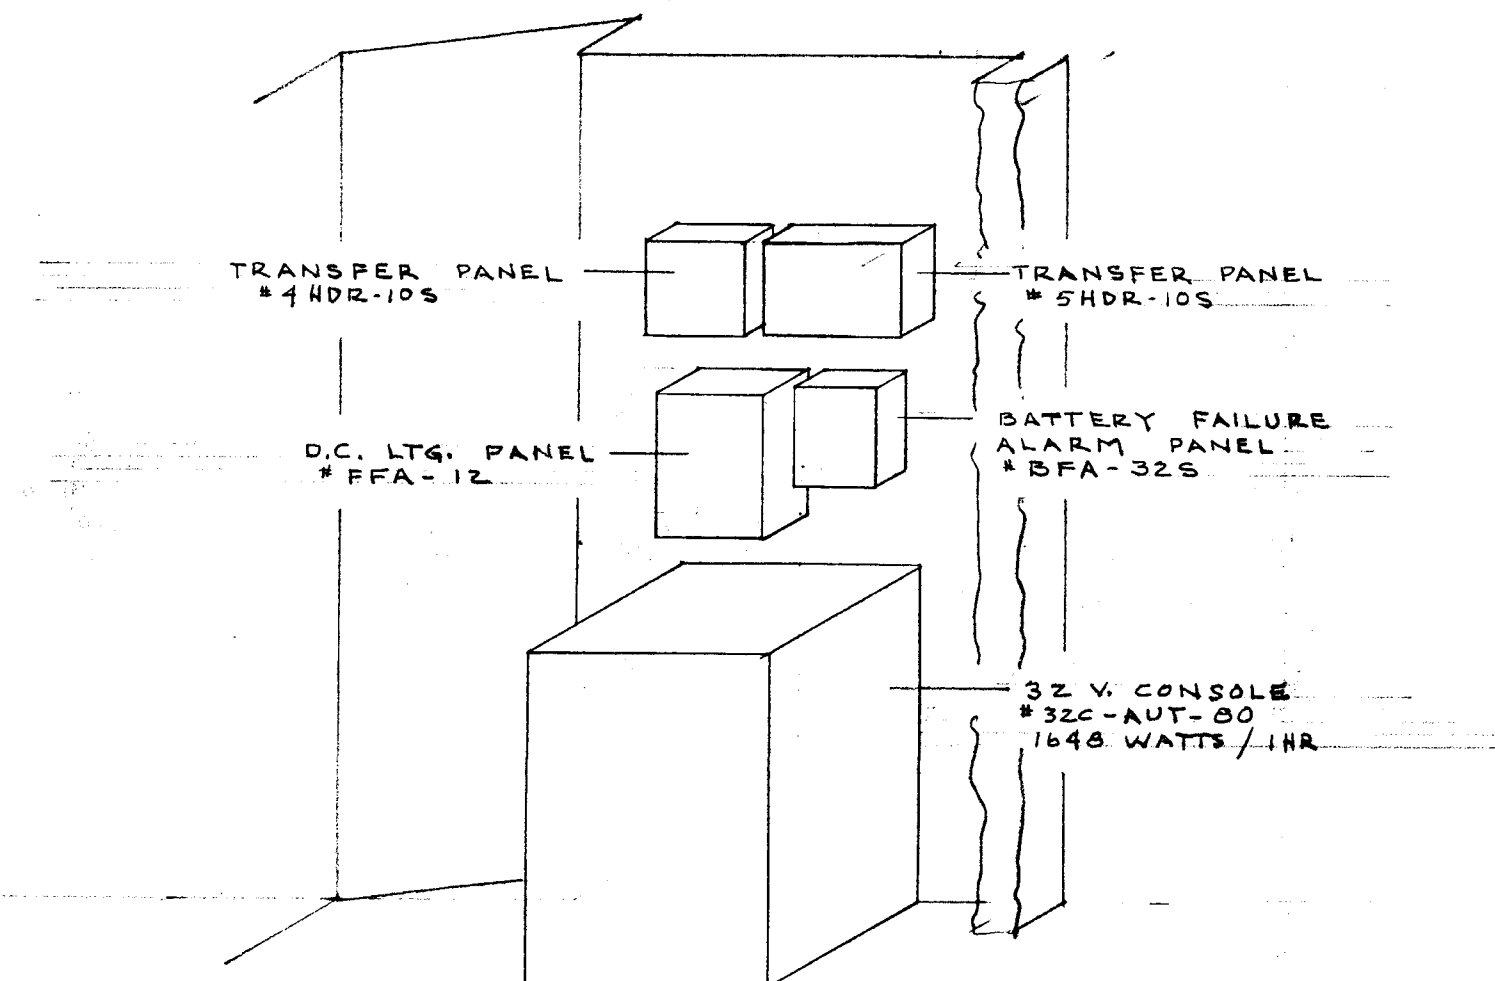

ISOMETRIC OF EMERGENCY EQUIPMENT

NO SCALE

AUDITORIUM.
CITY OF HARTFORD, CONNECTICUT
DEPARTMENT OF ENGINEERING
FOR
EMERGENCY LIGHTING
BULKELEY HIGH SCHOOL
470 MAPLE AVE., HARTFORD CONN.

VERIFY EXISTING
CONDITIONS AND
DIMENSIONS AT
BUILDING

SUBMITTED
RECOMMENDED
APPROVED

DESIGN R.G.B. DRAWN R.G.B. DAYBOOK NO. 09615-B
TRACED CHECK DATE MARCH 10, 1960