


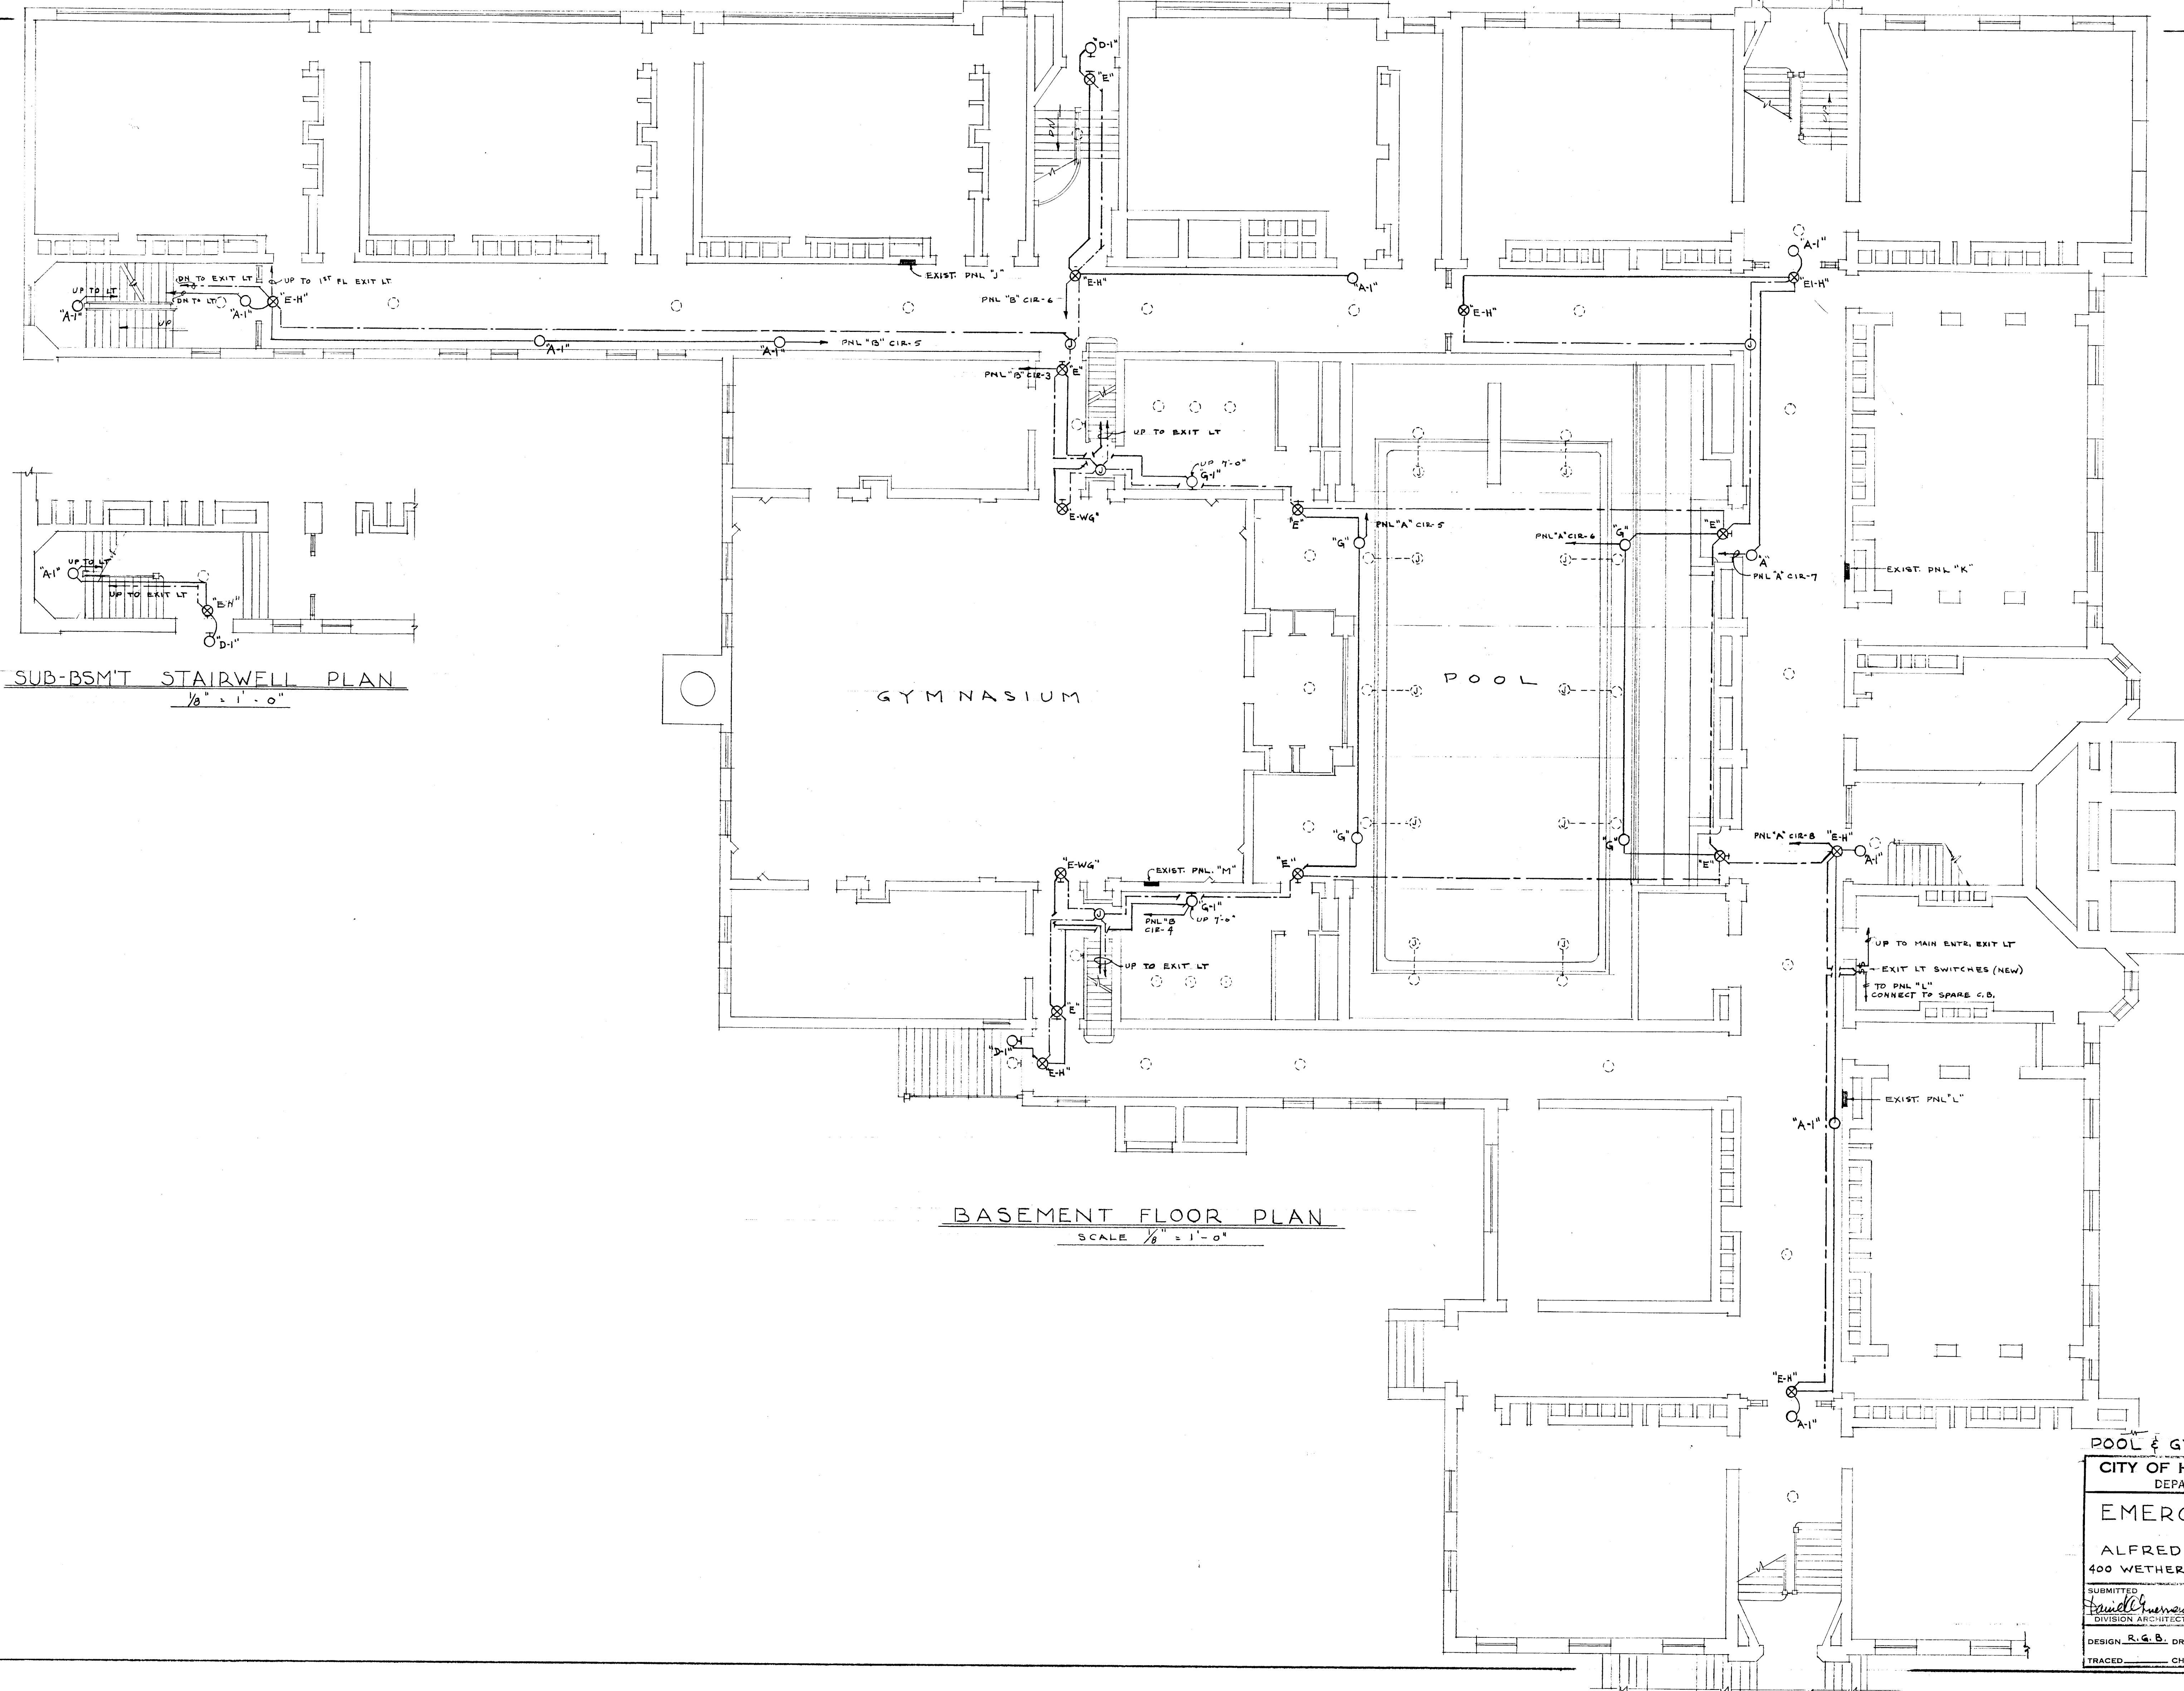

SUB-BSM'T STAIRWELL PLAN
1/8" = 1'-0"

BASEMENT FLOOR PLAN
SCALE 1/8" = 1'-0"

7		
POOL & GYM.		
CITY OF HARTFORD, CONNECTICUT DEPARTMENT OF ENGINEERING		
EMERGENCY LIGHTING FOR		
ALFRED E. BURR SCHOOL 400 WETHERSFIELD AV. HARTFORD CONN.		
SUBMITTED DIVISION ARCHITECT	RECOMMENDED CITY ARCHITECT	APPROVED CITY ENGINEER
DESIGN R.G.B.	DRAWN R.G.B.	DAYBOOK NO. 09613-G
TRACED	CHECK	DATE MARCH 10, 1960