


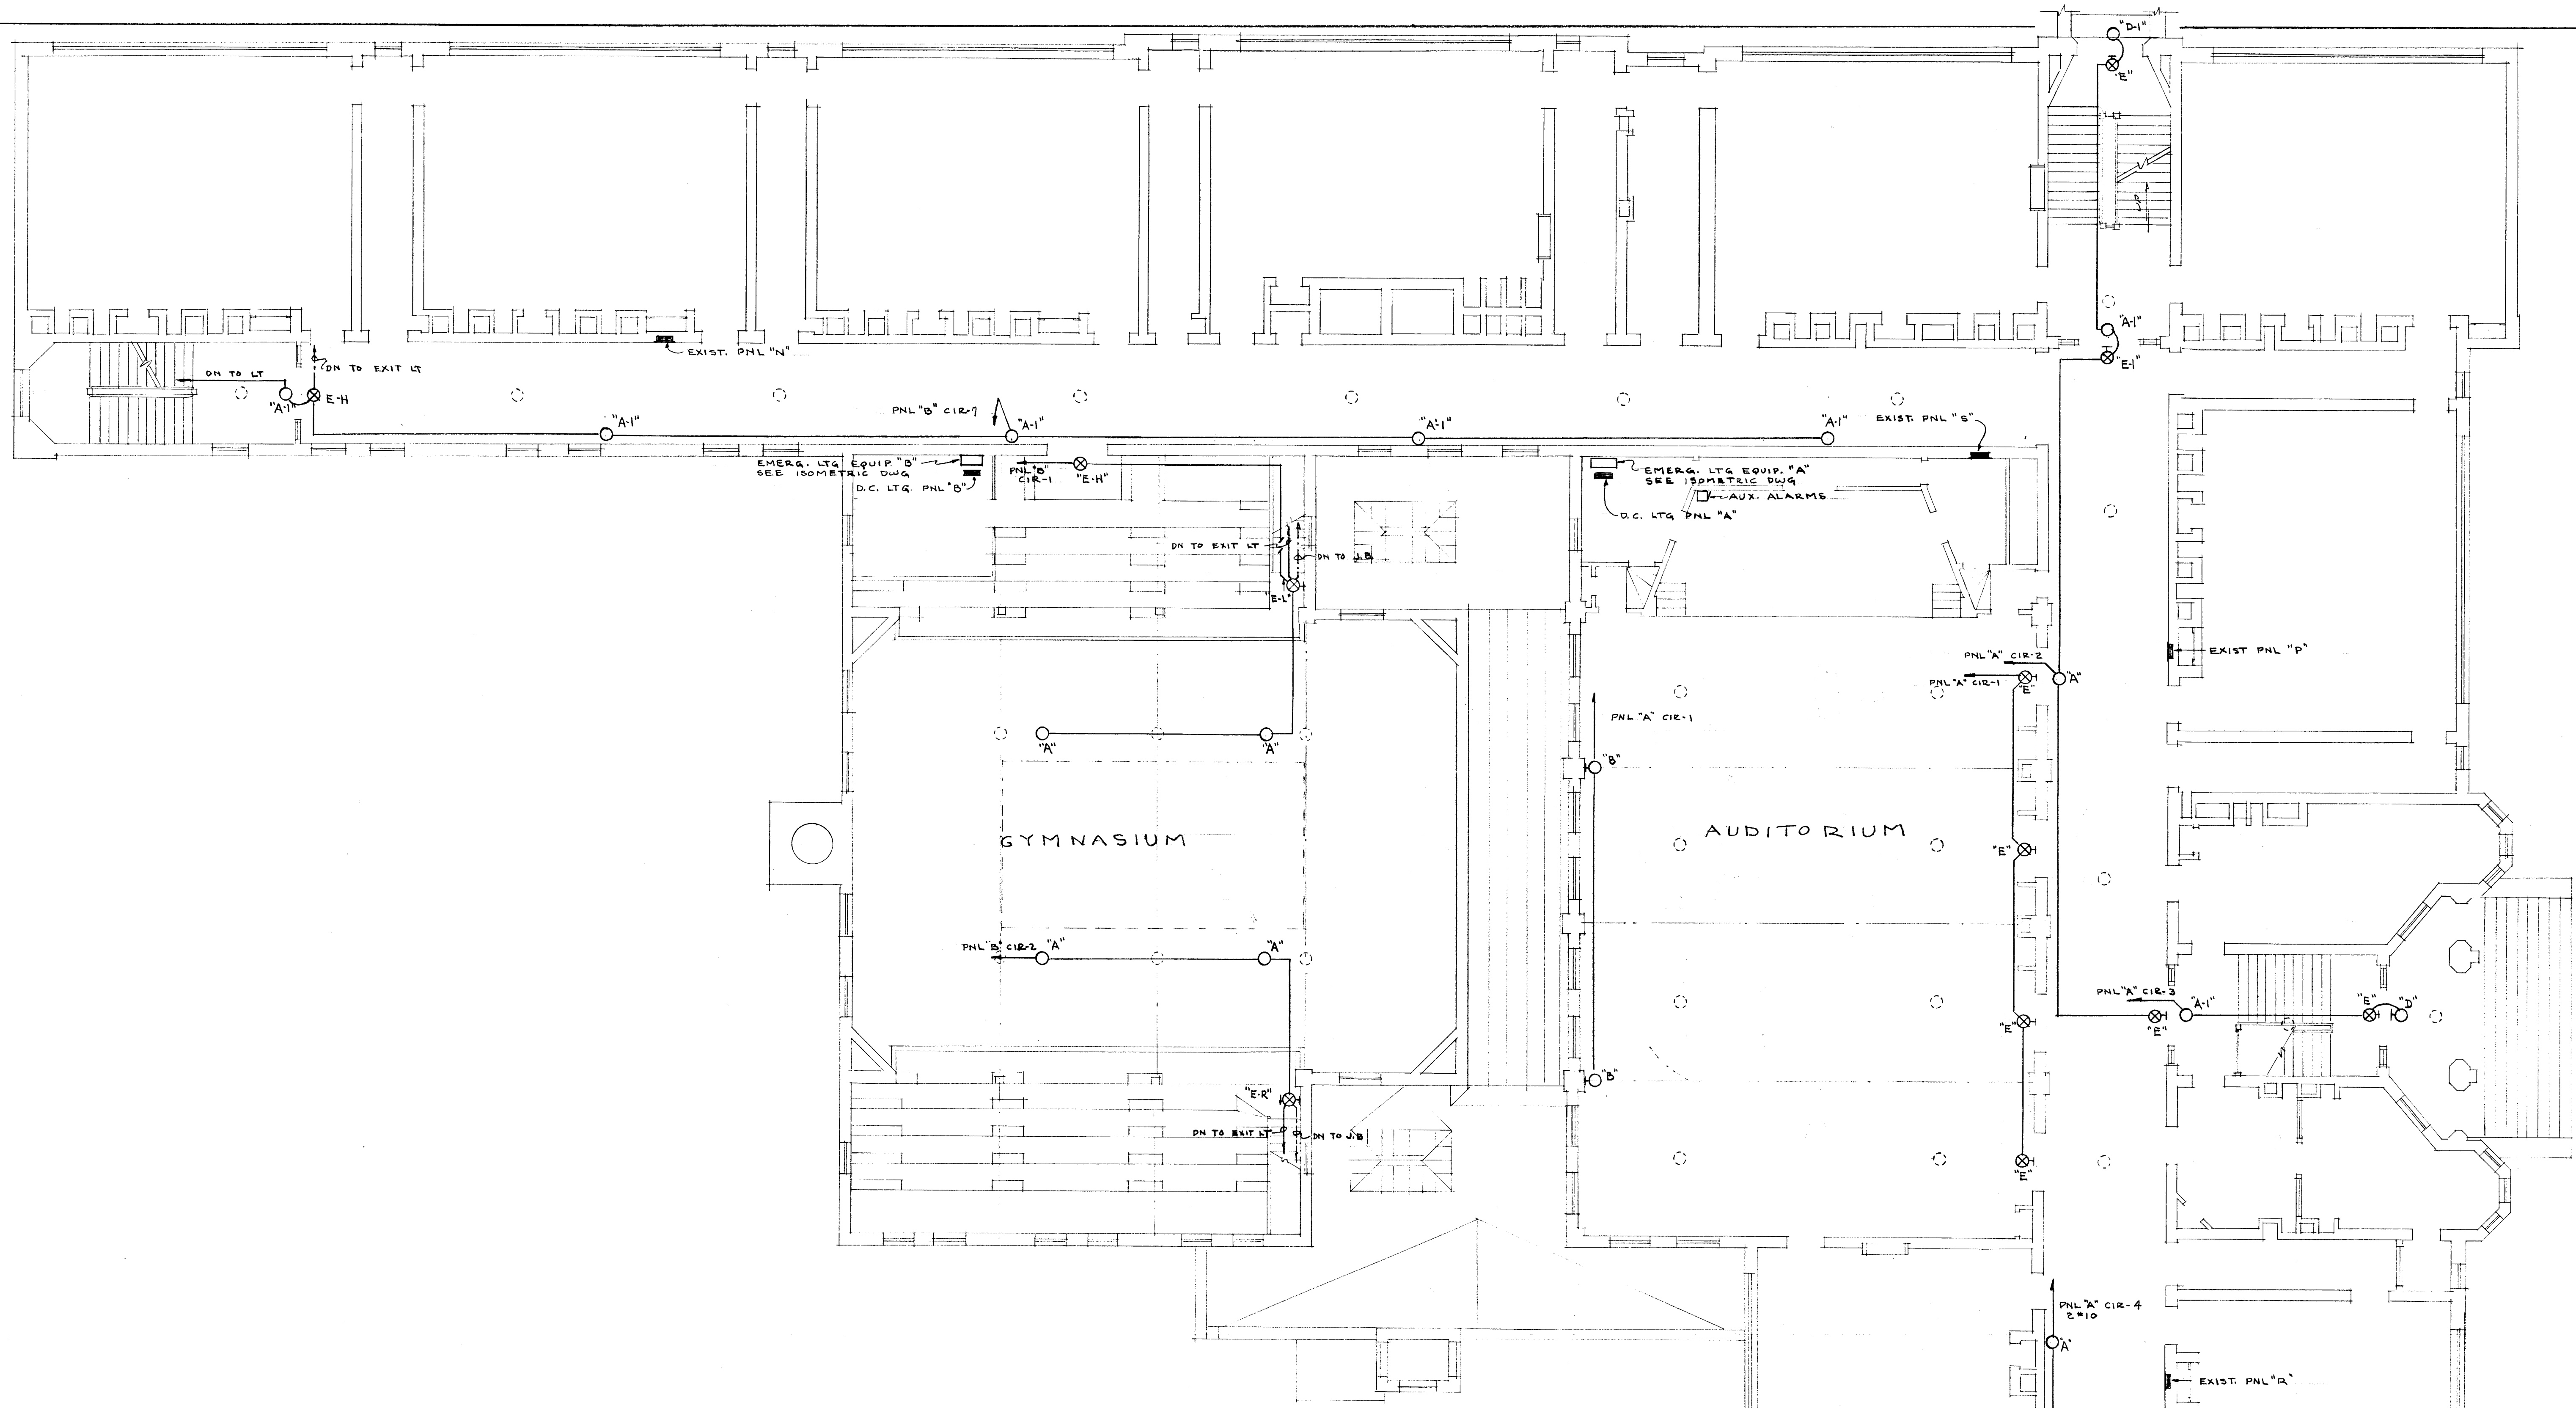

FIRST FLOOR PLAN
SCALE 1/8" = 1'-0"

FIXTURE SCHEDULE		
TYPE	MANUFACTURER & CATALOG NO.	LAMPS
A	DUAL-LITE *EXT-1245	2-32 CP
A-1	" *EXT-1245	2-15 CP
B	" *EXT-121	1-50 CP
D	" *EXT-05	2-32 CP
D-1	" *EXT-05	2-15 CP
E	" *EXT-125	2-25WATT A.C. & 3-15 CP
E-H	" *EXT-125H	" & "
E-L	" *EXT-125L	" & "
E-R	" *EXT-125R	" & "
E-W	" *EXT-125WG	" & "
EI	" *EXT-125	" & 1-15 CP & 2-32 CP
EI-H	" *EXT-125H	" & " & "
G	" *EXT-1235	1-50 CP
G-1	" *EXT-1235	1-32 CP

SYMBOL LIST	
SYMBOL	DESCRIPTION
○	EXISTING CEILING OUTLET OR FIXTURE
○	CEILING FIXTURE
⊗	WALL BRACKET
⊗	EXIT LIGHT
⊙	JUNCTION BOX
—	D.C. WIRING
- - -	A.C. WIRING
■	PANELBOARD
□	AUX. ALARMS FOR BFA & D.C. LTG PNLS.

VERIFY EXISTING
CONDITIONS AND
DIMENSIONS AT
BUILDING

AUD. & GYM.

CITY OF HARTFORD, CONNECTICUT DEPARTMENT OF ENGINEERING		
EMERGENCY LIGHTING		
FOR ALFRED E. BURR SCHOOL 400 WETHERSFIELD AV., HARTFORD CONN.		
SUBMITTED DIVISION ARCHITECT <i>R.G.B.</i>	RECOMMENDED CITY ARCHITECT <i>David L. Tindle</i>	APPROVED CITY ENGINEER <i>Walter D. May</i>
DESIGN <i>R.G.B.</i> DRAWN <i>R.G.B.</i>		DAYBOOK NO. 09613-H
TRACED	CHECK	DATE MARCH 10, 1960