




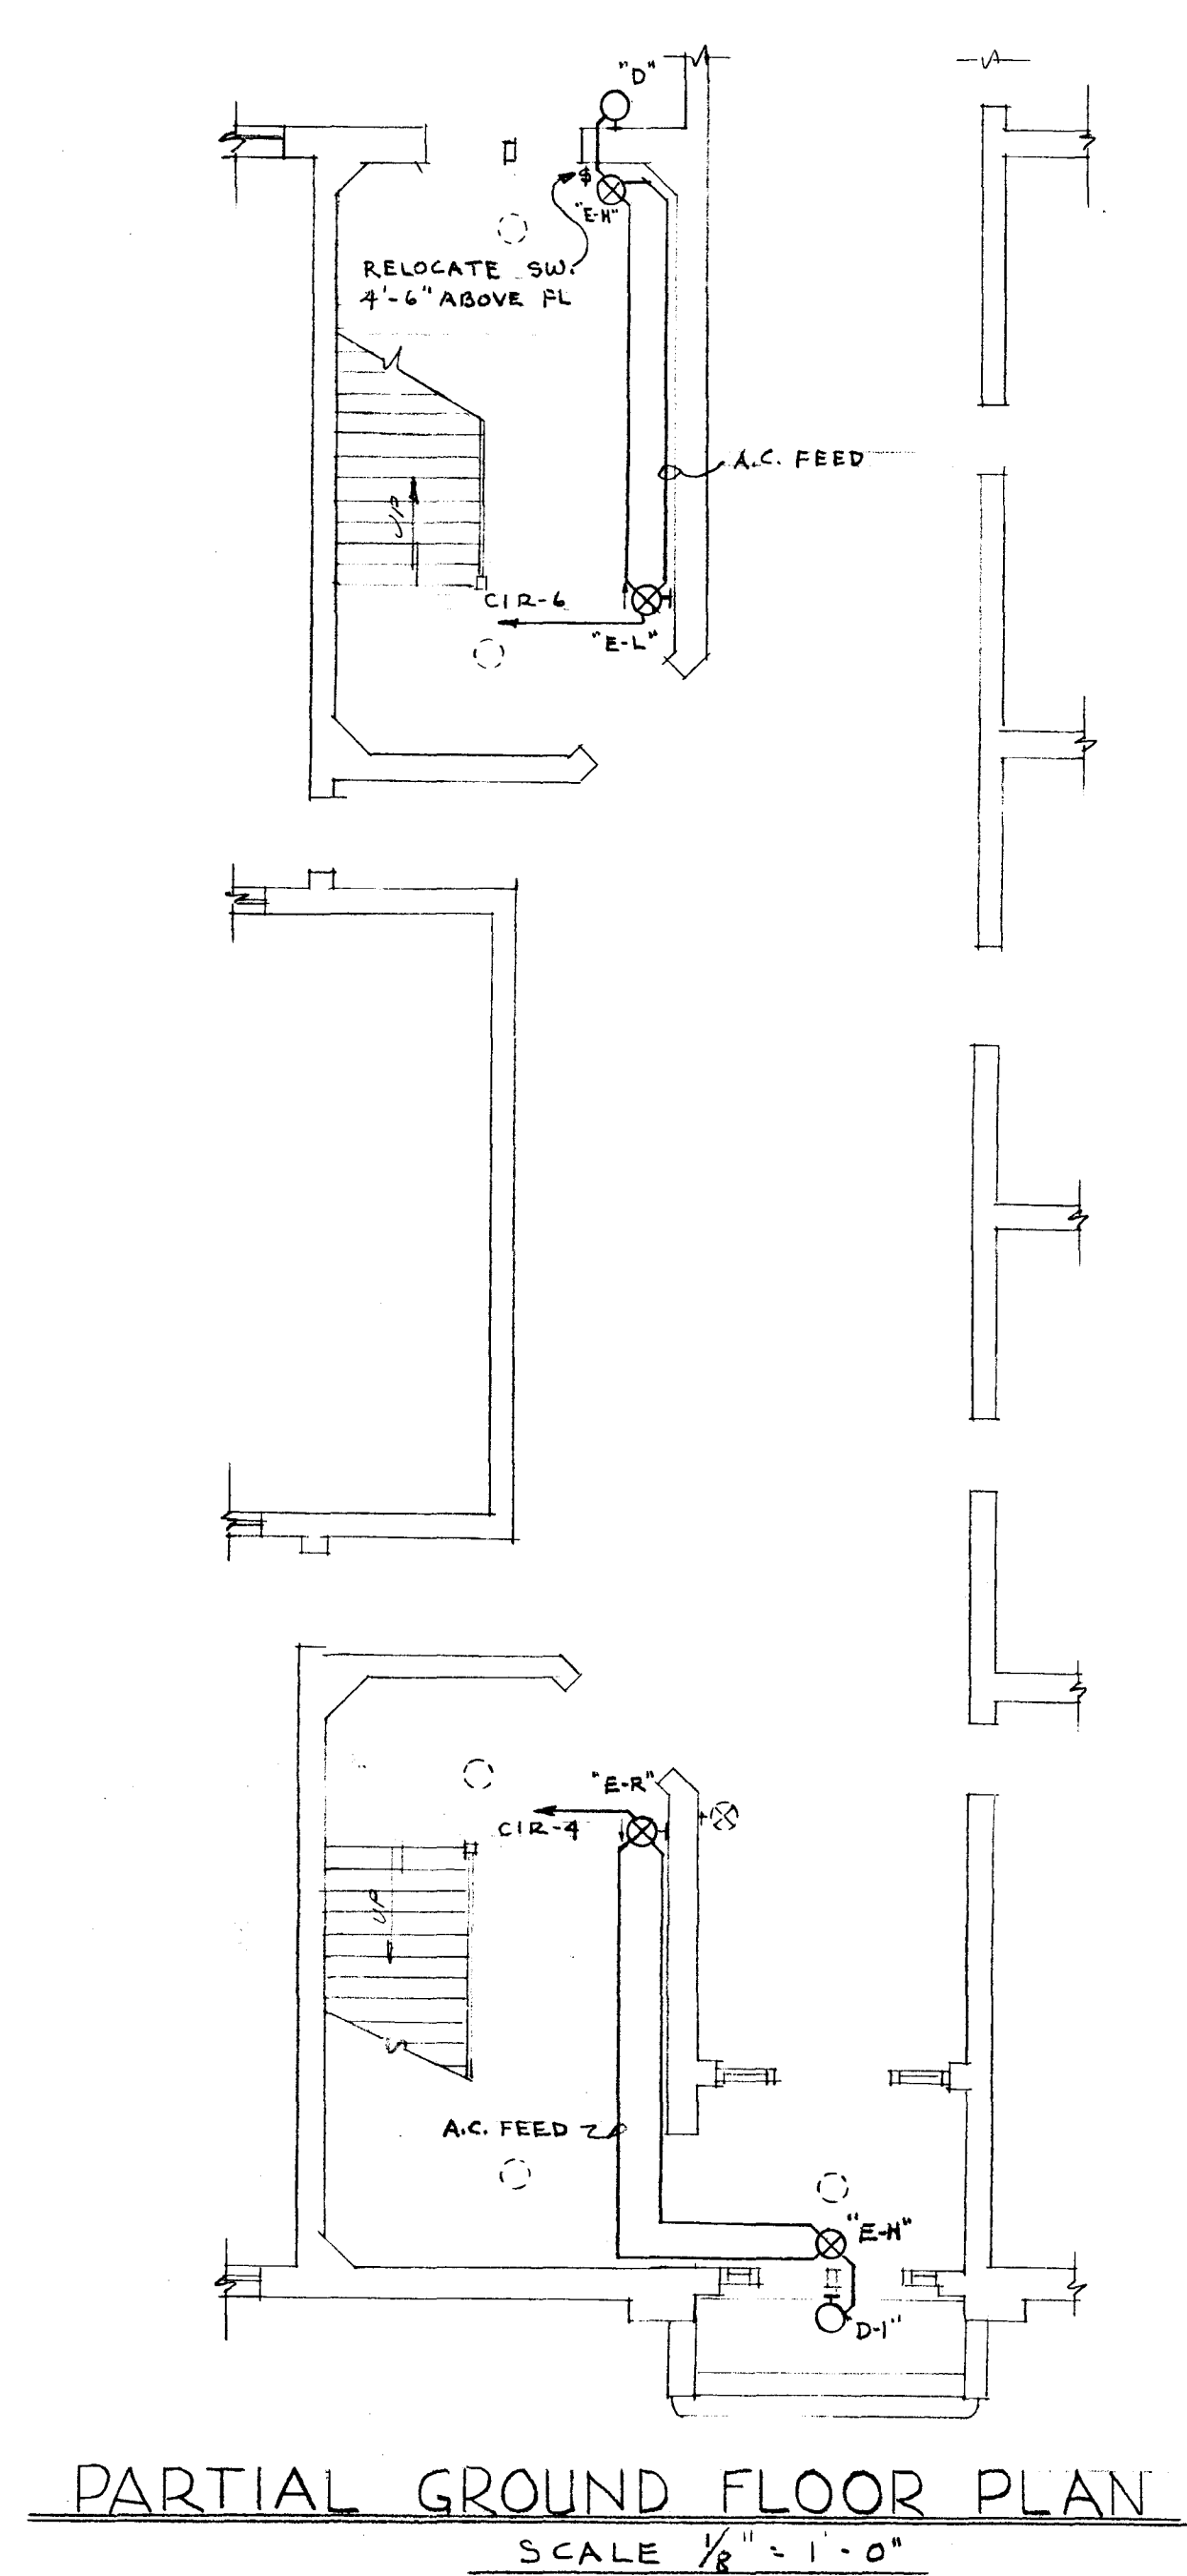


PARTIAL GROUND FLOOR PLAN
SCALE 1/8" = 1'-0"

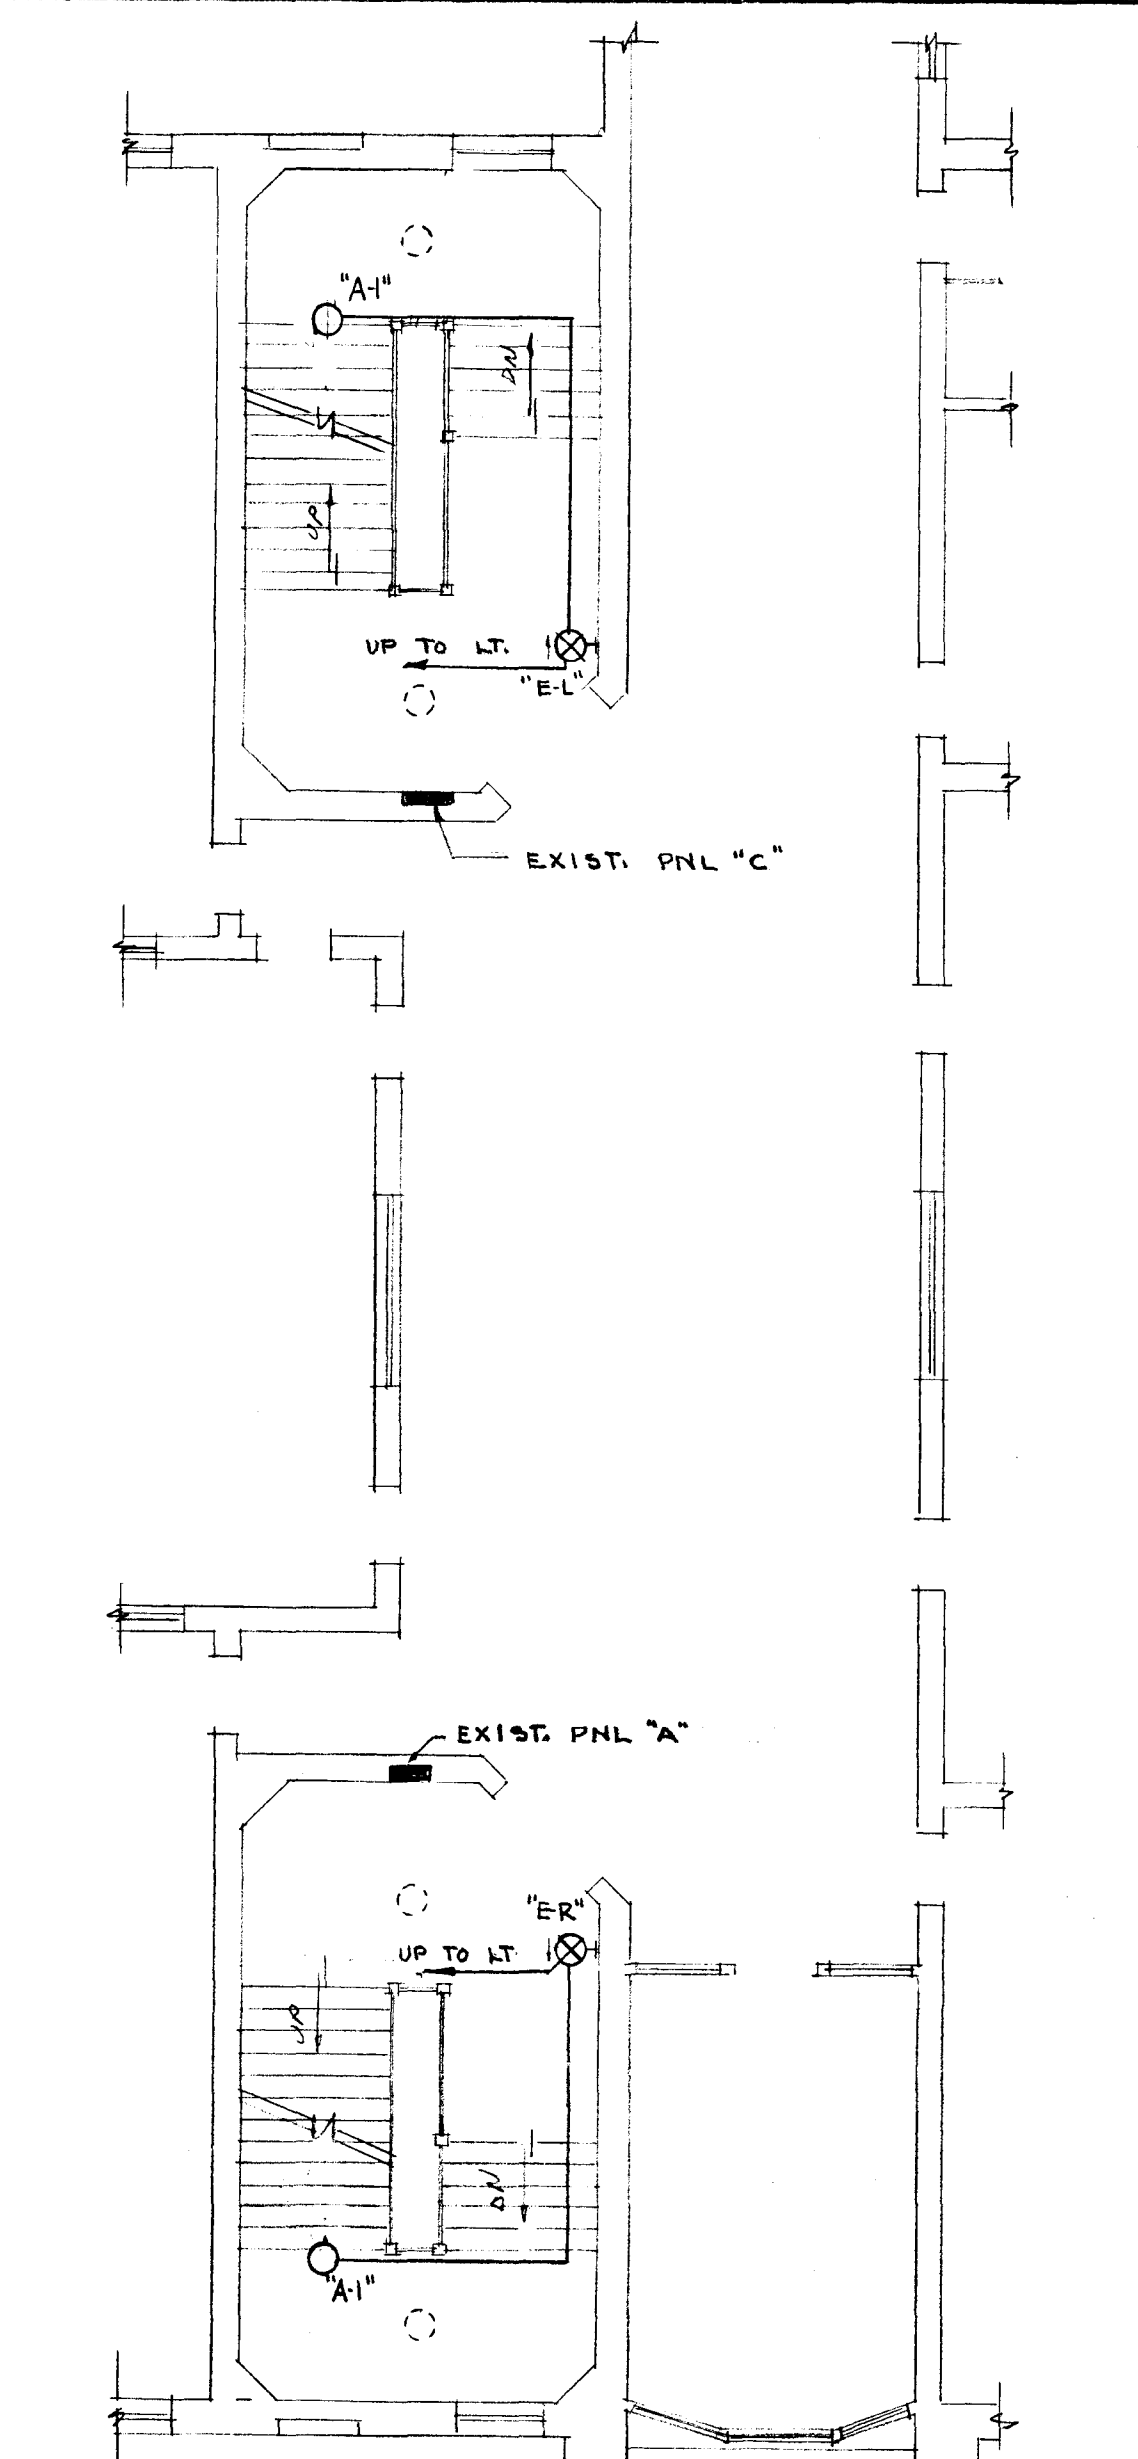


PARTIAL FIRST FLOOR PLAN
SCALE 1/8" = 1'-0"

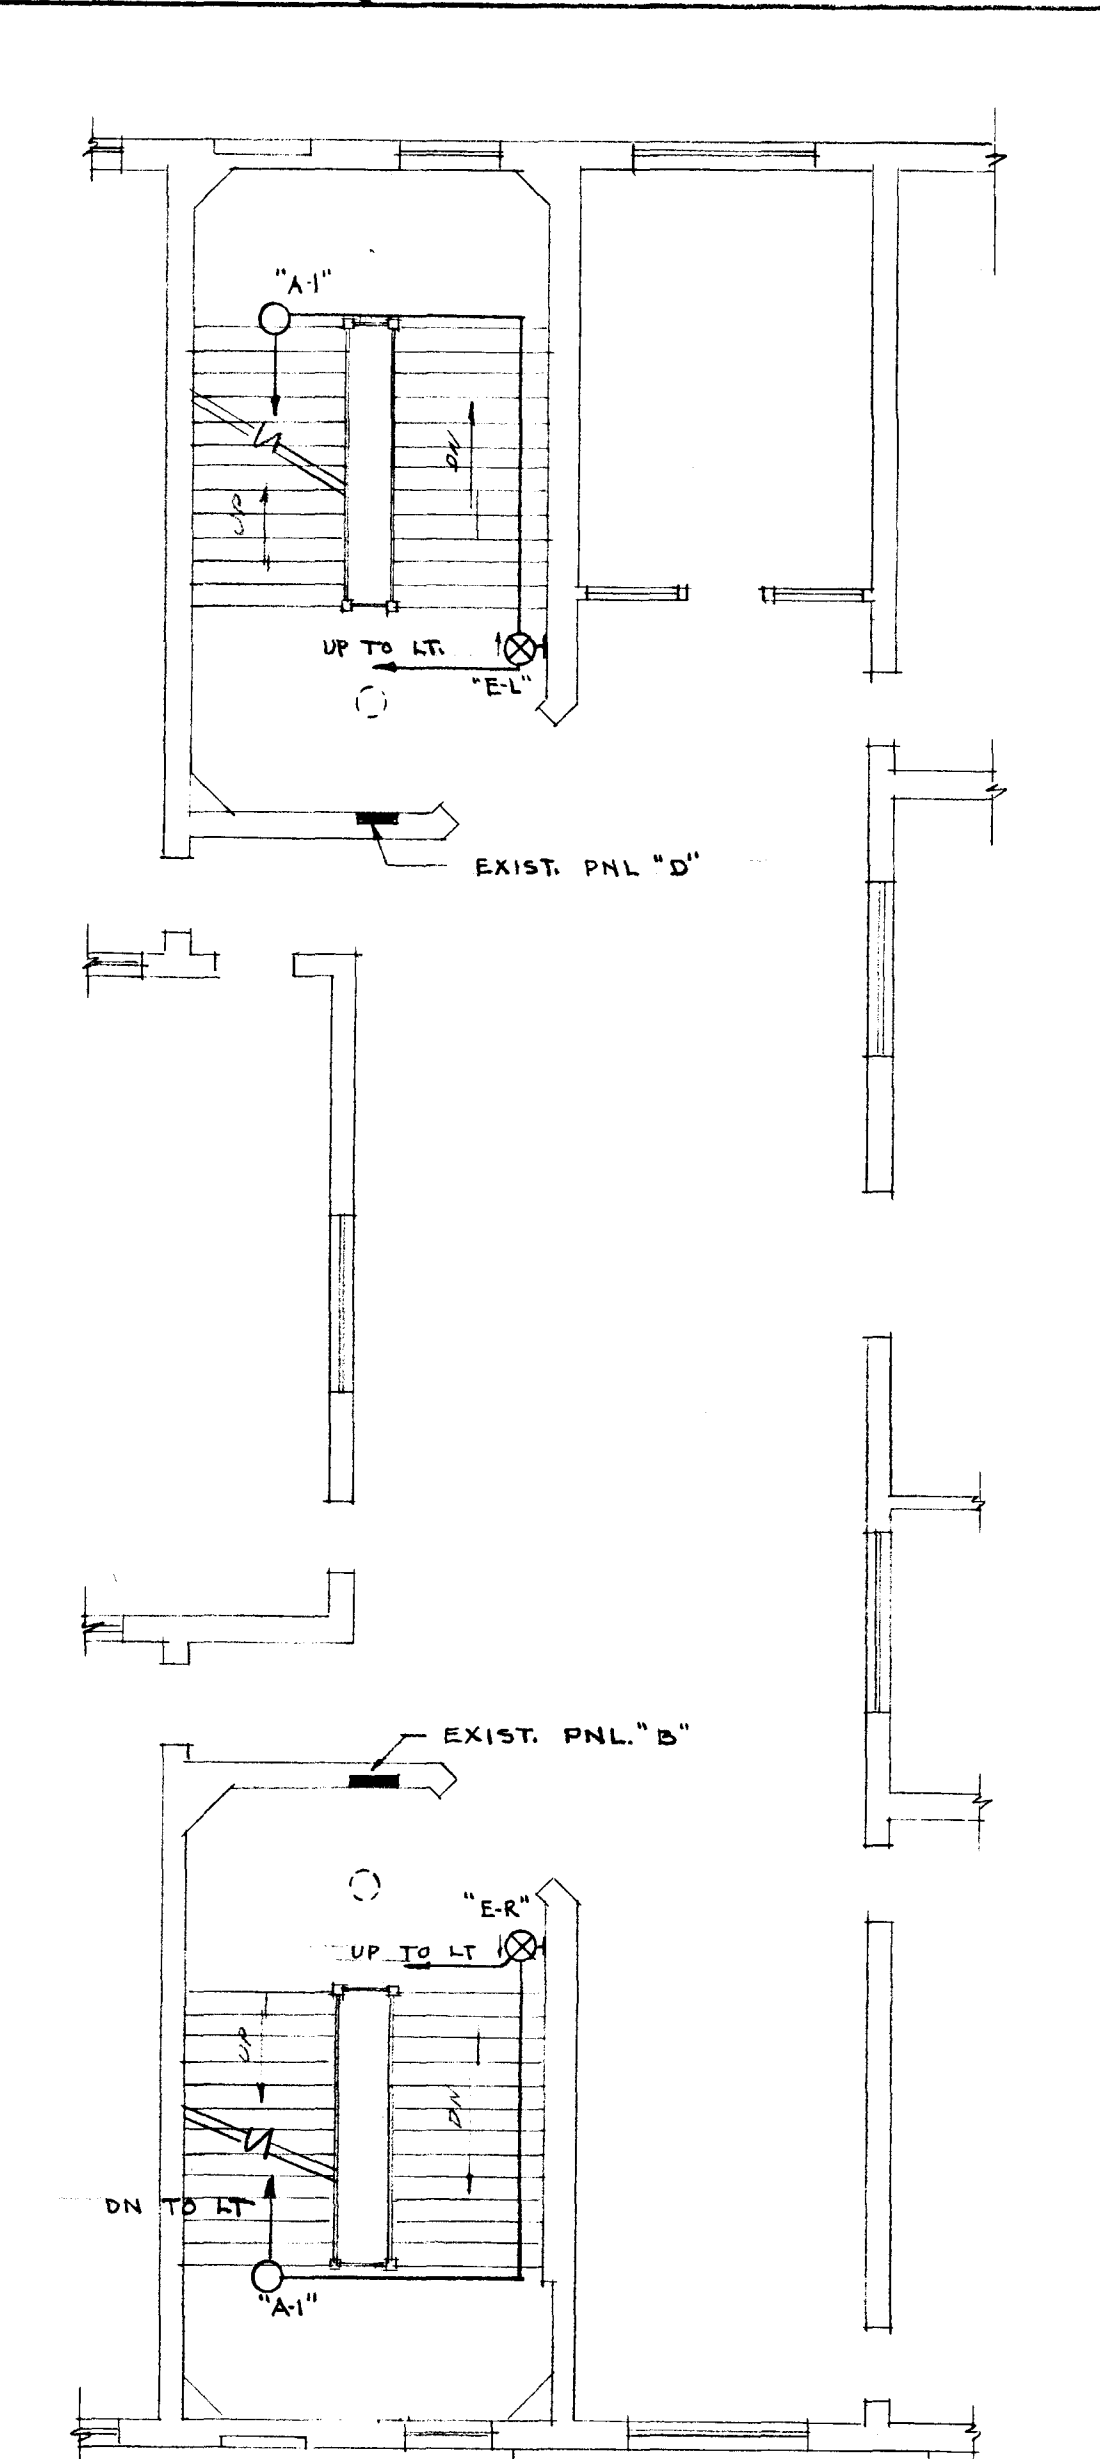

PARTIAL SECOND FLOOR PLAN
SCALE 1/8" = 1'-0"

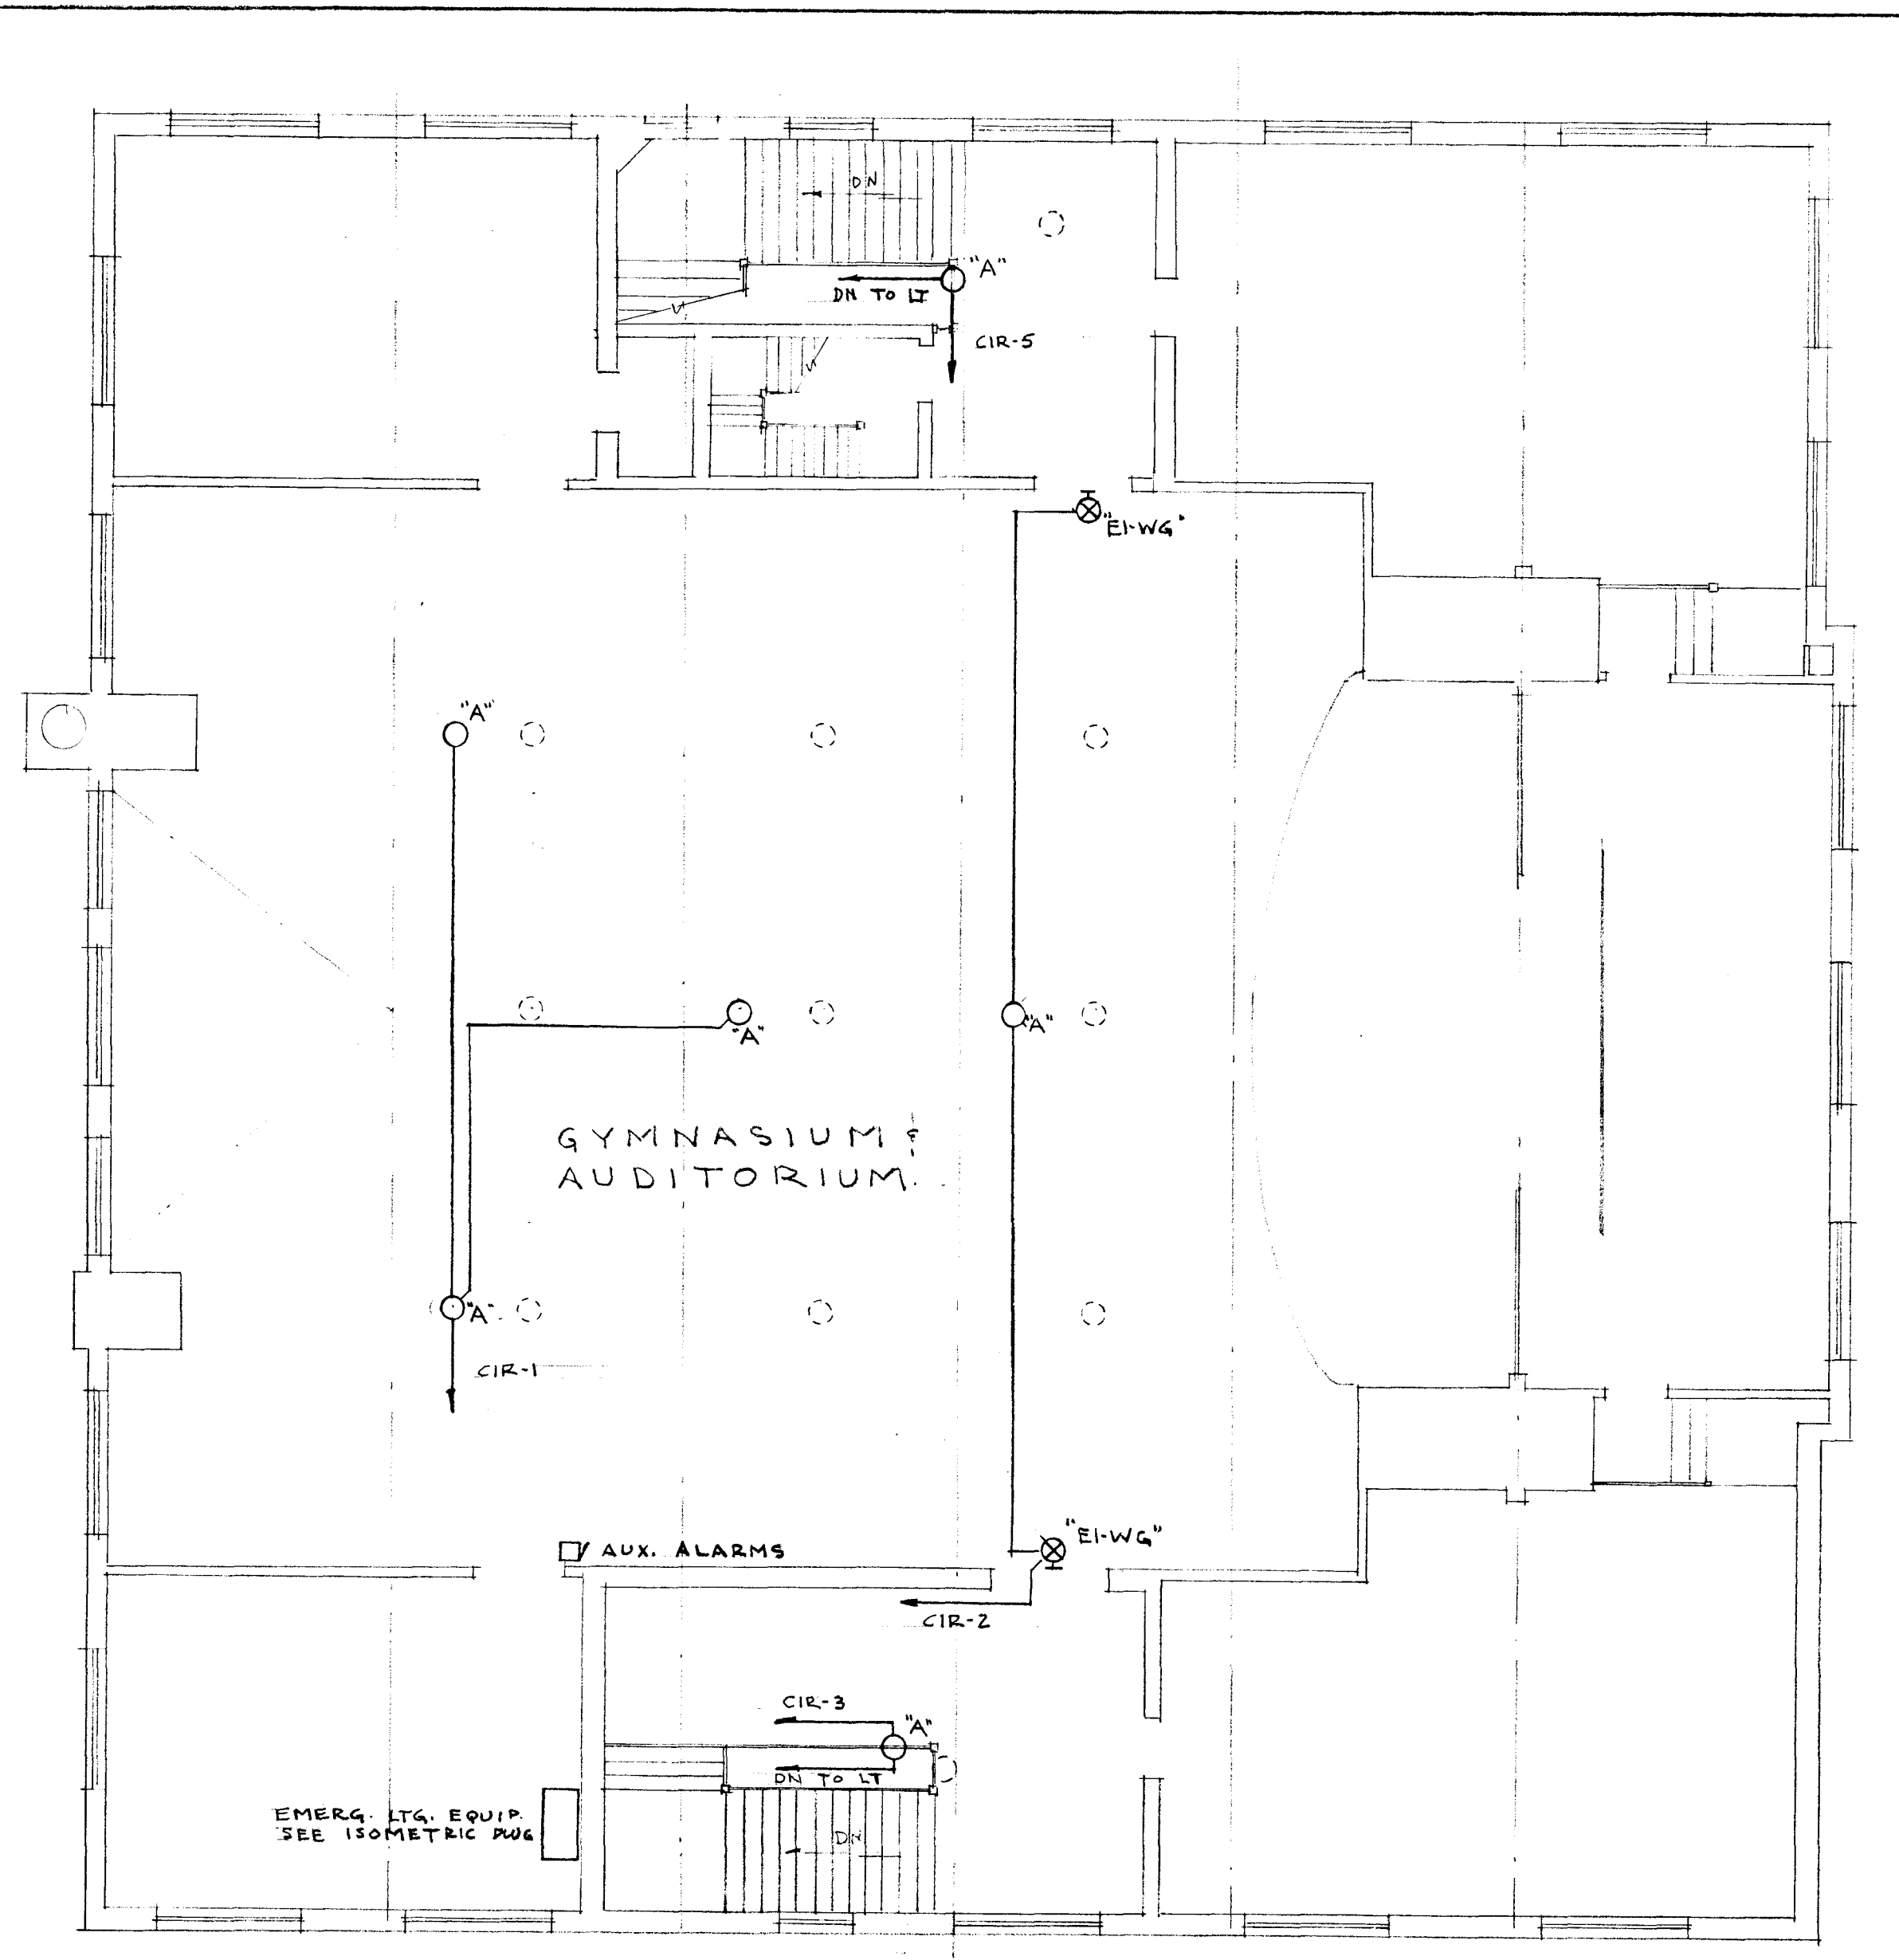


THIRD FLOOR PLAN
SCALE 1/8" = 1'-0"

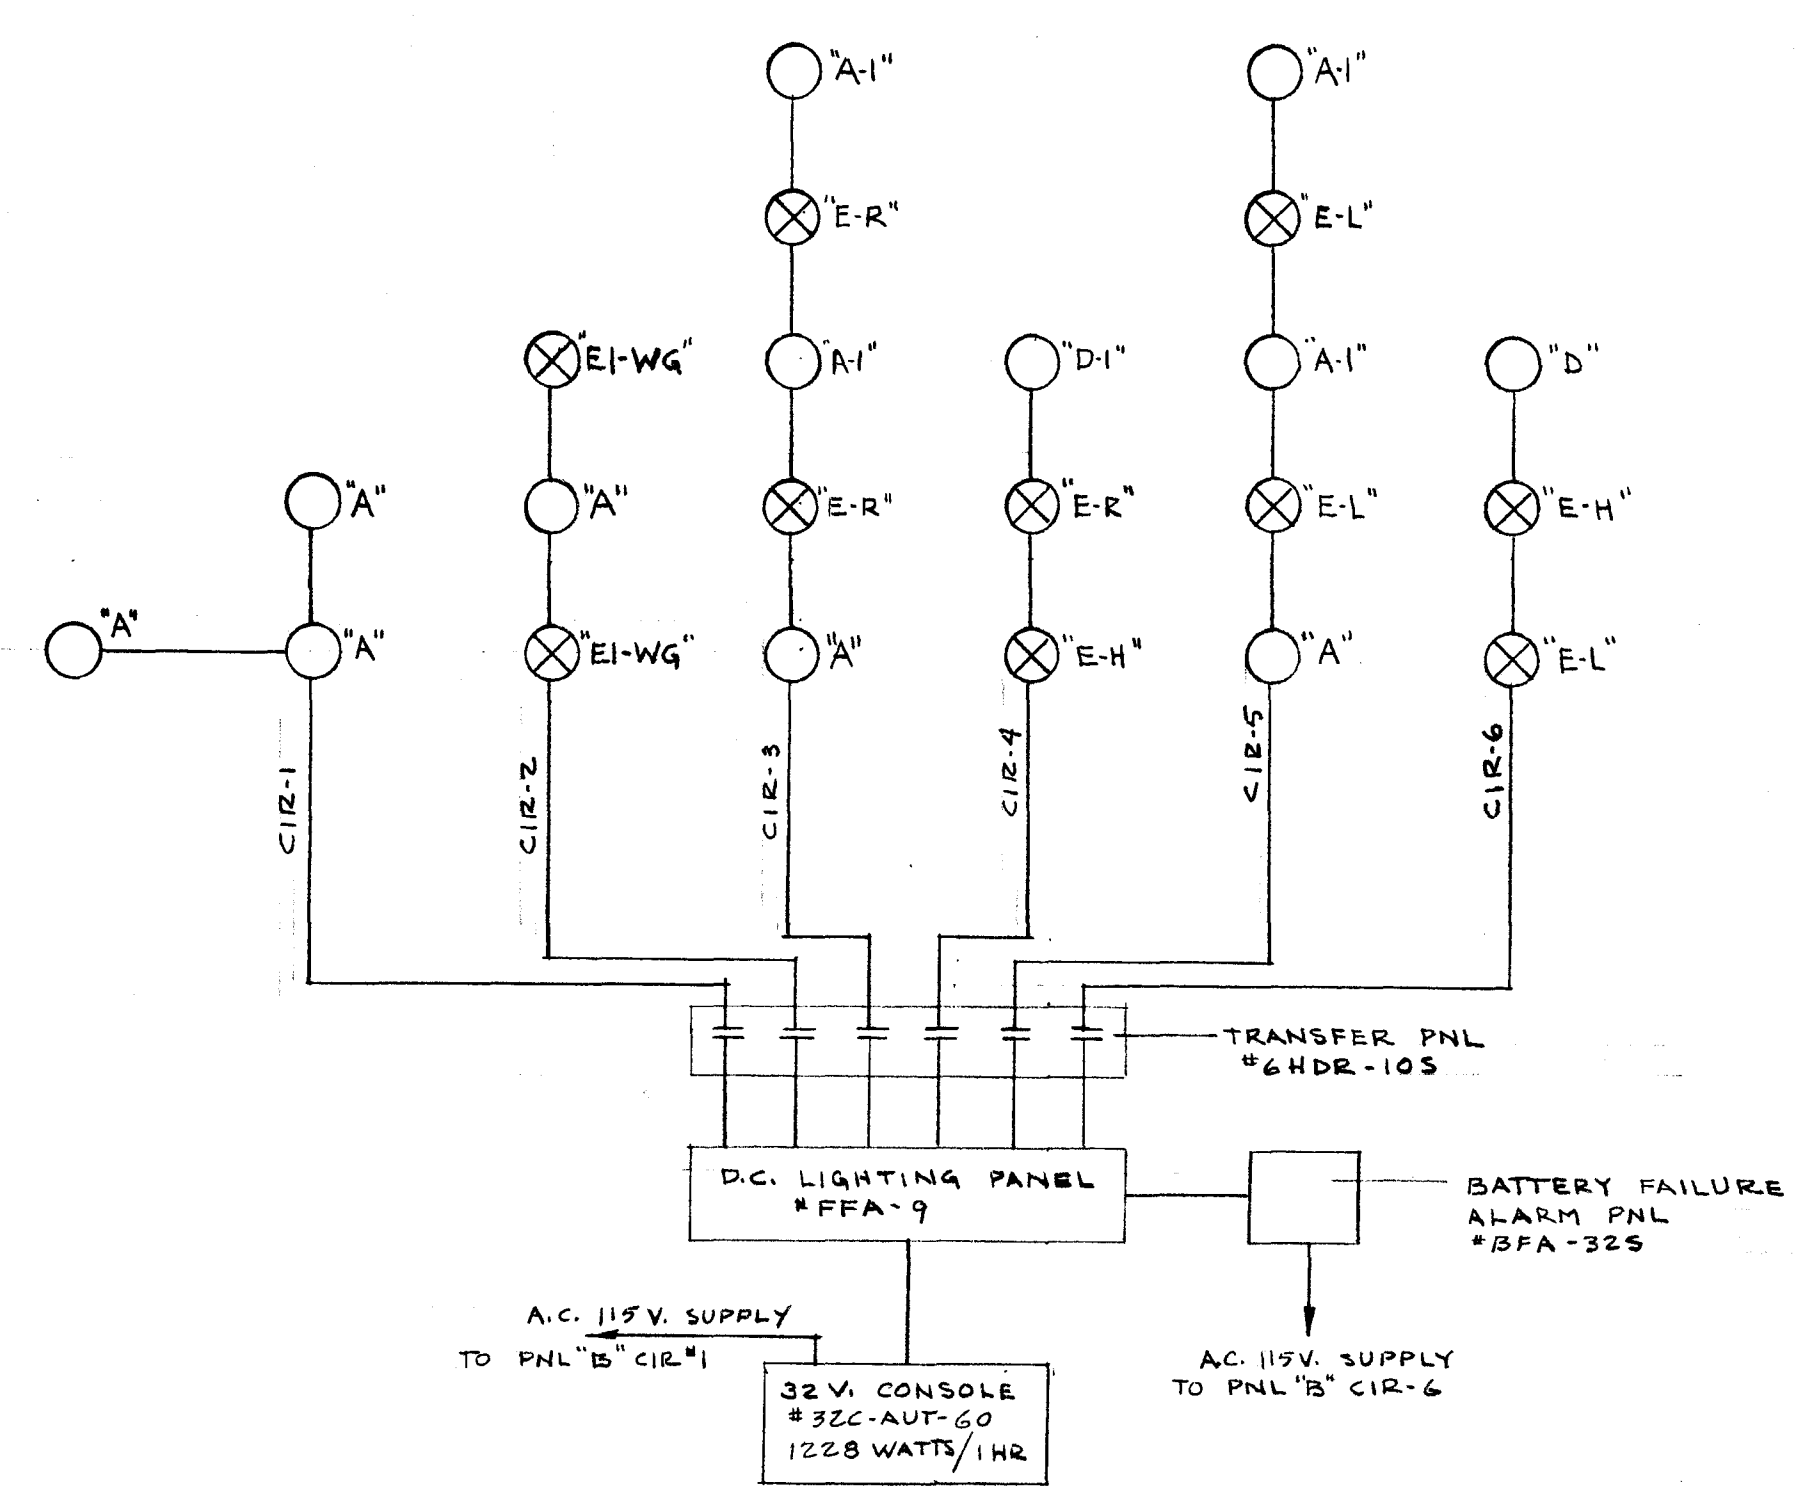


EMERGENCY LIGHTING SCHEMATIC
NO SCALE

FIXTURE		SCHEDULE
TYPE	MANUFACTURER & CATALOG NO	LAMPS
A	DUAL-LITE #EXT-1245	2-32 CP
A-1	" #EXT-1245	2-15 CP
D	" #EXT-OS	2-32 CP
D-1	" #EXT-OS	2-15 CP
E-H	" #EXT-125 H	2-25 WATT AC & 3-15 CP
E-L	" #EXT-125 L	" & "
E-R	" #EXT-125 R	" & "
EI-WG	" #EXT-125 WG	" & 1-15 CP & 2-32 CP

SYMBOL LIST	
SYMBOL	DESCRIPTION
○	EXISTING FIXTURE OR OUTLET
○	CEILING FIXTURE
○	WALL BRACKET
⊗	EXIT LIGHT
■	PANELBOARD
□	AUX. ALARMS FOR BFA & D.C. LTG PNLS

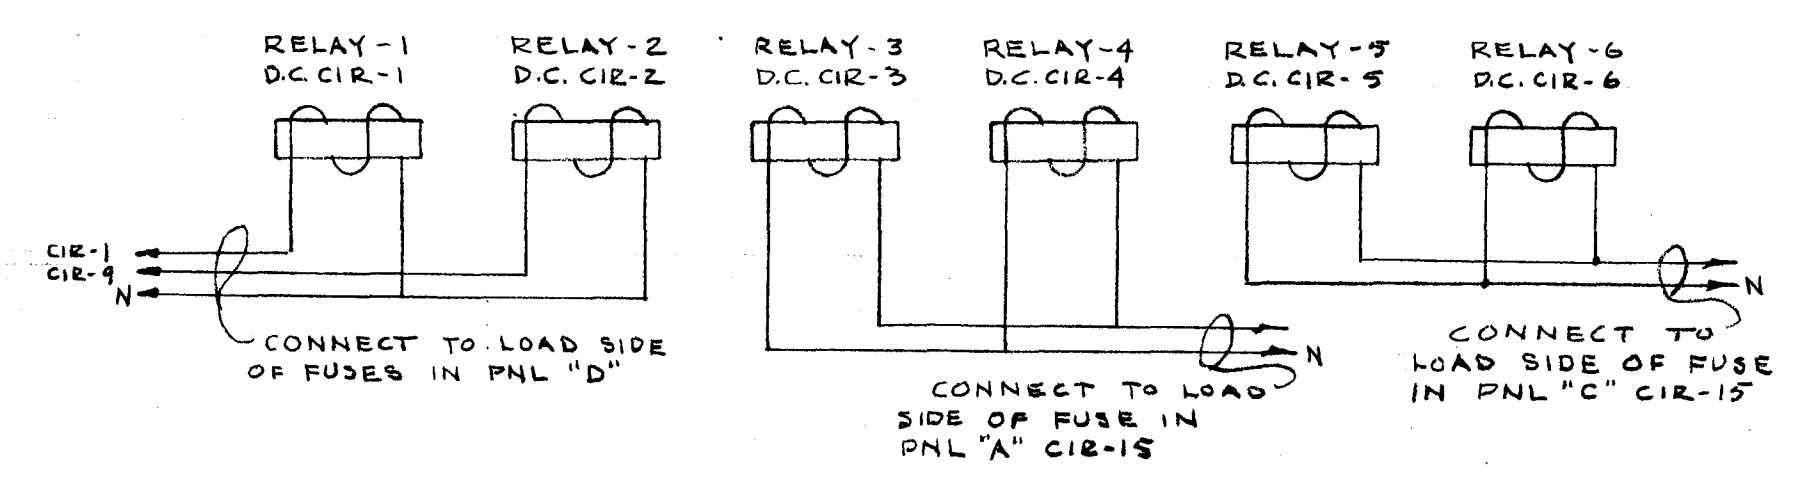

WIRING DIAGRAM FOR A.C. CONTROL
OF RELAYS IN TRANSFER PANEL
NO SCALE

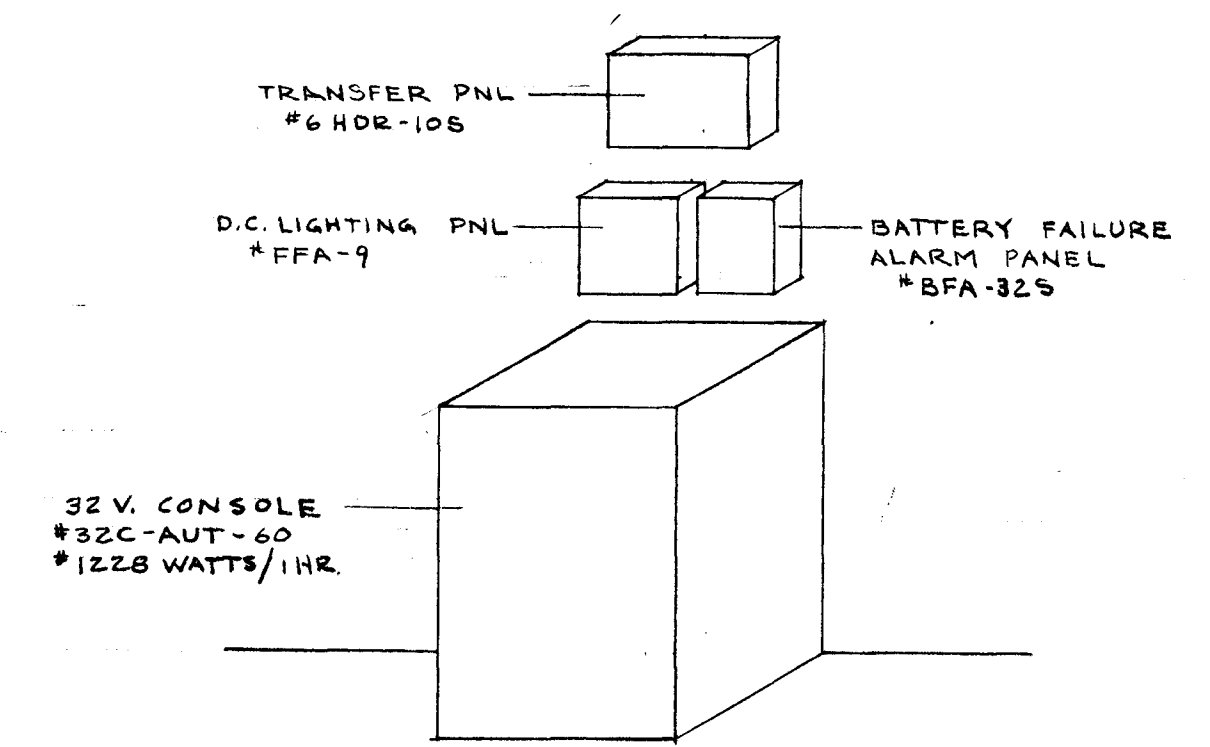

ISOMETRIC OF EMERGENCY EQUIPMENT
NO SCALE

CITY OF HARTFORD, CONNECTICUT
DEPARTMENT OF ENGINEERING

EMERGENCY LIGHTING
FOR
HENRY C. DWIGHT SCHOOL
595 WETHERSFIELD AV., HARTFORD CONN.

SUBMITTED: *David W. Brown* RECOMMENDED: *David W. Brown* APPROVED: *David W. Brown*
DIVISION ARCHITECT: *David W. Brown* CITY ARCHITECT: *David W. Brown* CITY ENGINEER: *David W. Brown*

DESIGN: R.G.B. DRAWN: R.G.B. DAYBOOK NO. 09613-J
TRACED: _____ CHECK: _____ DATE: MARCH 10, 1960