


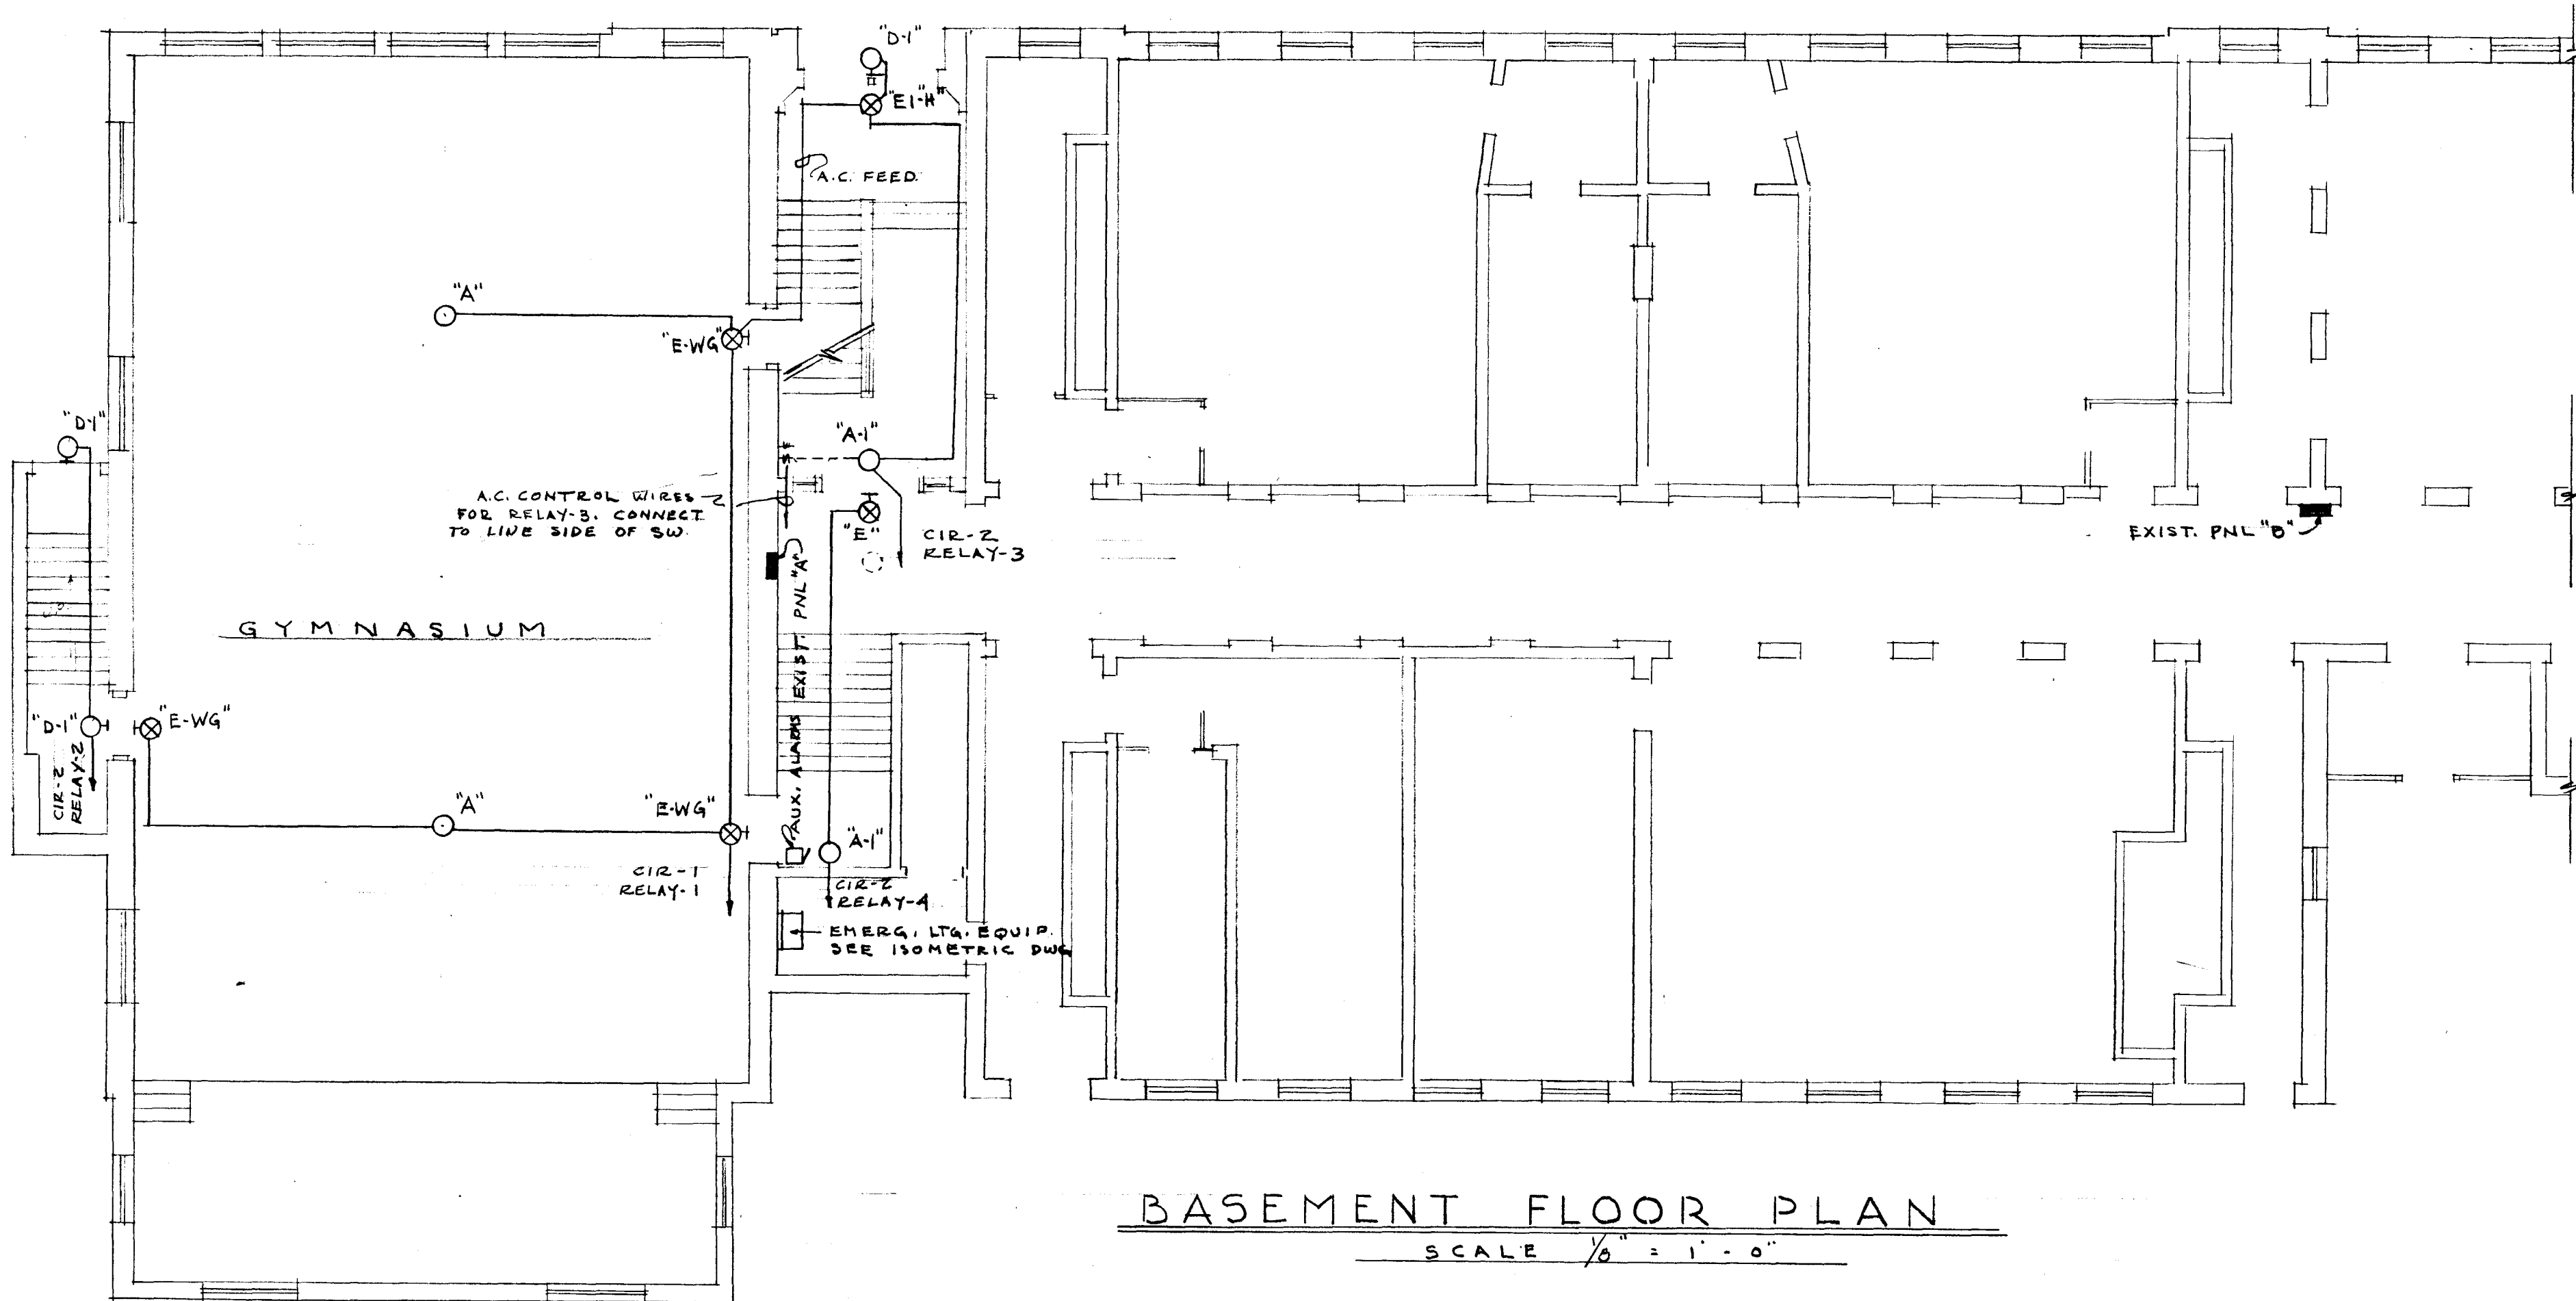


BASEMENT FLOOR PLAN

SCALE 1/8" = 1' - 0"


FIXTURE SCHEDULE		
TYPE	MANUFACTURER & CATALOG NO.	LAMPS
A	DUAL-LITE *EXT-1245	2-32 CP
A-1	" *EXT-1246	2-15 CP
D-1	" *EXT-08	2-15 CP
E	" *EXT-125	2-25WATT A.C. & 3-15 CP
E-WG	" *EXT-125WG	" & "
E-I-H	" *EXT-125H	" & 1-15CP & 2-32 CP

SYMBOL LIST	
SYMBOL	DESCRIPTION
○	EXISTING FIXTURE OR OUTLET
○	CEILING FIXTURE
⊕	WALL BRACKET
⊗	EXIT LIGHT
■	PANELBOARD
□	AUX. ALARMS FOR BFA & D.C. LIGHTING PNLS

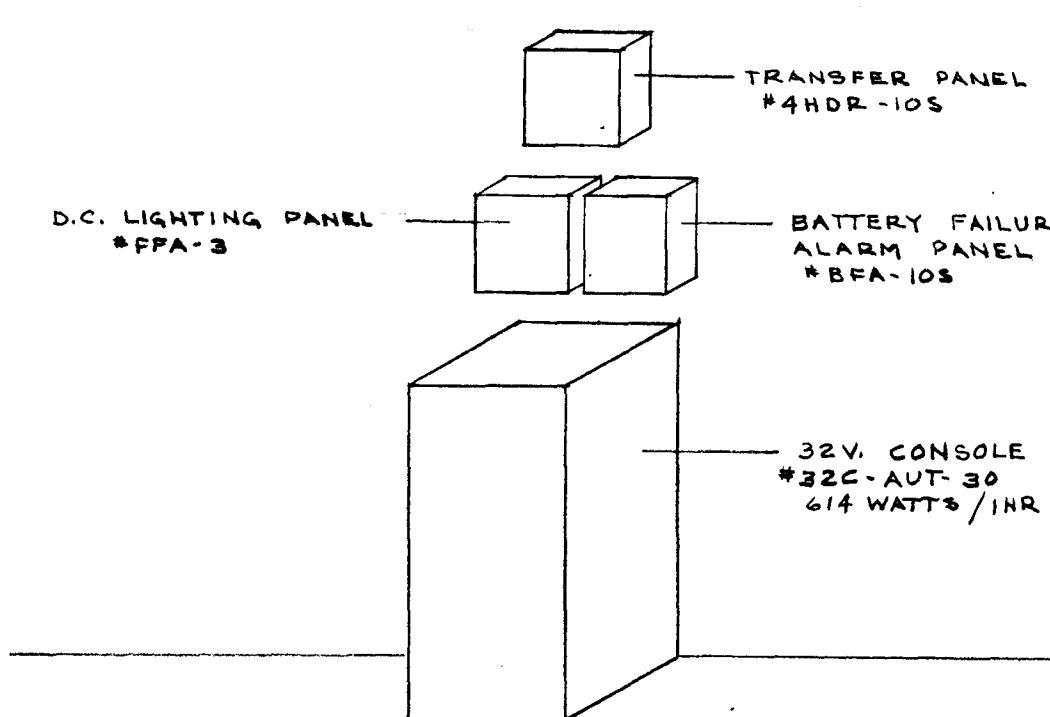


ISOMETRIC OF EMERGENCY EQUIPMENT

NO SCALE

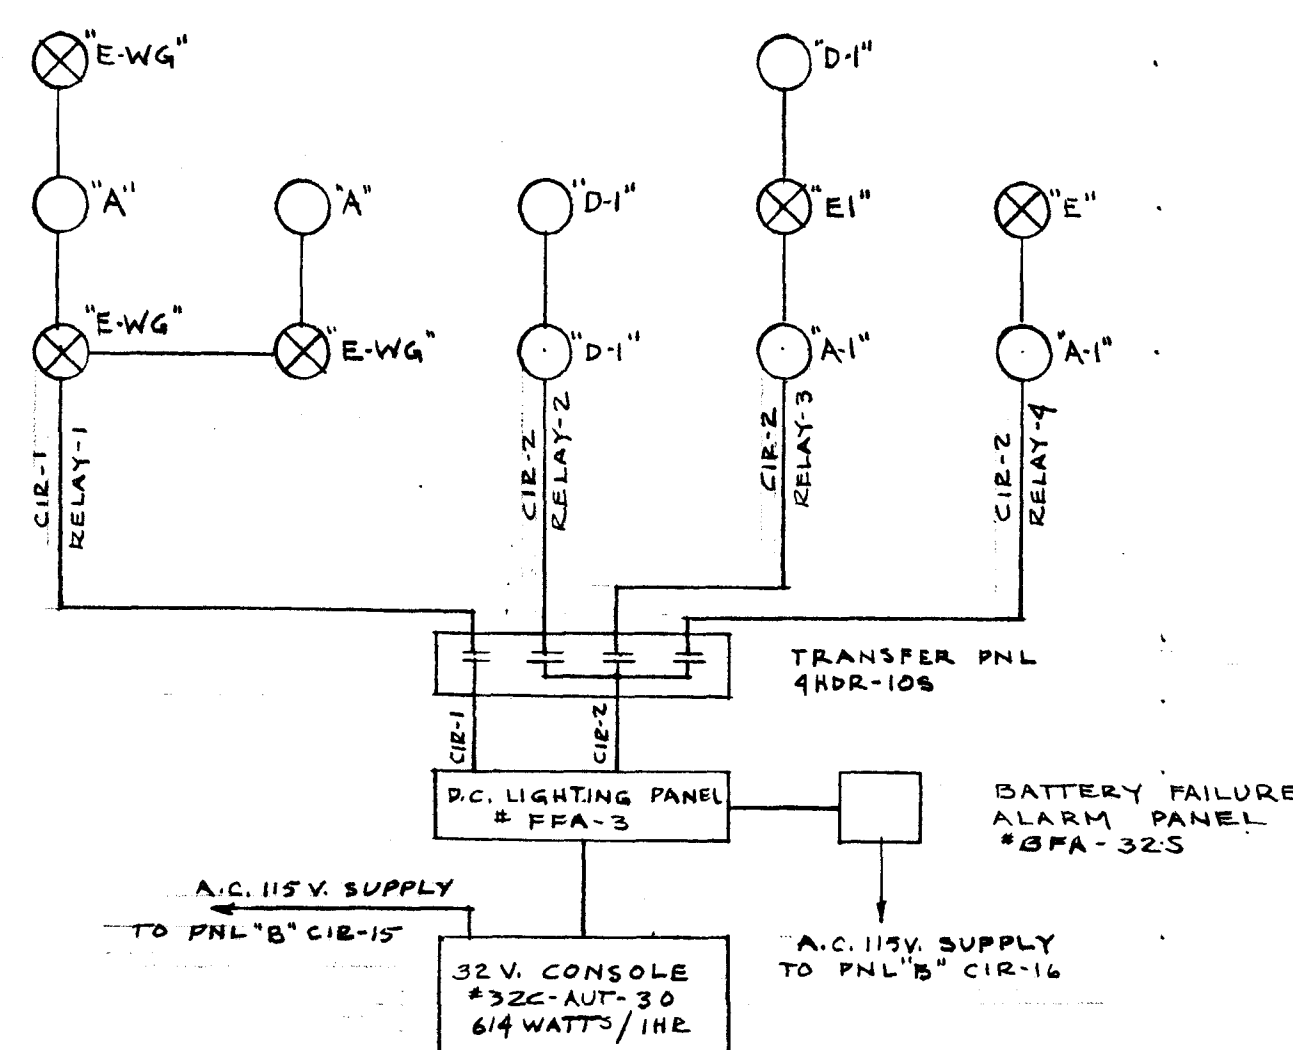

EMERGENCY LIGHTING SCHEMATIC

NO SCALE

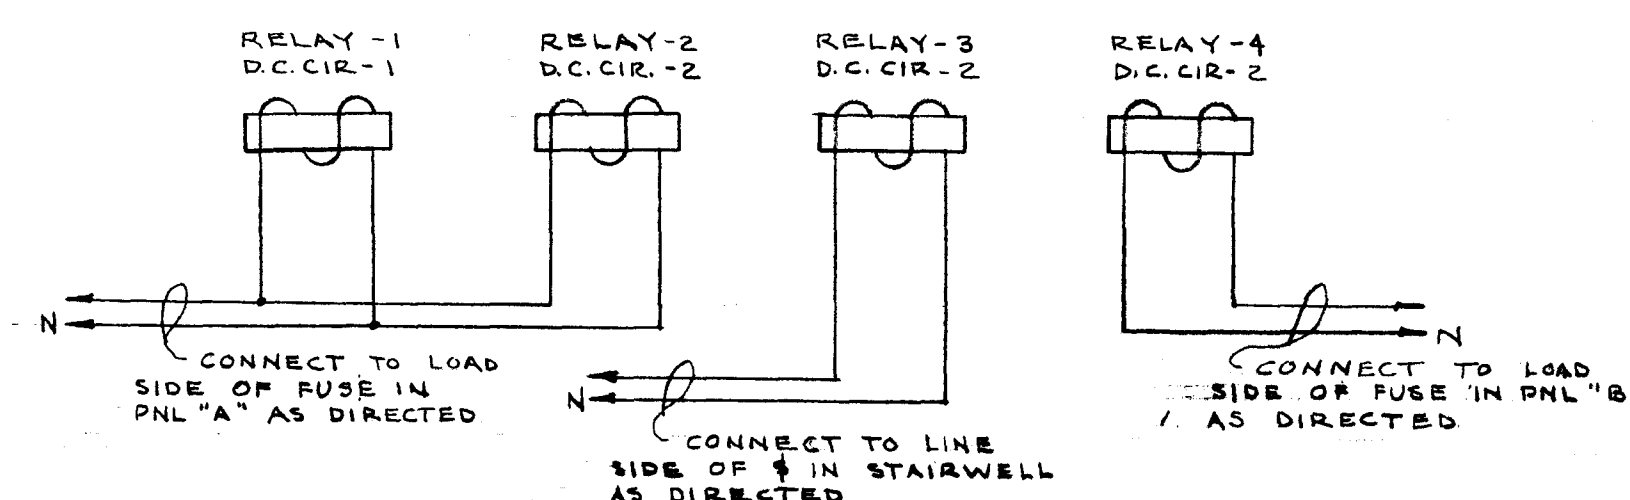

WIRING DIAGRAM FOR A.C. CONTROL OF RELAYS IN TRANSFER PANEL

NO SCALE

CITY OF HARTFORD, CONNECTICUT DEPARTMENT OF ENGINEERING			
EMERGENCY LIGHTING FOR MICHAEL D. FOX SCHOOL 461 WASHINGTON ST., HARTFORD CONN.			
SUBMITTED	RECOMMENDED	APPROVED	
DIVISION ARCHITECT	CITY ARCHITECT	CITY ENGINEER	
DESIGN R.G.B.	DRAWN R.G.B.	DAYBOOK NO. 09613-K.	
TRACED	CHECK	DATE MARCH 10, 1960	

VERIFY EXISTING
CONDITIONS AND
DIMENSIONS AT
BUILDING

11

58