


4
85

4
85

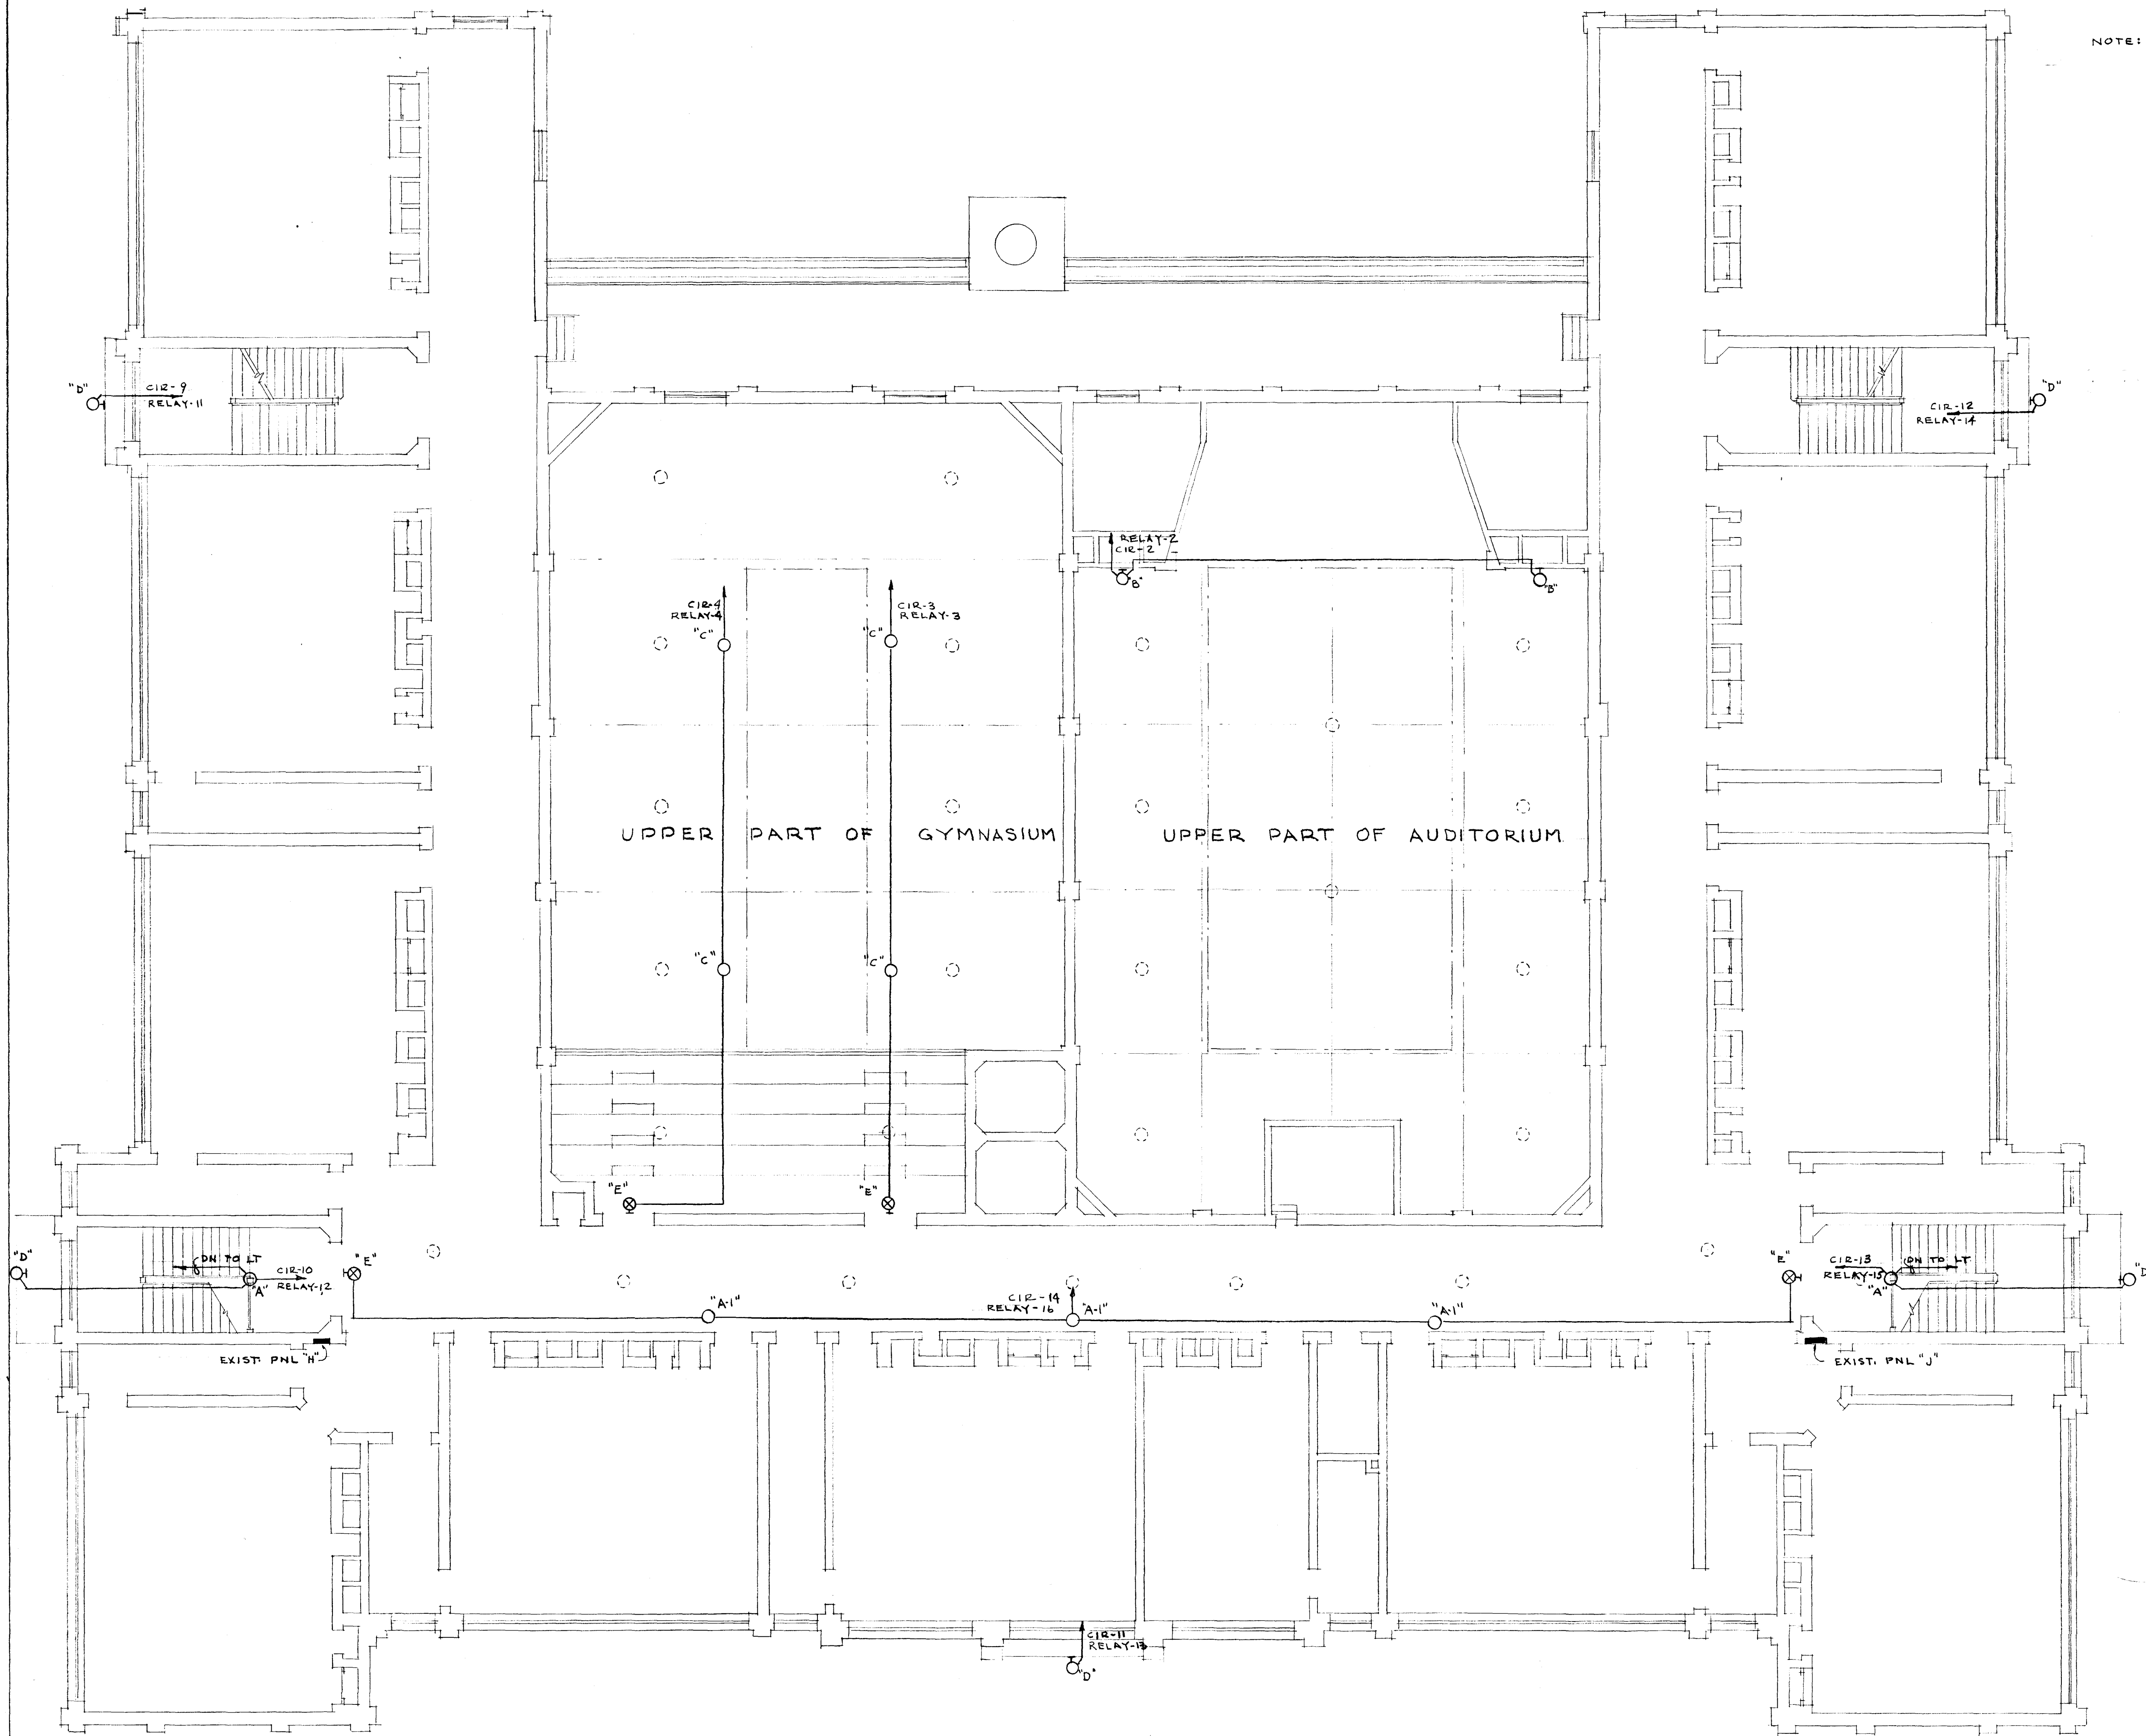

NOTE: TYPE "D" FIXTURES TO BE MOUNTED ON TOP OF PORTICO IN SUCH WAY AS TO ILLUMINATE STAIRS BELOW.

SECOND FLOOR PLAN
SCALE 1/8" = 1'-0"

133

CITY OF HARTFORD, CONNECTICUT DEPARTMENT OF ENGINEERING		
EMERGENCY LIGHTING FOR JAMES H. NAYLOR SCHOOL 645 FRANKLIN AV., HARTFORD CONN.		
SUBMITTED DIVISION ARCHITECT DESIGN R.G.B. TRACED	RECOMMENDED CITY ARCHITECT DRAWN R.G.B. CHECK	APPROVED CITY ENGINEER DAYBOOK NO. 09613-M DATE MARCH 10, 1960

VERIFY EXISTING
CONDITIONS AND
DIMENSIONS AT
BUILDING

4
85

4
85