
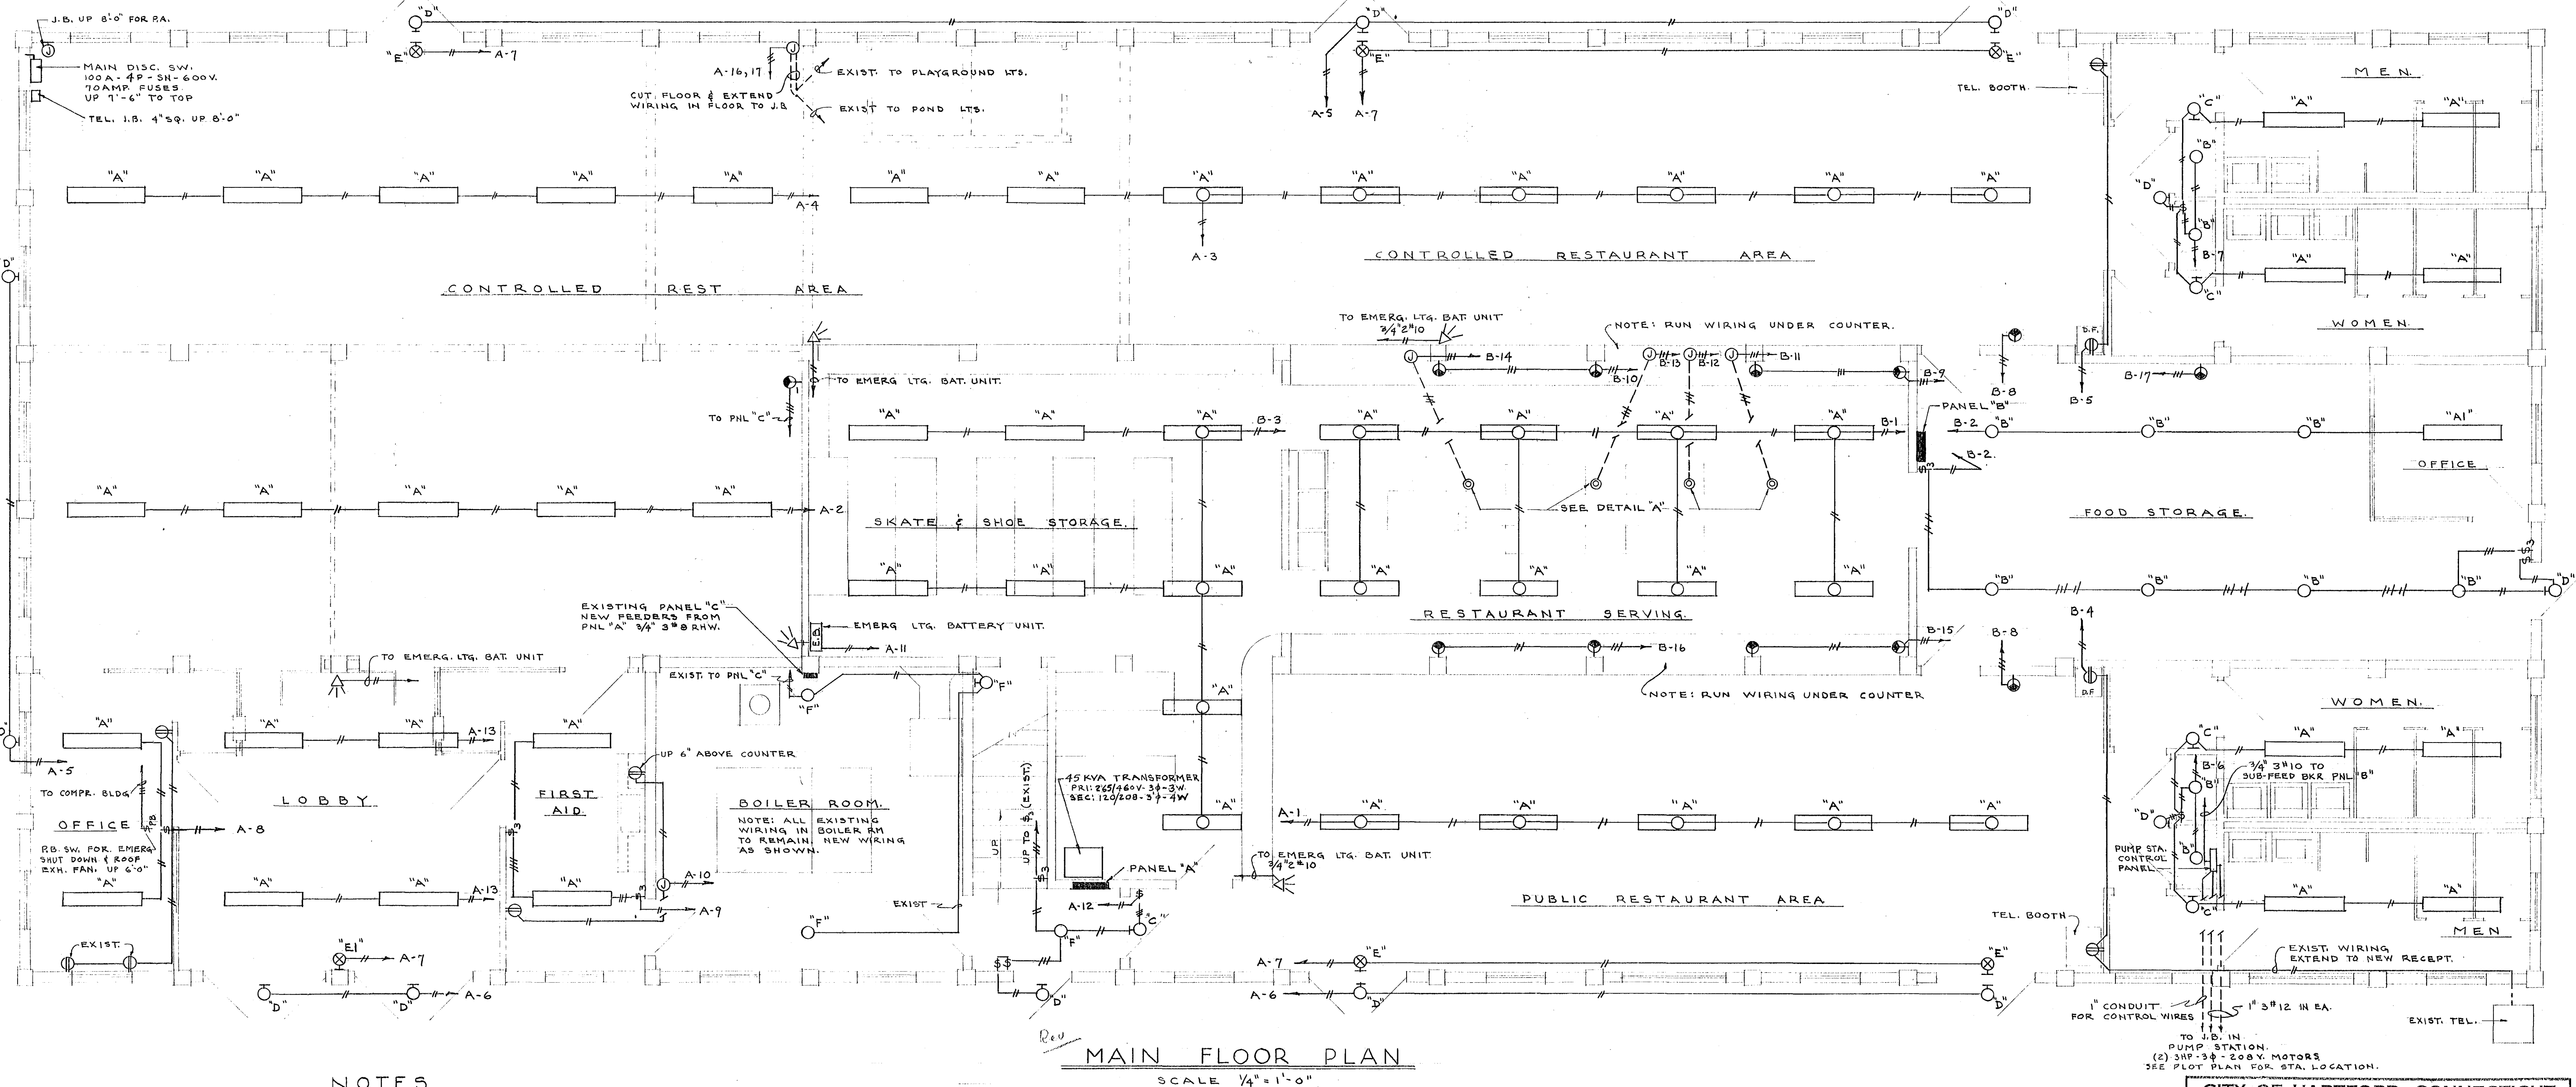


SYMBOL	DESCRIPTION
○	CEILING OUTLET
□	FLUORESCENT FIXTURE
⊖	WALL BRACKET
⊗	EXIT LIGHT
⊕	DUPLEX CONV. OUTLET - H&H #5262 - UP 1'-6"
⊖	125/250V. RECEPTACLE - H&H #5292 - UP 6" ABOVE COUNTER
⊖	" " - H&H #5292 - UP 1'-6"
⊖	" " - (2) H&H #5292 - SEE DETAIL "A"
⊕	JUNCTION BOX
⊕	SINGLE POLE SW - H&H #1891 - UP 4'-6"
⊕	THREE-WAY SW - H&H #1893 - UP 4'-6"
⊕	EMERGENCY LIGHTING BATTERY UNIT - DUAL-LITE #PC-40-NC-UP 7'-0"
⊕	EMERGENCY LIGHTING FIXTURE - DUAL-LITE #EXT-696B - UP 8'-0"
⊕	PANELBOARD
⊕	FUSED DISCONNECT SWITCH
⊕	MAGNETIC MOTOR STARTER
⊕	EMERG. PUSH BUTTON SW. FOR COMPRESSOR BLDG. A-H #6115 UP 6'-0"

PANEL	BRANCHES	MAINS	SERVICE	SUB-FEED BKR	REMARKS
A	22-1P-20A.	200A.	120/208V-3φ-4W.	1-3P-E-100A.	FLUSH MTD.
B	1-2P-50A.			(FOR PNL "B")	
	10-1P-20A.	100A.	120/208V-3φ-4W.	1-3P-E-50A.	SURFACE MTD.
C	10-2P-20A.			(FOR PUMP STA.)	
			120/208V-1φ-3W.		EXISTING.

TYPE	MANUFACTURER & CATALOG NO.	MOUNTING HGT.	WATTS
A	ELECTRO LIGHTING CORP # B240 RSH		100
A1	SAME AS "A" EXCEPT WITH PULL CHAIN.		100
B	H&H #829		60
C	PRESCOLITE #WB-24 - SATIN CHROME	UP 7'-6"	100
D	PRESCOLITE #WB-24 - SATIN CHROME	OVER DOOR	200
E	EXISTING - RELOCATE AS SHOWN.	" "	2-25's
E1	DAYBRITE #2516	" "	2-25's
F	EXISTING		

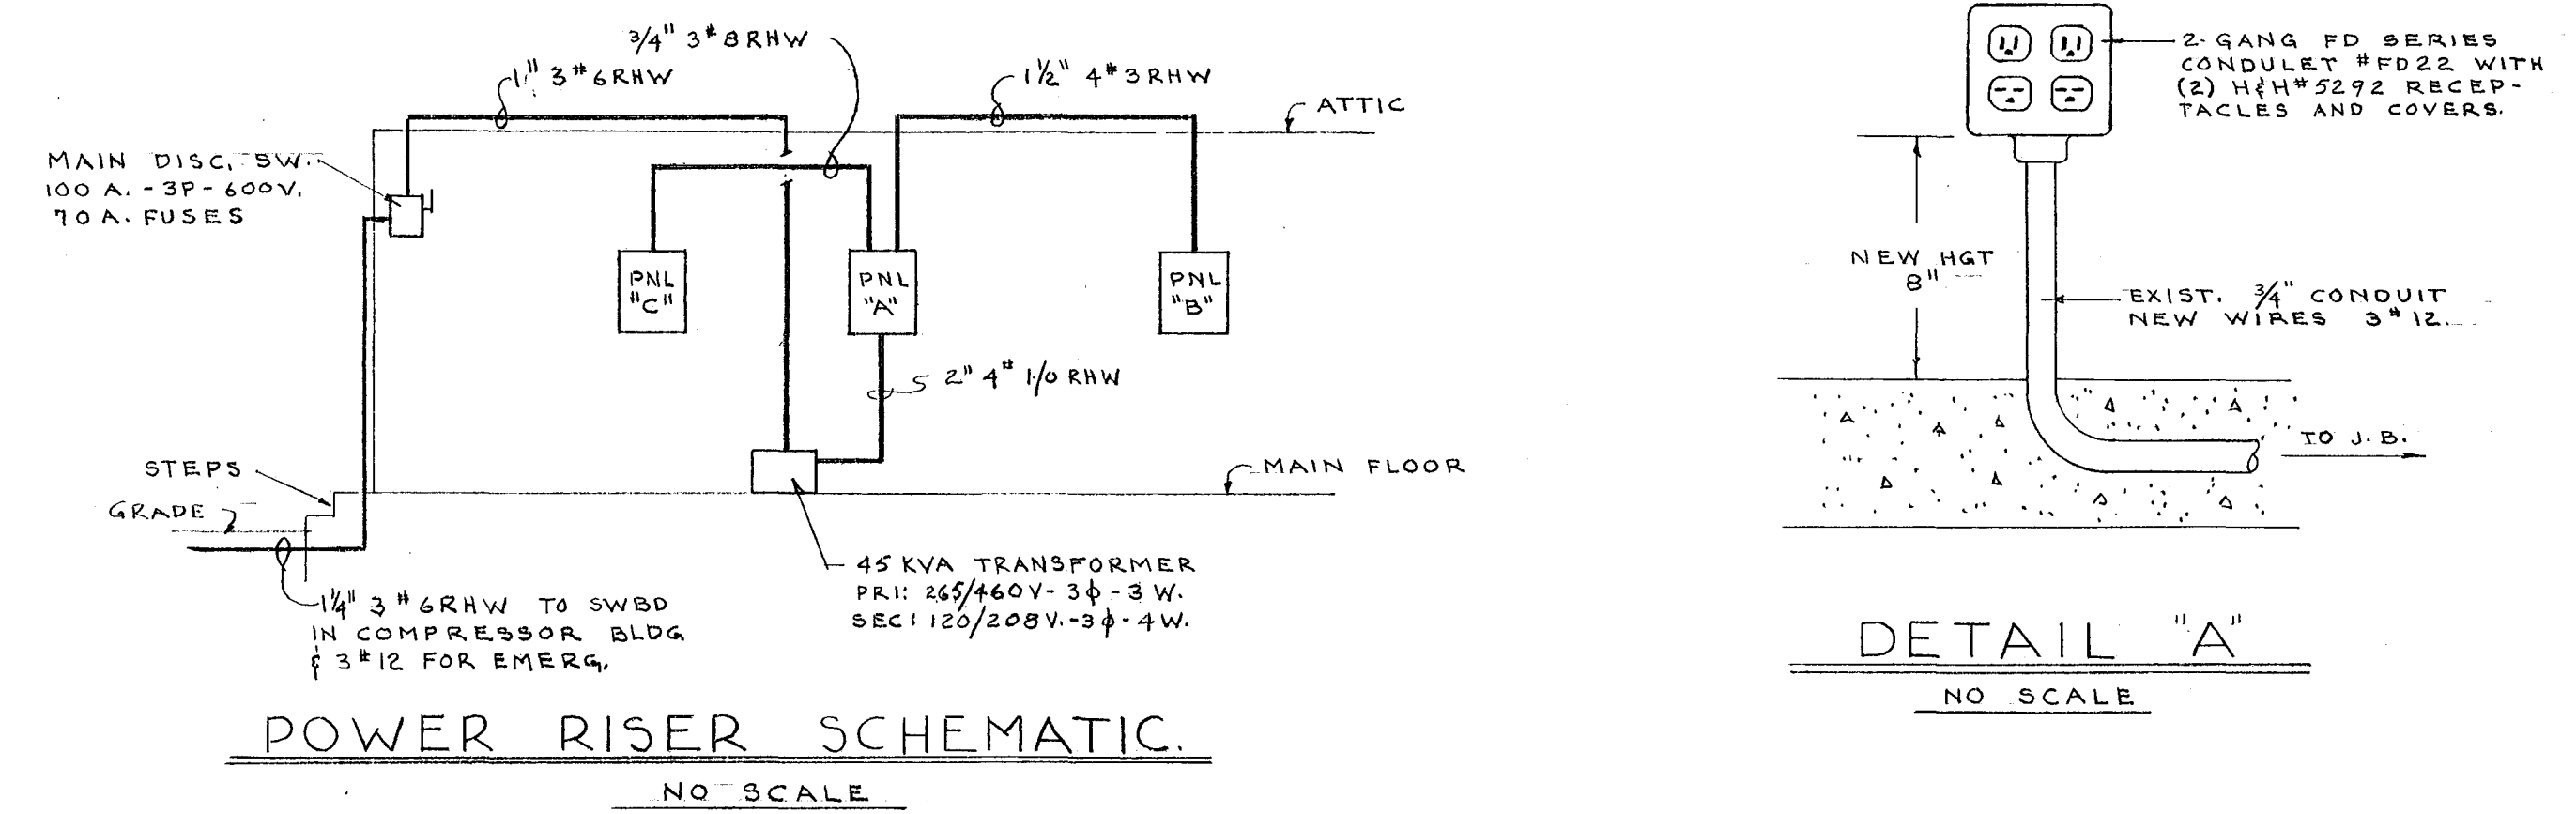

NOTES

- ALL EXISTING EXPOSED WIRING, WIRING DEVICES, APPLIANCES, LIGHTING FIXTURES ETC. ON MAIN FLOOR SHALL BE REMOVED EXCEPT WHERE SHOWN. CONDUIT STUB-UPS SHALL BE CUT FLUSH WITH FLOOR AND PLUGGED.
- ALL EXISTING WIRING, WIRING DEVICES, APPLIANCES, LIGHTING FIXTURES, ETC. IN ATTIC SHALL REMAIN. PROVIDE NEW HOME RUNS TO PANEL "A" FOR EACH EXISTING ATTIC BRANCH CIRCUIT.
- ALL OUTSIDE FIXTURES SHALL BE REMOVED AND OUTLETS CAPPED EXCEPT WHERE NEW FIXTURES ARE TO BE INSTALLED.

BEMIS & FREEMAN
CONSULTING ENGINEERS
36 PEARL STREET
HARTFORD, CONN.
COMM. NO.
1455

CITY OF HARTFORD, CONNECTICUT DEPARTMENT OF ENGINEERING		
FLOOR PLAN - REFECT. ICE SKATING RINK COLT PARK HARTFORD, CONN.		DWG NO. E33
SUBMITTED DIVISION ARCHITECT JAMES J. GUERRE CITY ARCHITECT	RECOMMENDED CITY ARCHITECT DAVID J. CASILLI CITY ENGINEER	APPROVED CITY ENGINEER WILLIAM W. BRIDGES
DESIGN: V.J.S.	DRAWN: R.G.B.	DAYBOOK NO. 09635- AA
TRACED: R.G.B.	CHECK: V.J.S.	DATE: JUNE 22, 1960