




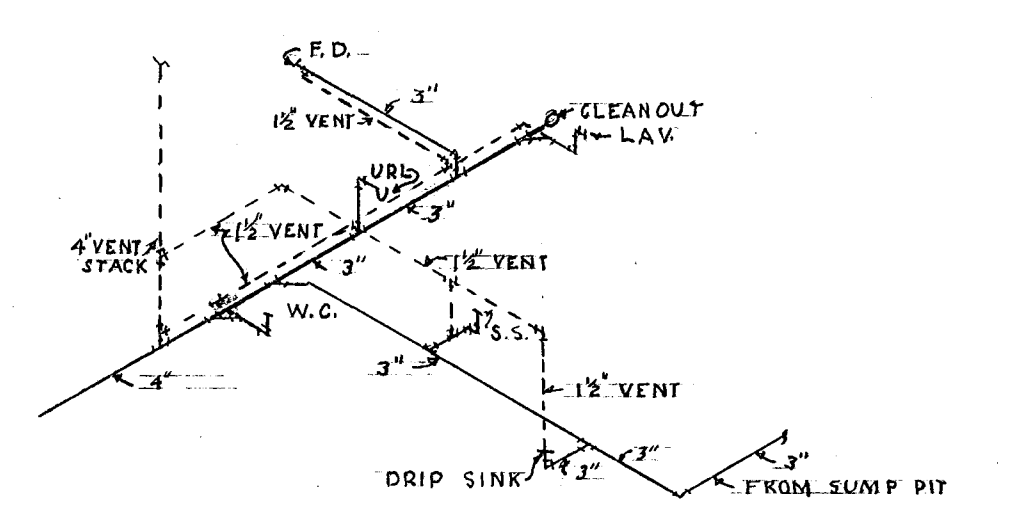

SOIL, WASTE AND VENT PIPING
ISOMETRIC FOR TOILET
NO SCALE

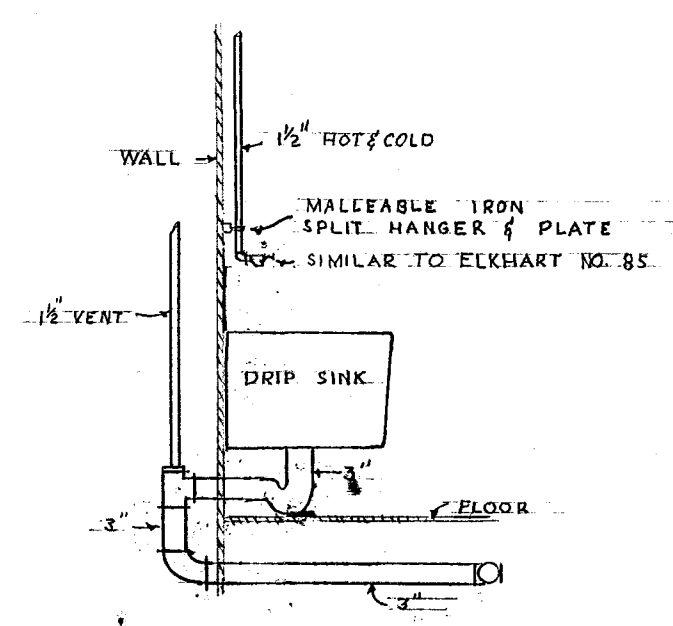


DRIP SINK DETAIL
NO SCALE

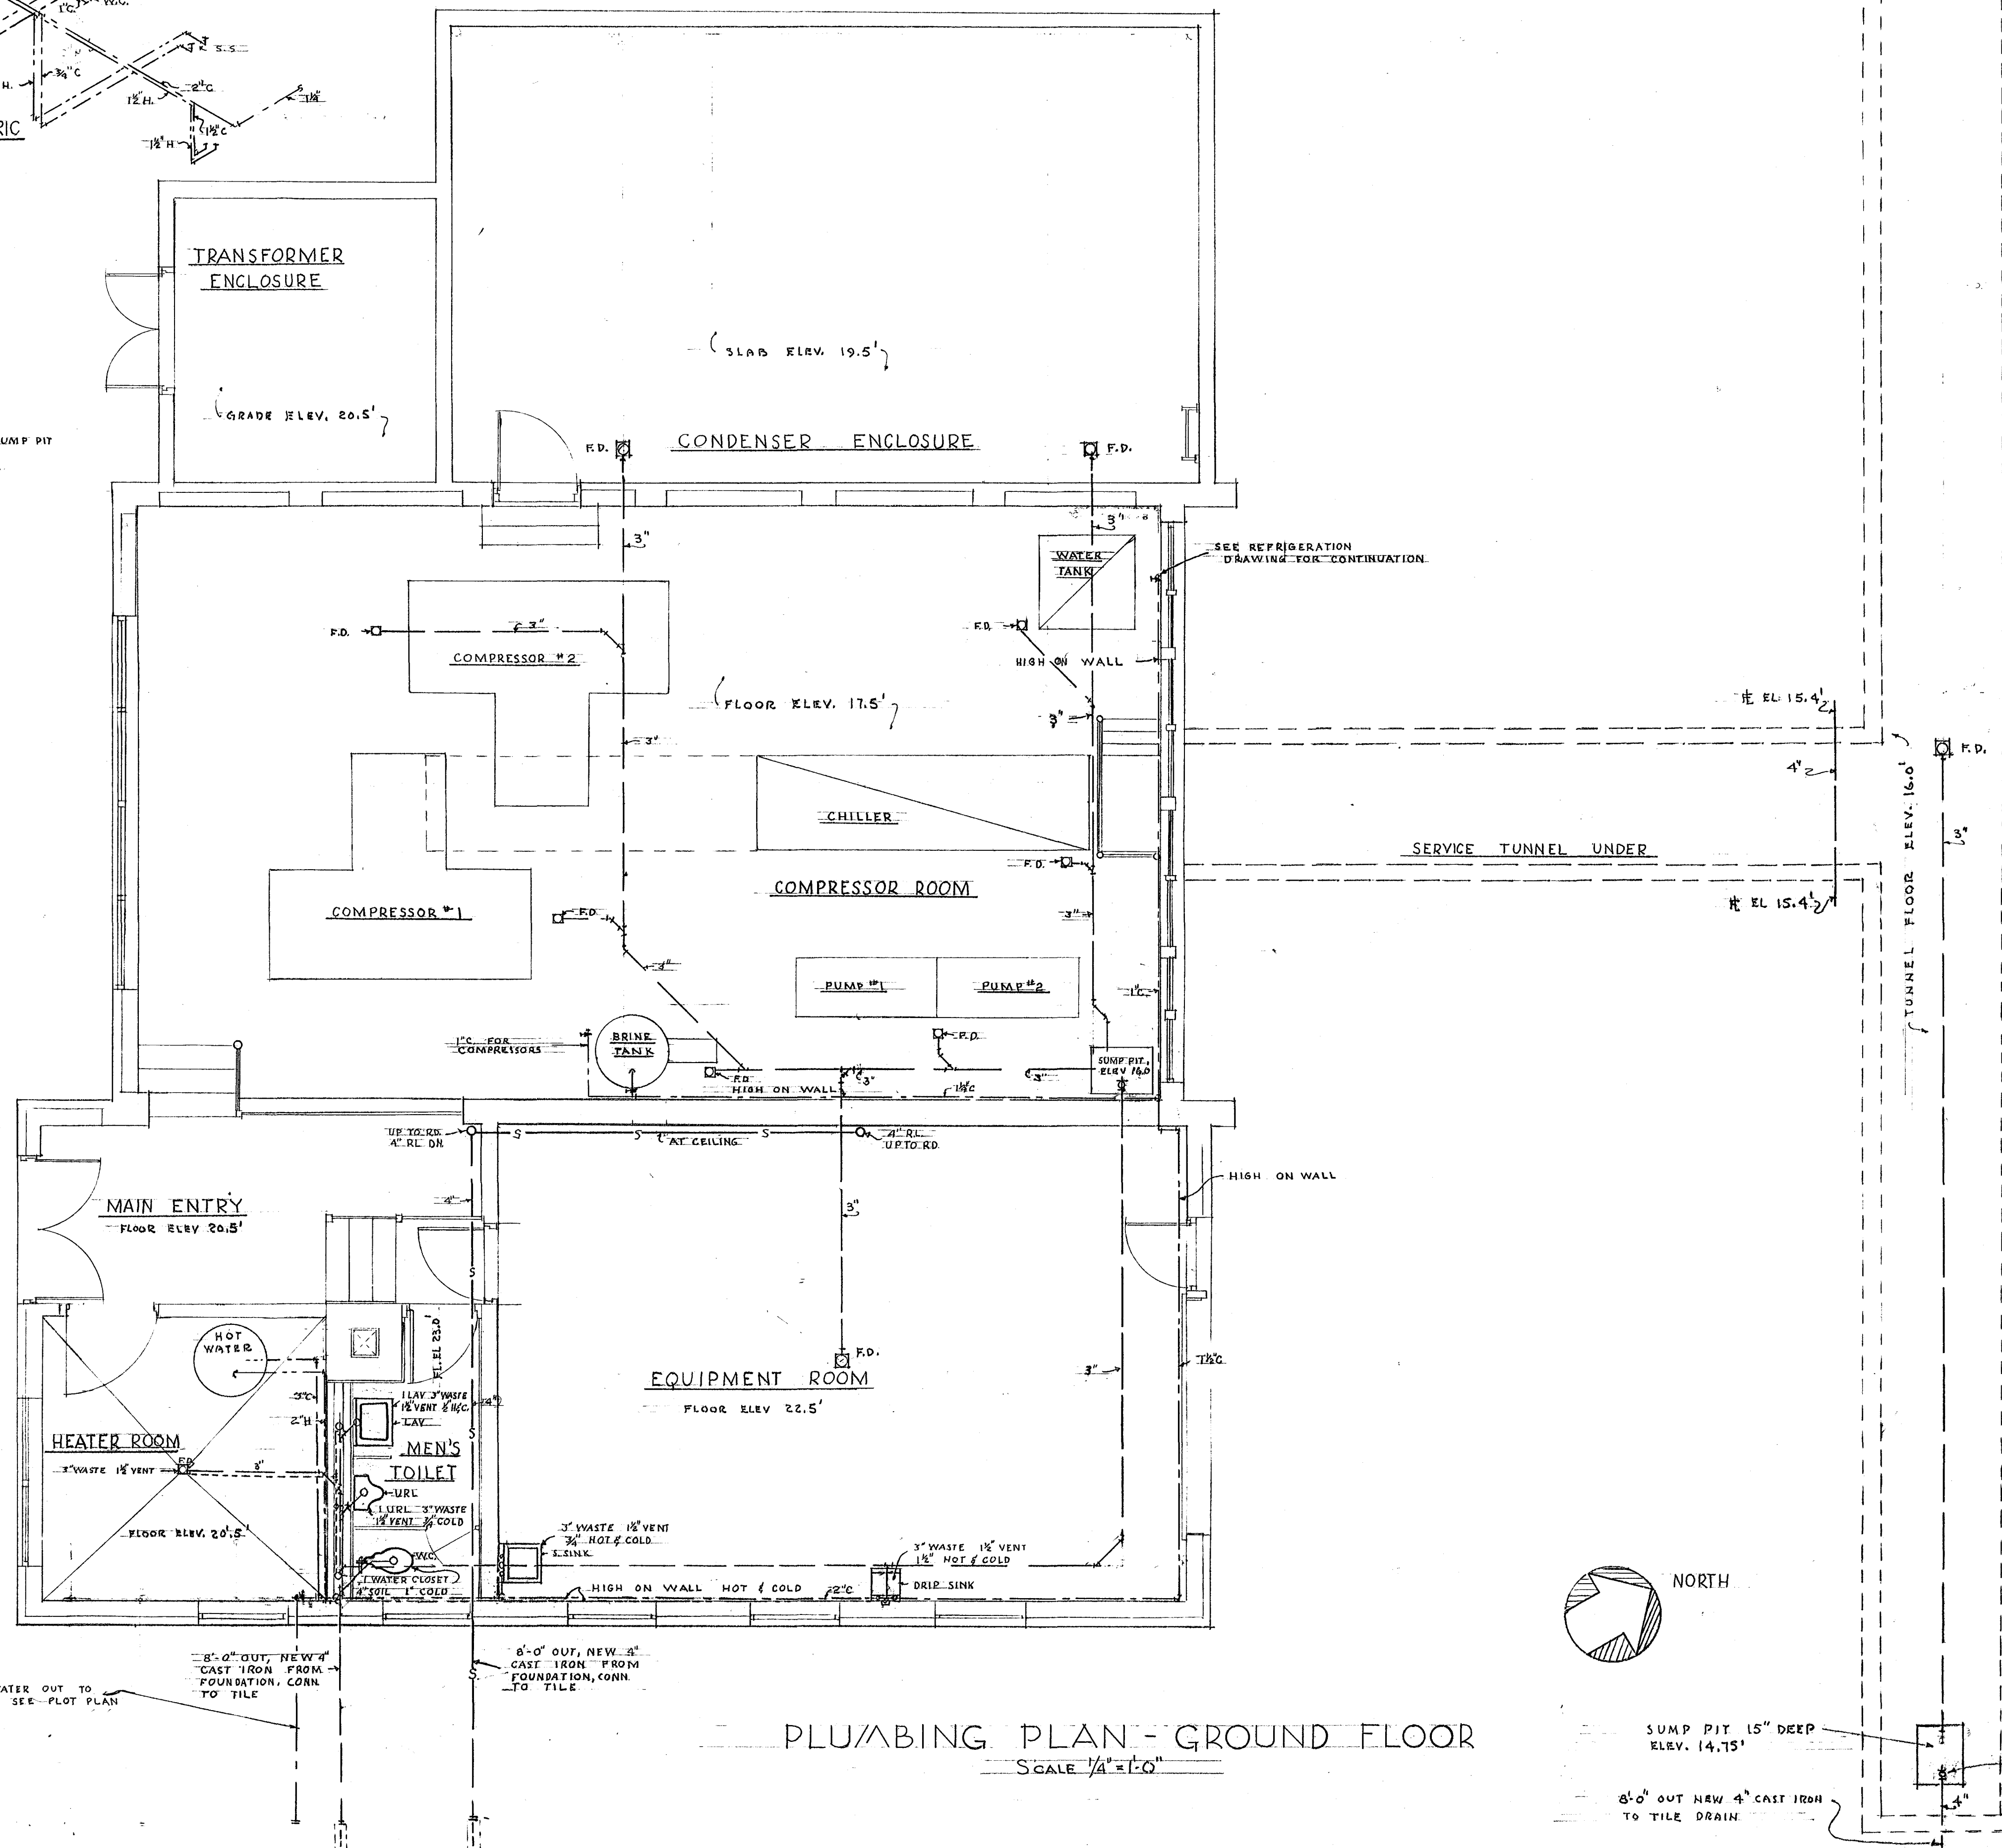


PLUMBING PLAN - GROUND FLOOR


SCALE 1/4" = 1'-0"

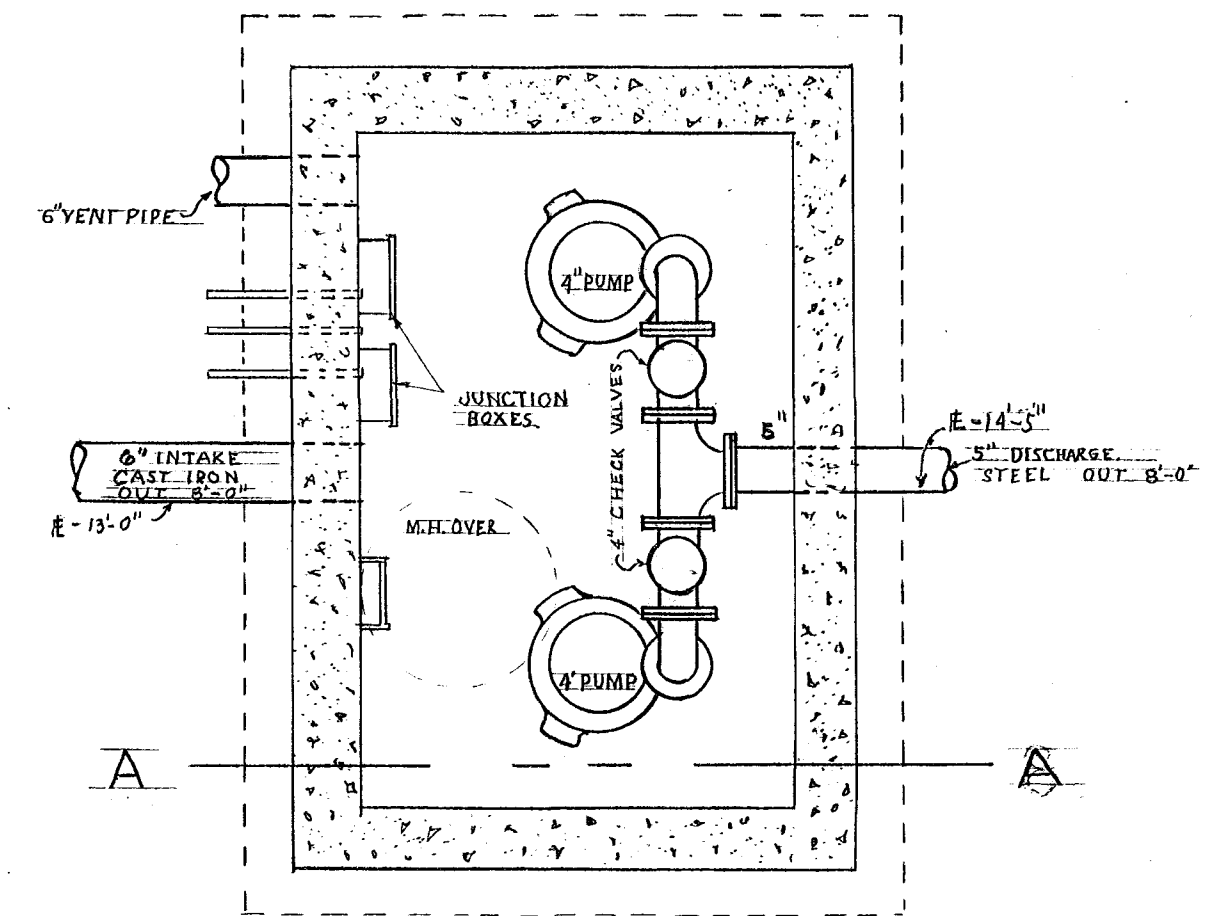

PLAN THRU PUMP STATION
SCALE - 1" = 10'

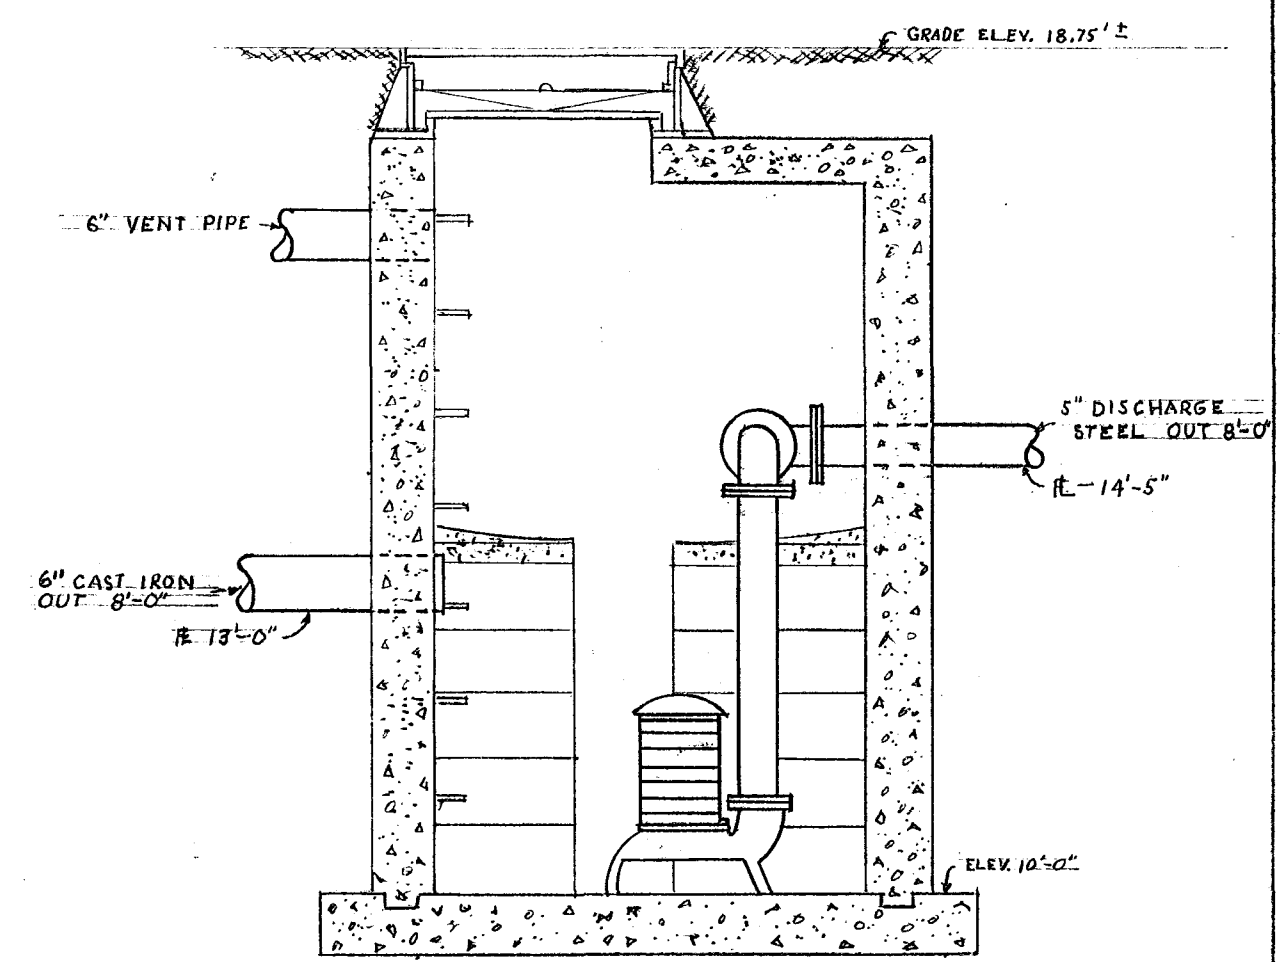

SECTION THRU A
SCALE - $\frac{1}{2}" = 1'-0"$

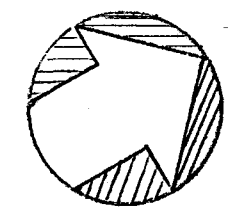

NORTH

SUMP PIT. 1
ELEV. 14.75'

8'-0" OUT NEW 4" CAST IRON
TO TILE DRAIN



BEMIS & FREEMAN
CONSULTING ENGINEERS
36 PEARL STREET
HARTFORD, CONN.
COMM. NO. 1455

CITY OF HARTFORD, CONNECTICUT
DEPARTMENT OF ENGINEERING

FLOOR PLAN-EQUIP. BLDG.
ICE SKATING RINK
COLT PARK
HARTFORD, CONN.

DWG. N°



SUBMITTED <i>Amal K. Panwar</i> DIVISION ARCHITECT	RECOMMENDED <i>David L. Tice</i> CITY ARCHITECT	APPROVED <i>W. J. Sullivan</i> CITY ENGINEER
DESIGN <i>R. B. Little</i>	DRAWN <i>M. B.</i>	DAYBOOK NO. 09635- W
TRACED <i>M. B.</i>	CHECK <i>C. W. F.</i>	DATE JUNE 22, 1960