



NOTES:

1. ALL LINES OF PIPING ETC. SHOWN ARE DIAGRAMMATIC ONLY. EXACT LOCATIONS SHALL BE DETERMINED ON THE JOB AND IN CONJUNCTION WITH THE OTHER TRADES.
2. PROVIDE ALL AIR CHAMBERS AS REQUIRED TO PREVENT WATER HAMMER.
3. PROVIDE STOPS ON BOTH HOT AND COLD WATER LINES AT EACH INDIVIDUAL FIXTURE.
4. ALL FIXTURES, FLOOR DRAIN, AND ENDS OF ALL BRANCH LINES SHALL BE VENTED.
5. ALL PIPING BELOW SLAB AND IN FILL SHALL NOT BE LESS THAN 3", EXCEPT VENT FROM FLOOR DRAINS ETC., WHICH MAY BE 2" AND MAY BE DECREASED TO 1 1/2" UPON RISING ABOVE FLOOR LEVEL.
6. THE ENTIRE INSTALLATION SHALL BE ACCORDING TO THE LOCAL CODES AND TO THE SATISFACTION OF THE PLUMBING AND HEALTH INSPECTORS. FURNISH AND INSTALL ANY SPECIAL TRAPS AND VENTS REQUIRED BY SAID INSPECTORS.

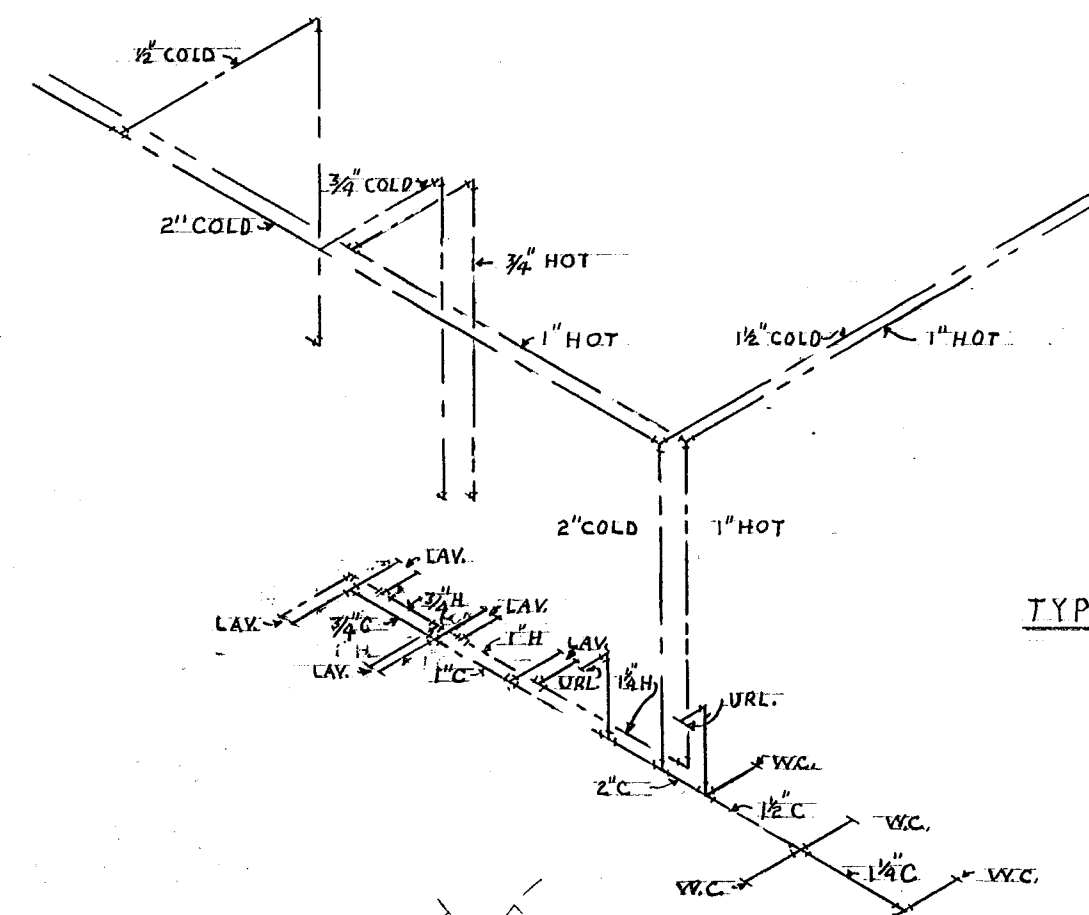

TYPICAL ISOMETRIC OF HOT & COLD WATER PIPING FOR TOILETS
NO SCALE

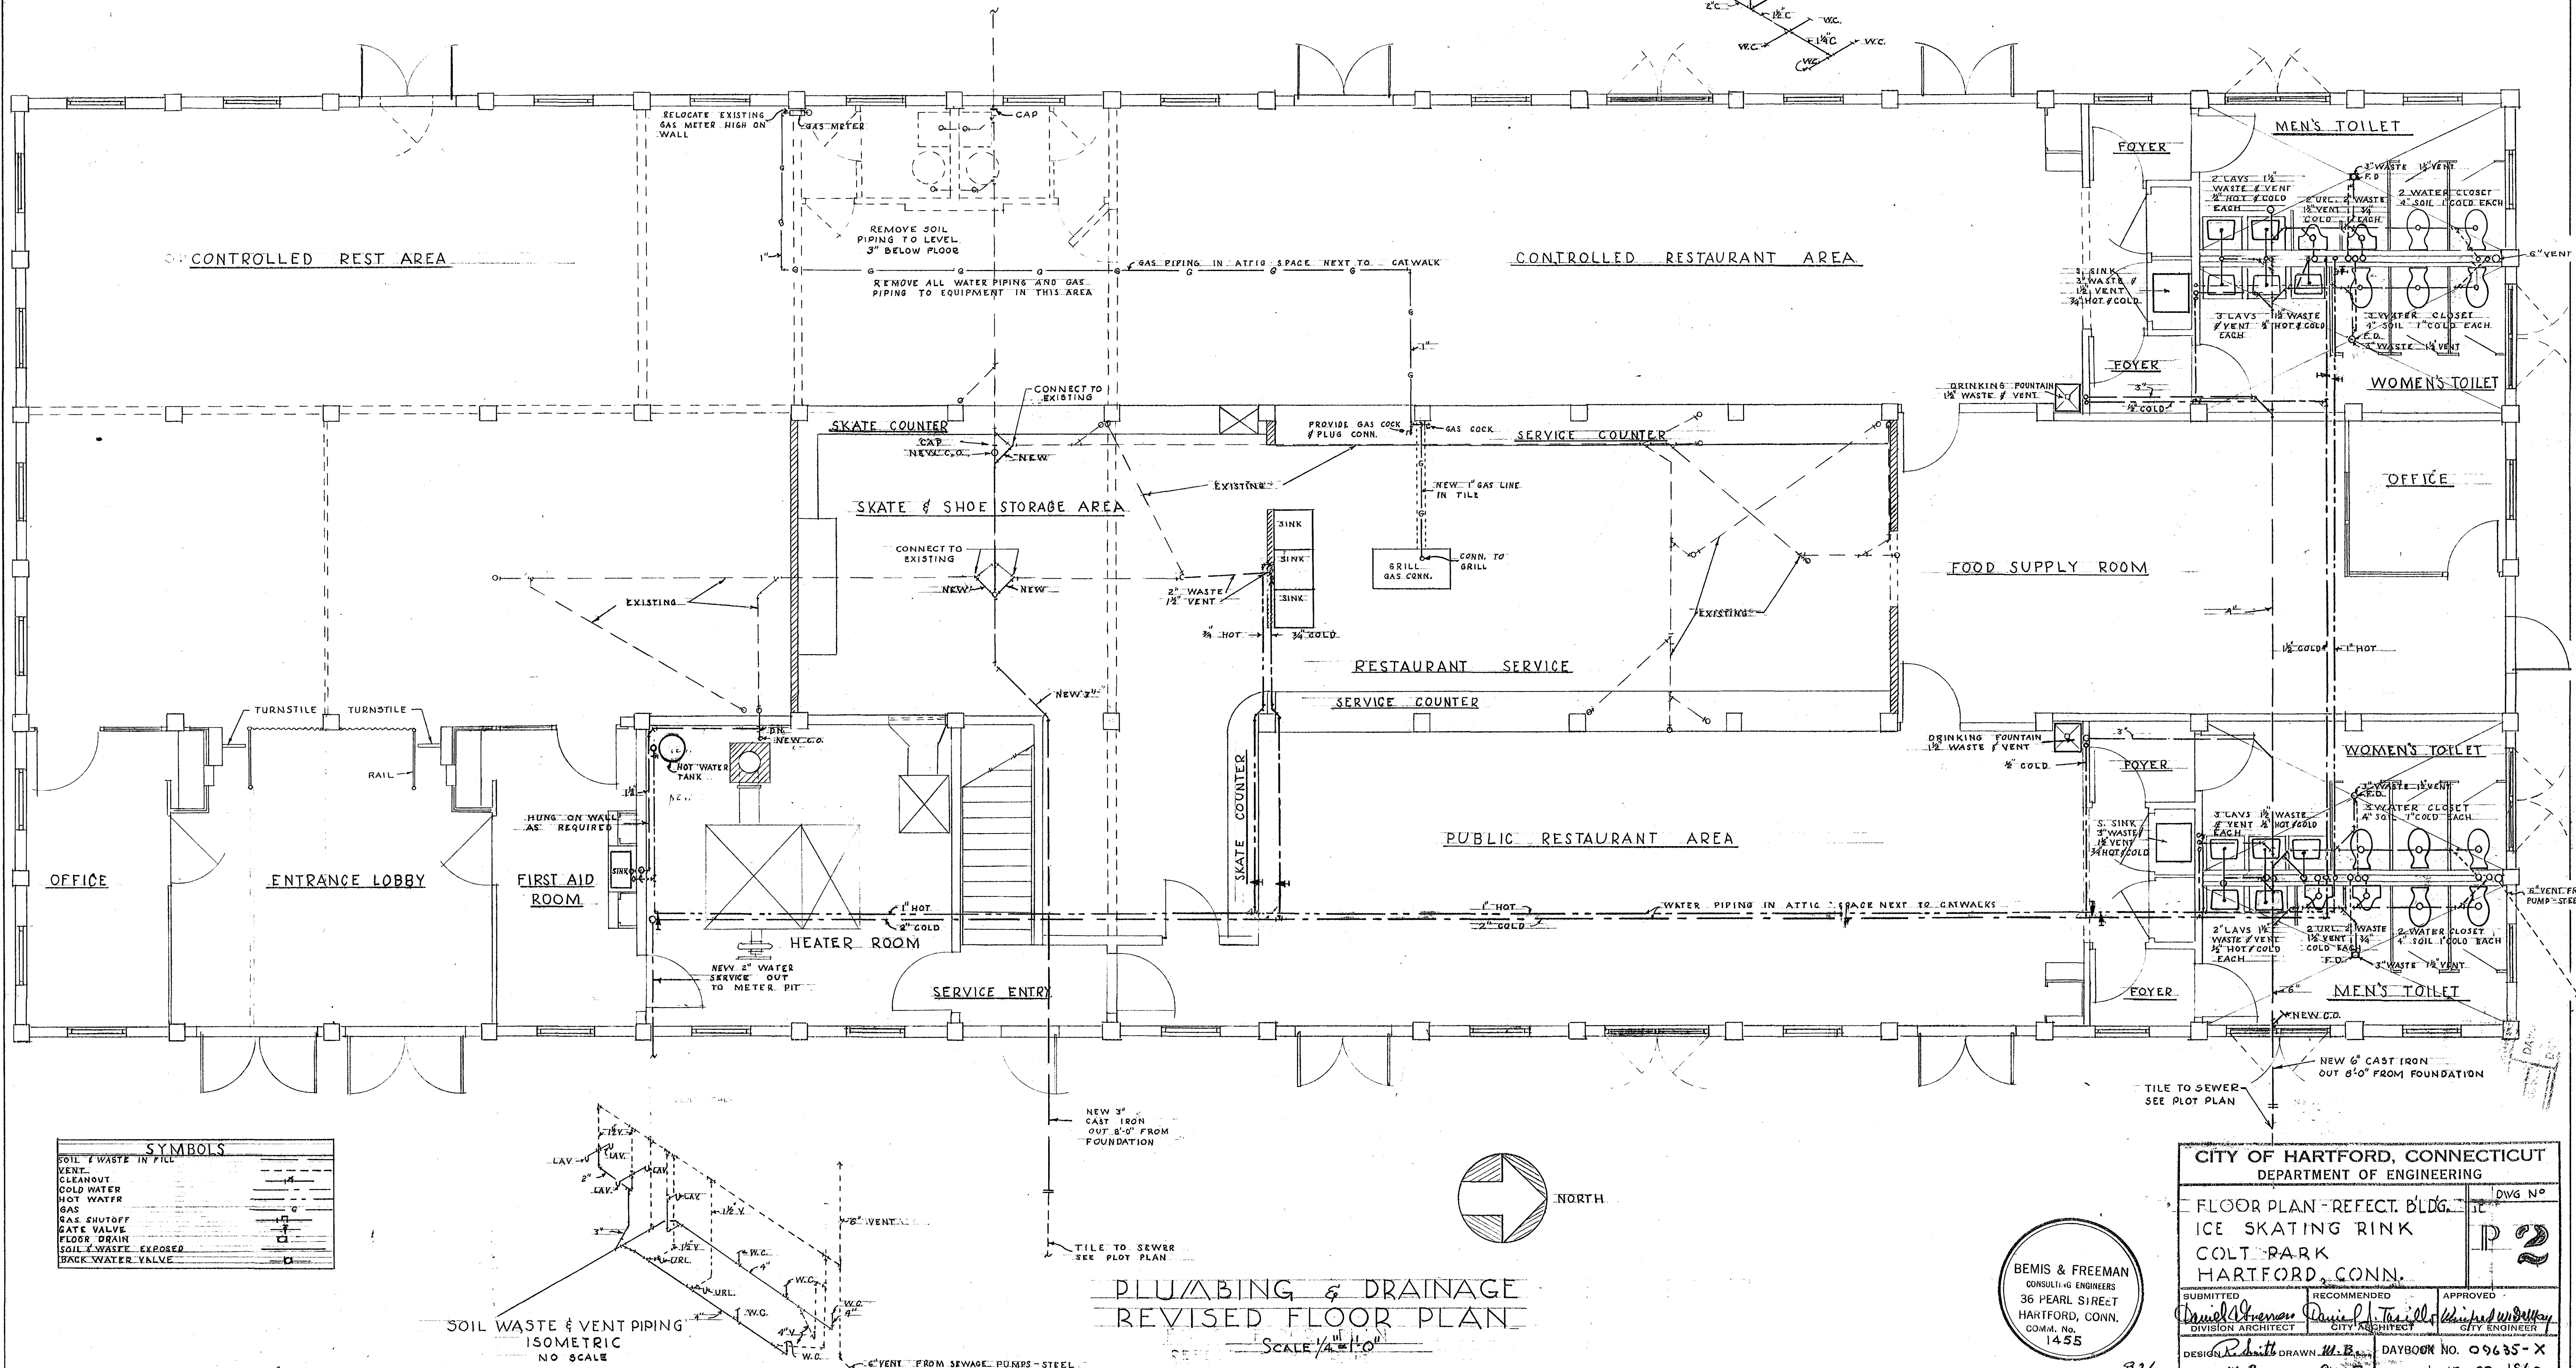

SYMBOLS	
SOIL & WASTE IN FILL	---
VENT	---
CLEANOUT	---
COLD WATER	---
HOT WATER	---
GAS	---
GAS SHUTOFF	---
GATE VALVE	---
FLOOR DRAIN	---
SOIL & WASTE EXPOSED	---
BACK WATER VALVE	---


SOIL WASTE & VENT PIPING ISOMETRIC
NO SCALE

PLUMBING & DRAINAGE REVISED FLOOR PLAN

SCALE 1/4\"/>

CITY OF HARTFORD, CONNECTICUT DEPARTMENT OF ENGINEERING		
FLOOR PLAN - REFACT. BLDG.		DWG NO.
ICE SKATING RINK COLT PARK HARTFORD, CONN.		P 2
SUBMITTED	RECOMMENDED	APPROVED
<i>Daniel J. Brennan</i>	<i>Daniel J. Brennan</i>	<i>William W. Dwyer</i>
DIVISION ARCHITECT	CITY ARCHITECT	CITY ENGINEER
DESIGN <i>R. Smith</i>	DRAWN <i>M. B.</i>	DAYBOOK NO. 09635-X
TRACED <i>M. B.</i>	CHECK <i>C. P.</i>	DATE JUNE 22, 1960

BEMIS & FREEMAN
CONSULTING ENGINEERS
36 PEARL STREET
HARTFORD, CONN.
COMM. NO. 1455

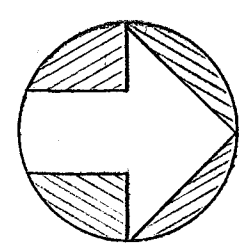

NORTH