



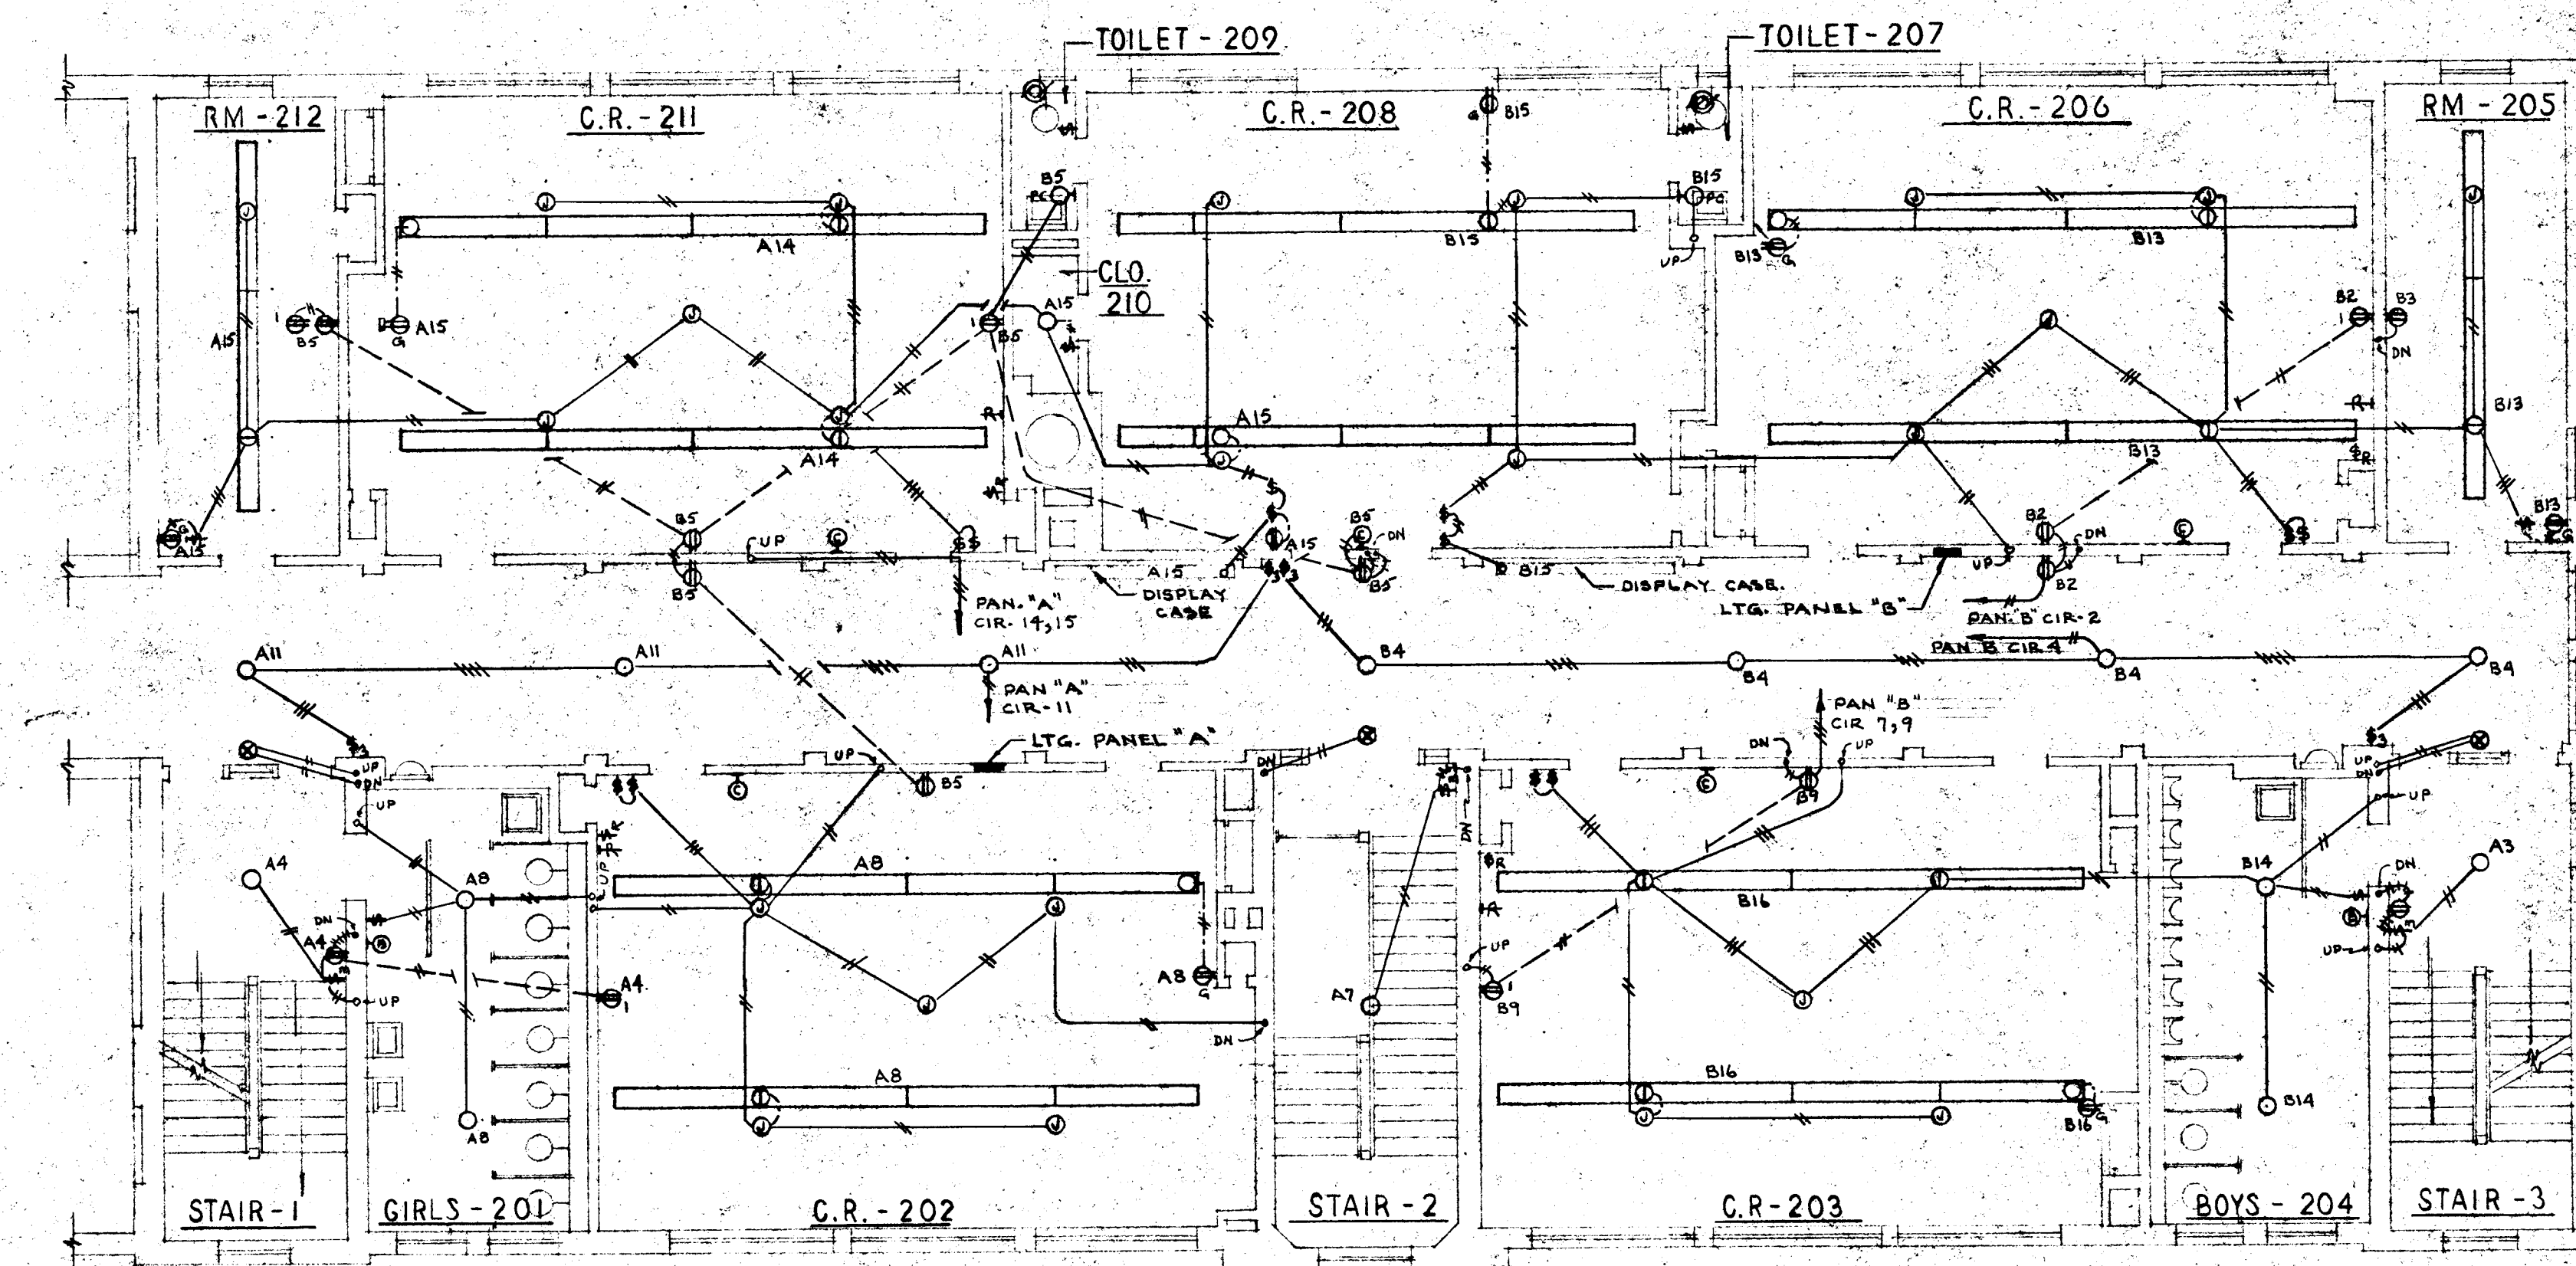


SECOND FLOOR PLAN-EXISTING
SCALE 1/8" = 1' - 0"


NOTE:
THIS DRAWING OF EXISTING CONDITIONS IS PRESENTED AS AN
AID TO THE CONTRACTOR. THE CIRCUIT ON WHICH EACH FIXTURE,
RECEPTACLE, ETC. IS NOTED AS SHOWN IS AS ACCURATE AS FIELD
CONDITIONS WILL PERMIT. THE DIRECTION, LOCATION AND TERMINATION
OF CONDUITS AND THE NUMBER OF WIRES IN EACH, AS SHOWN ON
THE FLOOR PLANS, ARE ASSUMPTION, ONLY. THE CONTRACTOR SHALL
VERIFY AND BE RESPONSIBLE FOR ALL EXISTING CONDITIONS.

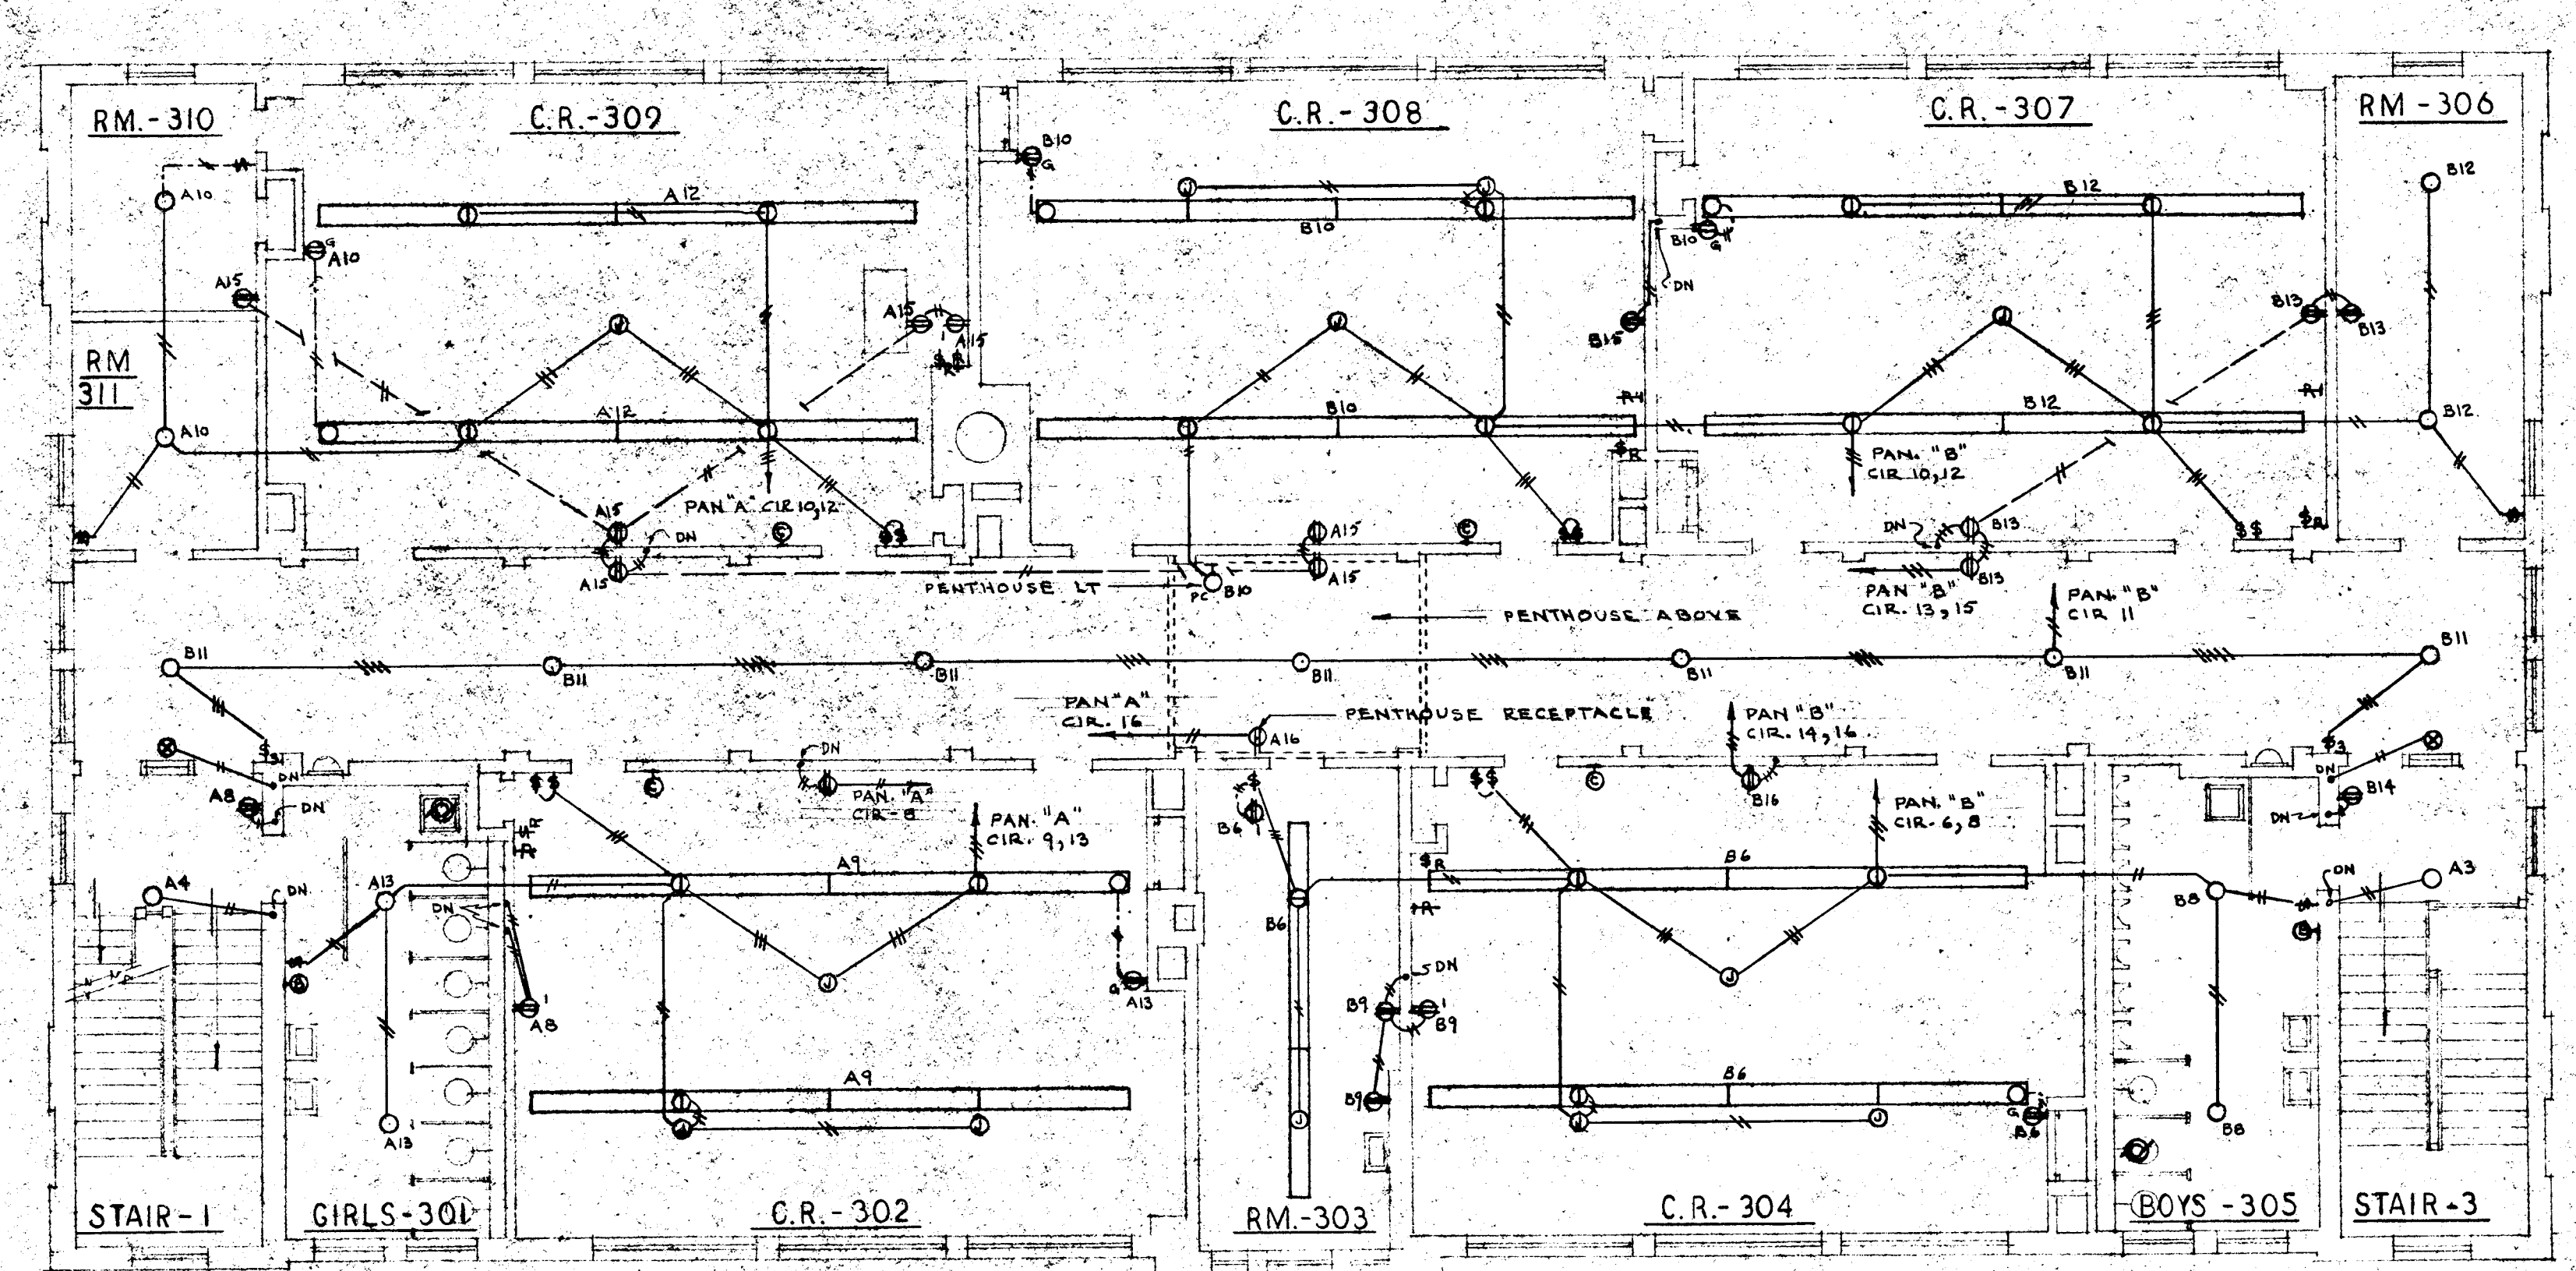

THIRD FLOOR PLAN-EXISTING
SCALE 1/8" = 1' - 0"

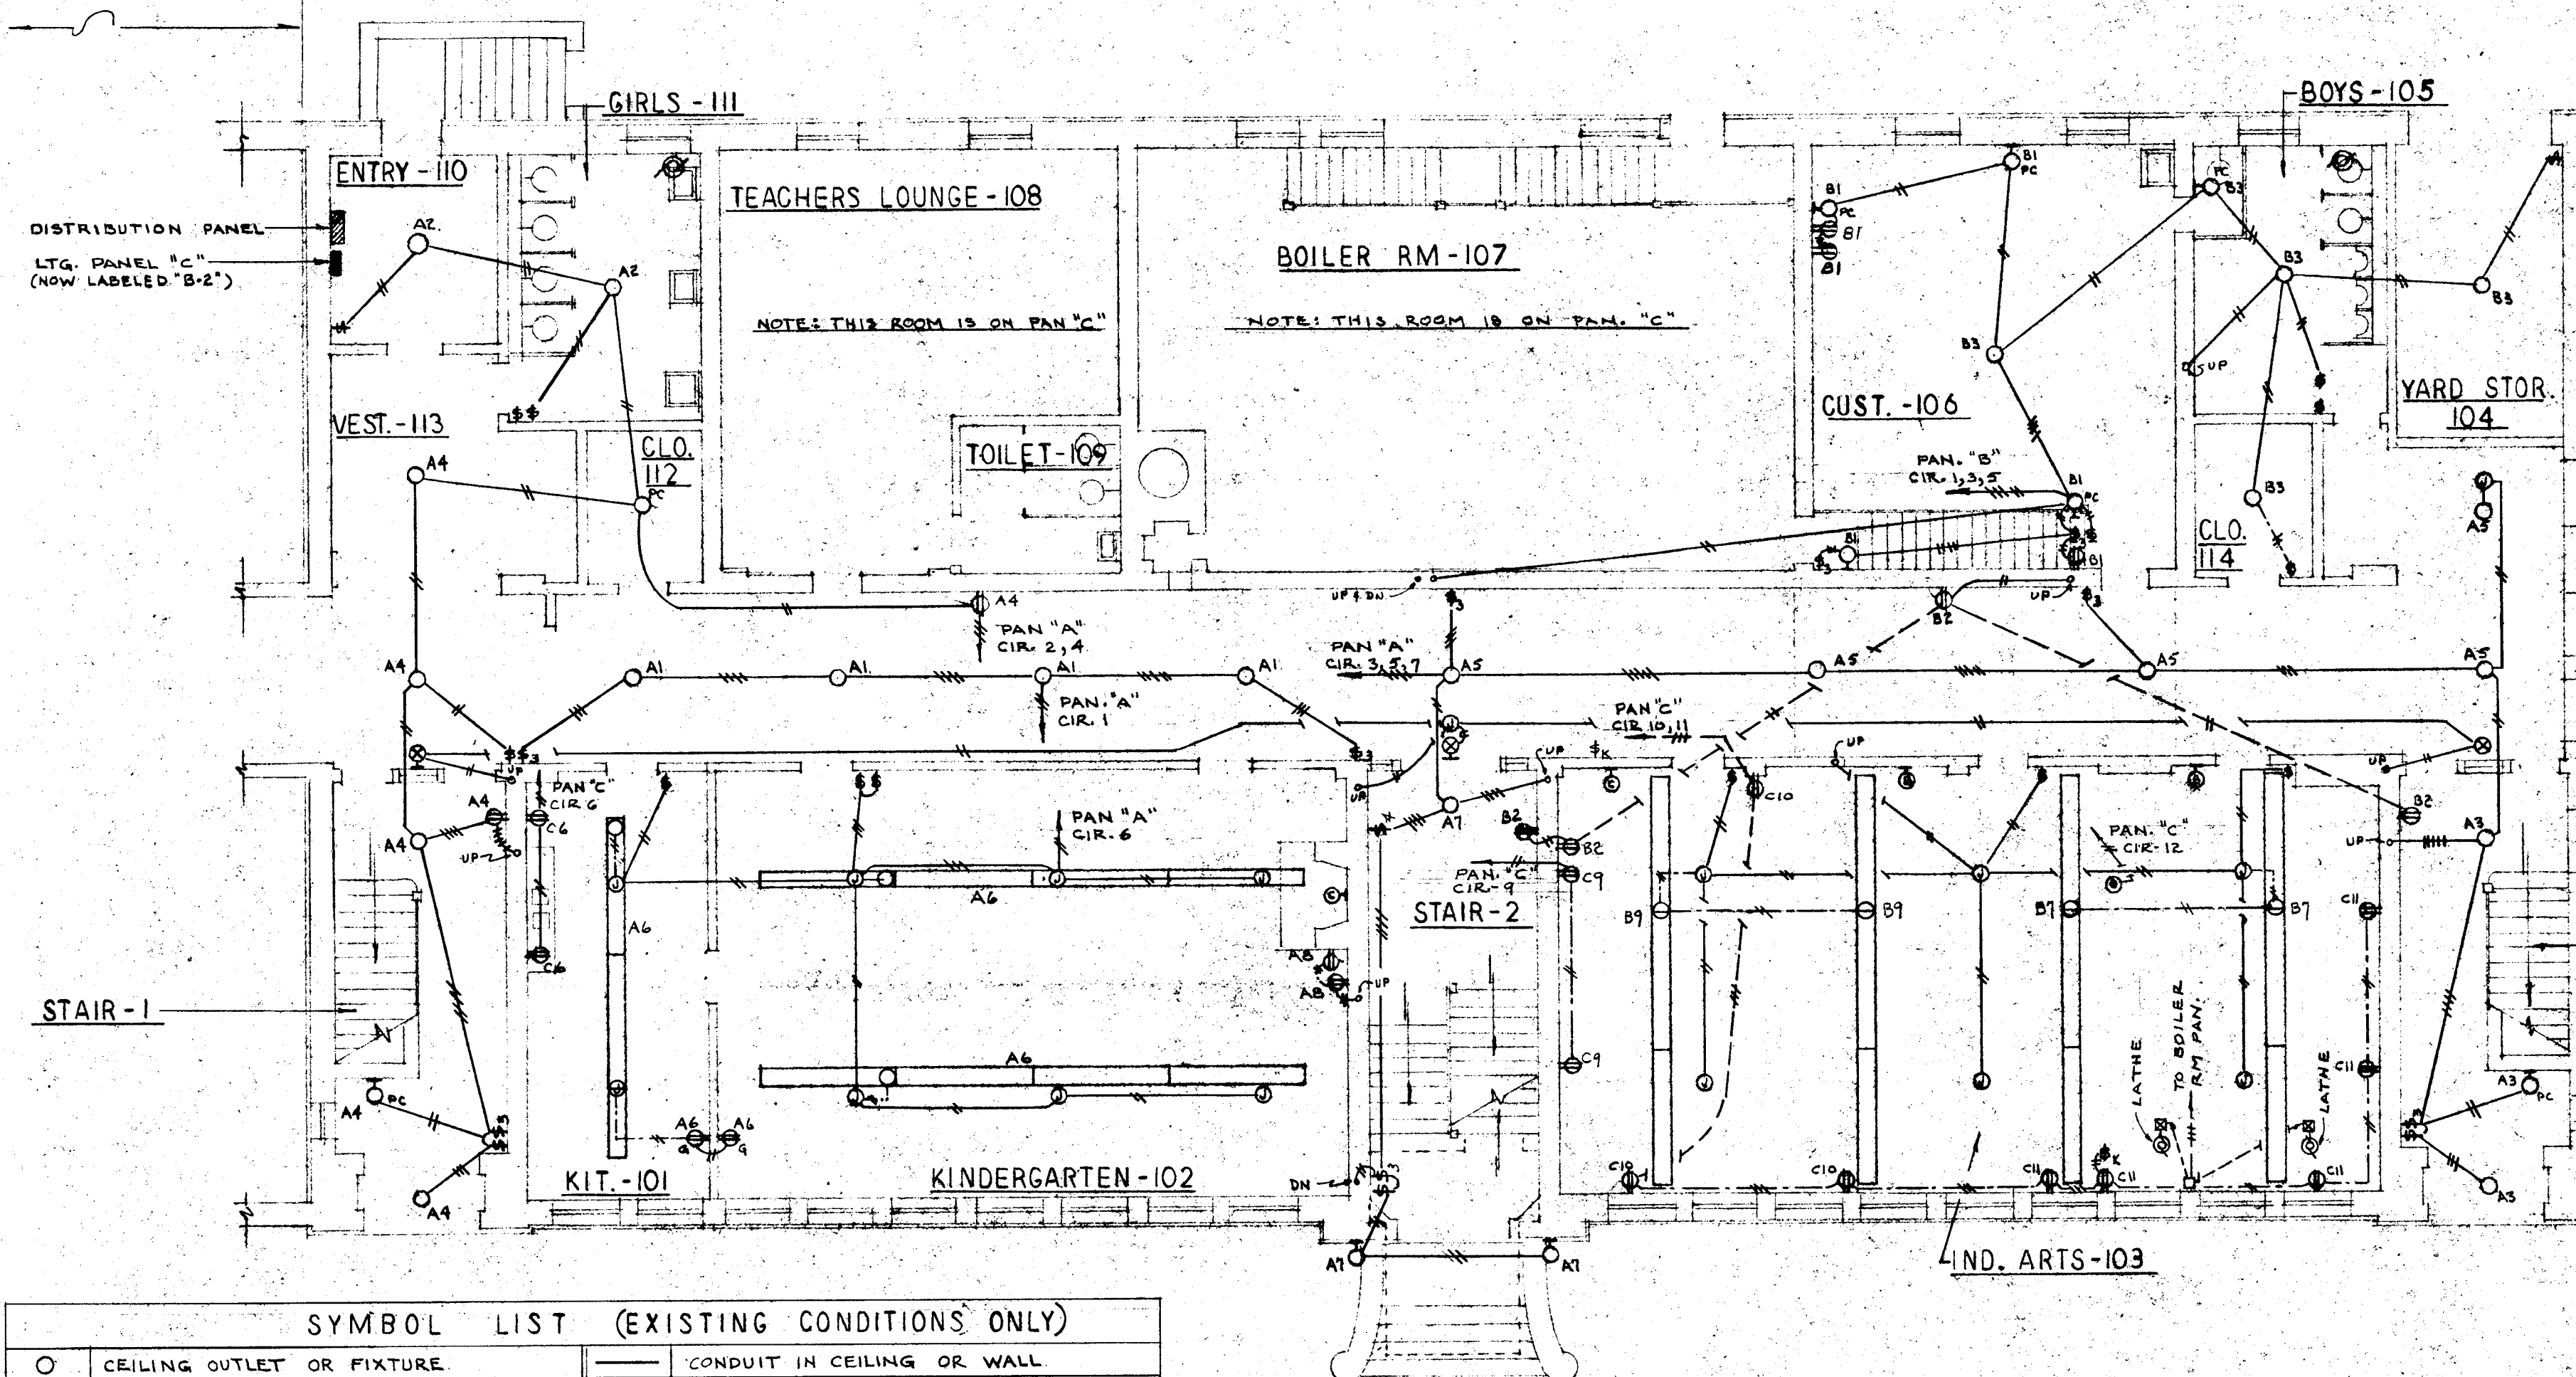

FIRST FLOOR PLAN-EXISTING
SCALE 1/8" = 1' - 0"

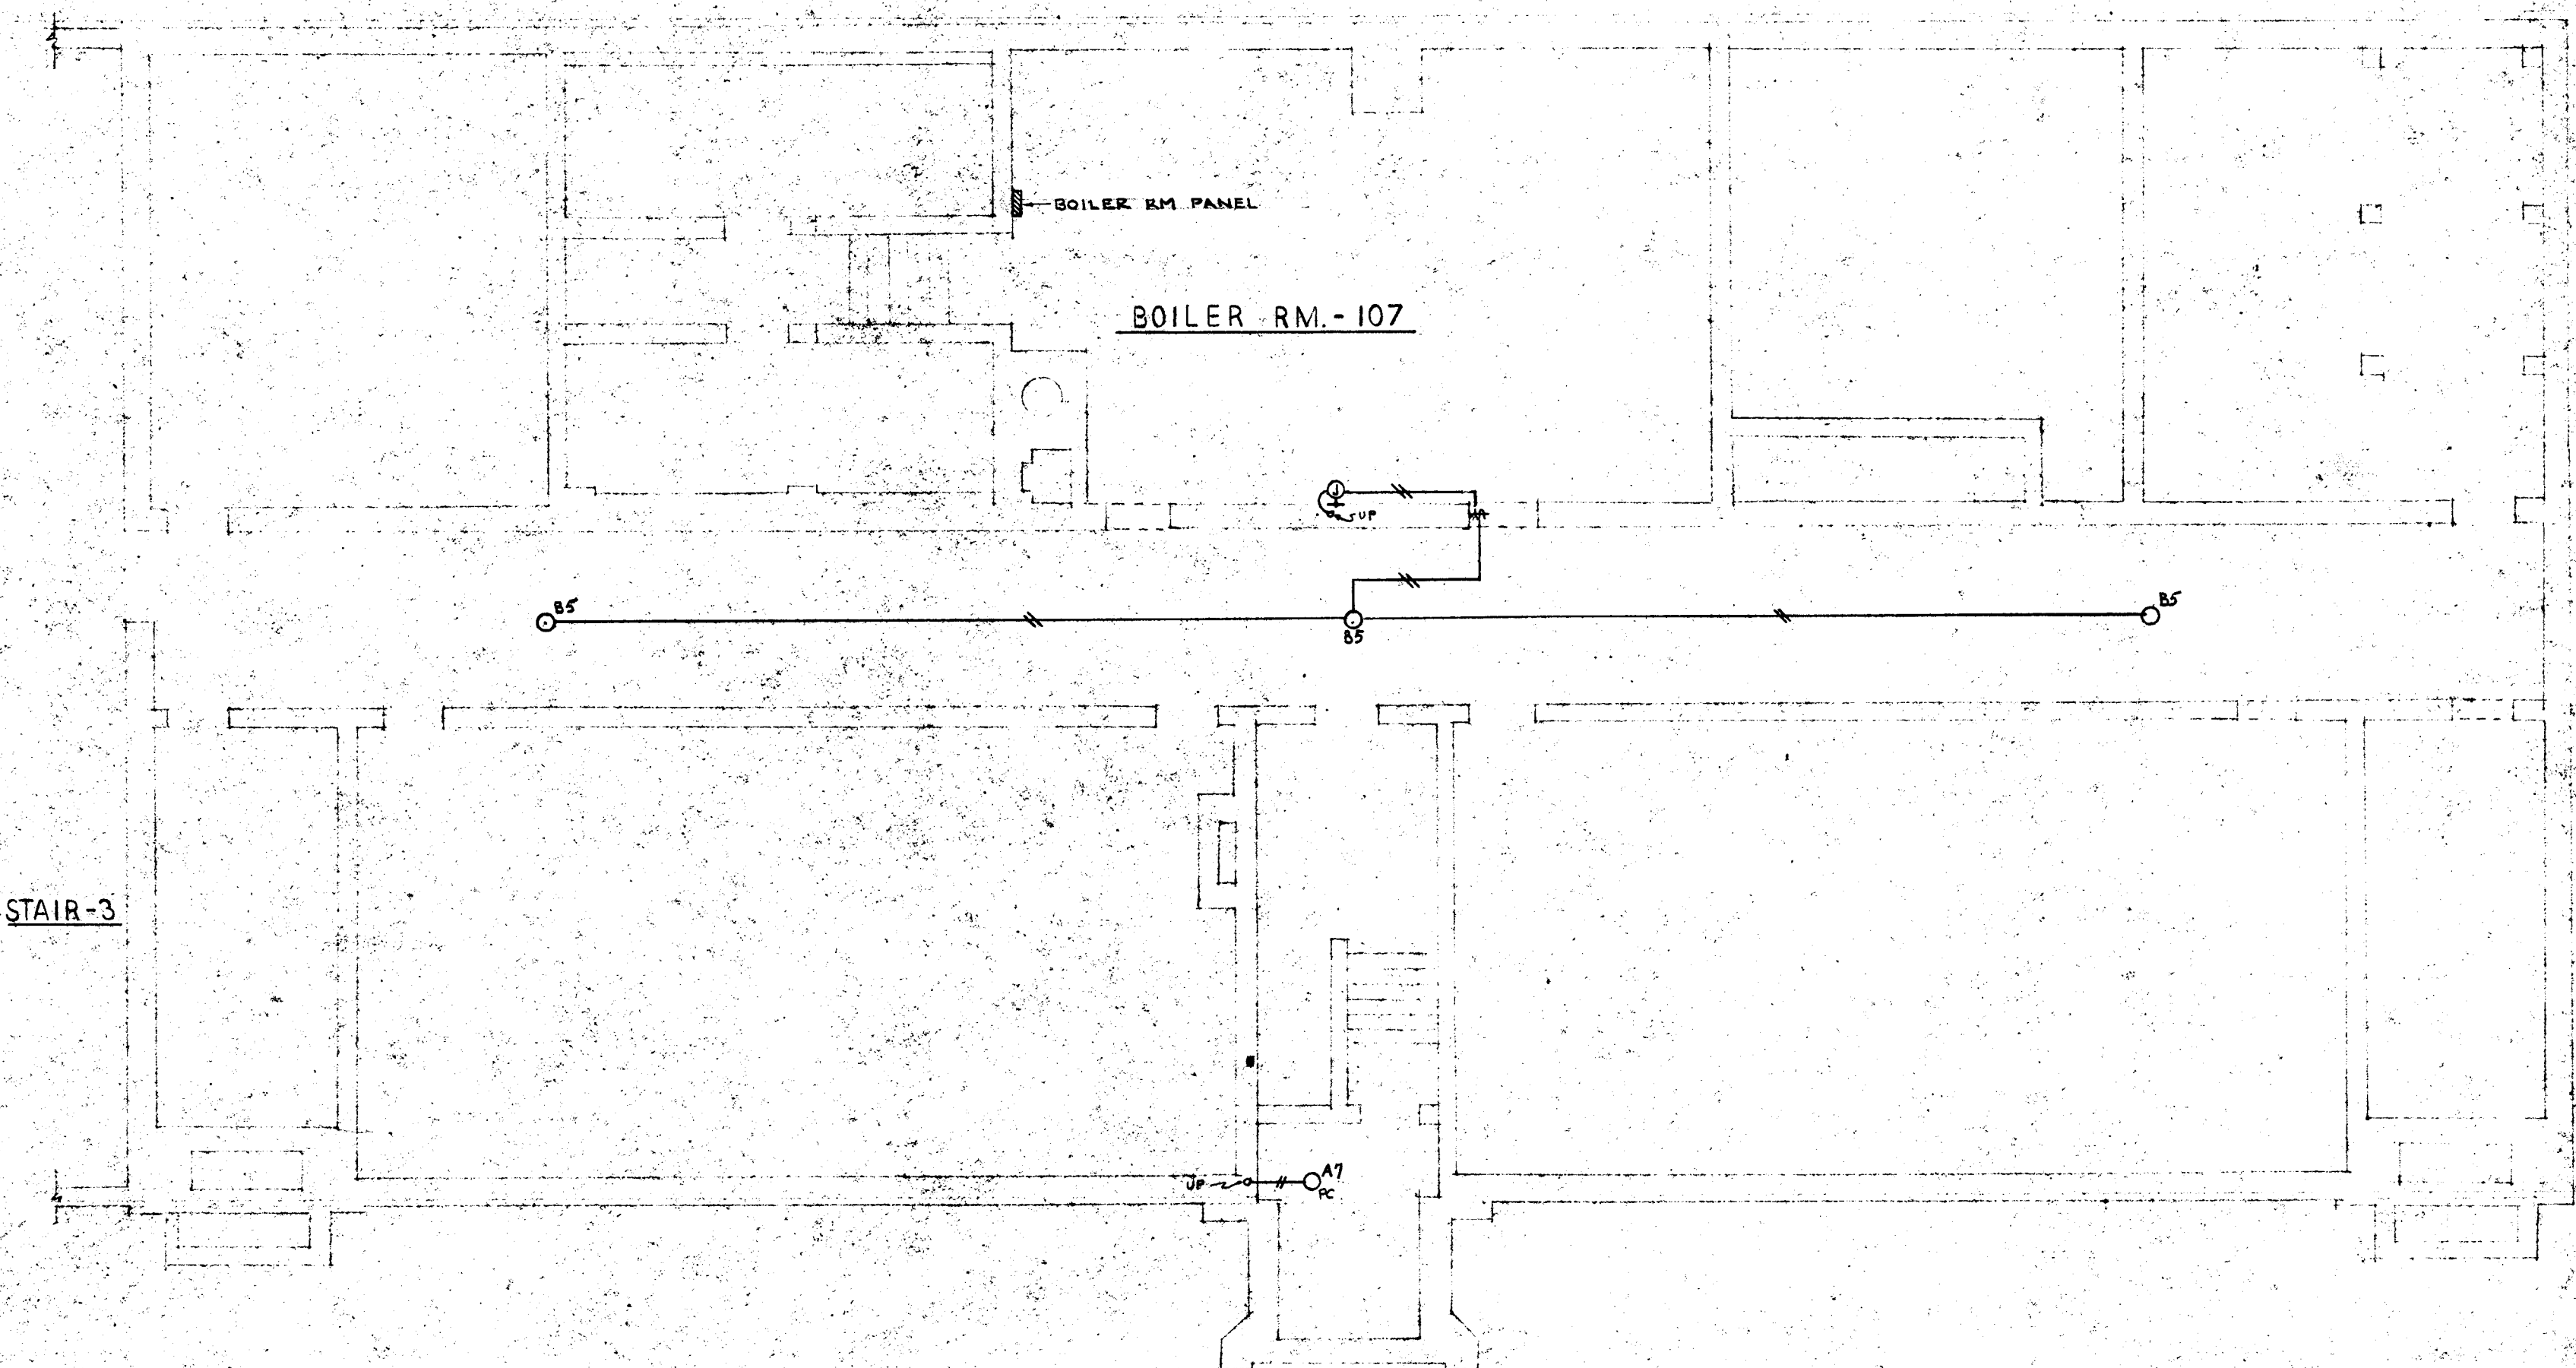

PIPE TUNNEL PLAN-EXISTING
SCALE 1/8" = 1' - 0"

SYMBOL LIST (EXISTING CONDITIONS ONLY)			
○	CEILING OUTLET OR FIXTURE	---	CONDUIT IN CEILING OR WALL
○	FIXTURE WITH PULL CHAIN	---	CONDUIT IN FLOOR
○	WALL BRACKET	---	WIREMOLD RACEWAY
○	WITH PULL CHAIN	---	INTERCOMM. SWITCH
○	JUNCTION BOX	---	JACK FOR SPEAKER
○	EXIT SIGN		
○	FLUORESCENT FIXTURE		
○	DUPLEX CONVENIENCE OUTLET		
○	SINGLE " "		
○	DUPLEX CONV. OUTLET-GROUNDED		
○	BLANKED OUTLET		
○	MOTOR		
○	SINGLE POLE SWITCH		
○	3-WAY SWITCH		
○	4-WAY SWITCH		
○	KEY SWITCH		
○	CLOCK		
○	FLOOR RECEPTACLE		

NOTE: LETTER AND NUMBER (A7) NEXT TO SYMBOL INDICATES PANEL AND CIRCUIT NUMBER.

EXISTING CONDITIONS

CITY OF HARTFORD, CONNECTICUT
DEPARTMENT OF ENGINEERING

ELECTRICAL ALTERATIONS
FOR
CLARENCE A. BARBOUR SCHOOL
150 TOWER AVENUE
HARTFORD, CONNECTICUT

SUBMITTED: [Signature] APPROVED: [Signature]
DESIGN: R.G.B. DRAWN: R.G.B. DAYBOOK NO. 09659C
TRACED: CHECK: DATE MARCH 27, 1961

VERIFY EXISTING CONDITIONS
AND DIMENSIONS AT BUILDING