



2/10


2/10

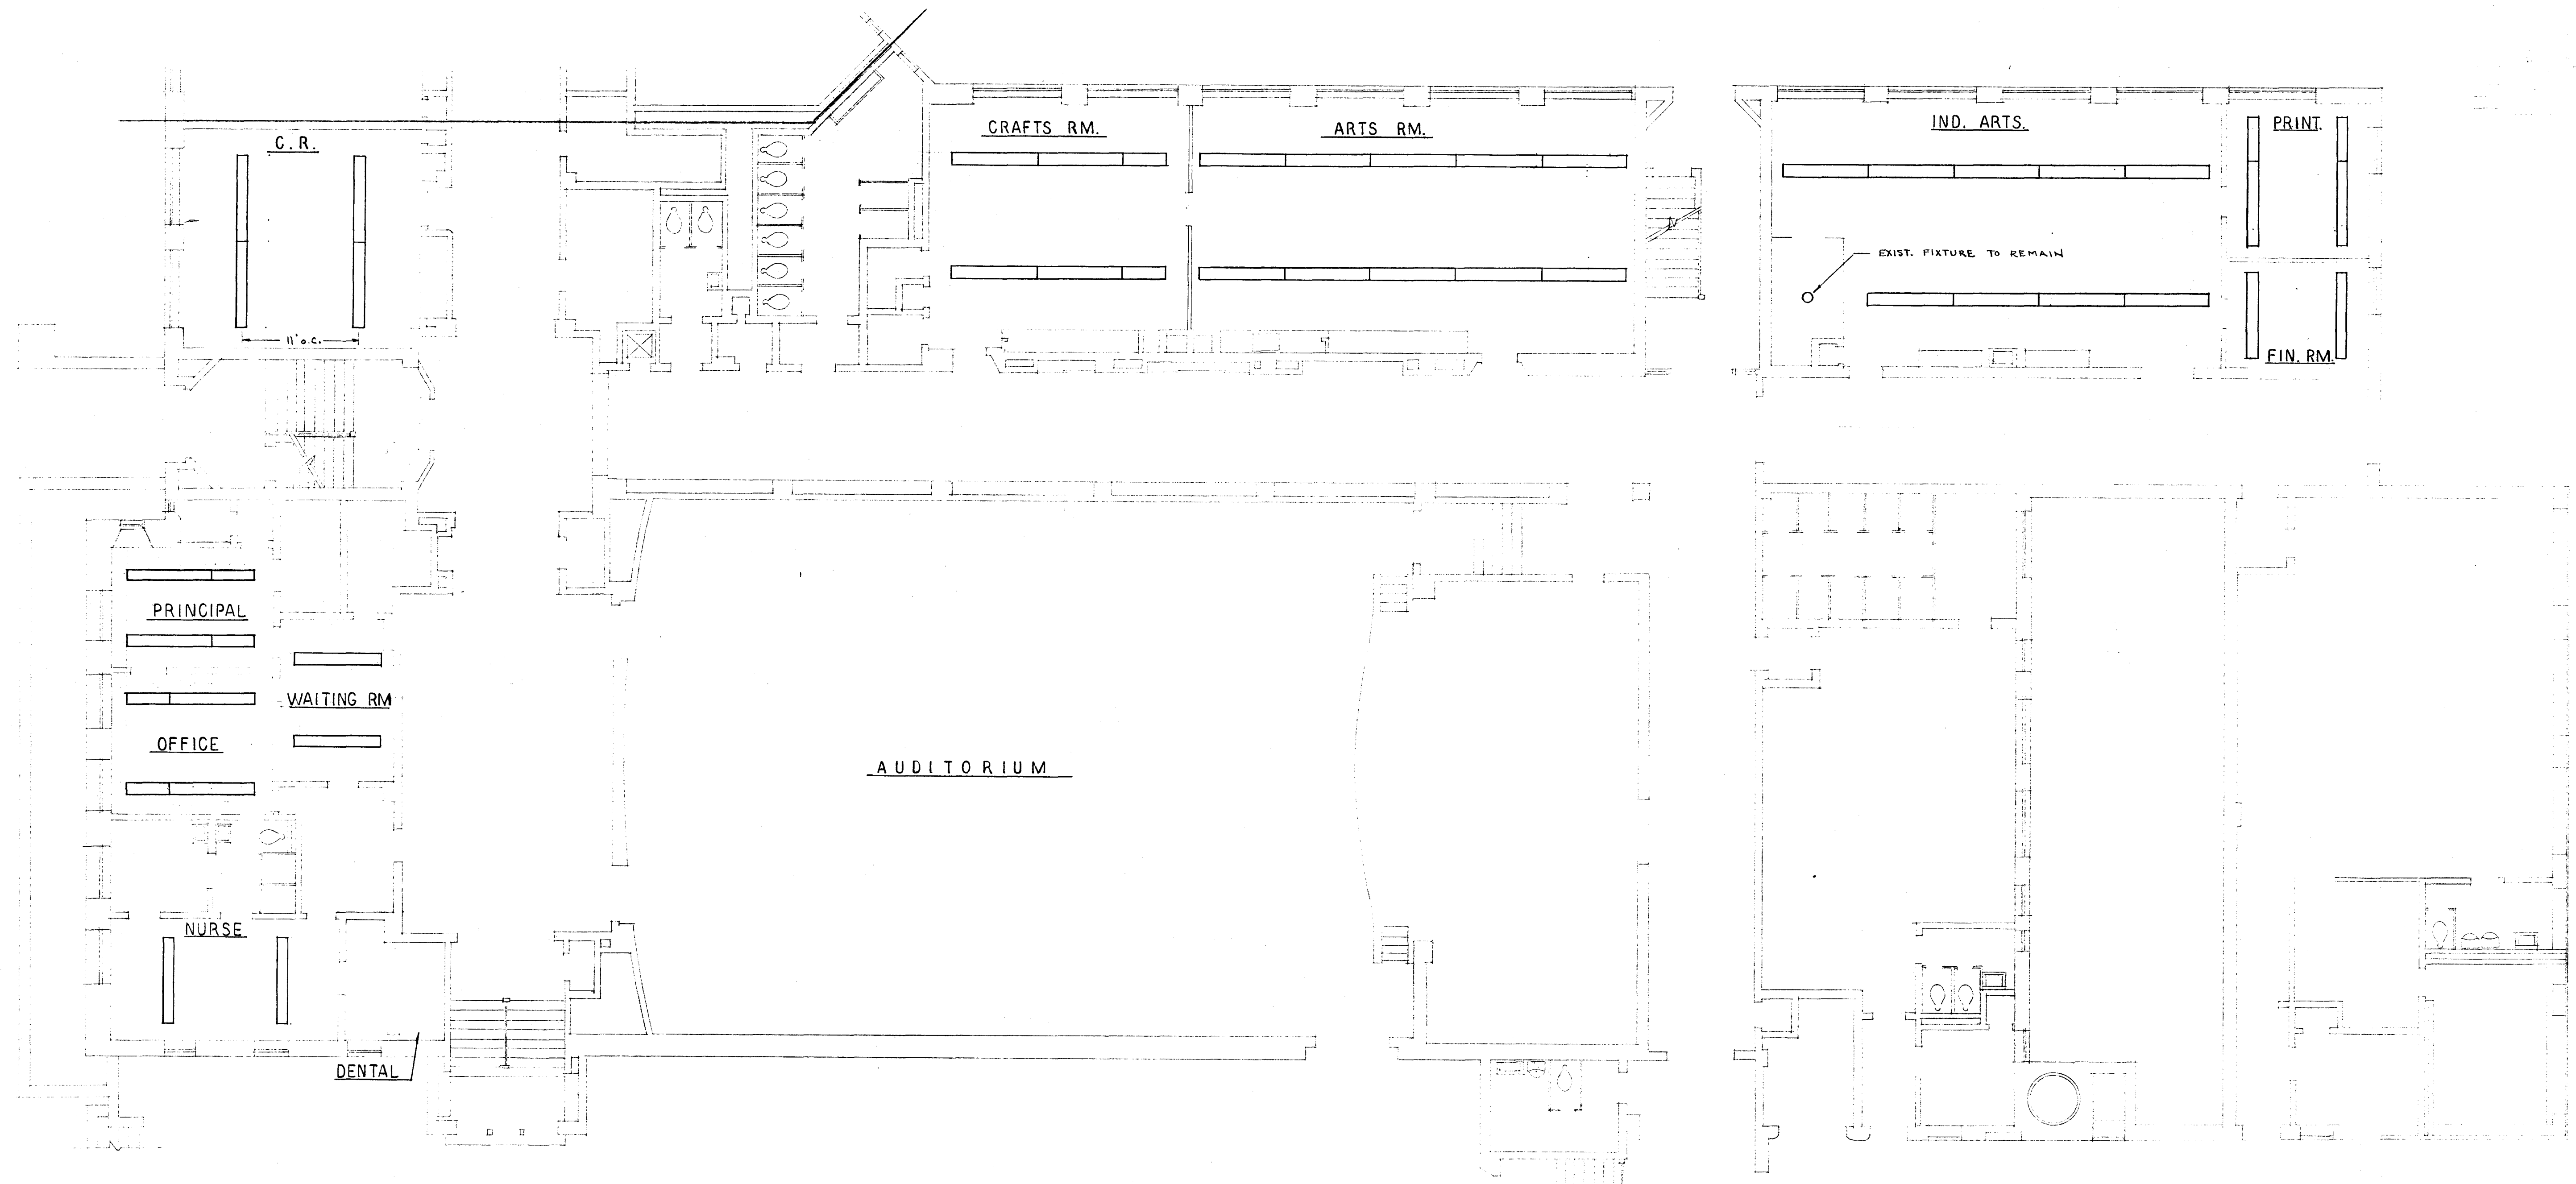


FIRST FLOOR PLAN
SCALE 1/8" = 1'-0"

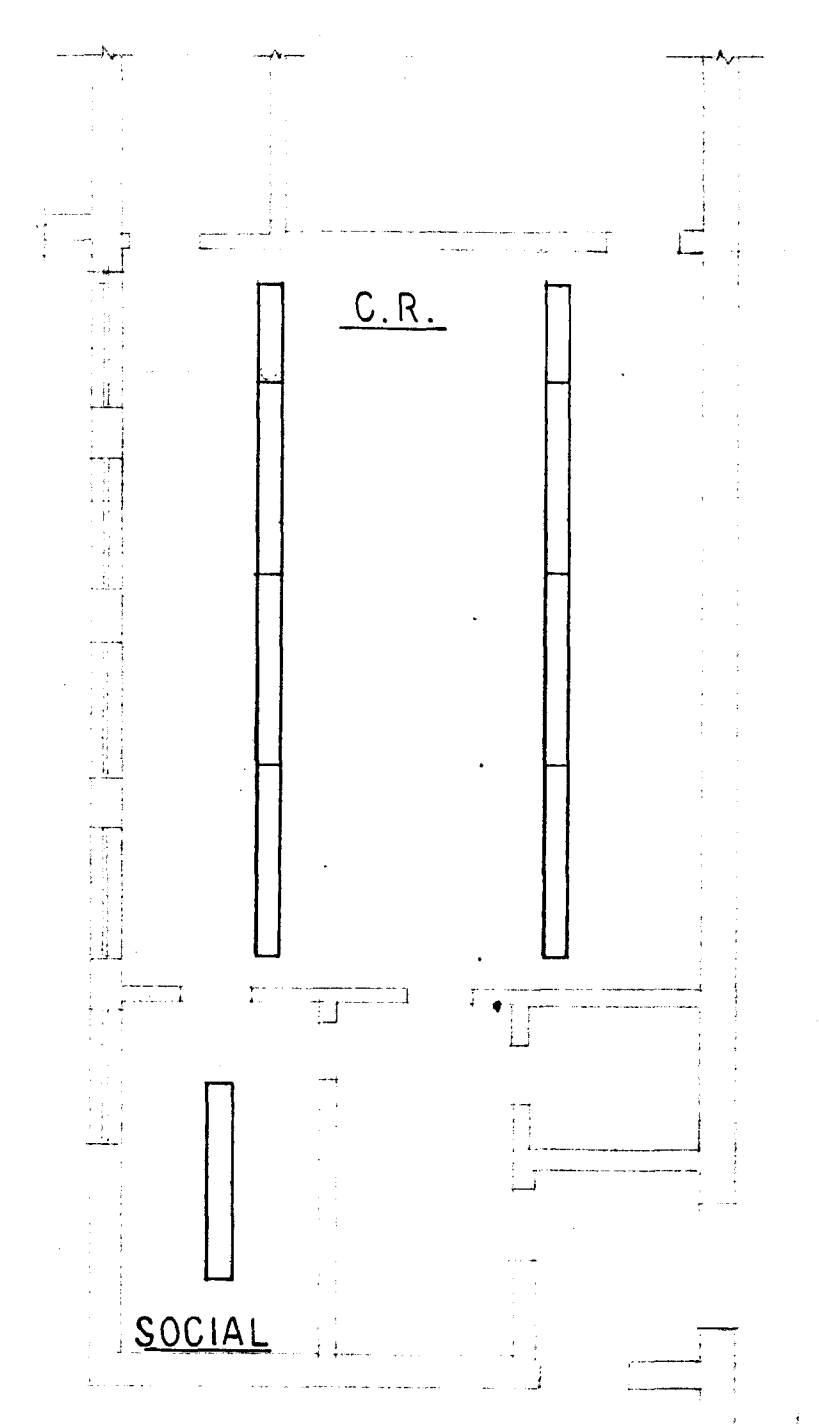

BSM'T PLAN
SCALE 1/8" = 1'-0"

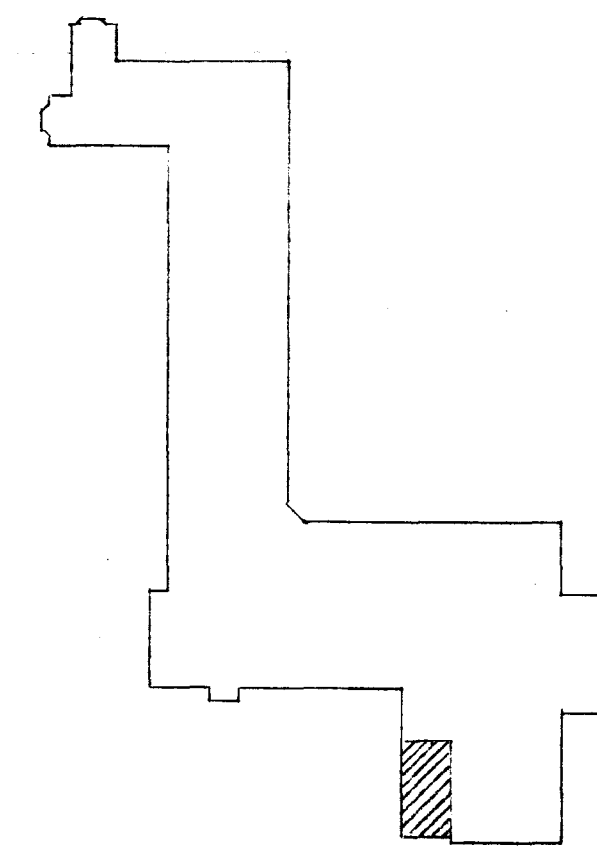

KEY PLAN

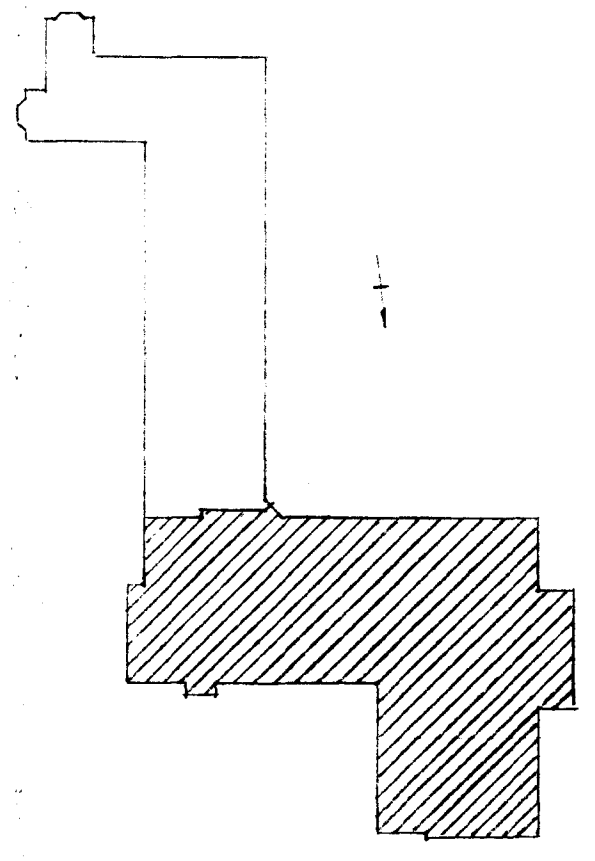

KEY PLAN

SHEET NO.
1
OF 4 SHEETS

CITY OF HARTFORD, CONNECTICUT DEPARTMENT OF ENGINEERING		
LIGHTING IMPROVEMENTS FOR DOMINICK F. BURNS SCHOOL 195 PUTNAM ST. HARTFORD CONN.		
SUBMITTED <i>Samuel S. Bonner</i> DESIGNER	RECOMMENDED <i>Daniel J. Tavelle</i> CITY ARCHITECT	APPROVED <i>Patricia A. Brown</i> CITY ENGINEER
DESIGN R. G. B.	DRAWN R. G. B.	DAYBOOK NO. 09705-A
TRACED	CHECK	DATE MAY 31, 1962

VERIFY EXISTING
CONDITIONS AND
DIMENSIONS AT
BUILDING

2/10

2/10