



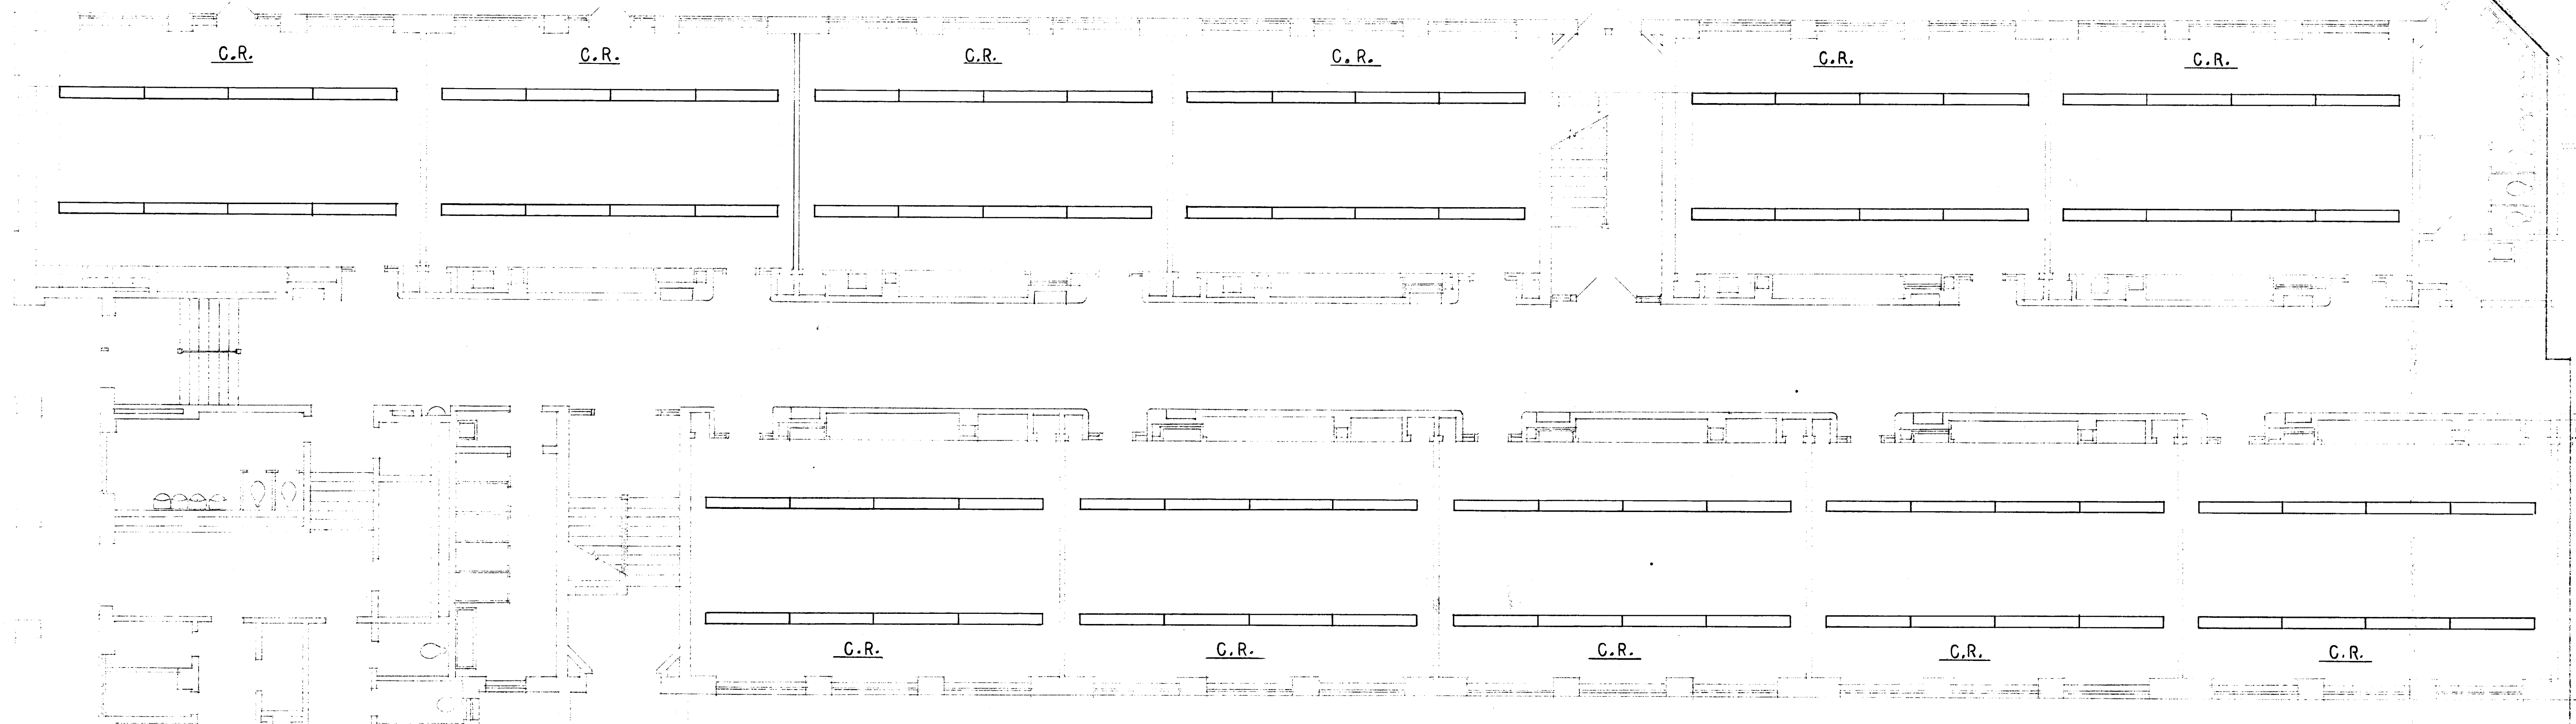

FIRST FLOOR PLAN

SCALE 1/8" = 1'-0"

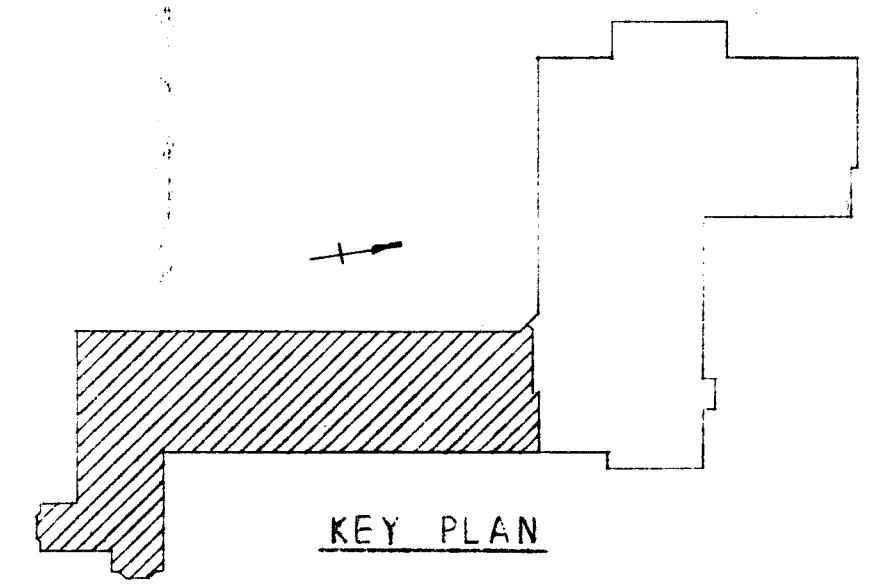

NOTES:
1. ALL FLUORESCENT FIXTURES FOR THIS SCHOOL SHALL BE TYPE "A" FOR 8 FT. FIXTURES AND TYPE "AX" FOR 4 FT. FIXTURES.

SHEET NO. 2
OF 4 SHEETS

CITY OF HARTFORD, CONNECTICUT DEPARTMENT OF ENGINEERING			
LIGHTING IMPROVEMENTS FOR DOMINICK F. BURNS SCHOOL 195 PUTNAM ST. HARTFORD CONN.			
SUBMITTED	RECOMMENDED	APPROVED	
<i>Raymond B. Benson</i>	<i>James D. Truitt</i>	<i>Robert H. Benson</i>	
CITY ARCHITECT	CITY ARCHITECT	CITY ENGINEER	
DESIGN R.G.B.	DRAWN R.G.B.	DAYBOOK NO. 09705-B	
TRACED	CHECK	DATE MAY 31, 1962	

VERIFY EXISTING
CONDITIONS AND
DIMENSIONS AT
BUILDING