



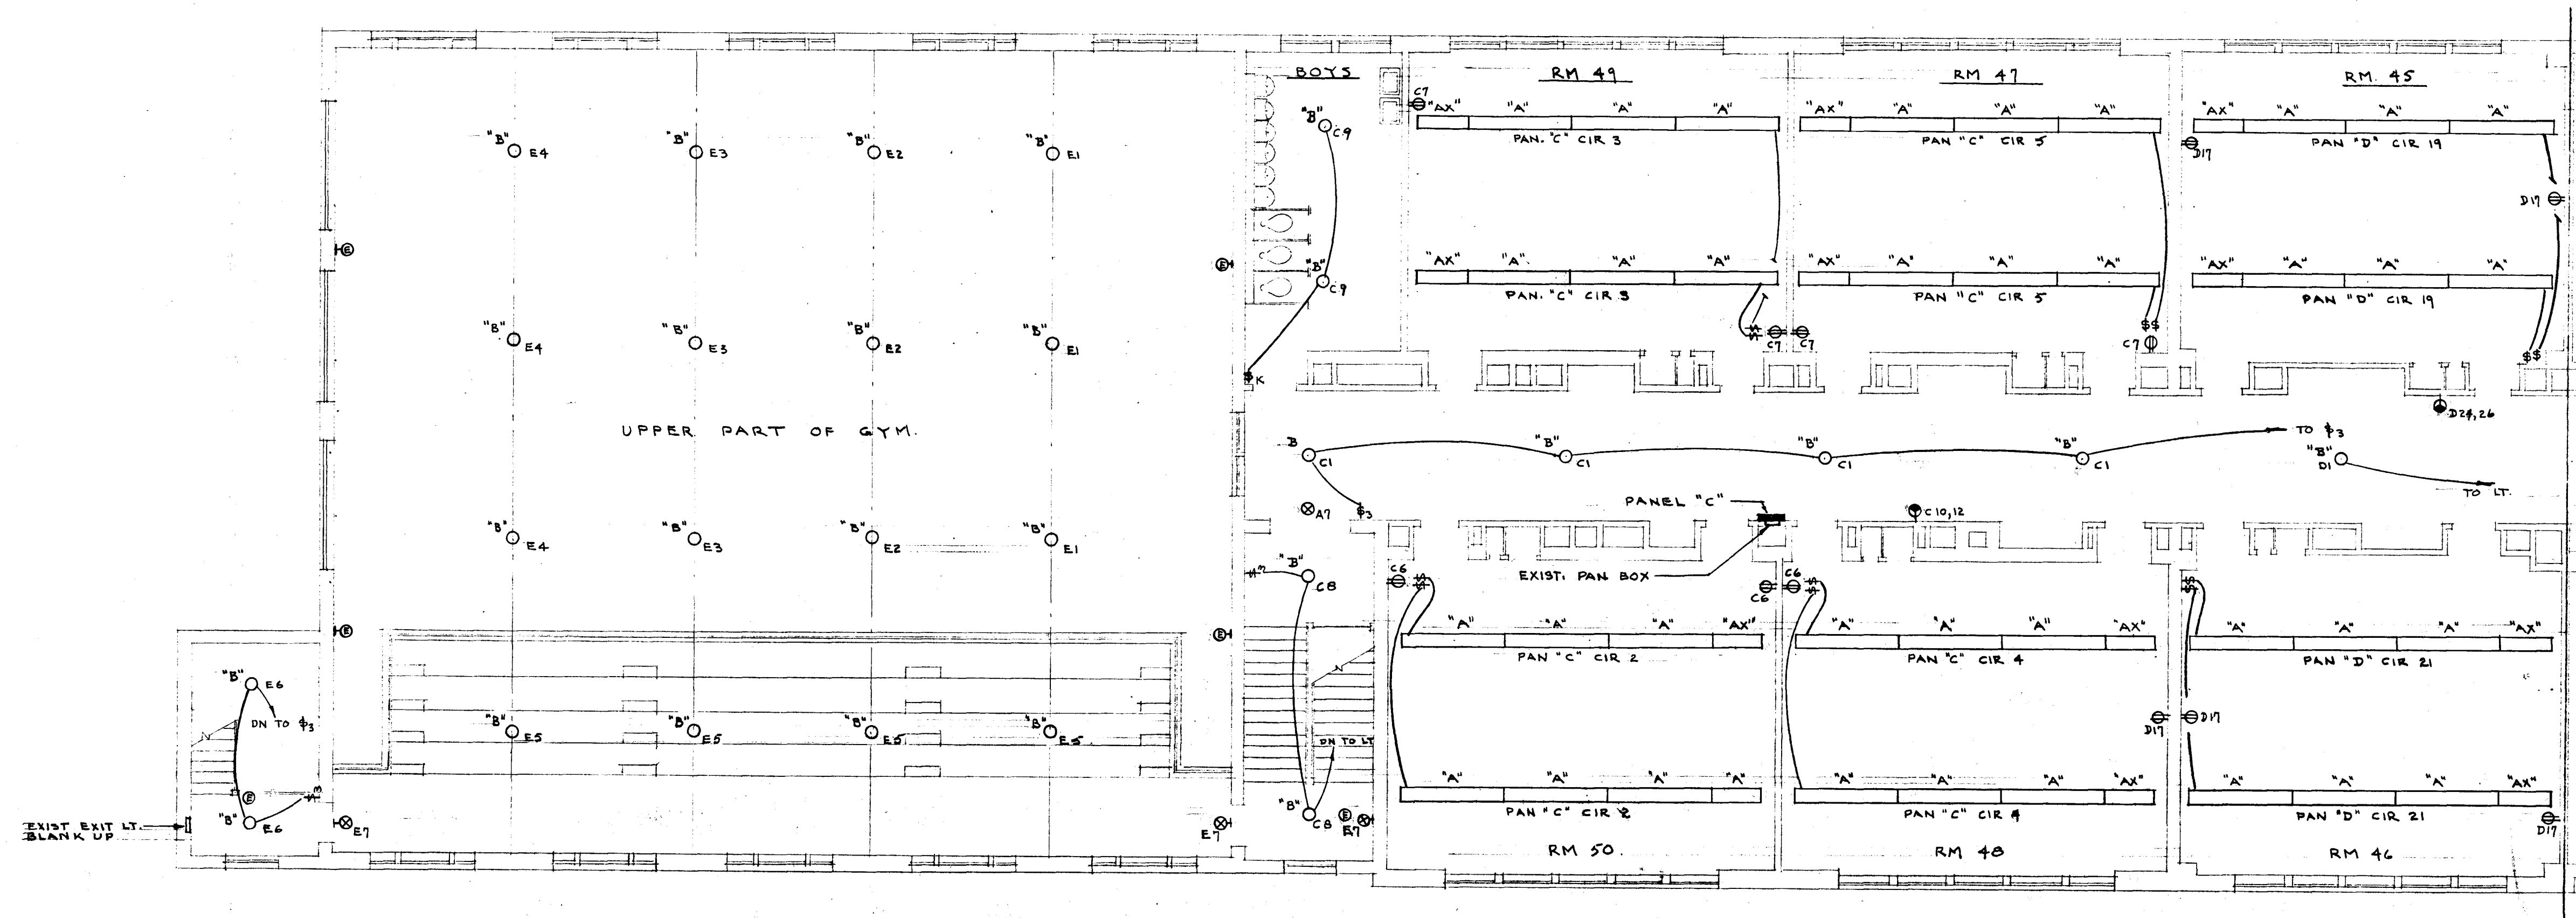

SECOND FLOOR PLAN - BLDG "B" NORTH SECTION
SCALE 1/8" = 1' - 0"

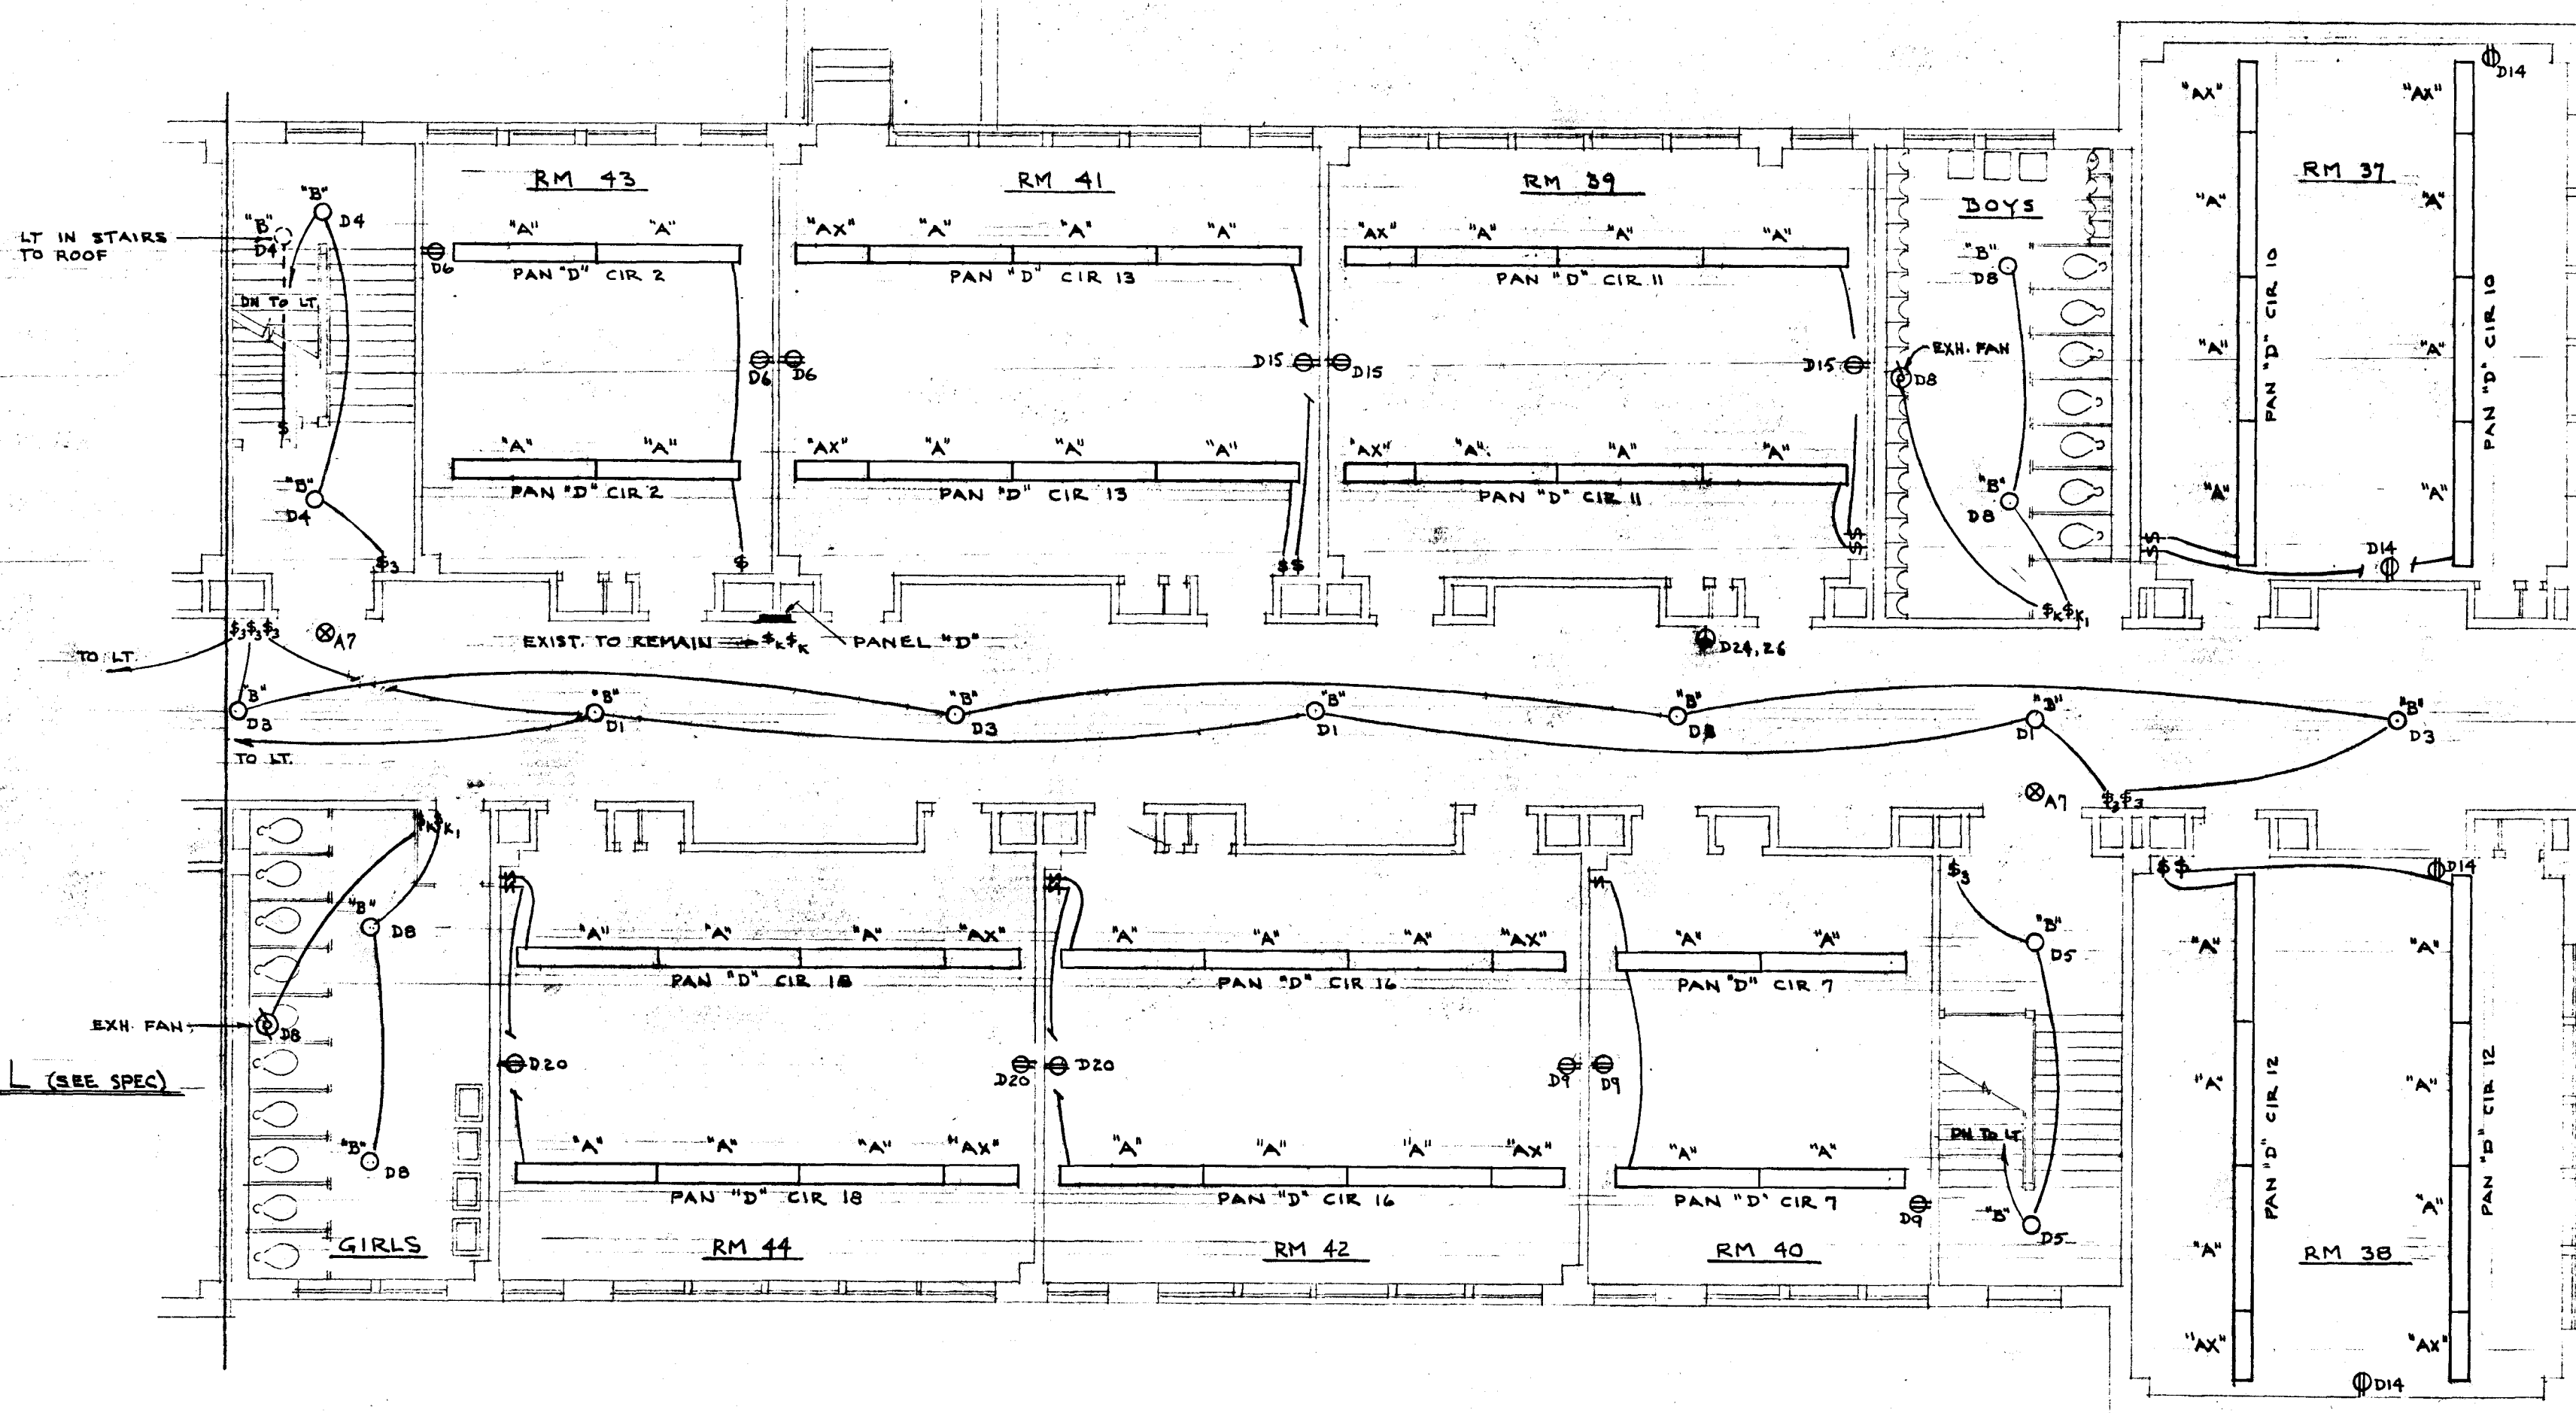

SECOND FLOOR PLAN - BLDG "B" SOUTH SECTION
SCALE 1/8" = 1' - 0"

SYMBOL LIST

○	CEILING FIXTURE - LETTER INDICATES FIXTURE TYPE E.G. "B". SEE NOTE 1.
○	FLUORESCENT FIXTURE " " " " " " " " " " " "
⊗	EXISTING EXIT LIGHT - SEE NOTE 1
⊕	SINGLE POLE SWITCH H&H #1991
⊕	THREE-WAY SWITCH H&H #1993
⊕	KEYED SWITCH H&H #1991-L
⊕	DUPLEX CONVENIENCE OUTLET H&H #5262 SEE NOTE 1 - UP 16"
⊕	CLEANING OUTLET H&H #5292 - SEE NOTE 1
⊕	EXISTING EMERGENCY LIGHT - TO REMAIN.
⊕	4-WAY SWITCH H&H #1994 UP 4'-0"
⊕	MOTOR SEE NOTE 1

NOTE 1 - LETTER & NUMBER INDICATE PANEL AND CIRCUIT E.G. A1 (PAN "A" CIR 1)

CITY OF HARTFORD, CONNECTICUT
DEPARTMENT OF ENGINEERING

ELECTRICAL ALTERATIONS

FOR
ELEANOR B. KENNELLY SCHOOL
180 WHITE ST. HARTFORD CONN.

VERIFY EXISTING
CONDITIONS AND
DIMENSIONS AT
BUILDING

SUBMITTED	RECOMMENDED	APPROVED
<i>Raymond H. Brown</i>	<i>David D. Tailla</i>	<i>Robert H. Brown</i>
DESIGN R.G.B.	DRAWN R.G.B.	DAYBOOK NO. 09709 B
TRACED	CHECK	DATE JUNE 4, 1962

SHEET NO.
2
OF 2 SHEETS