




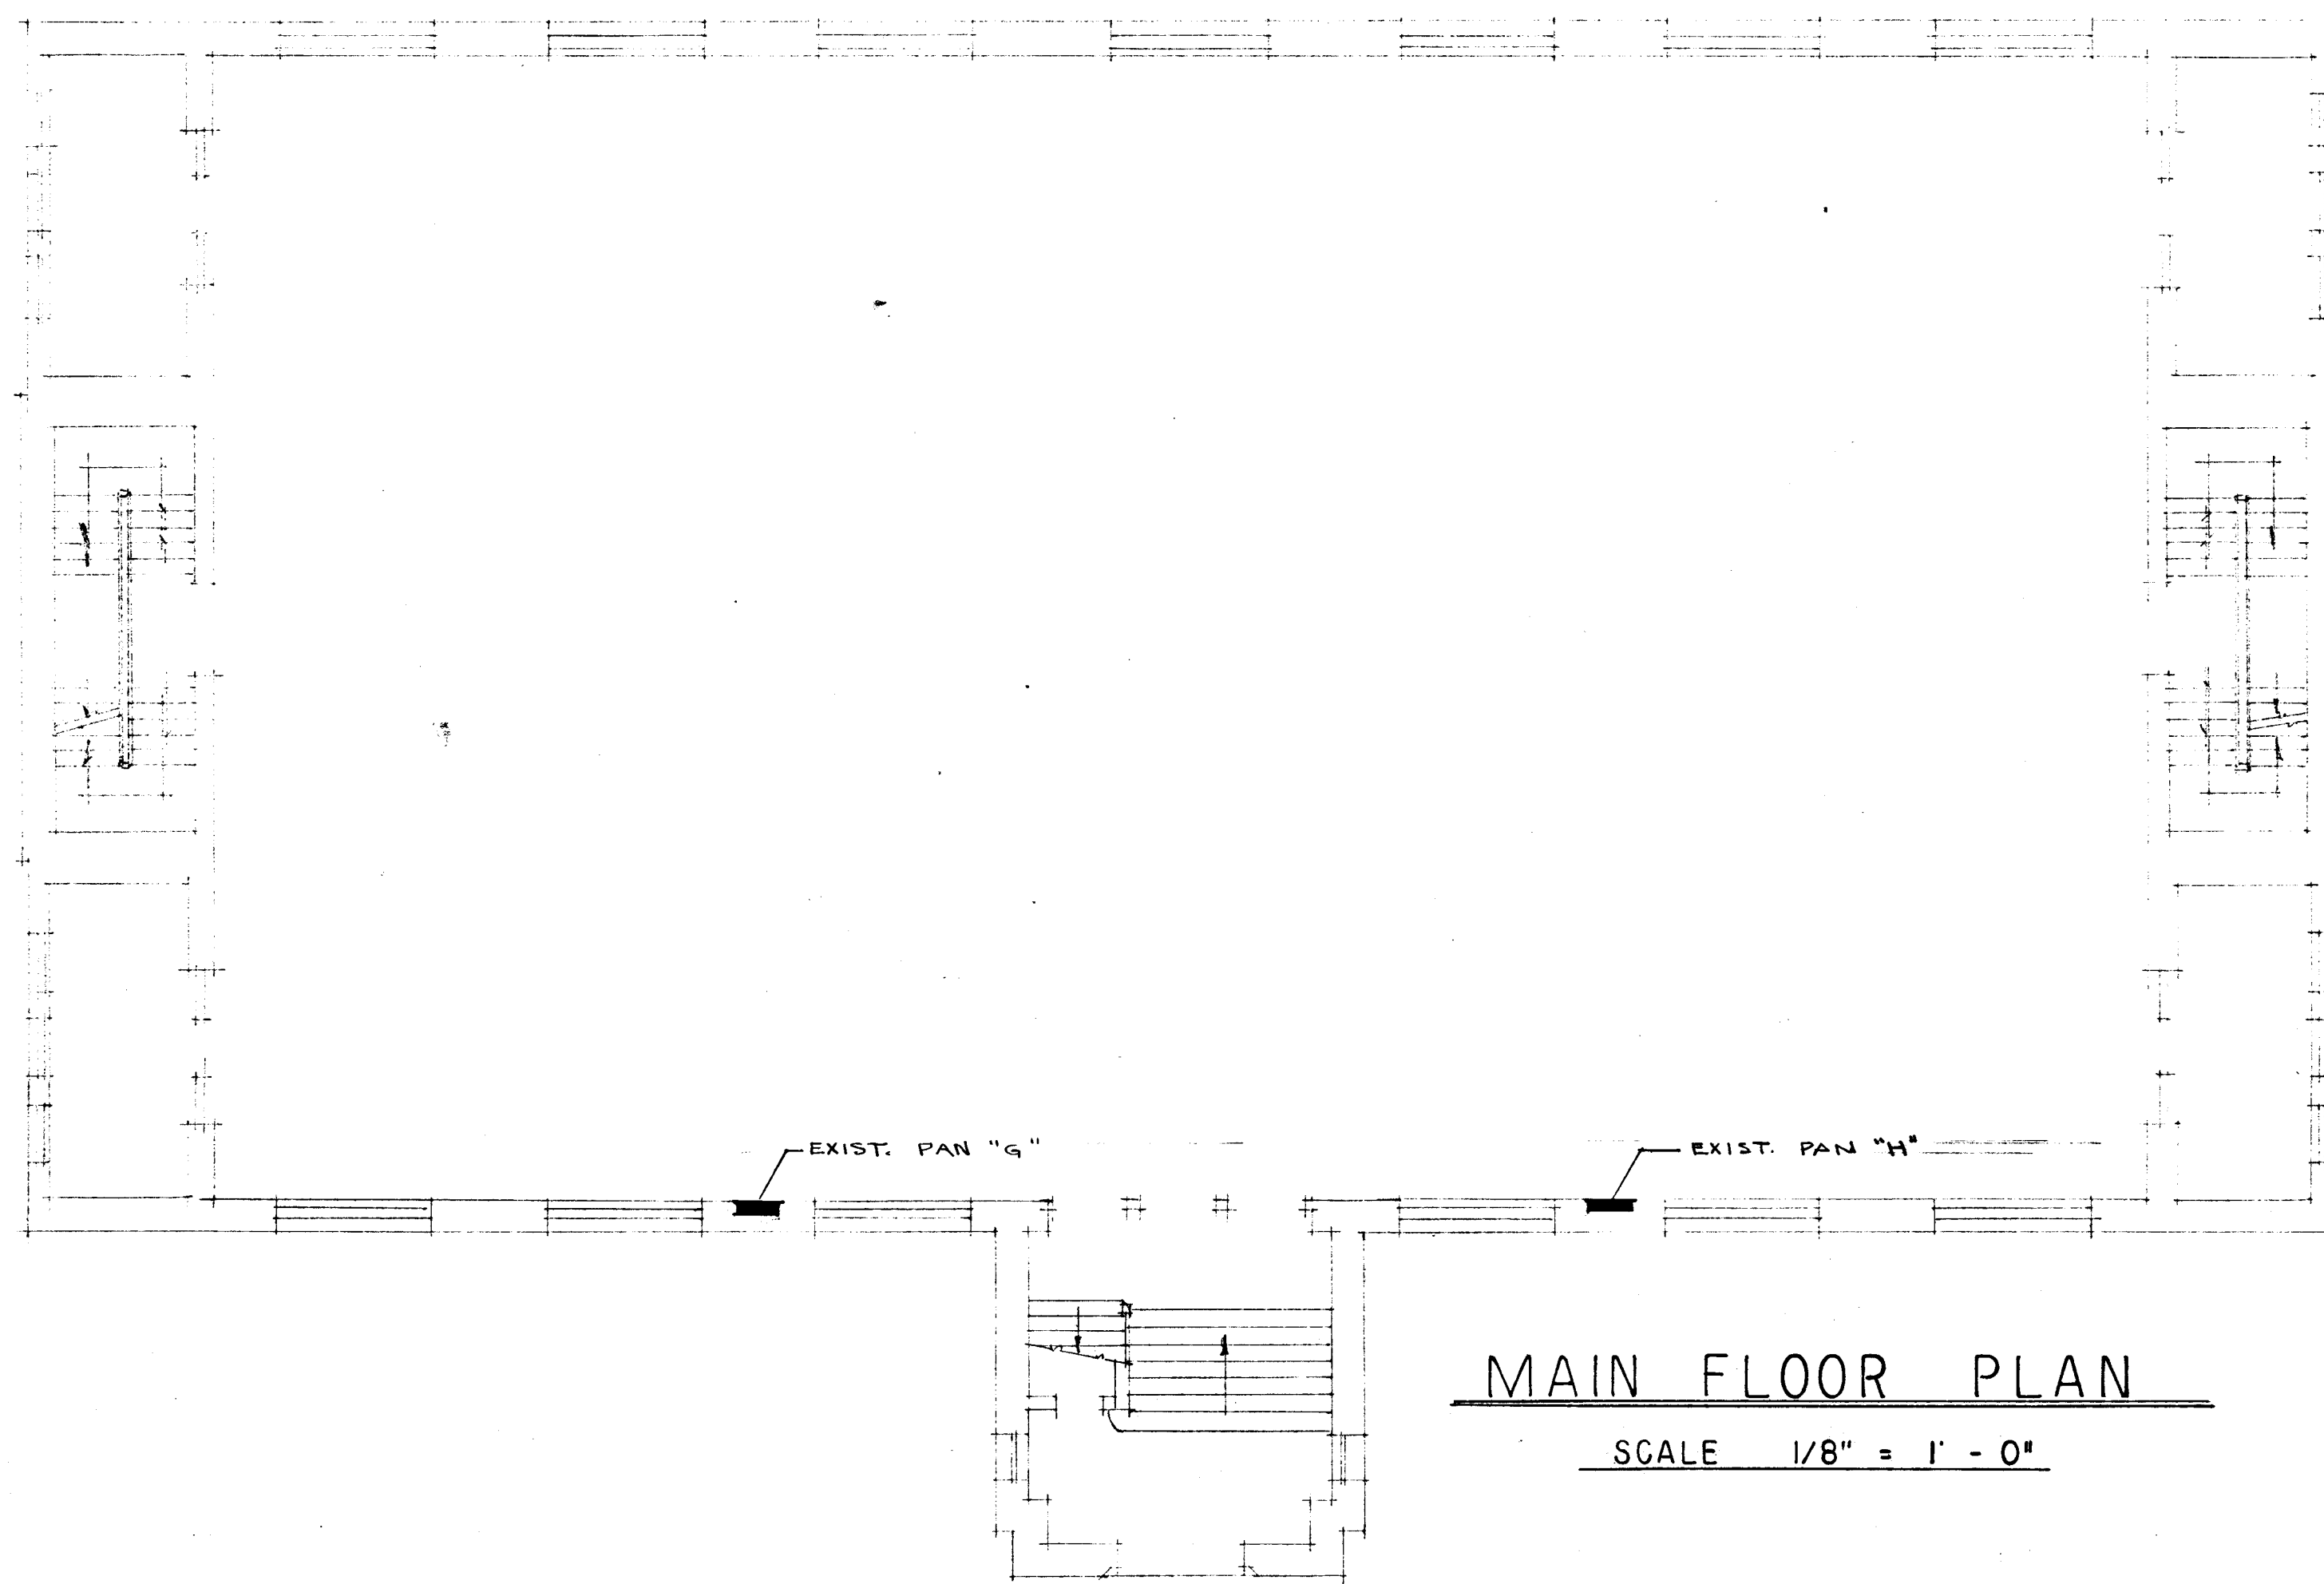

MAIN FLOOR PLAN
SCALE 1/8" = 1' - 0"

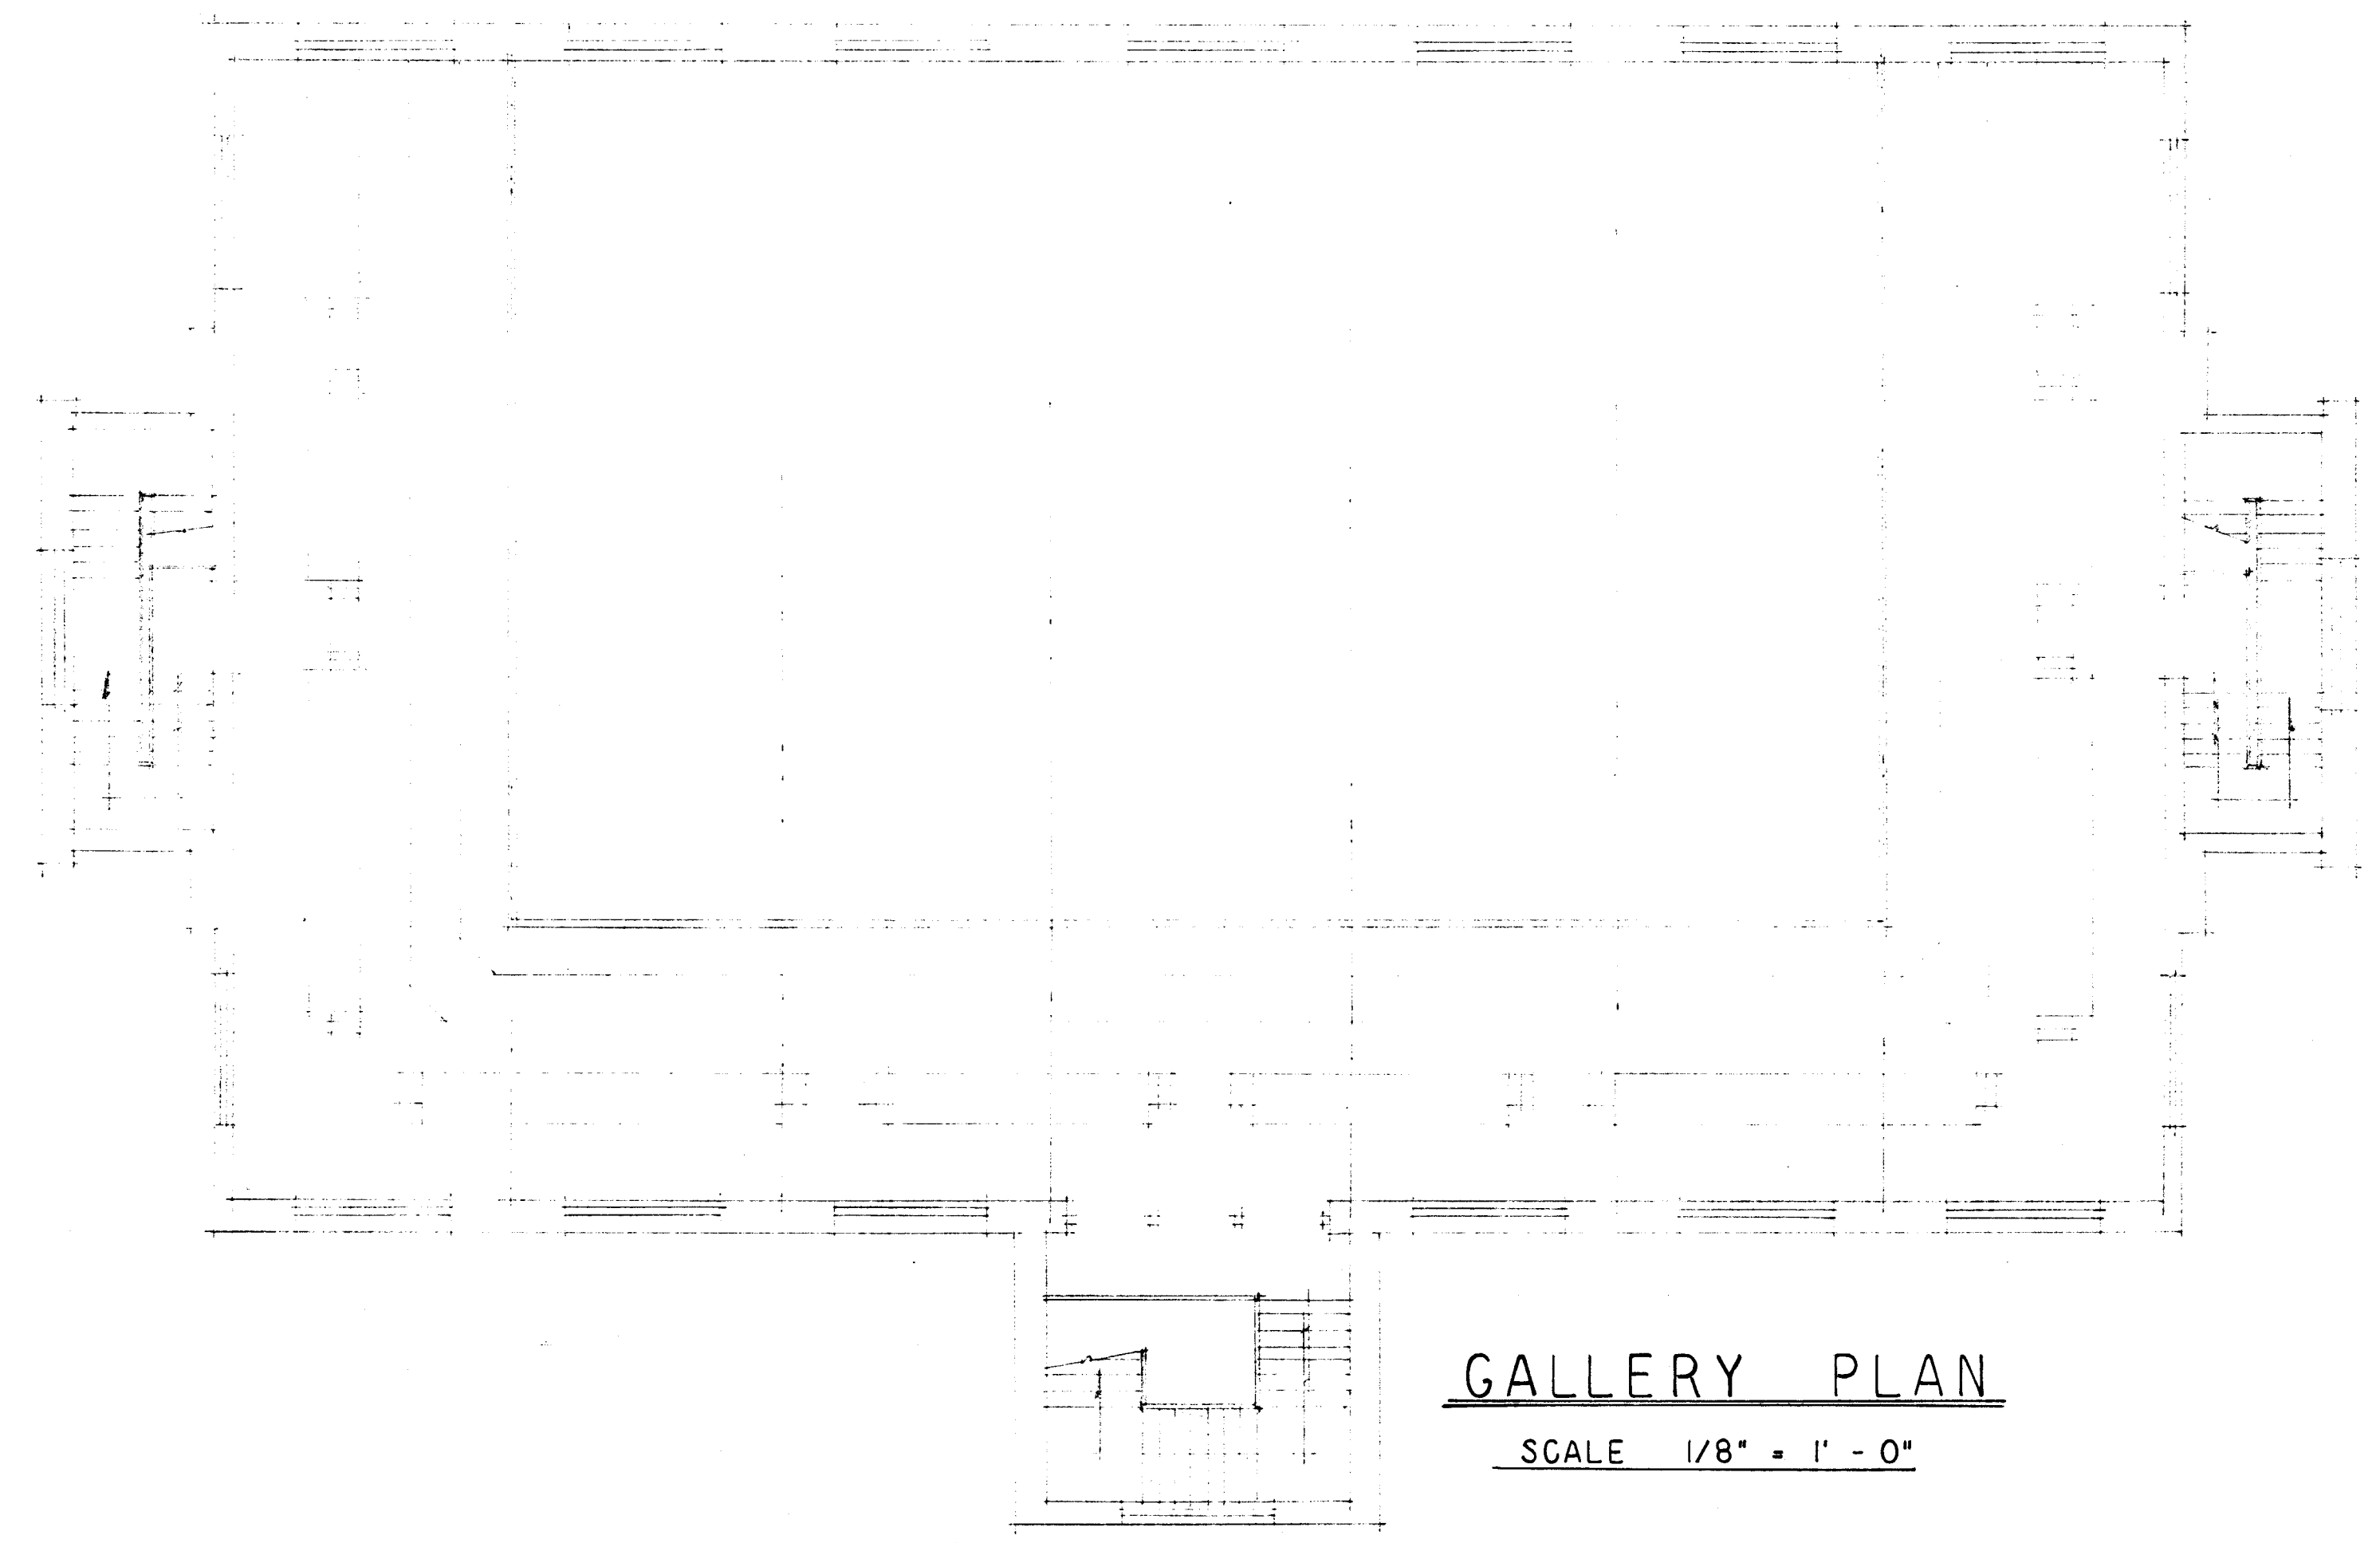

GALLERY PLAN
SCALE 1/8" = 1' - 0"

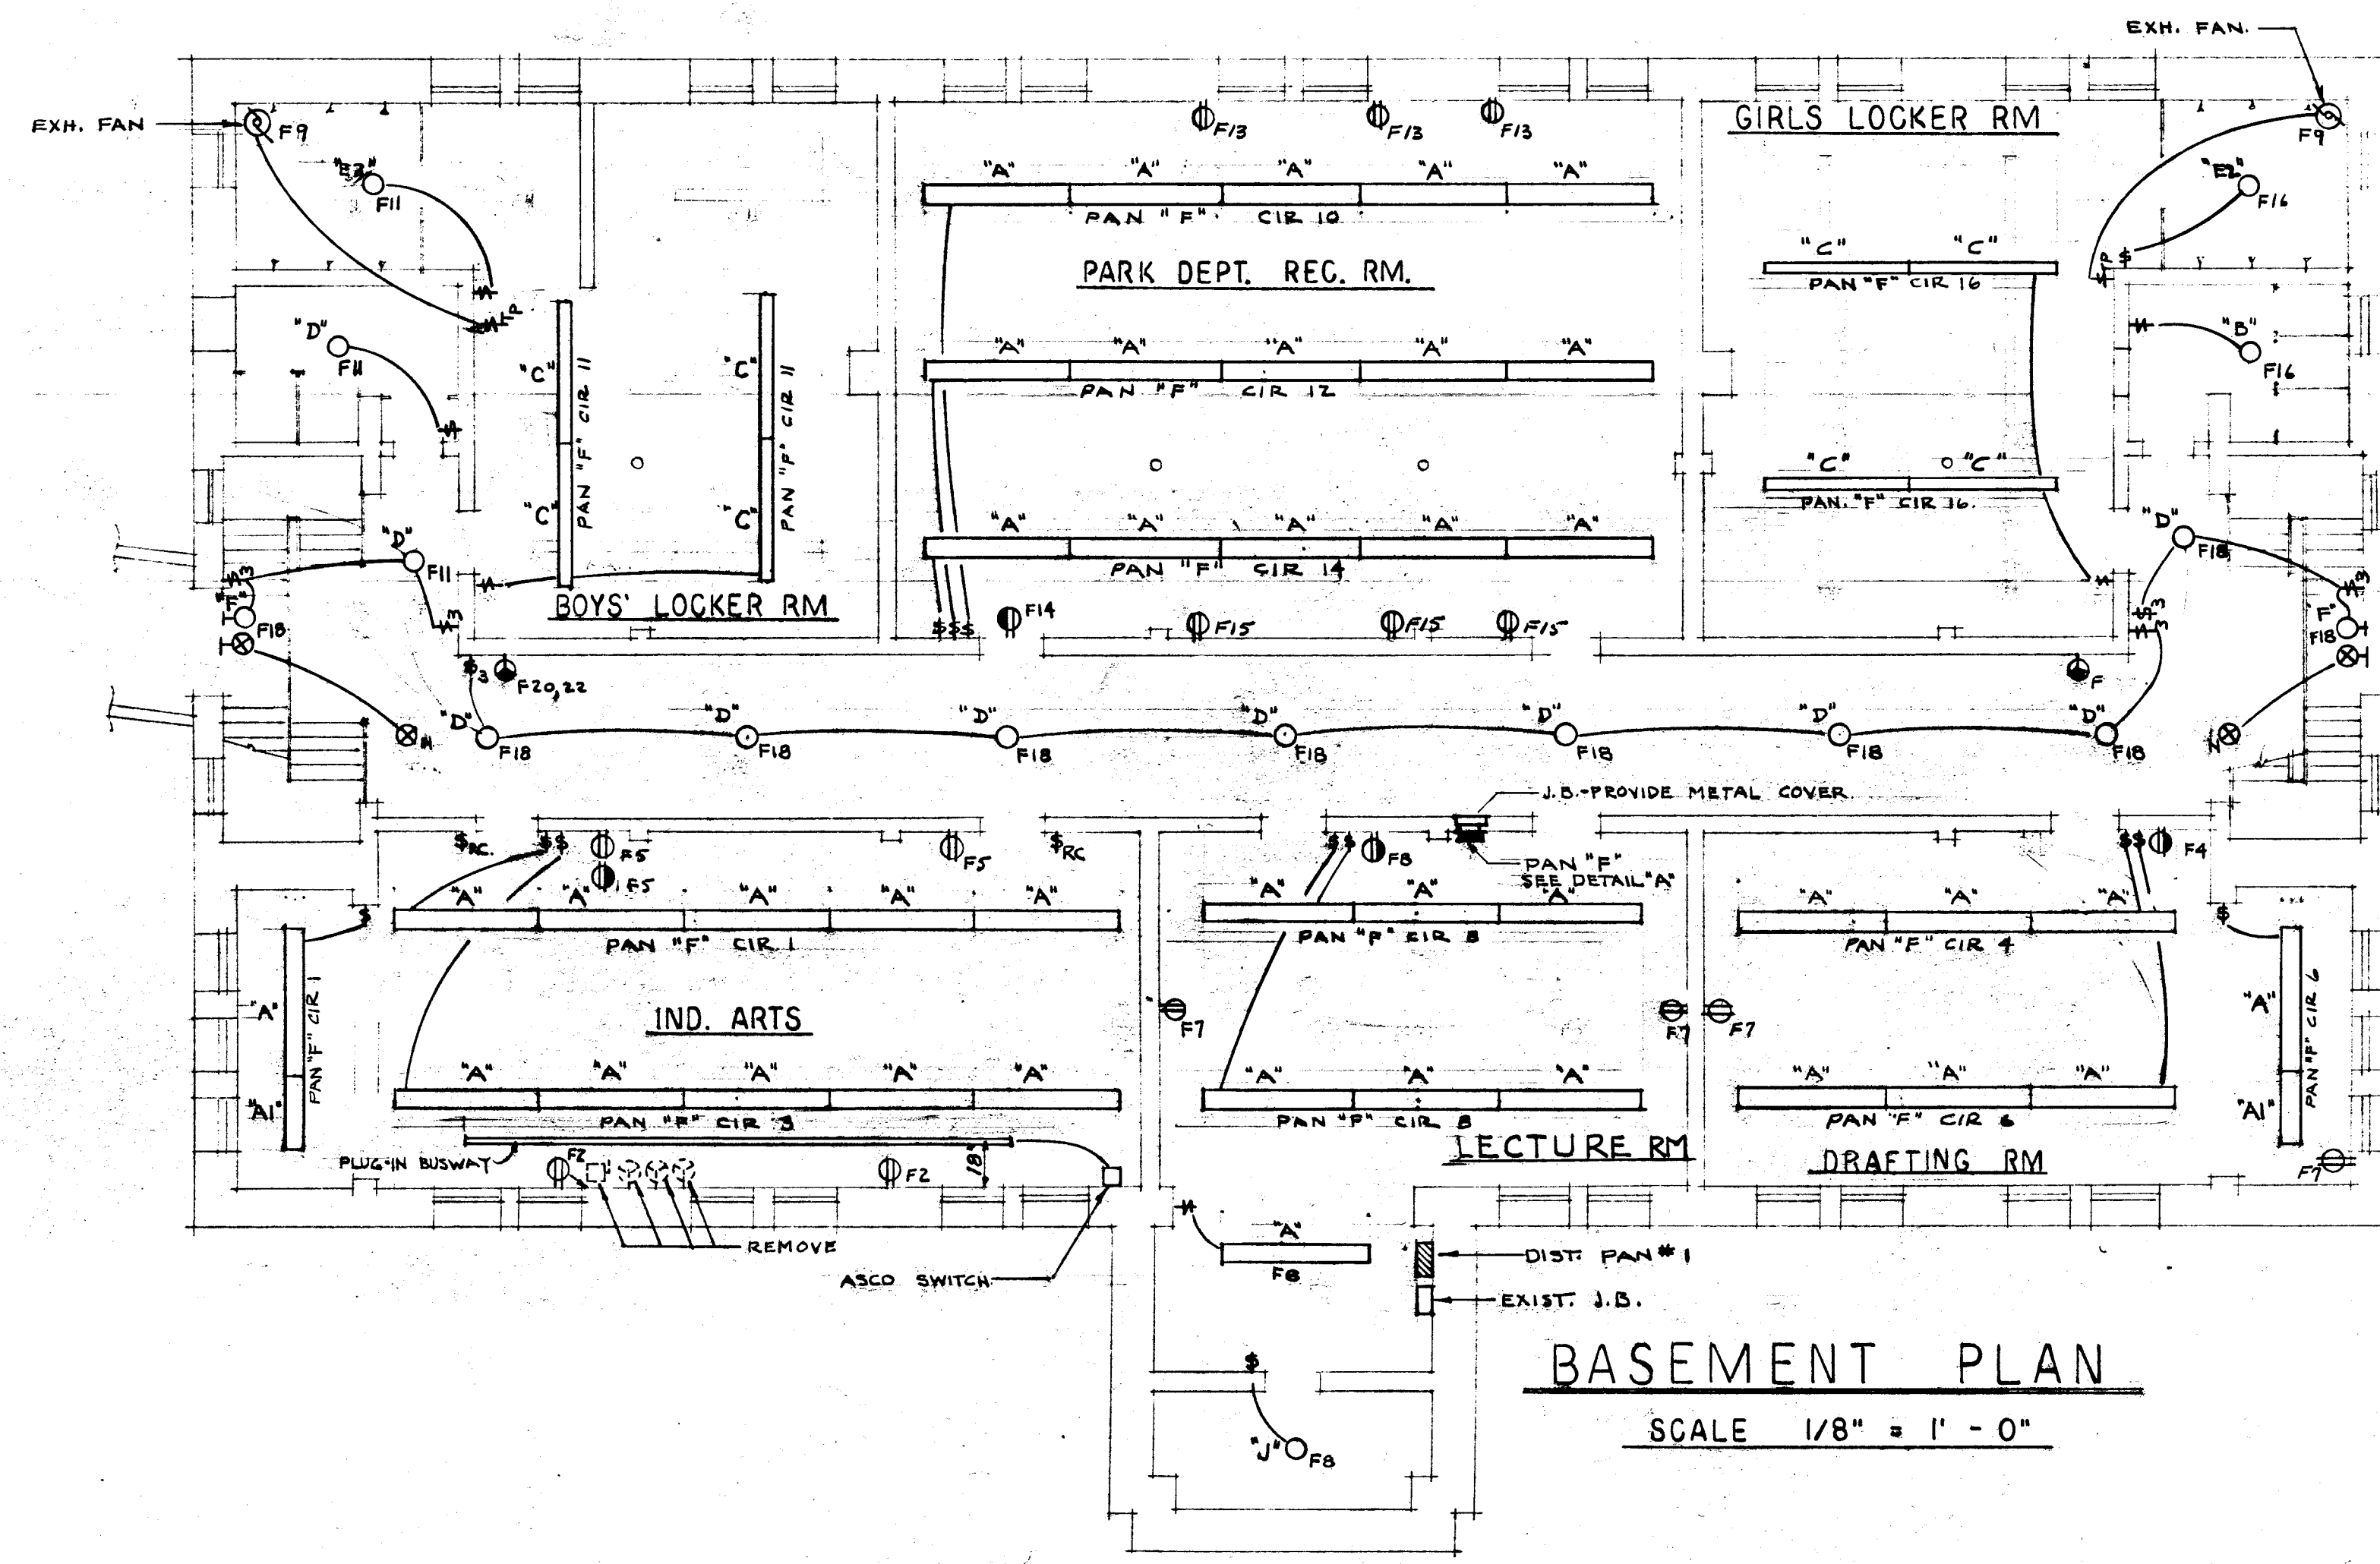

BASEMENT PLAN
SCALE 1/8" = 1' - 0"

SYMBOL LIST	
SYMBOL	DESCRIPTION
○	FLUORESCENT FIXTURE SEE NOTE #1
○	CEILING FIXTURE - SEE NOTE #1 & 2
○	WALL BRACKET - SEE NOTES #1 & 2
⊗	EXISTING EXIT LIGHT
⊗	NEW EXIT LIGHT - DAYBRITE *G-3116 STEM MTD 2-50W-A19-250V LAMPS SEE NOTE #1
⊗	DUPLEX CONVENIENCE OUTLET H/H *5262 UP 18" SEE NOTE #2
⊗	CONVENIENCE OUTLET WITH PILOT LT. H/H *5755 SEE NOTE #2
⊗	FLOOR OUTLET H/H *5284 SEE NOTE #2
⊗	EXISTING RANGE OUTLET
⊗	JUNCTION BOX
⊗	SINGLE POLE SWITCH H/H *1991 UP 4'-0"
⊗	THREE WAY SWITCH H/H *1993 UP 4'-0"
⊗	FOUR WAY SWITCH H/H *1994 UP 4'-0"
⊗	SINGLE POLE KEYED SWITCH *1991-L UP 4'-0"
⊗	MOMENTARY CONTACT SWITCH FOR CONTROL OF ASCO R.C. SW. IN IND. ARTS RM. SEE SPEC.
⊗	MOTOR
⊗	MAGNETIC MOTOR STARTER
⊗	FUSED DISCONNECT
⊗	MANUAL MOTOR STARTER WITH PILOT AH/H *RL11-PL
⊗	LIGHTING PANEL
⊗	POWER OR DISTRIBUTION PANEL
⊗	EXIST. RECEPTACLE TO REMAIN - PROVIDE NEW BRANCH CIRCUIT WIRING
⊗	SINGLE RECEPTACLE FOR CLOCK H/H *5284 - UP SAME HEIGHT AS EXISTING CLOCK OR 8'-0" MIN.
⊗	CLEANING RECEPTACLE H/H *5272 UP 18" SEE NOTE #2

NOTES:
1. LETTER INDICATES FIXTURE TYPE e.g. "A". SEE FIXTURE SCHEDULE.
2. COMBINATION OF LETTER & NUMBER INDICATES PANEL & CIRCUIT e.g. "A2" (PAN. A CIR #2)

GYMNASIUM BLDG

CITY OF HARTFORD, CONNECTICUT
DEPARTMENT OF ENGINEERING

ELECTRICAL ALTERATIONS
FOR
WEST MIDDLE SCHOOL
927 ASYLUM AVE. HARTFORD CONN.

SUBMITTED	RECOMMENDED	APPROVED
<i>Raymond A. Berman</i>	<i>Daniel A. Tansill</i>	<i>Patricia A. Berman</i>
CITY ARCHITECT	CITY ARCHITECT	CITY ENGINEER

DESIGN *R.G.B.* DRAWN
TRACED _____ CHECK _____

DAYBOOK NO. 09767D
DATE APRIL 1, 1963

VERIFY EXISTING
CONDITIONS AND
DIMENSIONS AT
BUILDING