


FIXTURE		SCHEDULE	
TYPE	MANUFACTURER & CATALOG NO.	MOUNTING	LAMPS
A	SEE SPEC.	SEE SPEC.	4-48" T12-40W RS
A1	SEE SPEC.	SEE SPEC.	2-48" T12-40W RS
B	LIGHTOLIER N° 7158	SURFACE MTD.	2-48" T12-40W RS
BI	LIGHTOLIER N° 7158	STEM MTD. - MIN. LENGTH STEMS TO CLEAR DUCTS	2-48" T12-40W RS
C	EXISTING - PROVIDE NEW FIXTURE WIRE.		
D	PERFECTITE N° HH-13	SURFACE MTD.	2-75W INCAND. 1F.
DI	PERFECTITE N° HH-15	SURFACE MTD.	2-100W INCAND. 1F.
E	PRESCOLITE N° CF-2	SURFACE MTD.	1-100W INCAND. 1F.
E1	PRESCOLITE N° CF-28	SURFACE MTD.	1-200W INCAND. 1F.
F	PRESCOLITE N° WB-24	WALL MTD.	1-100W INCAND. 1F.
F1	PRESCOLITE N° WB-28	WALL MTD. UP 8'-0"	1-200W INCAND. 1F.
F2	PRESCOLITE N° WB-28 W/WG-8	WALL MTD.	1-200W INCAND. 1F.
G	EXIST. FIXT. RELOCATED FROM C.R.		
H	HOLOPHANE N° C-824	CLG. MTD.	1-150W INCAND. 1F.
J	H&H N° 860	BOX MTD.	1-100W INCAND. 1F.
K	STONCO 3 N° 4400-L W/75B(20X) 1/28		3-150W PAR FL.

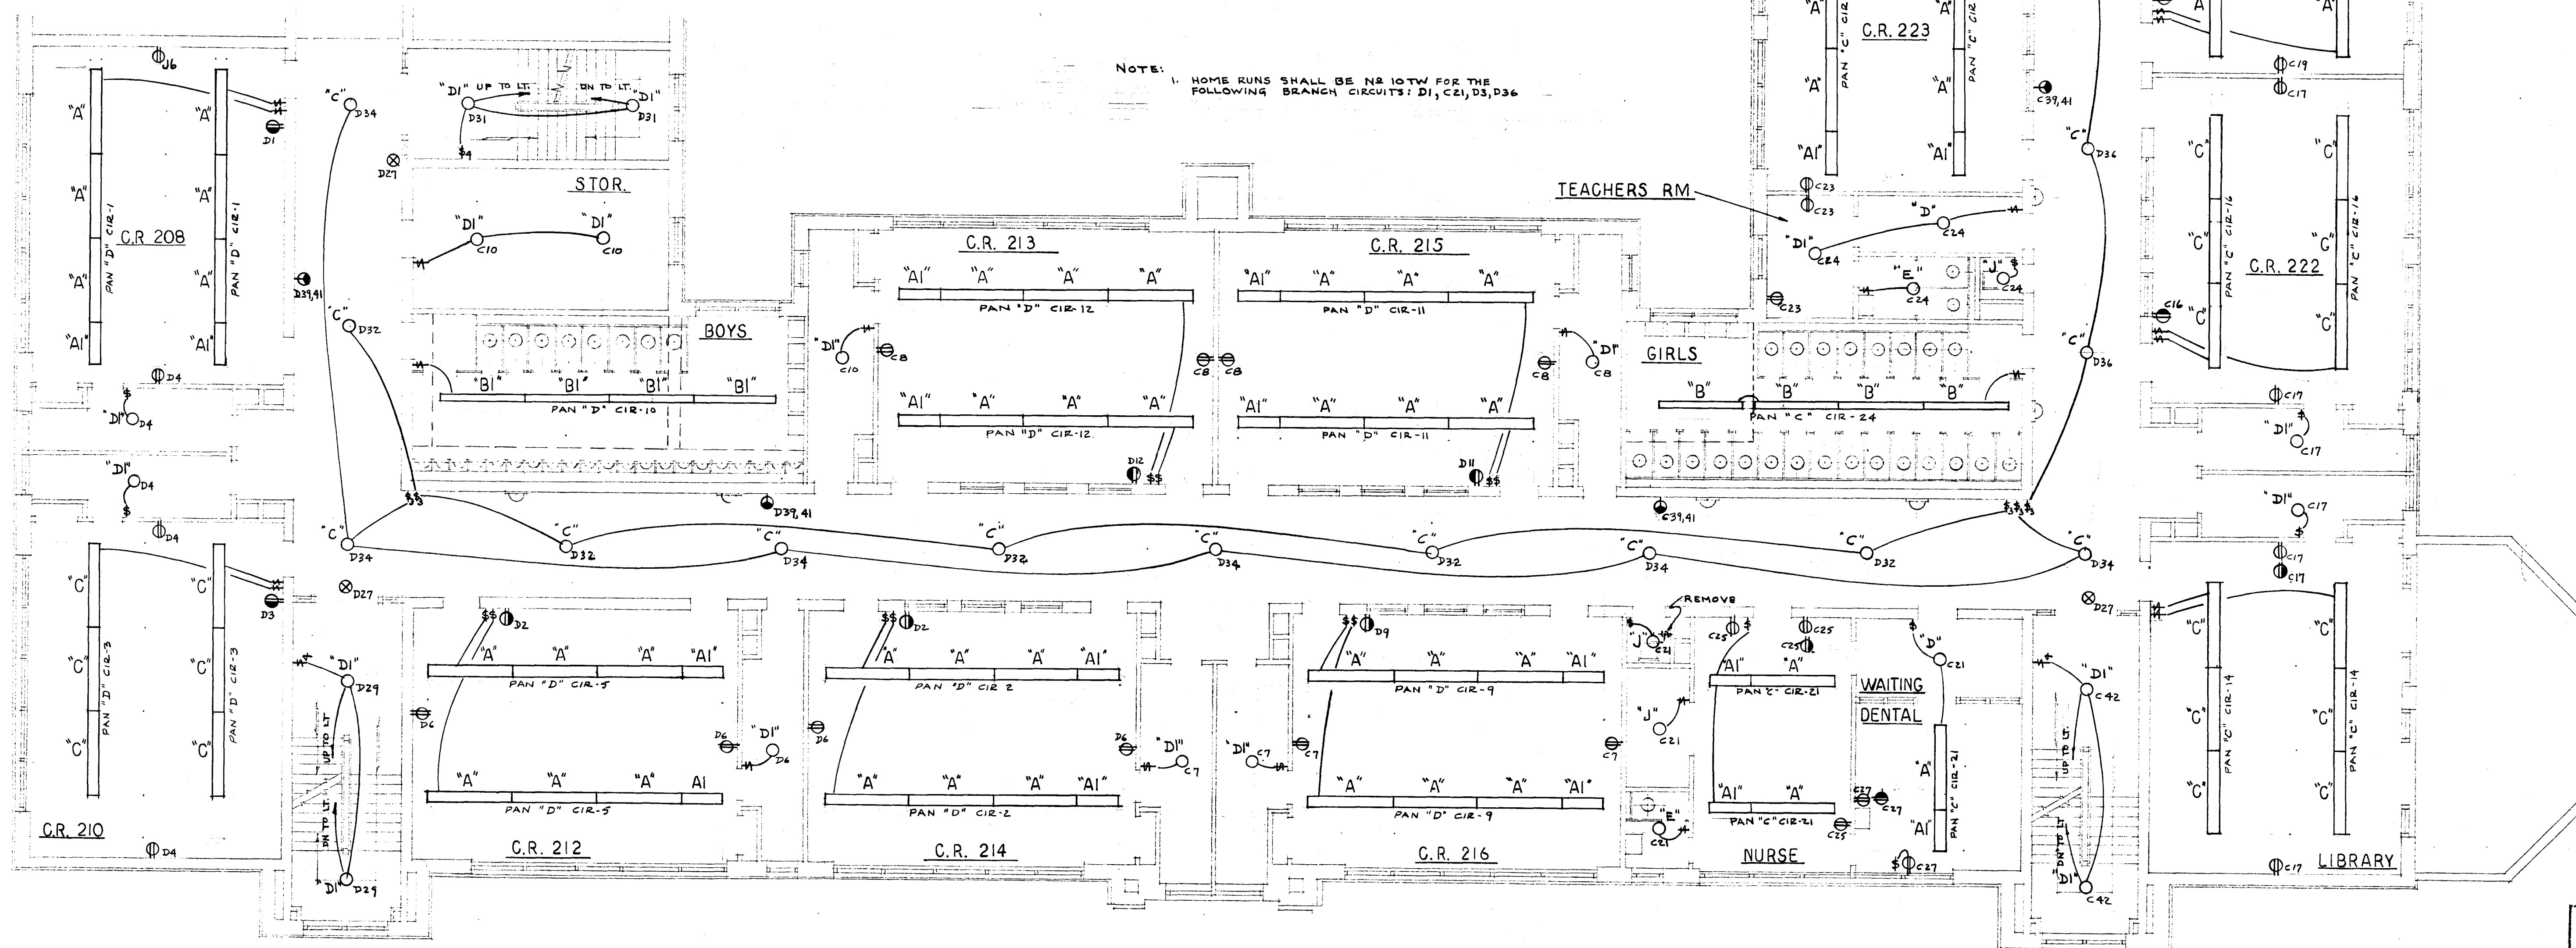

NOTE: 1. HOME RUNS SHALL BE N° 10TW FOR THE FOLLOWING BRANCH CIRCUITS: D1, C21, D3, D36

FIRST FLOOR PLAN - BLDG "A"

SCALE 1/8" = 1'-0"

CITY OF HARTFORD, CONNECTICUT DEPARTMENT OF ENGINEERING		
ELECTRICAL ALTERATIONS FOR HENRY BARNARD SCHOOL 1304 MAIN ST. HARTFORD CONN.		
SUBMITTED <i>Raymond L. Bannan</i>	RECOMMENDED <i>Daniel J. Taubell</i>	APPROVED <i>John J. Bannan</i>
DESIGN <i>R.C.B.</i>	DRAWN	DAYBOOK NO. 097685
TRACED	CHECK	DATE APRIL 1, 1943

VERIFY EXISTING
CONDITIONS AND
DIMENSIONS AT
BUILDING

SHEET NO.
2
OF 4 SHEETS