
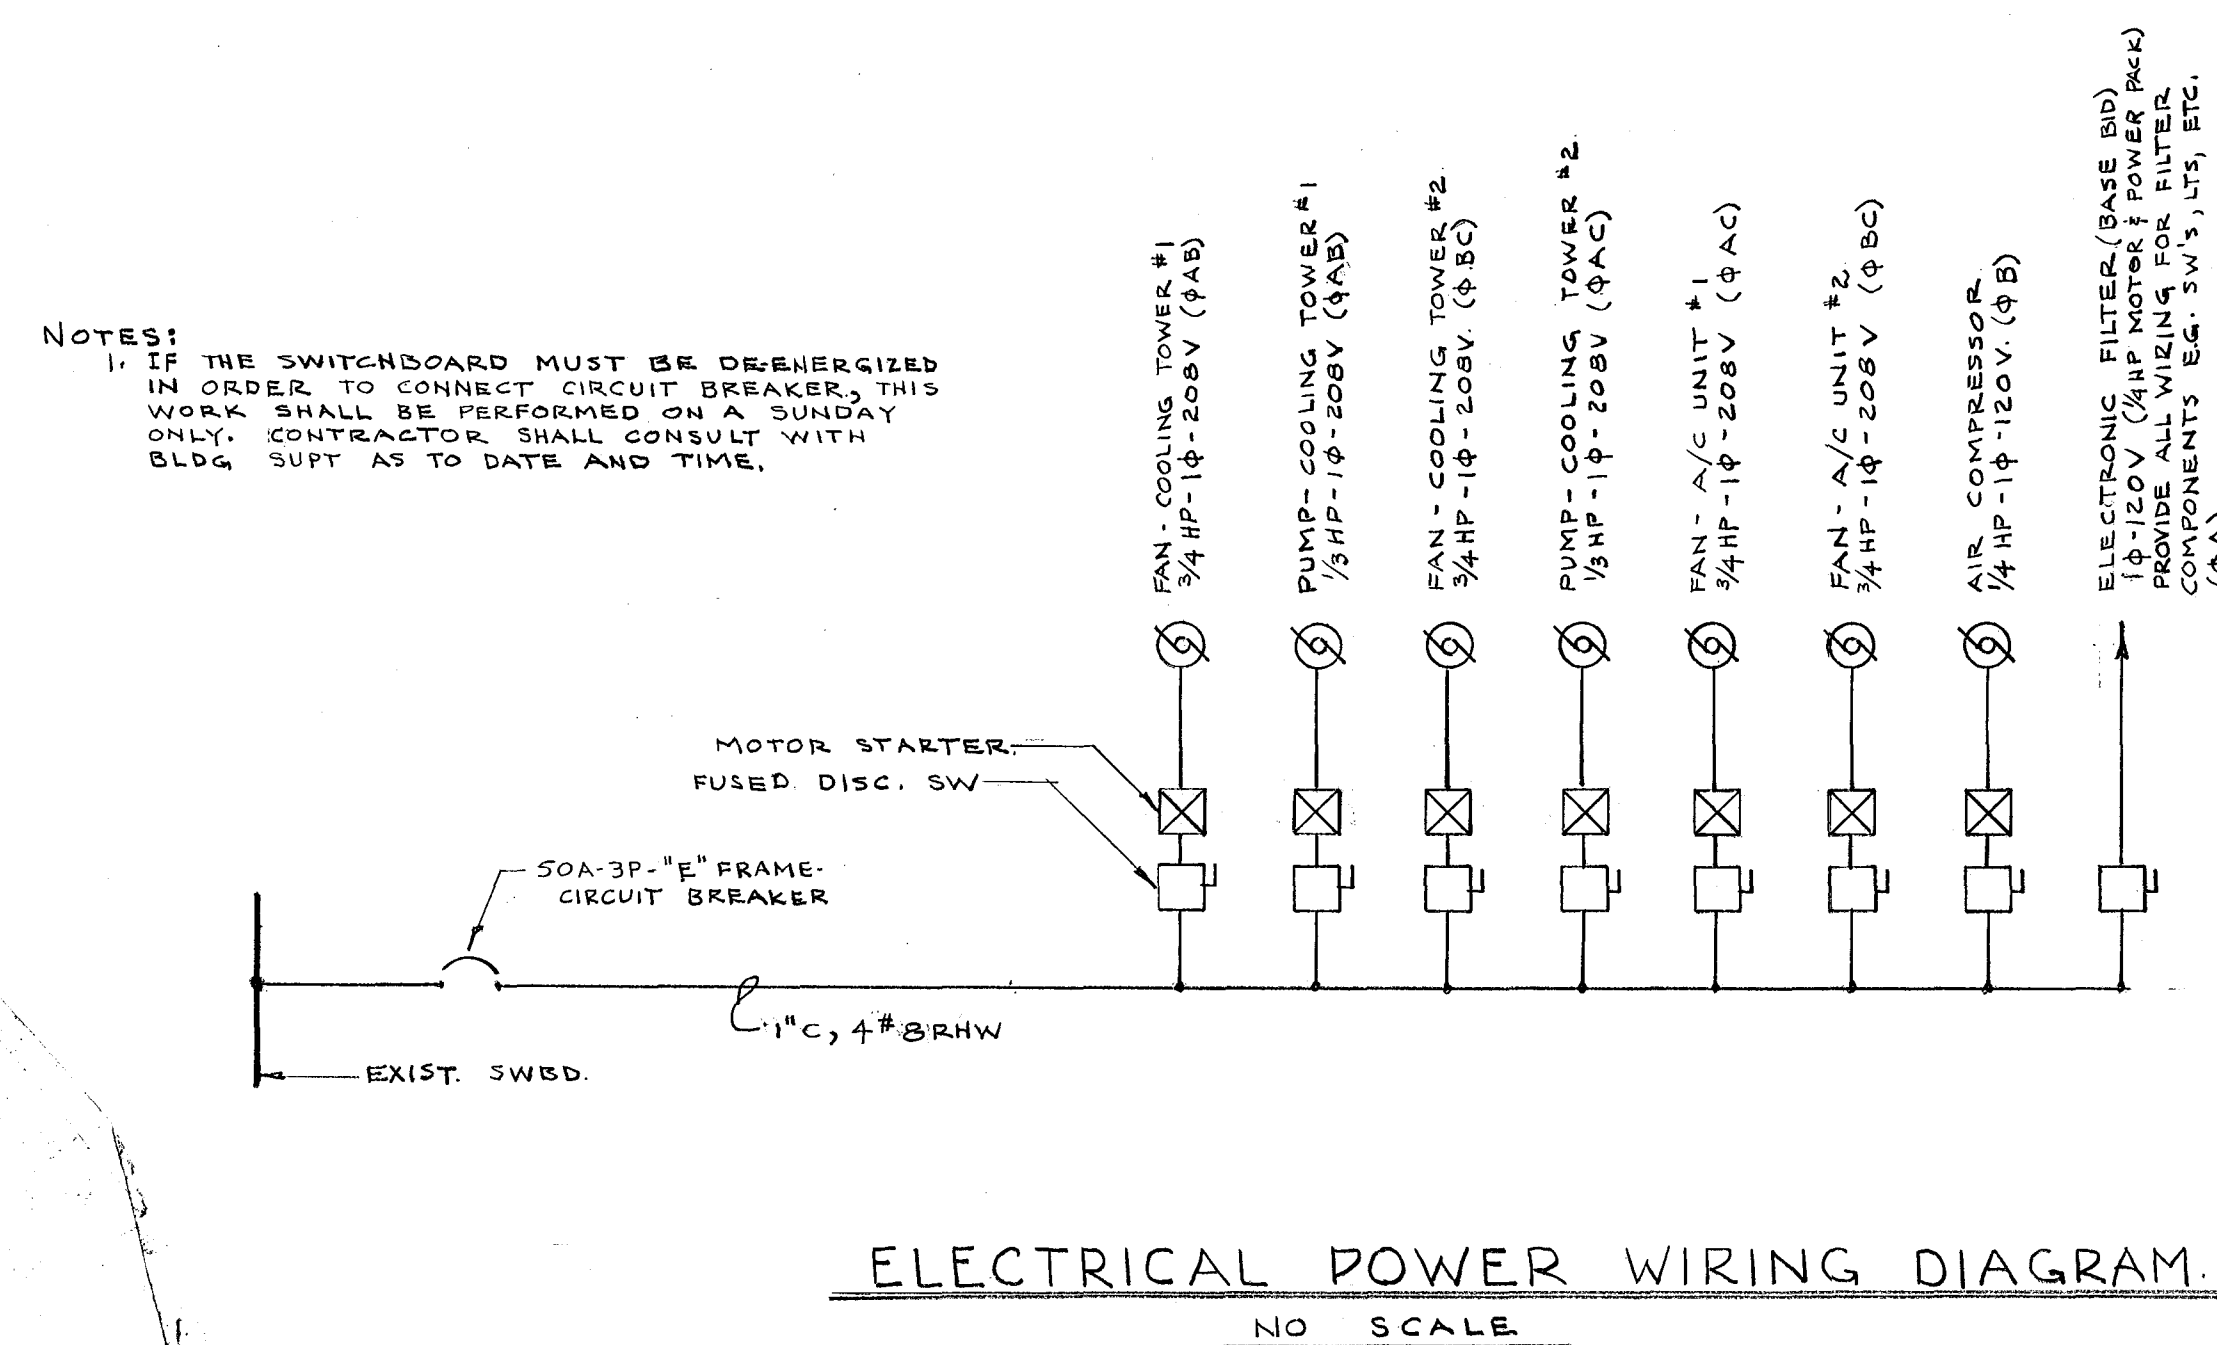
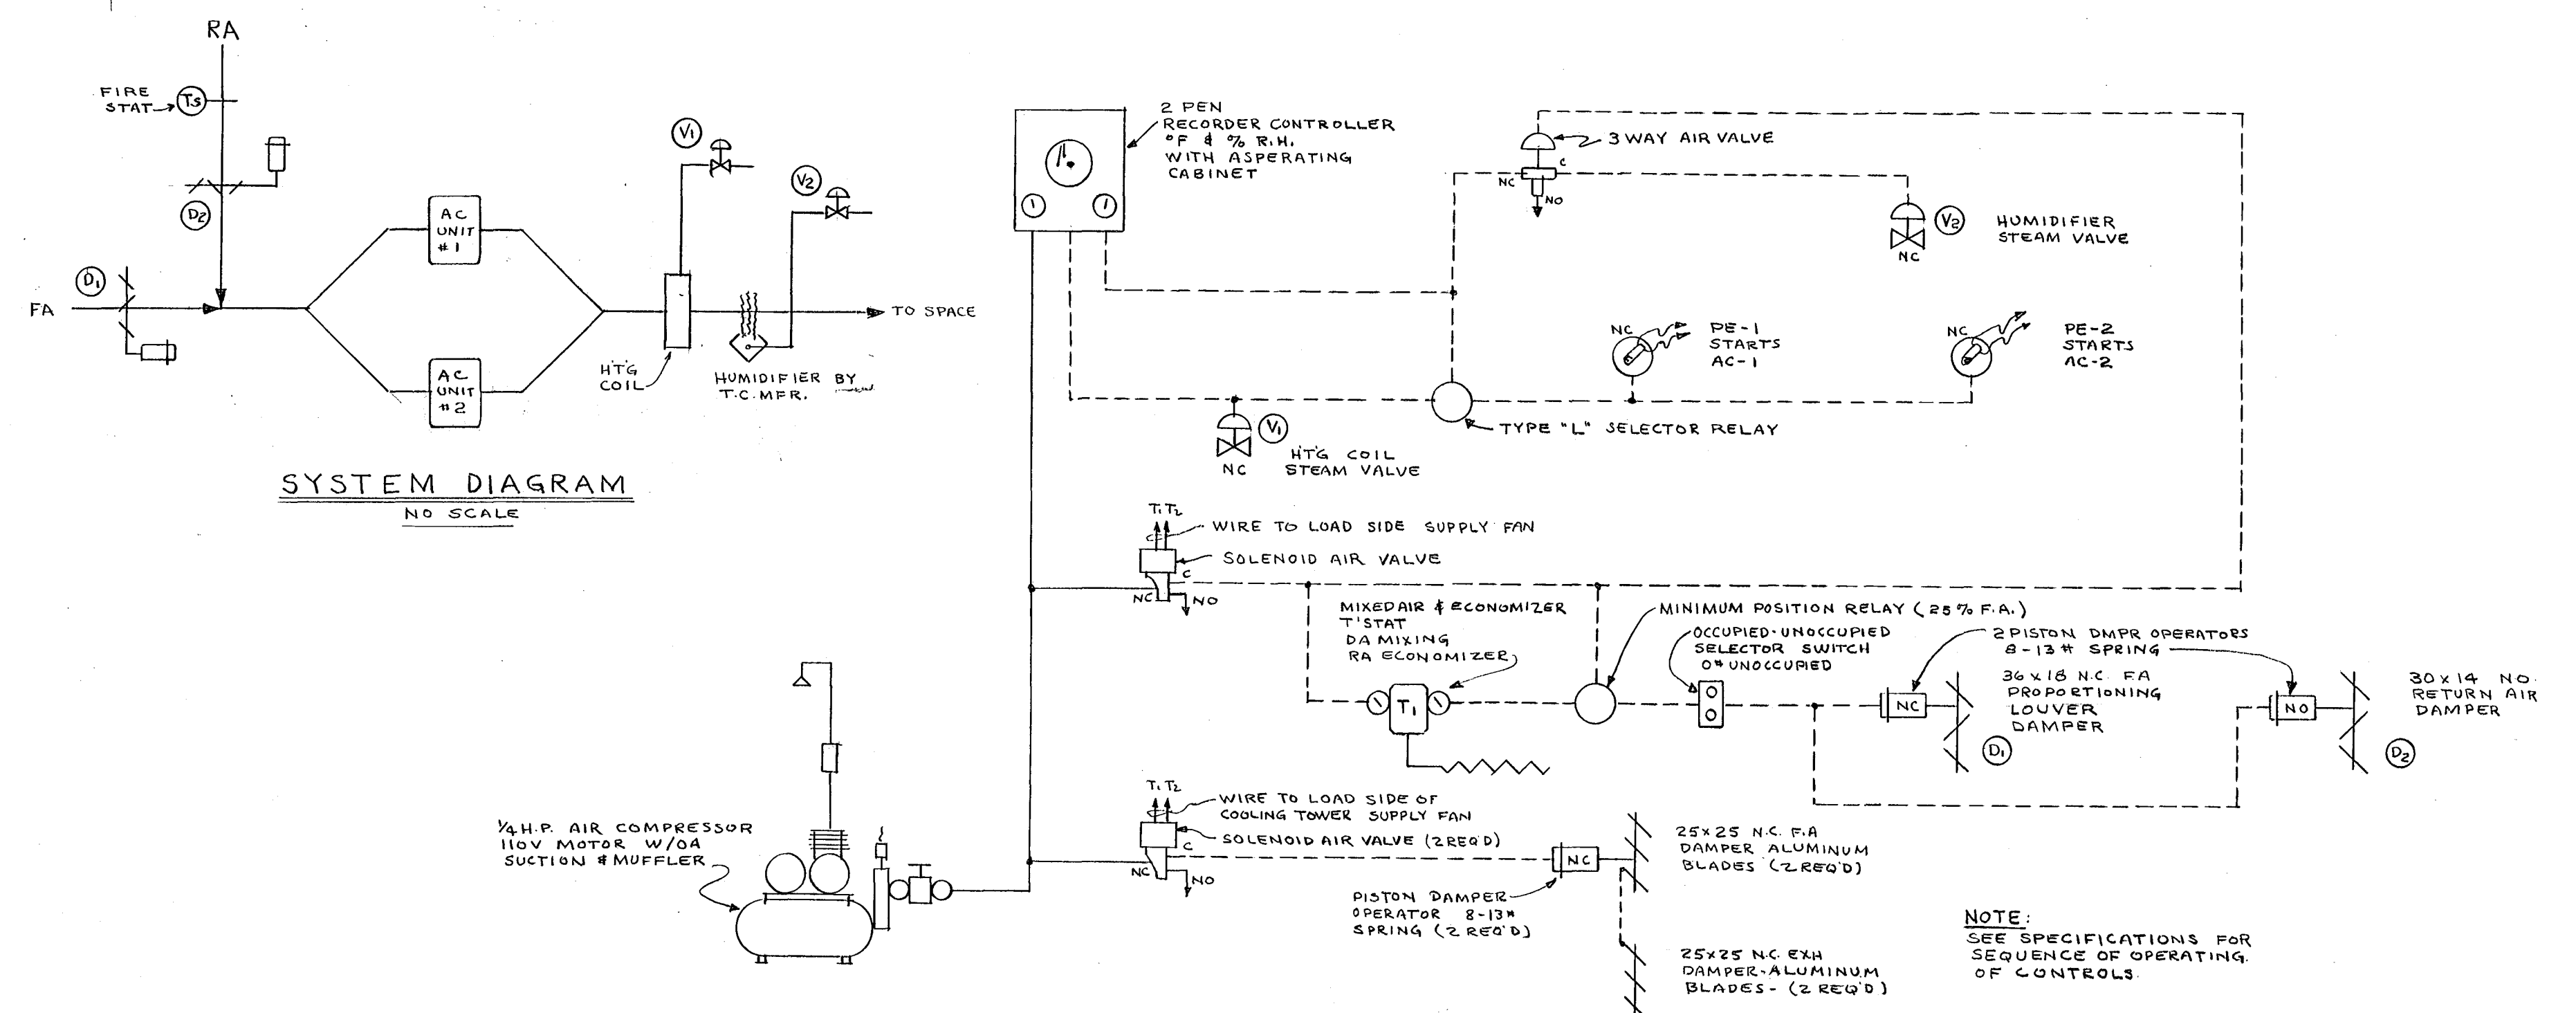
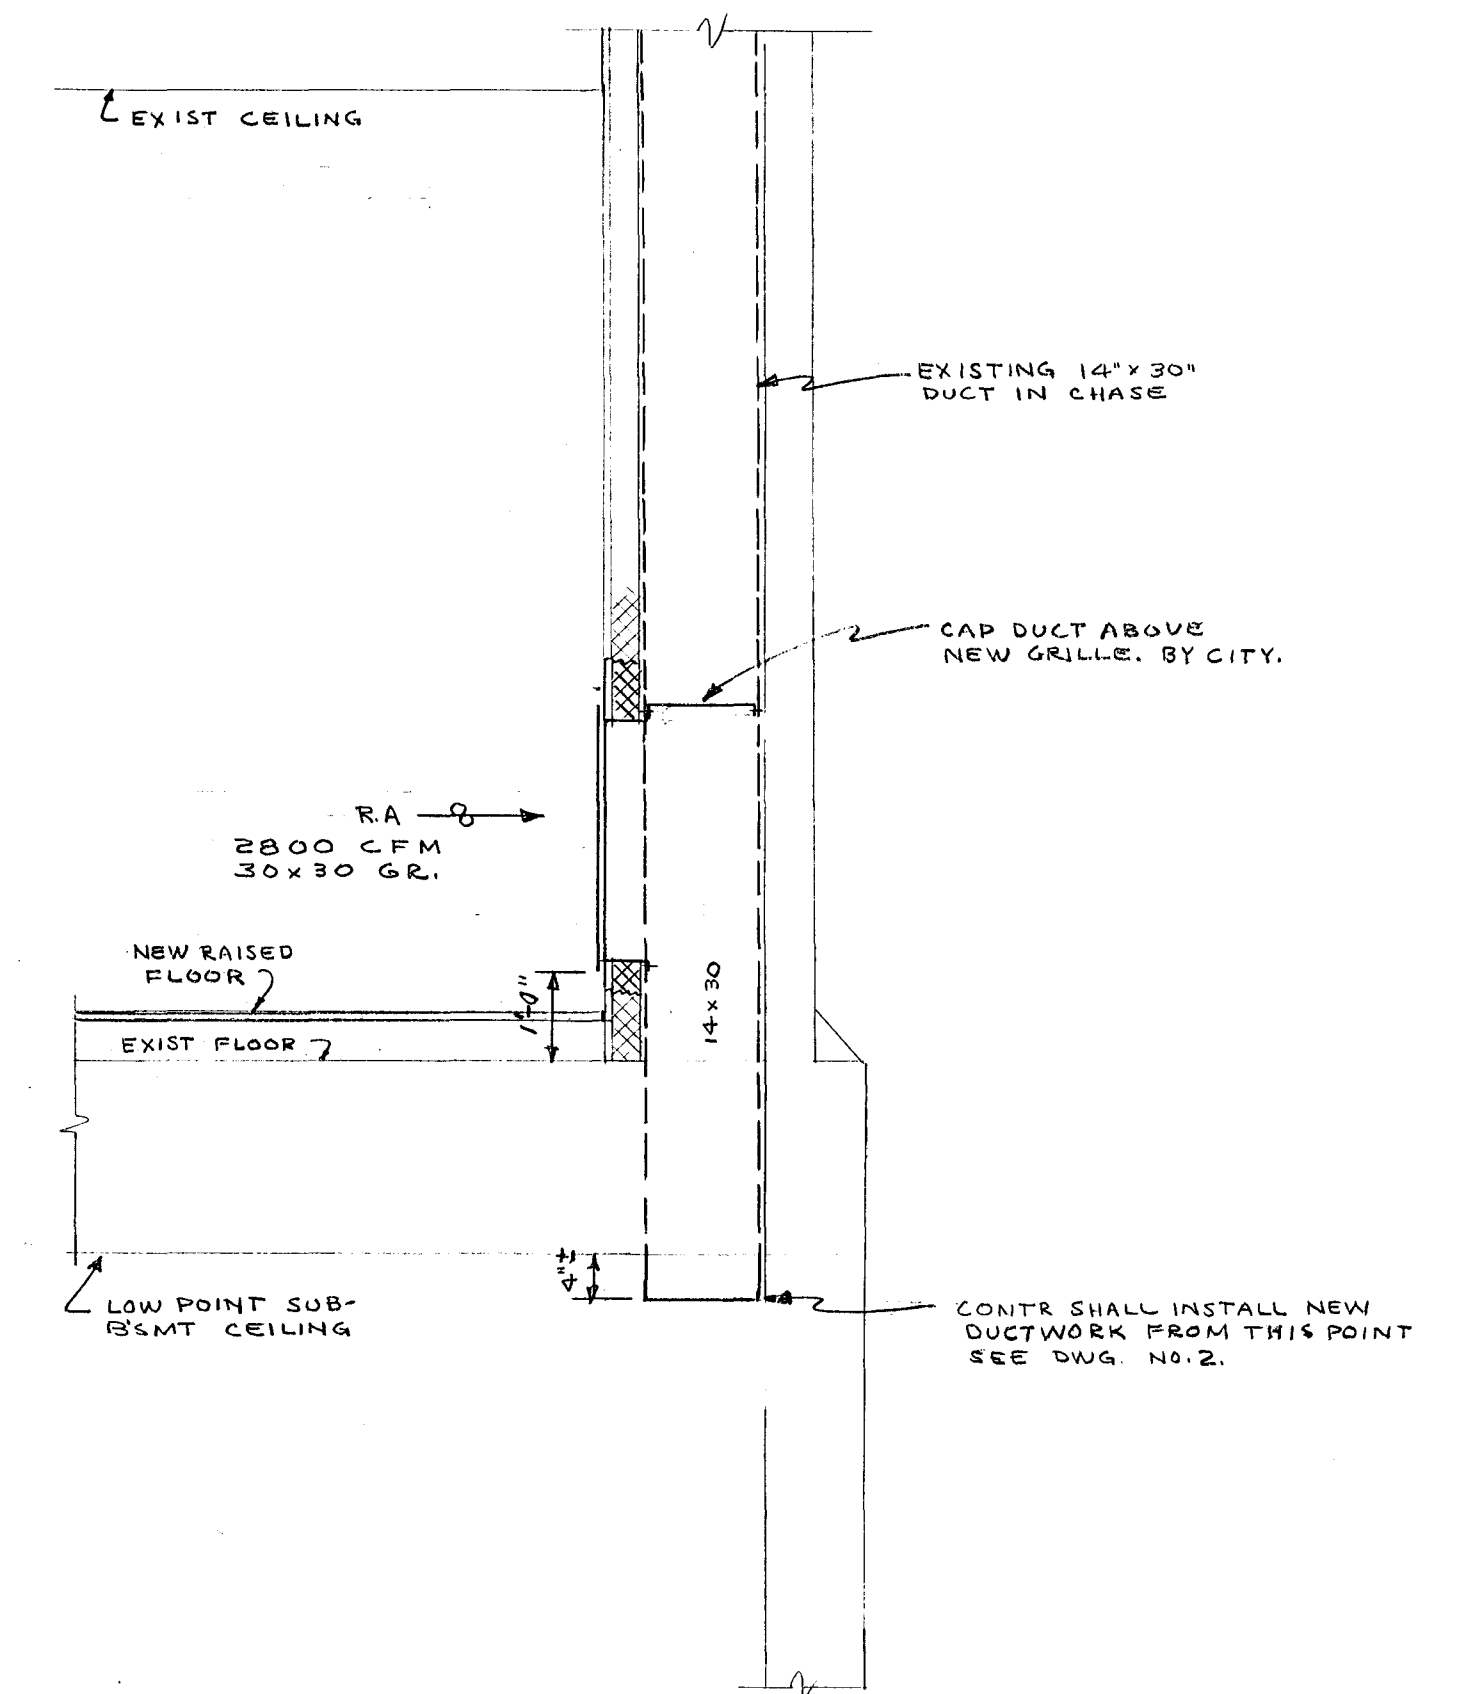
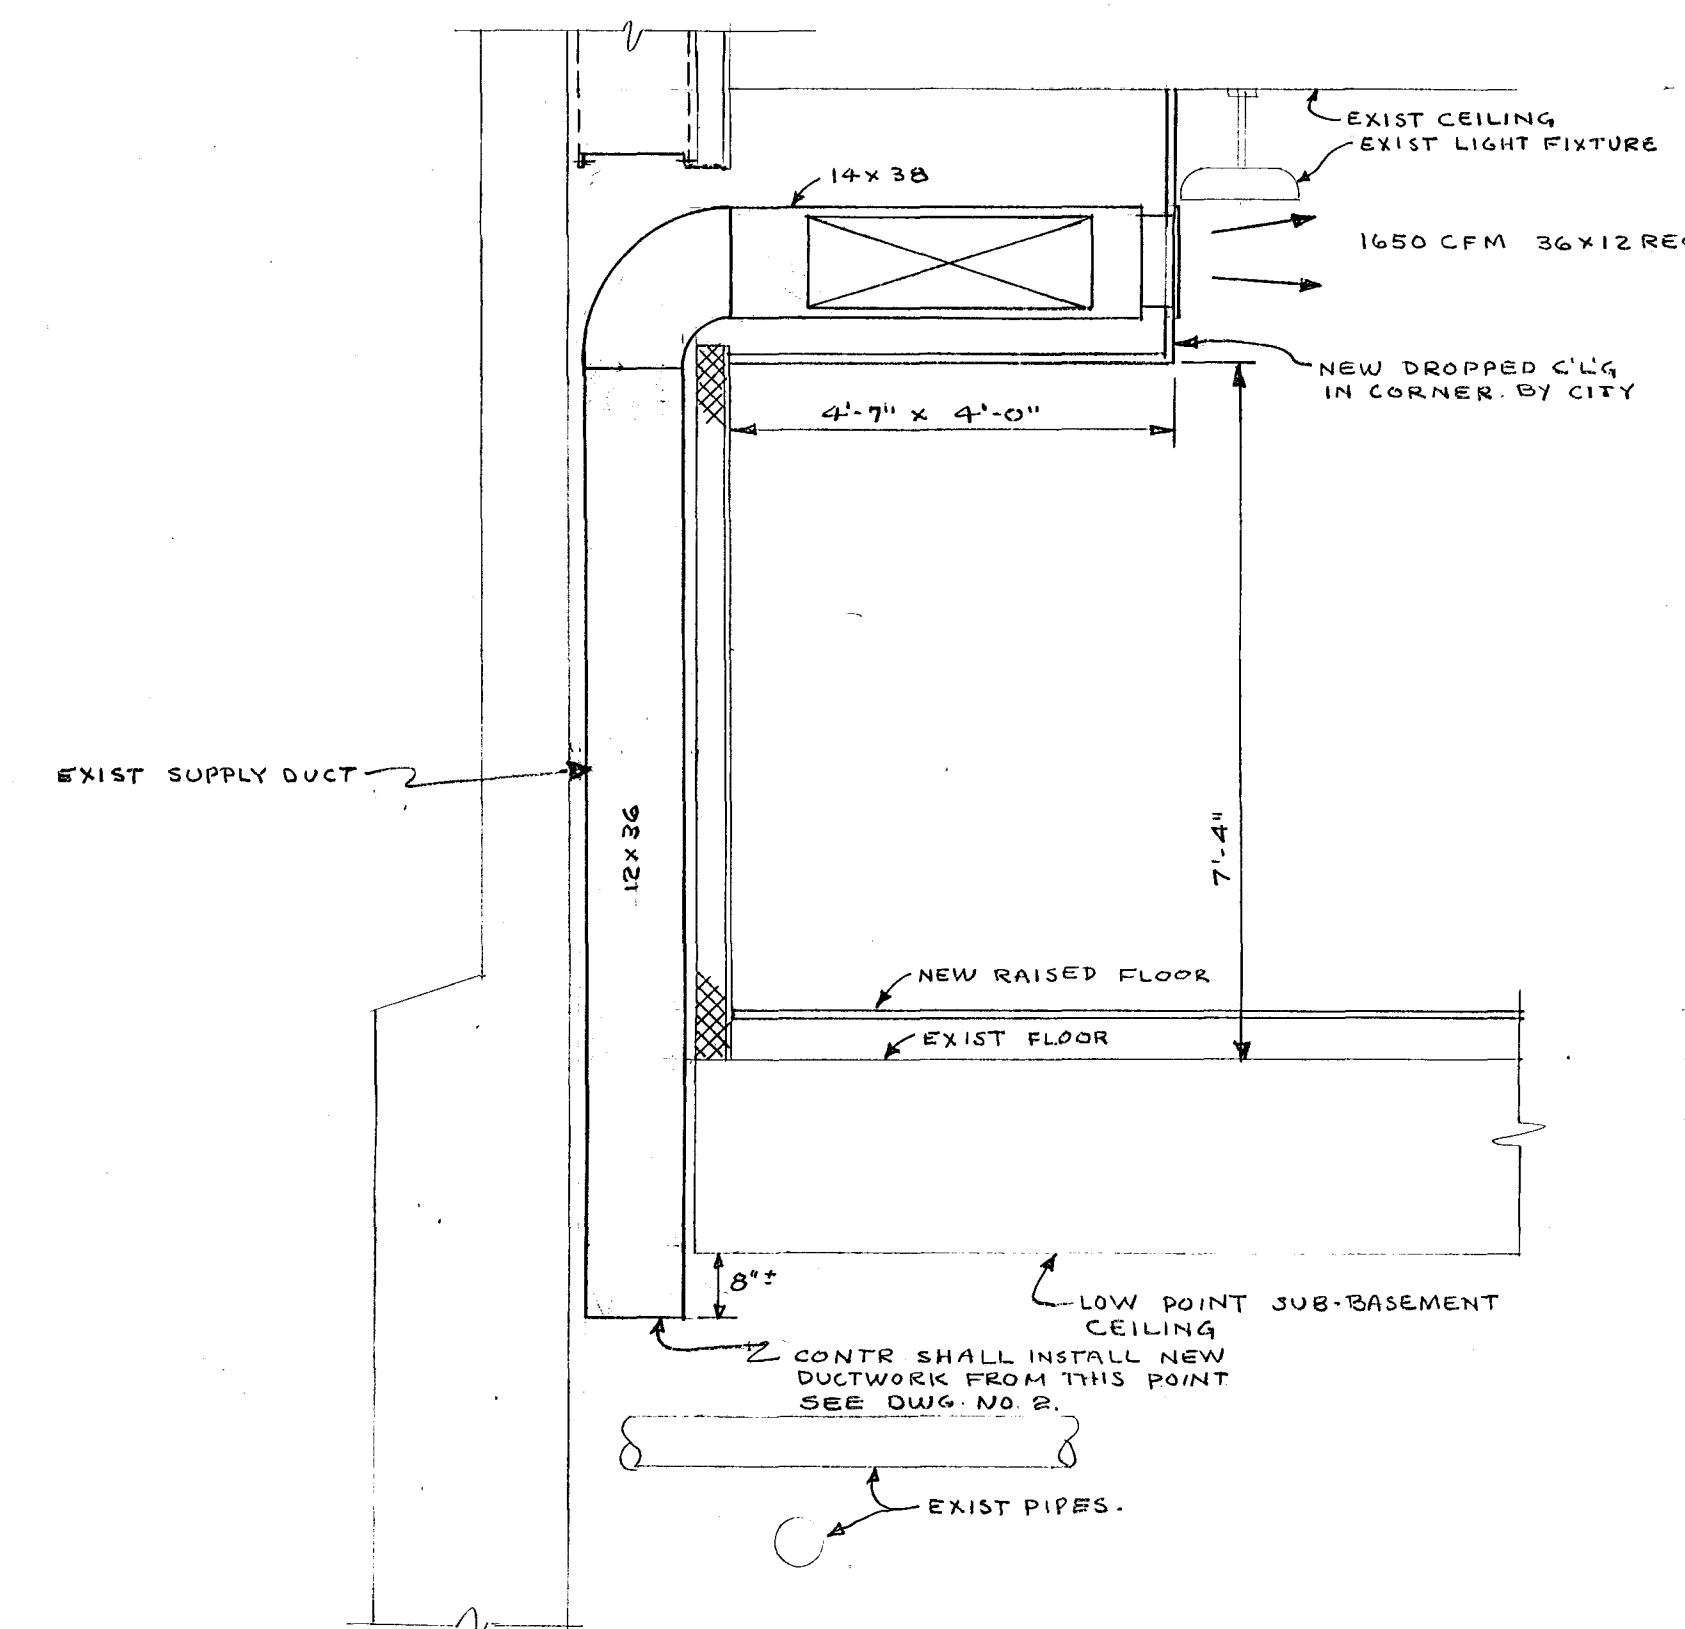


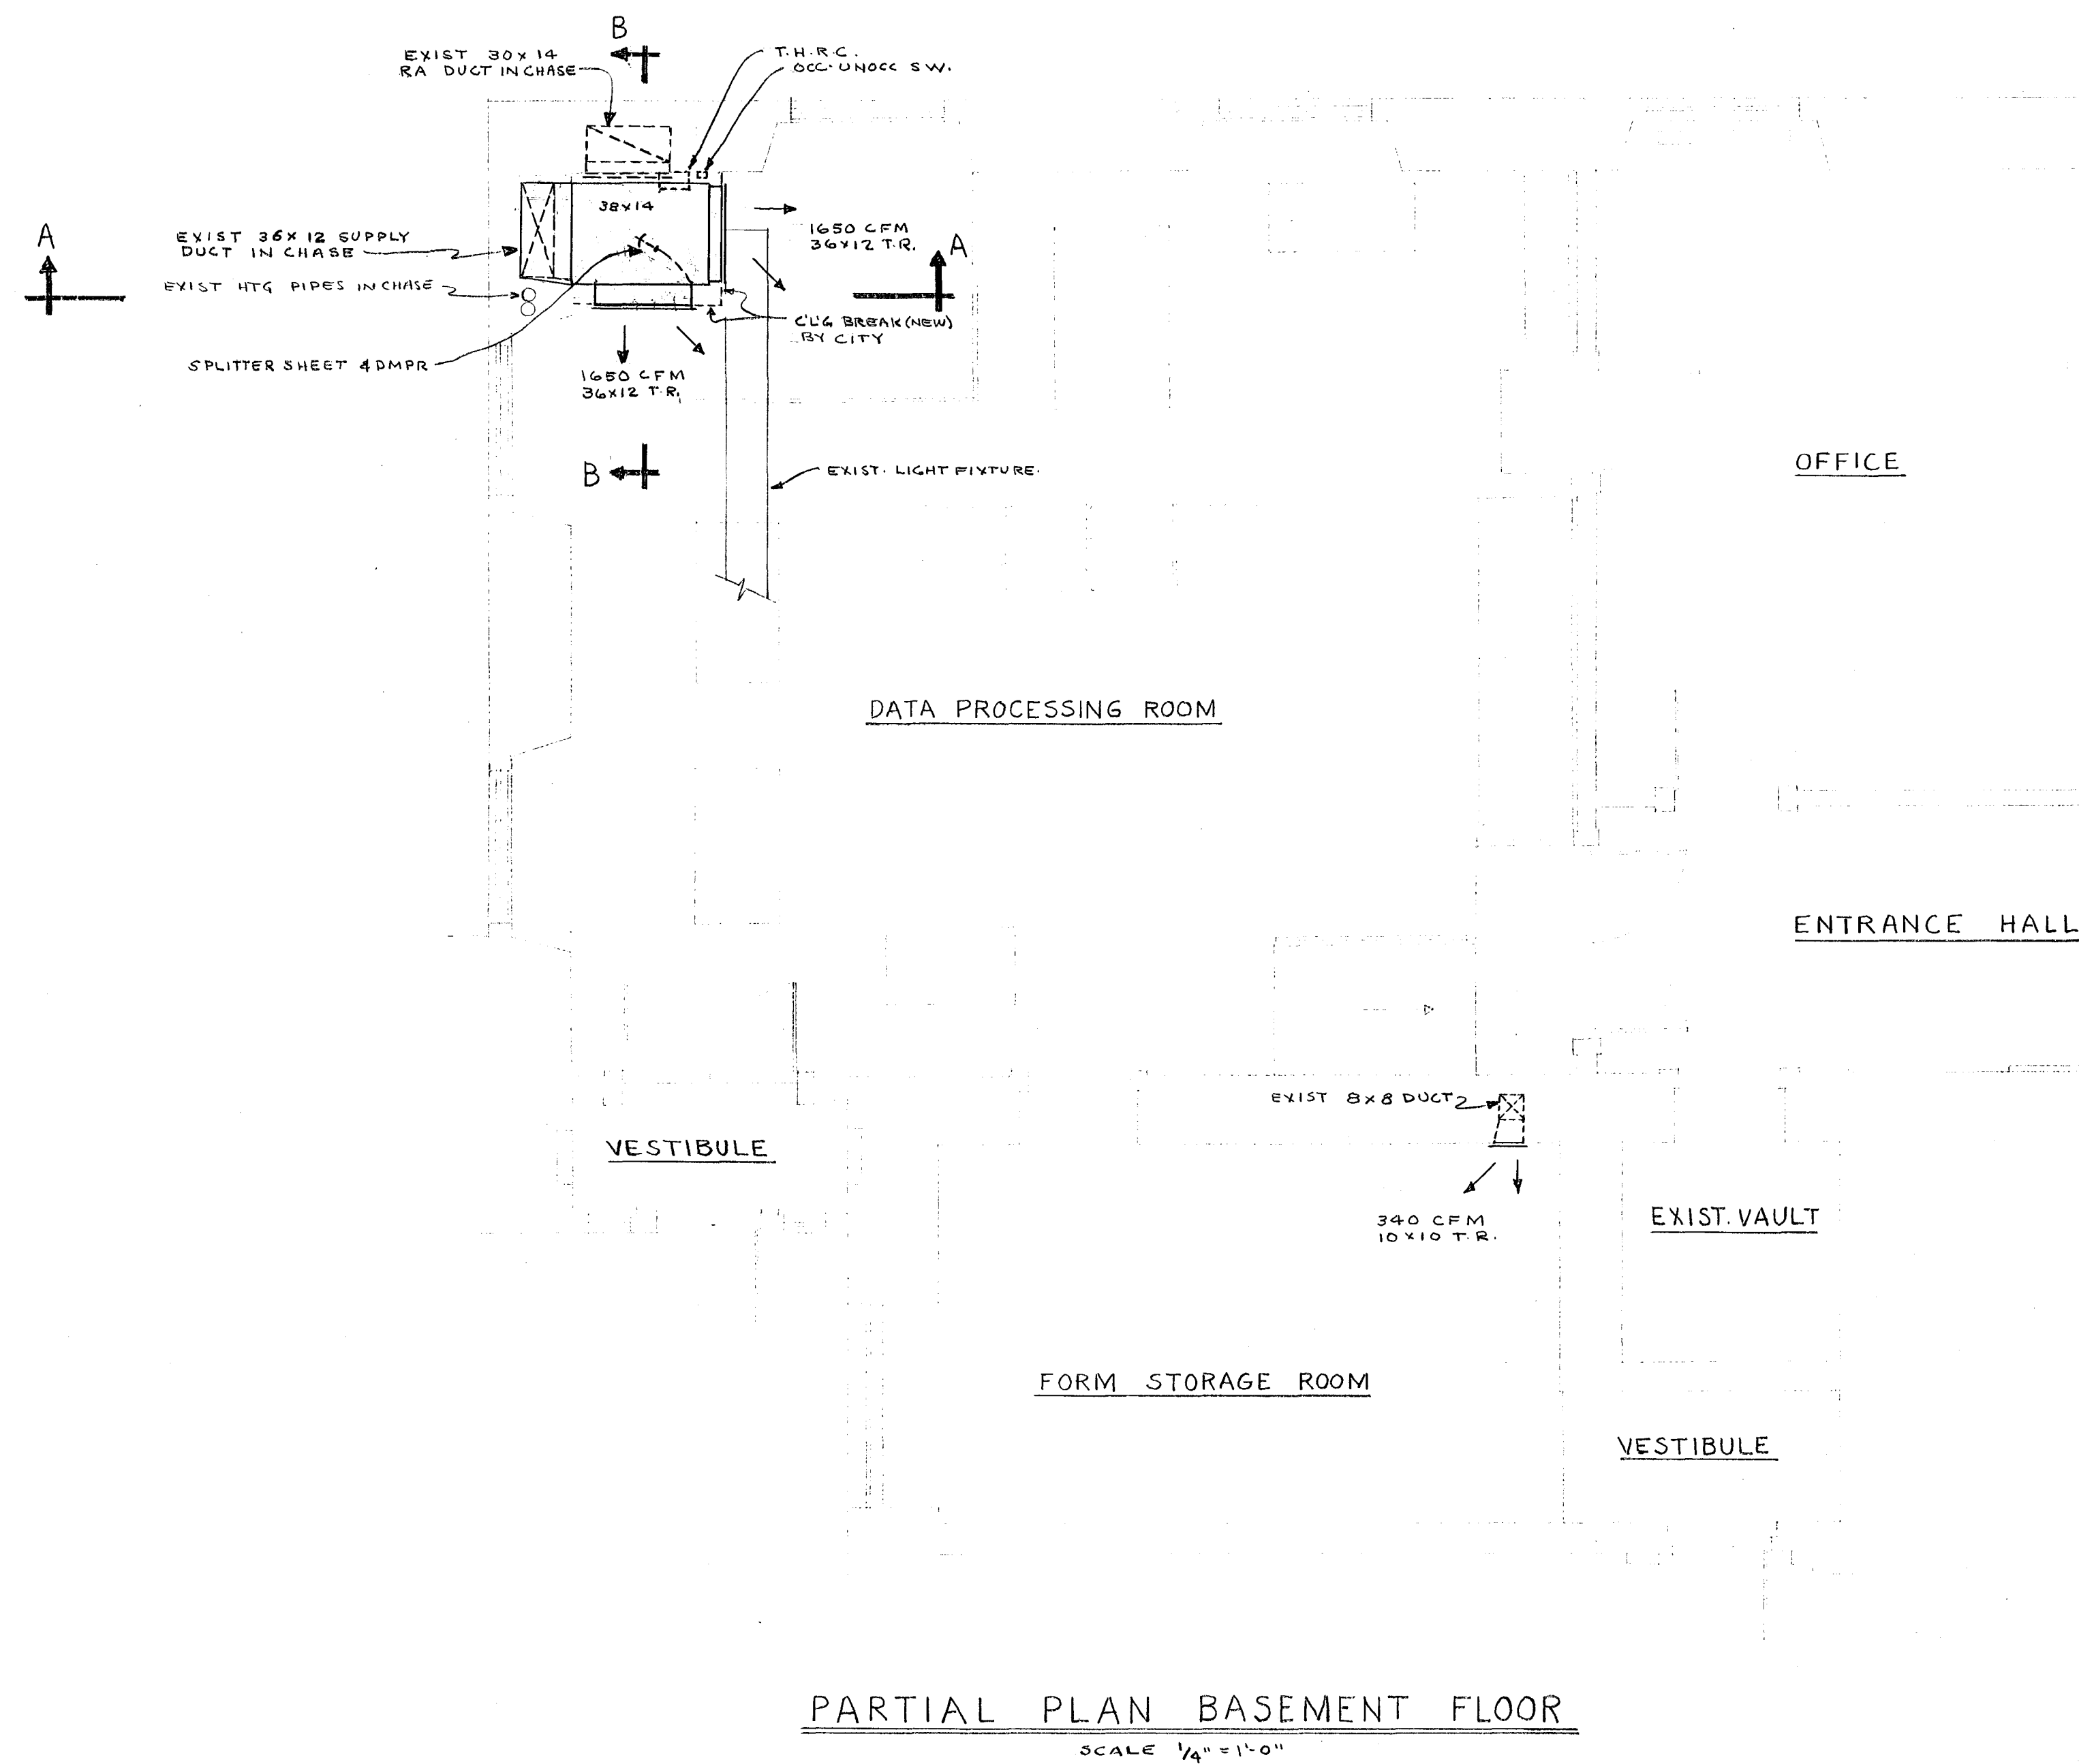

TEMPERATURE CONTROL DIAGRAMS
NO SCALE

VERIFY EXISTING
CONDITIONS AND
DIMENSIONS AT
BUILDING

CITY OF HARTFORD, CONNECTICUT DEPARTMENT OF ENGINEERING			DWG NO. 1
AIR CONDITIONING SYSTEM DATA PROCESSING ROOM			
MUNICIPAL BUILDING 350 MAIN STREET HARTFORD, CONN.			
SUBMITTED R.G.B. P.D.P.	RECOMMENDED R.G.B. P.D.P.	APPROVED R.G.B. P.D.P.	DAYBOOK NO. 09744-A
DESIGN	DRAWN	CHECKED	DATE NOV. 26, 1962