




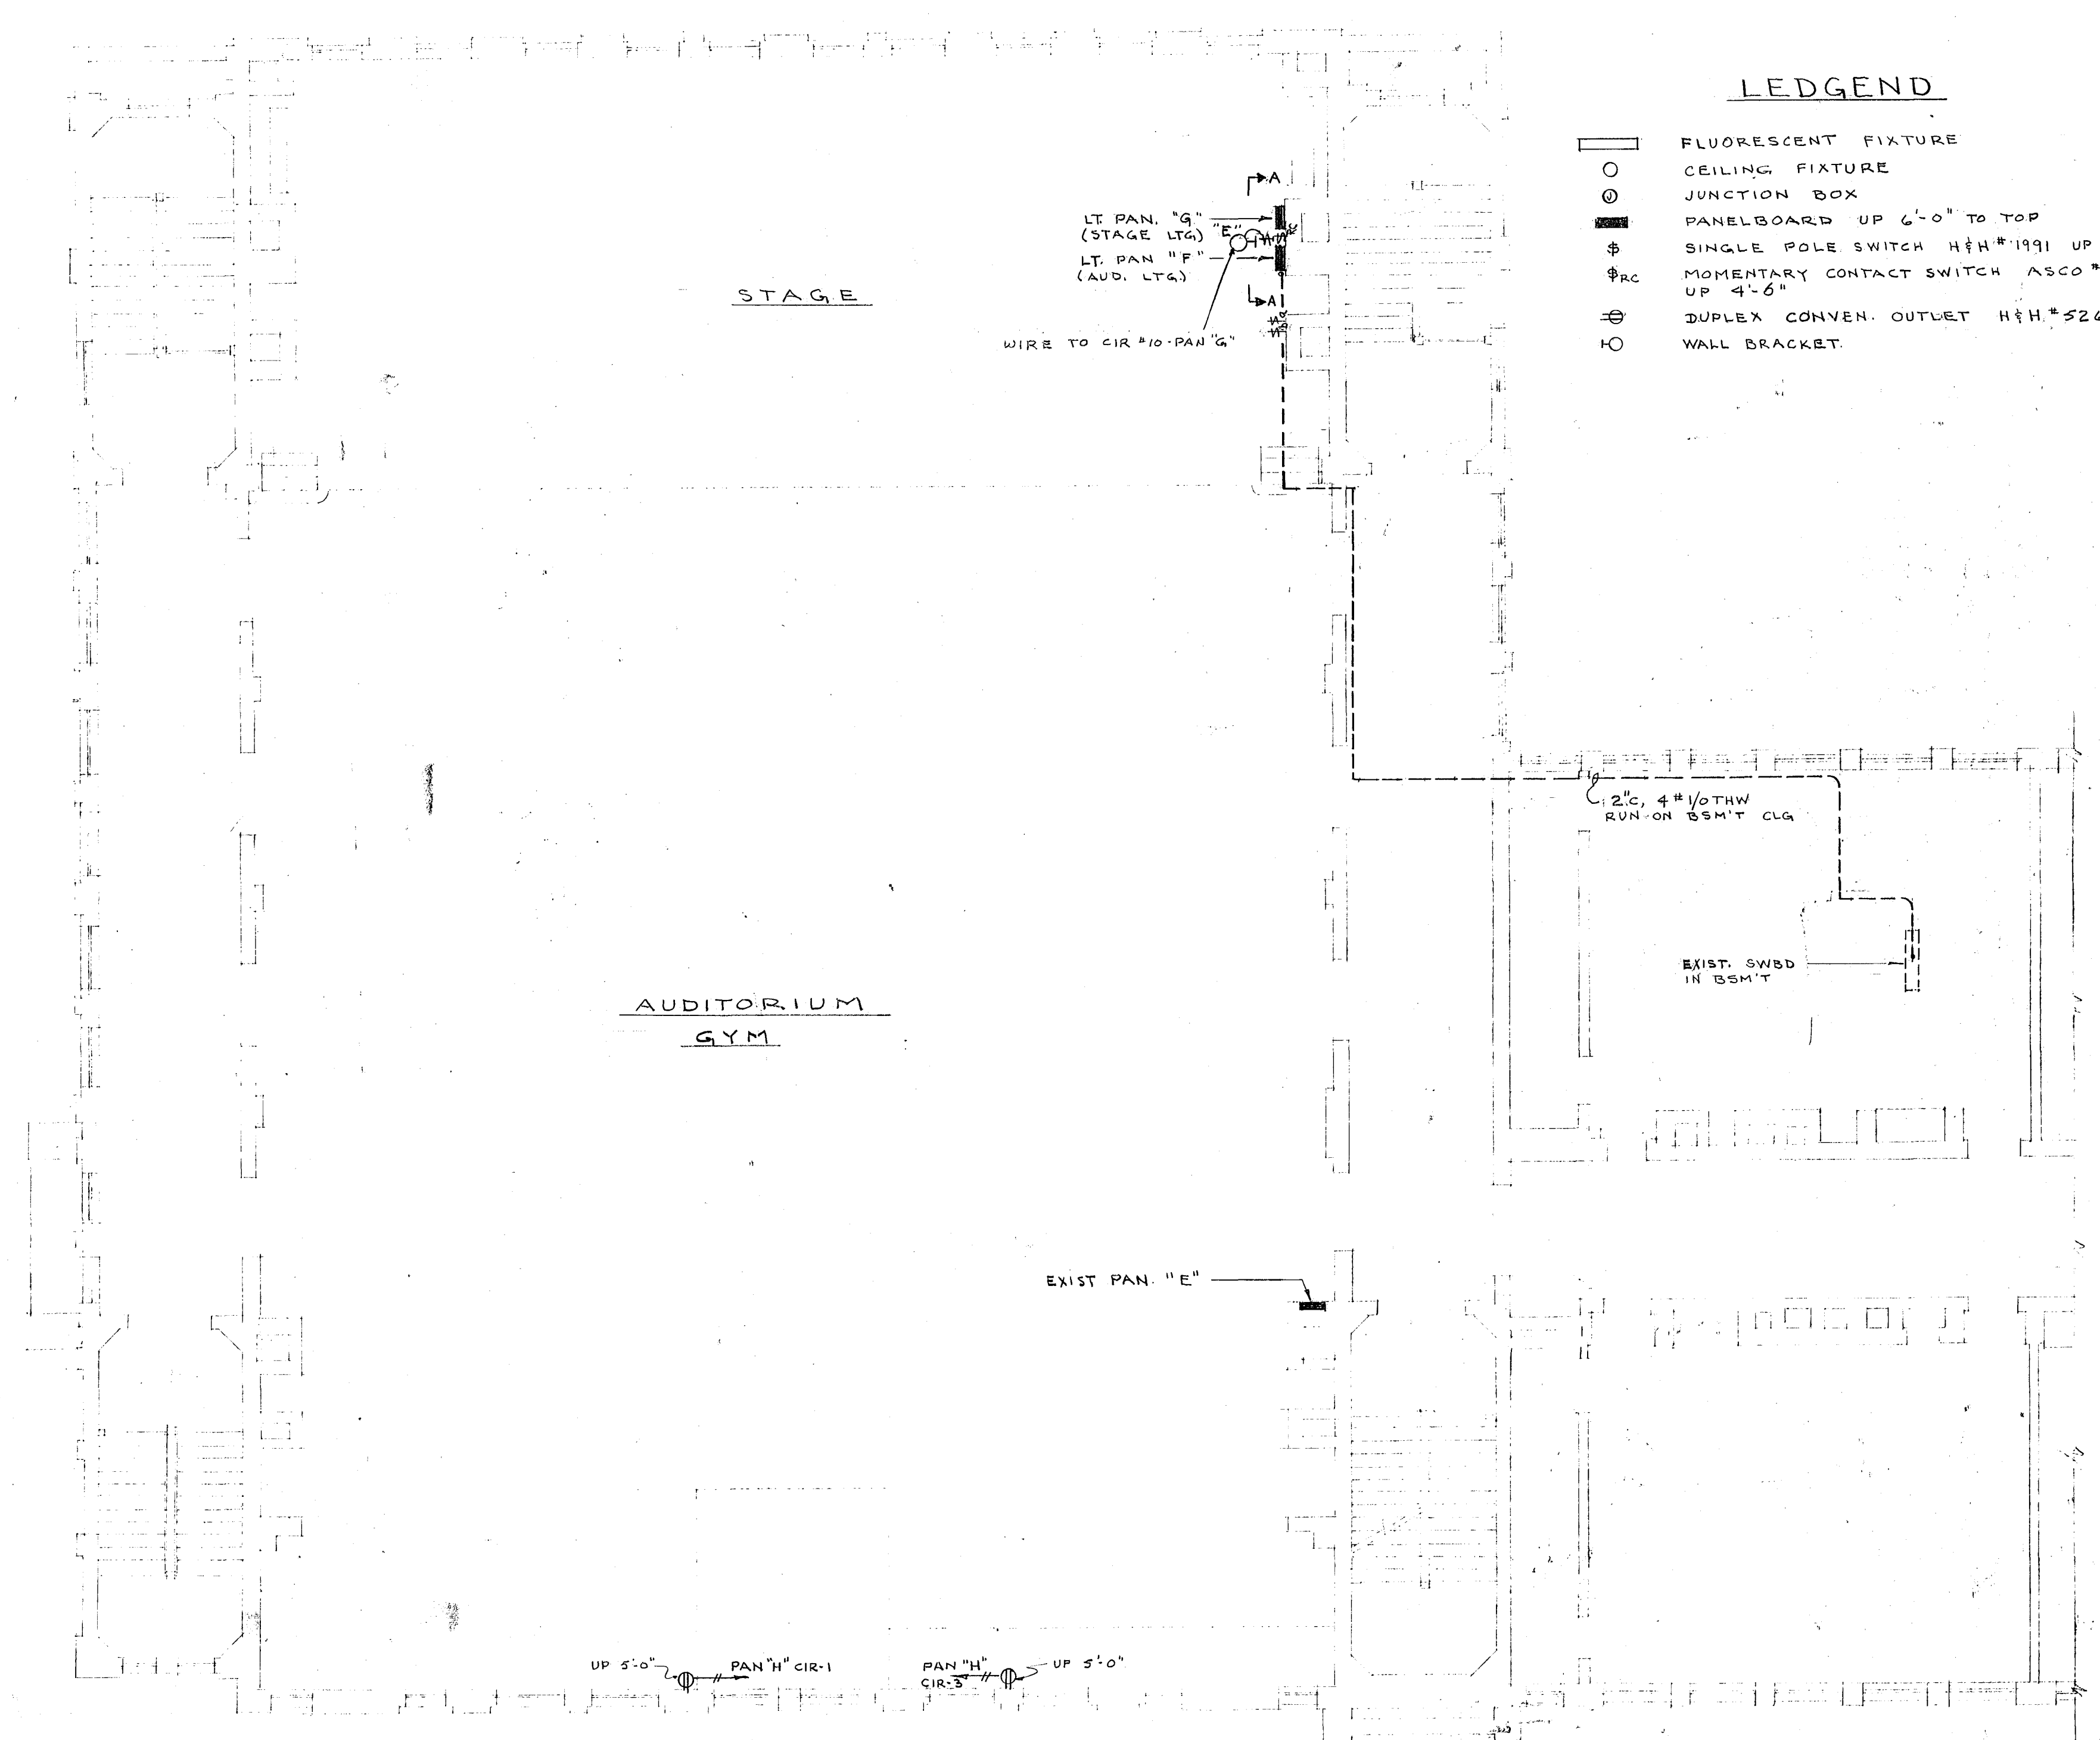


PARTIAL FIRST FLOOR PLAN SCALE 1/8" = 1' - 0"

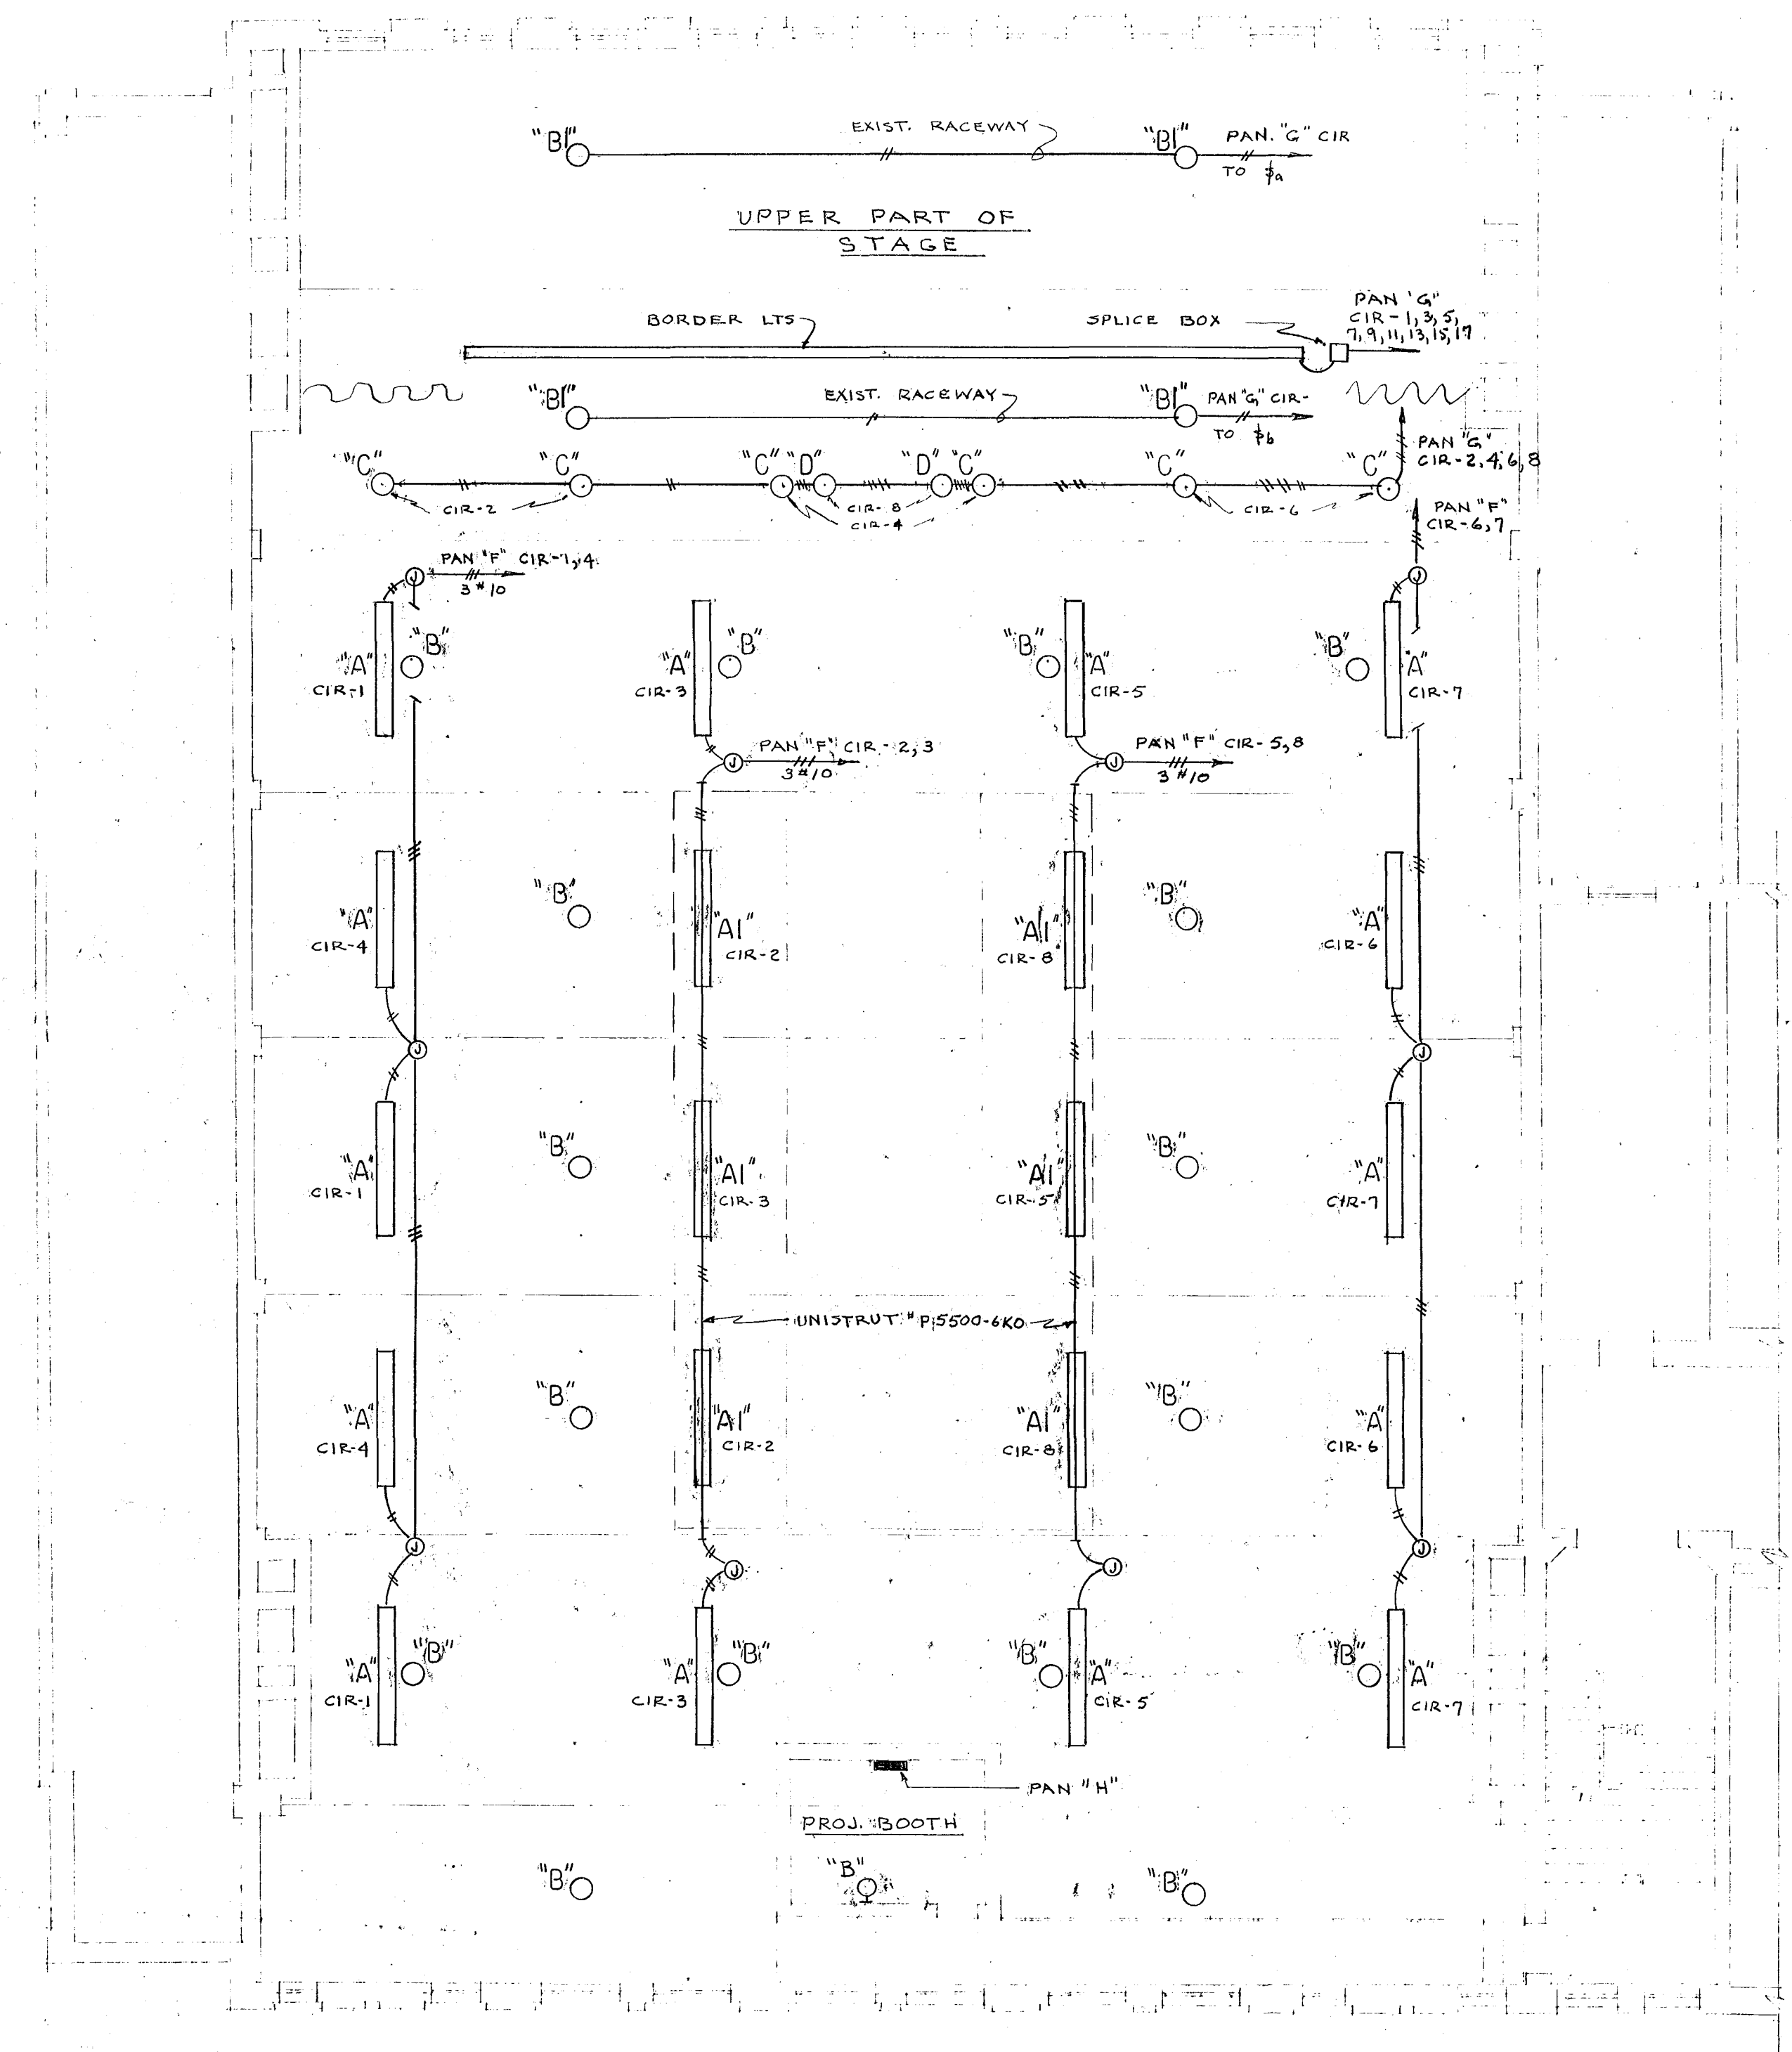


PARTIAL SECOND FLOOR PLAN SCALE 1/8" = 1' - 0"

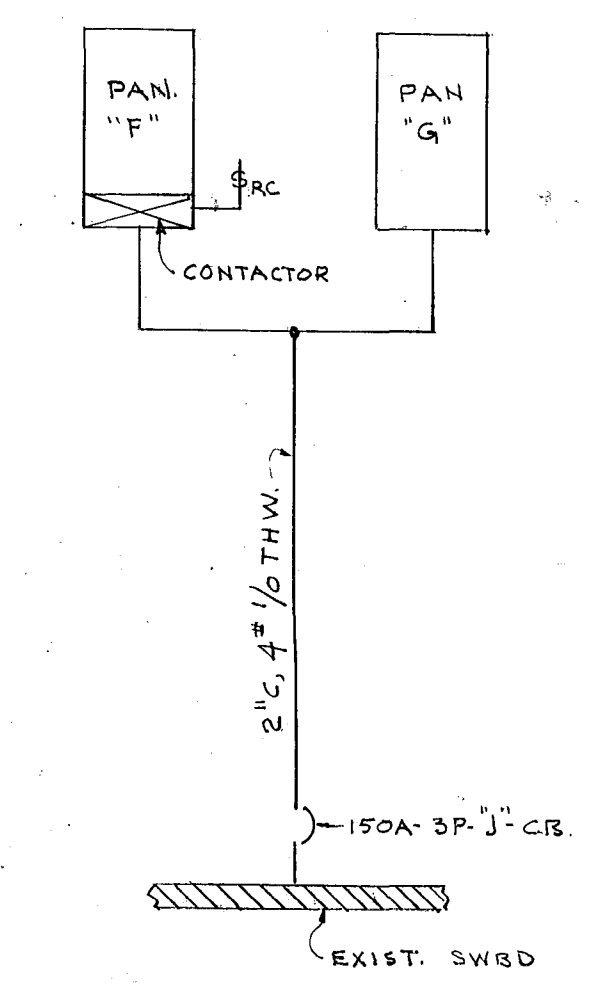


RISER DIAGRAM NO SCALE

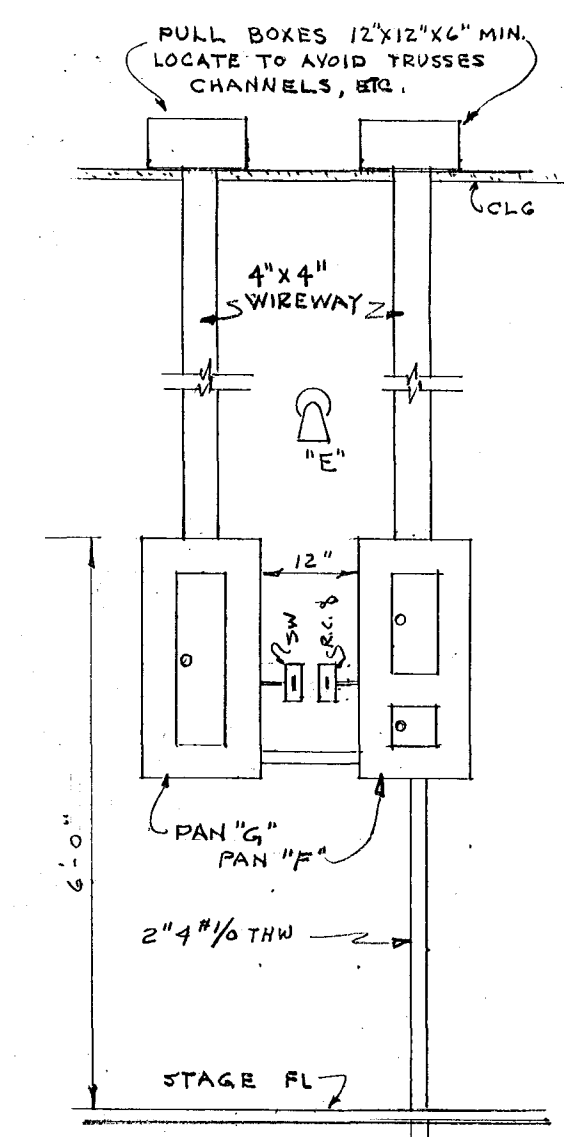

SECTION A-A NO SCALE

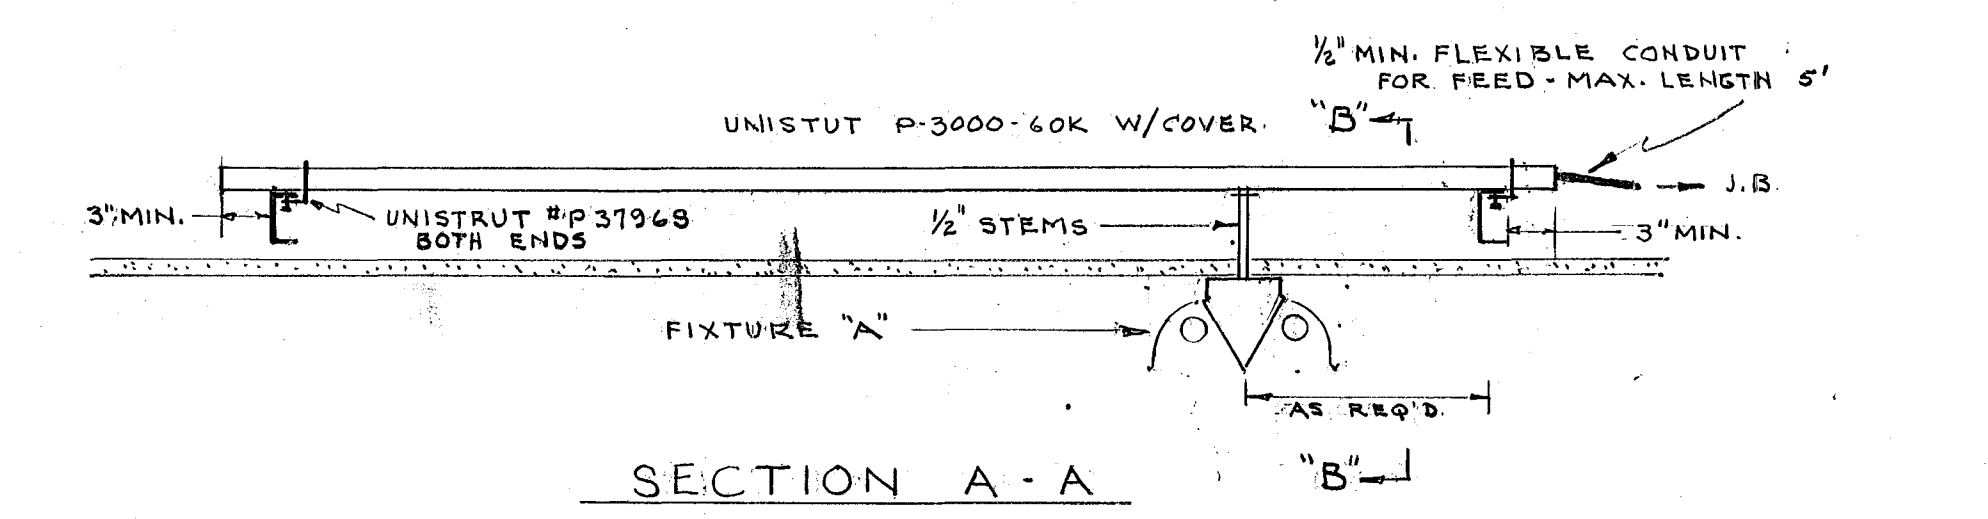


SECTION A-A

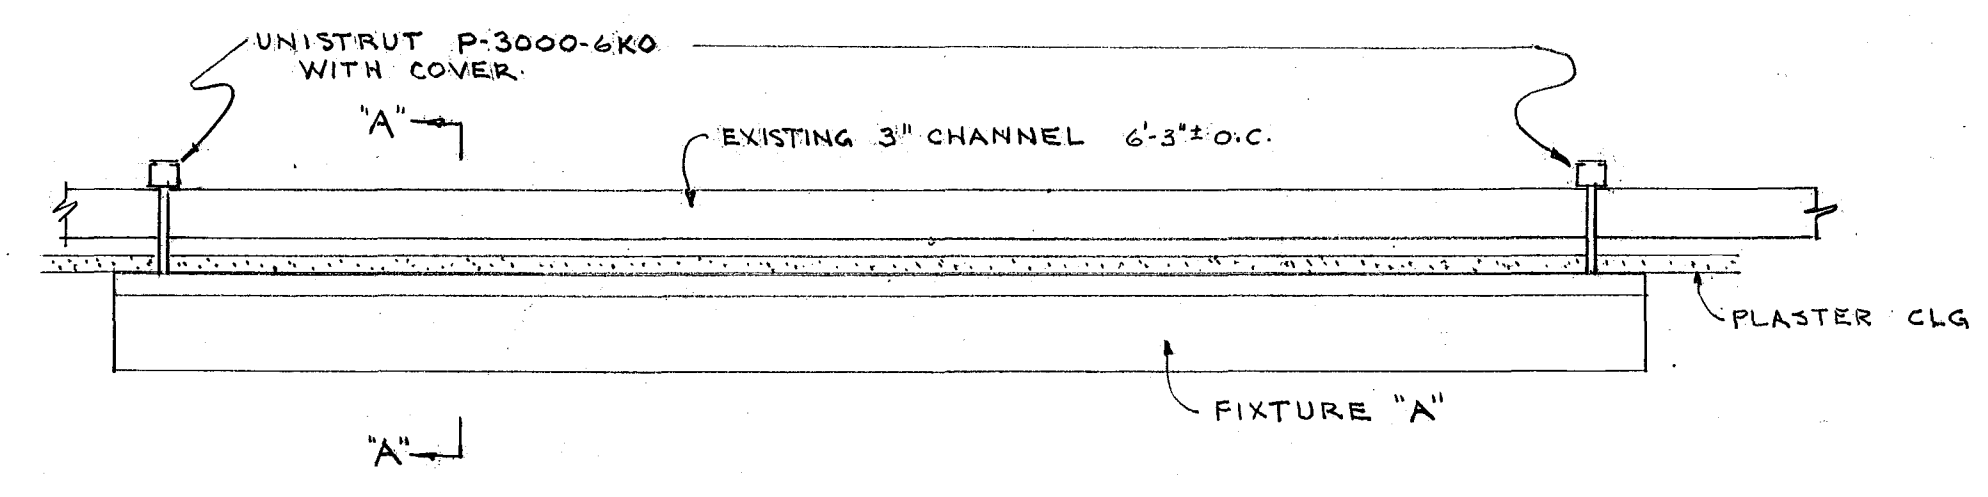


SECTION B-B


MOUNTING DETAIL - FIXTURE "A" 1" = 1'-0" (APPROX)

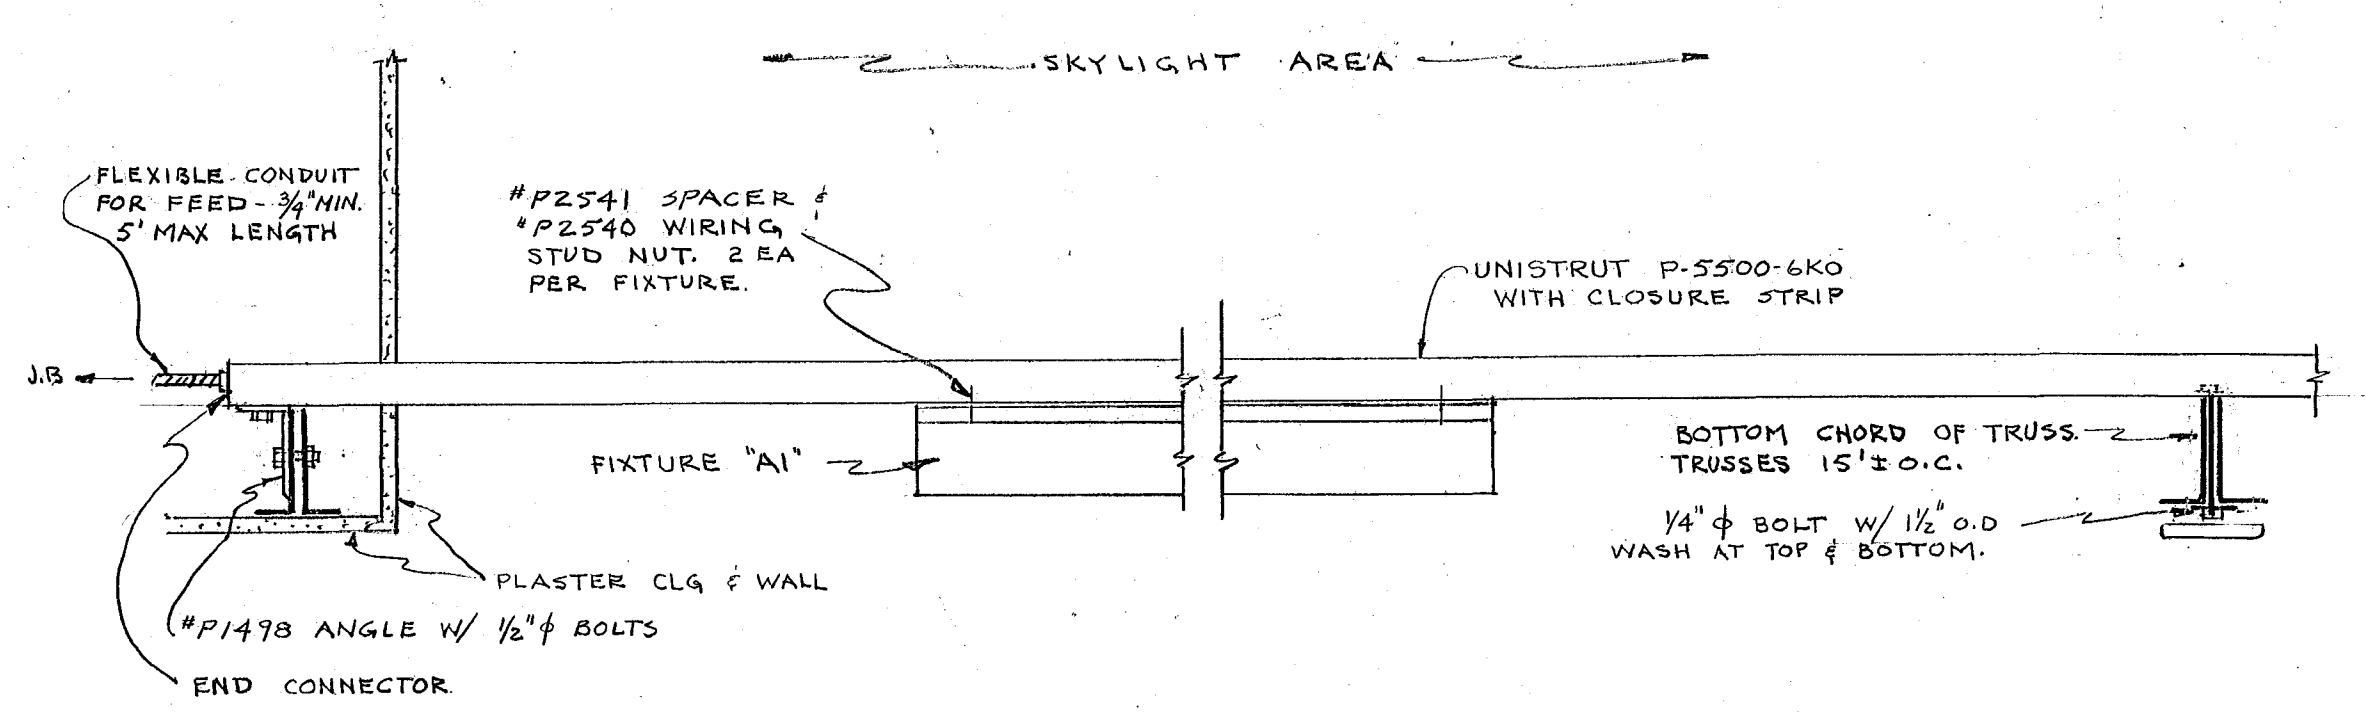

TYPICAL MOUNTING DETAIL FOR FIXTURE "A1" 1" = 1'-0" (APPROX)

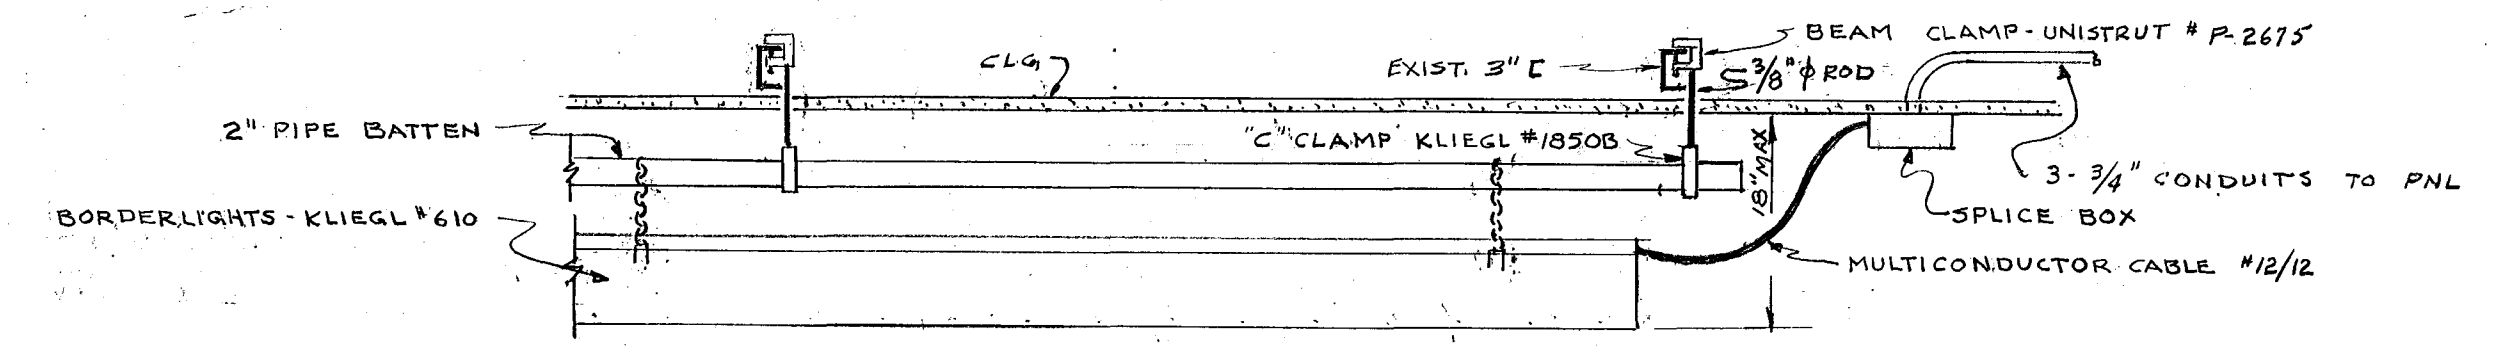

BORDERLIGHT MOUNTING DETAIL NO SCALE

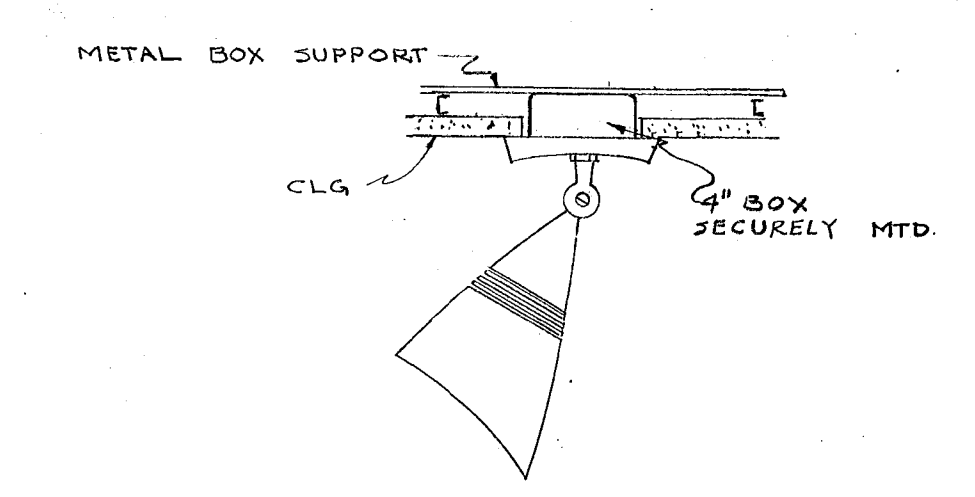

MOUNTING DETAIL FIXTURES "C" & "D" NO SCALE

CITY OF HARTFORD, CONNECTICUT DEPARTMENT OF ENGINEERING		
AUDITORIUM - GYM LIGHTING FOR CORNELIUS A. MOYLAN SCHOOL 235 HILLSIDE AVE. HARTFORD CONN.		
SUBMITTED <i>Raymond J. Barry</i> CITY ARCHITECT	RECOMMENDED <i>Raymond J. Barry</i> CITY ARCHITECT	APPROVED <i>Arthur H. Barrows</i> CITY ENGINEER
DESIGN <i>R.G.B.</i>	DRAWN <i>R.G.B.</i>	DAYBOOK NO. 09798
TRACED	CHECK	DATE NOV. 18, 1963