



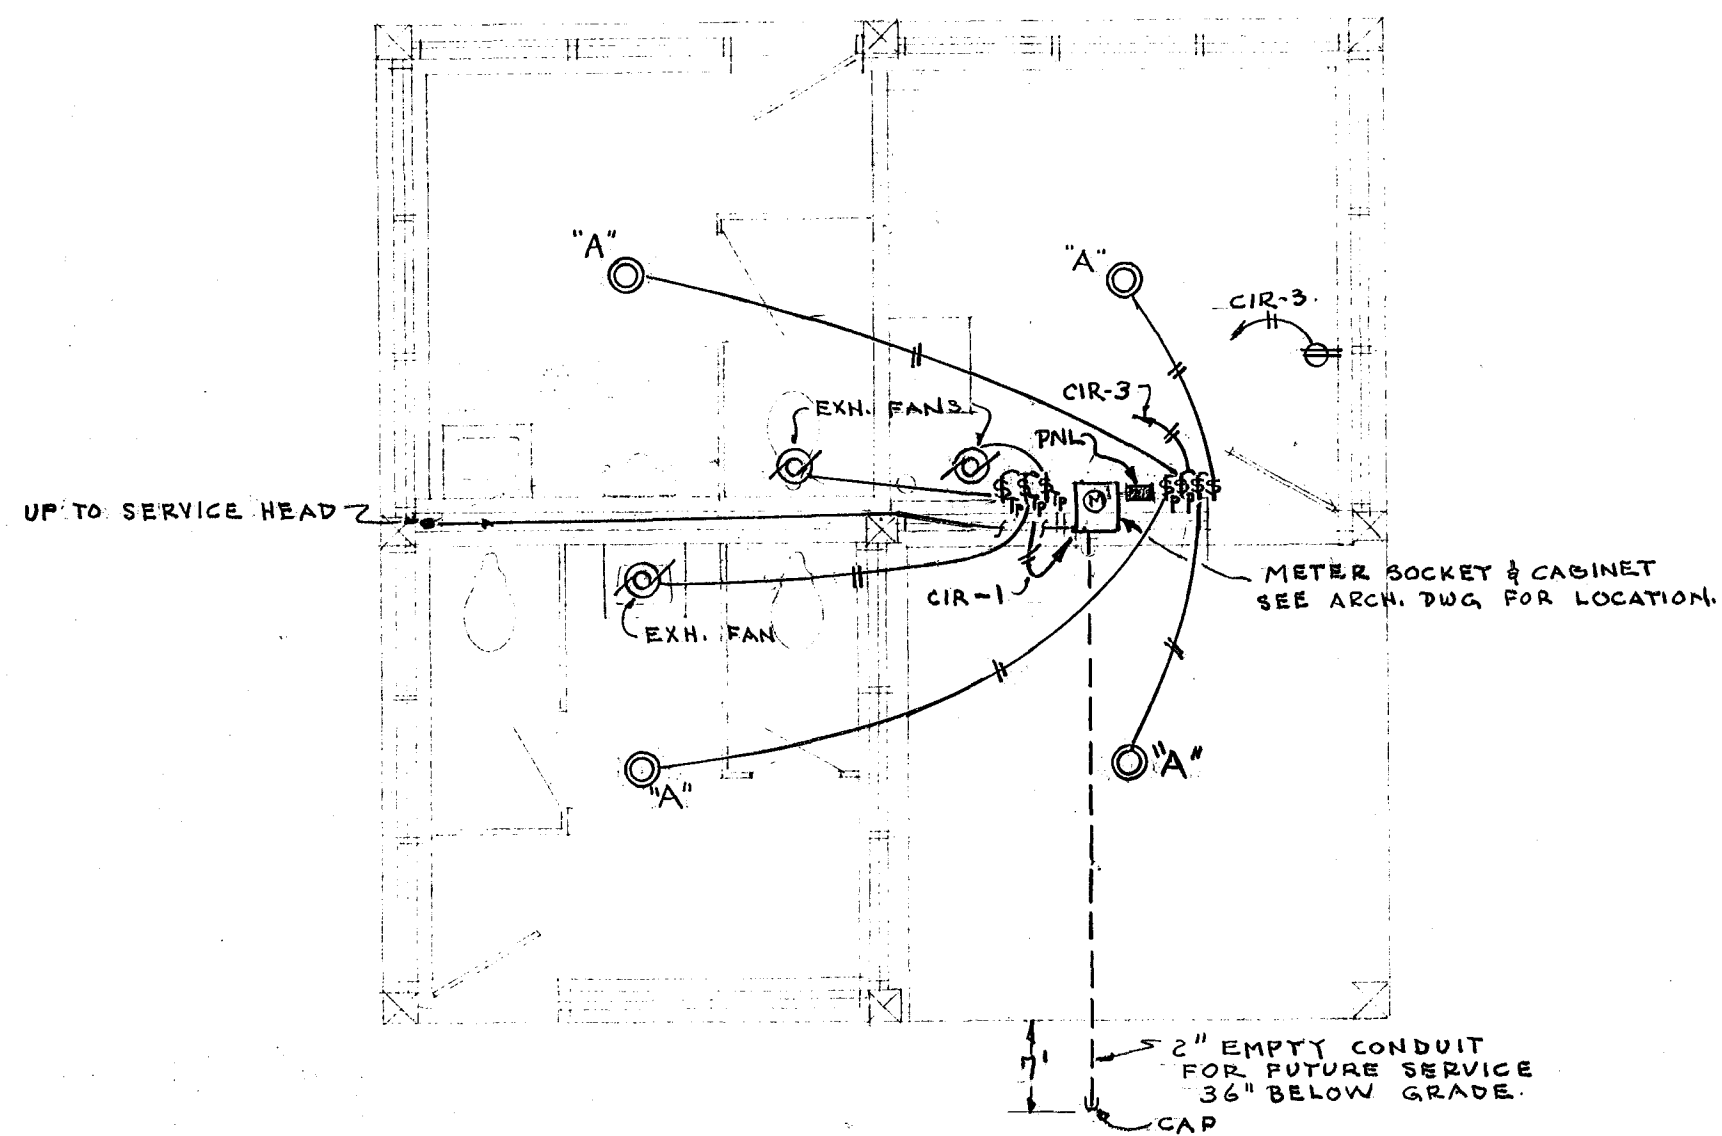

PLAN ELECTRICAL
SCALE 1/8" = 1'-0"

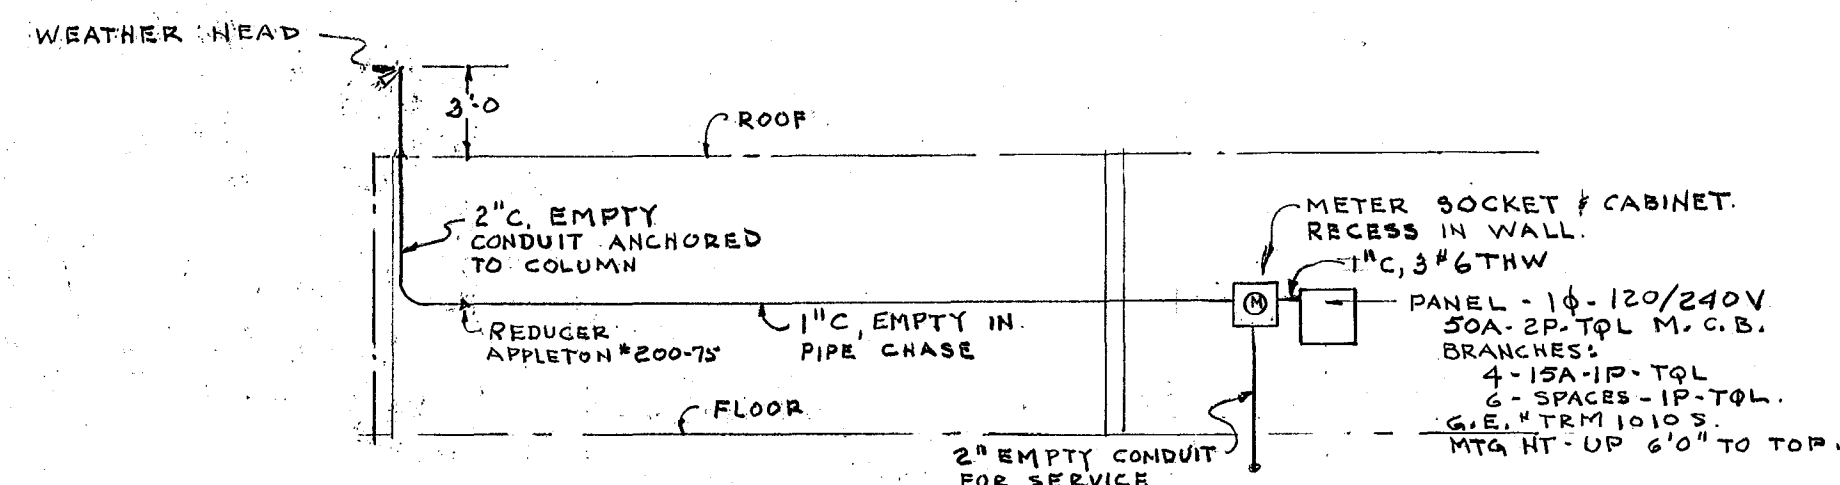


POWER RISER DIAGRAM
NO SCALE

SYMBOL LIST.


- ⊙ RECESSED LIGHTING FIXTURE
- ⊠ SINGLE POLE SW. H#H 1891 UP 4'-0"
- ⊡ " " & PILOT LT H#H 1891 & 1720 UP 4'-0"
- ⊙ MOTOR - FURNISHED & INSTALL BY OTHERS; WIRED BY E.C.
- ⊡ MOTOR STARTER & PILOT LT - FURN. BY OTHER; INSTALLED & WIRED BY EC. UP 4'-6"

FIXTURE SCHEDULE


"A" - PERFECTITE CAT # N386 CST-TP-MP-PW 150 W. IF LAMP

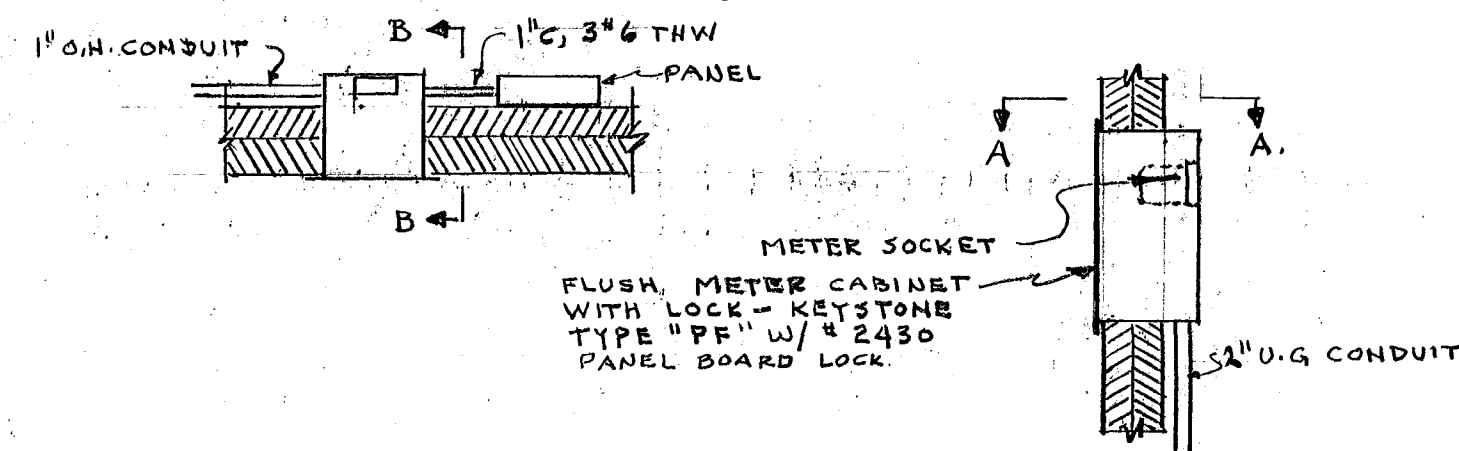

SECTION A-A
DETAIL OF METER CABINET

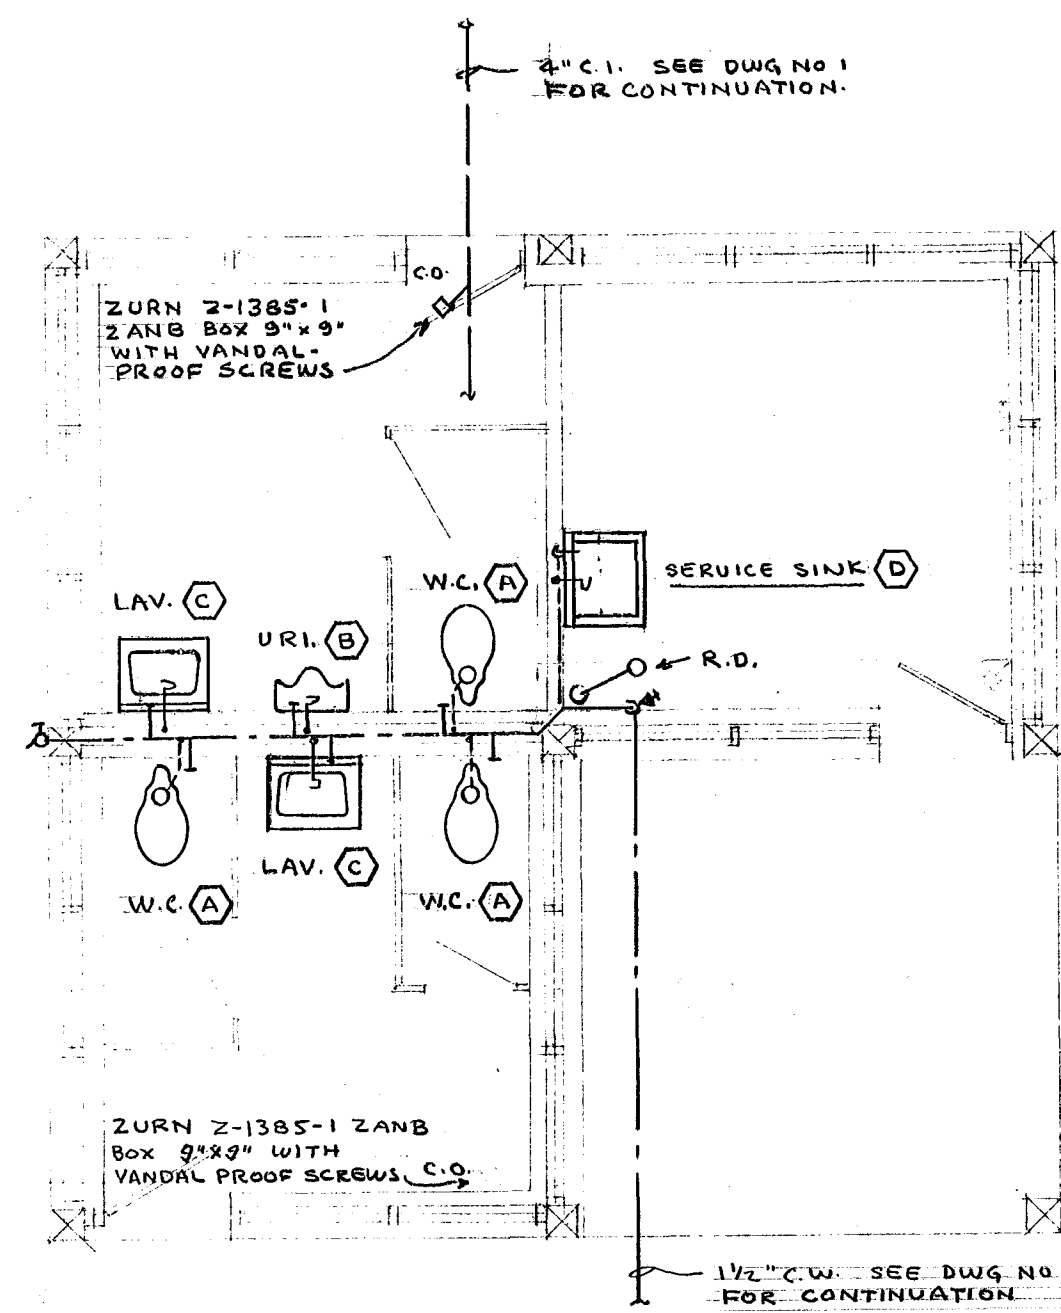


PLAN PLUMBING
SCALE 1/8" = 1'-0"

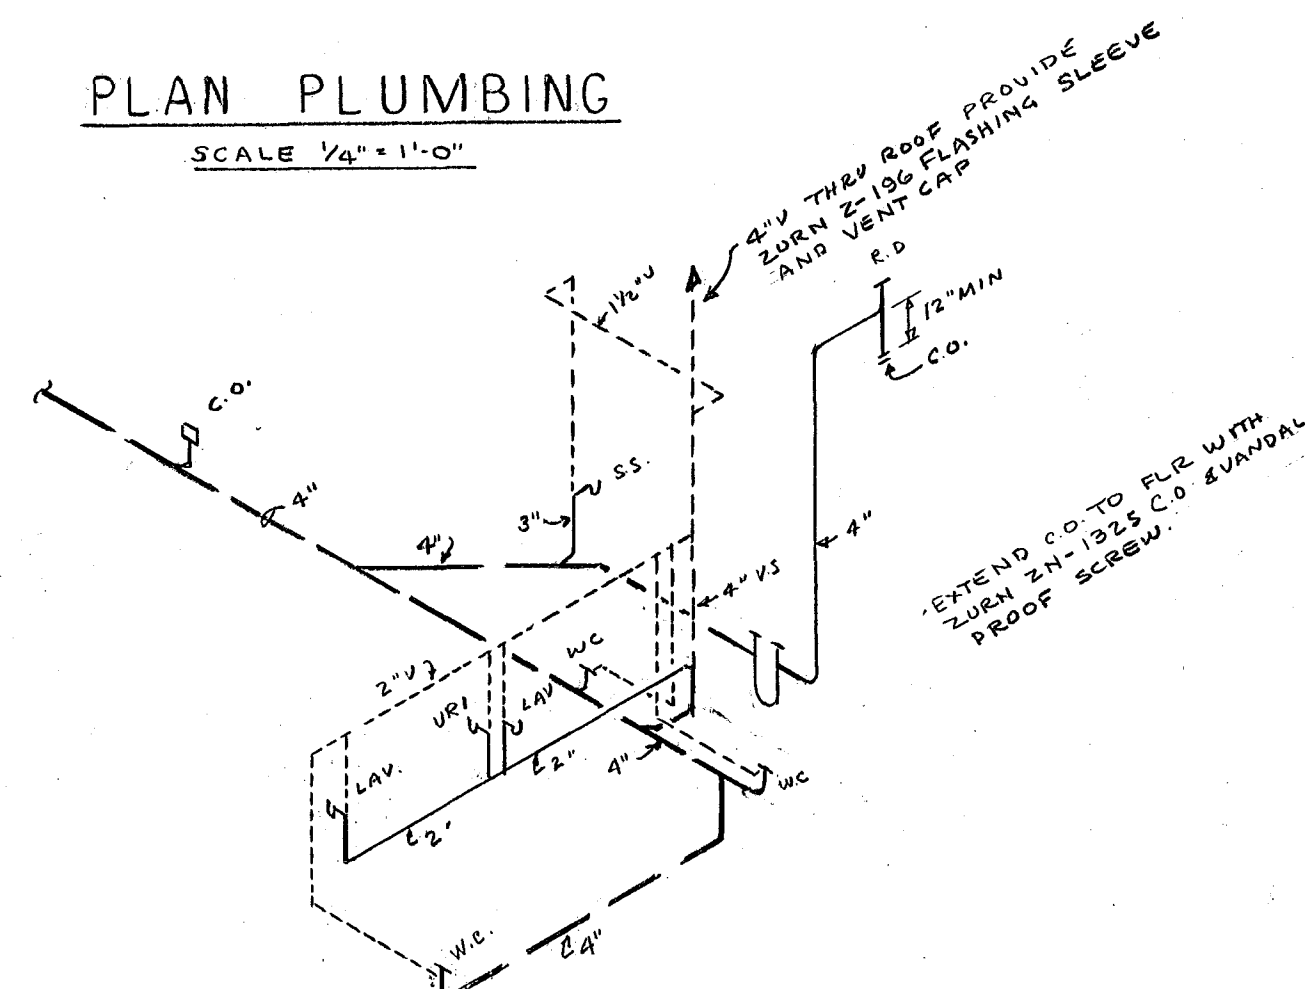


SCHEMATIC WASTE & VENT PIPING

PLUMBING FIXTURE SCHEDULE

SYM-BOL	FIXTURE	SOIL OR WASTE	VENT	C.W.	H.W.	SPECIFICATION
(A)	W.C.	4"	2"	1"	-	AM. STD. "NEW MADERA JUNIOR" F-7232 WITH NO 110-PV SLOAN ROYAL VALVE, OLSONITE W/ BLACK OPEN FRONT SEAT.
(B)	URINAL	2"	1 1/2"	3/4"	-	AM. STD. "WASHBROOK" F-6500-1 WITH NO 186-II SLOAN ROYAL VALVE. MOUNTING HEIGHT - 15"
(C)	LAVATORY	1 1/2"	1 1/2"	1/2"	-	AM. STD. "HEXAGON" P-3869-40, 22" VIO. C.I.A.R. ENAMEL WITH NISSA2 DRAIN, R2215 FAUCET, R-2607 SUPPLY & STOP, R-7013-44 1 1/4" x 1 1/2" P TRAP. MOUNTING HEIGHT - 27"
(D)	SERVICE SINK	3"	1 1/4"	1/2"	-	AM. STD. "ARGO" P-7706 22" x 18" C.I.A.R. ENAMEL WITH STAINLESS STEEL RIM GUARD, P-7798 TRAP STD. R-5084-T FAUCET.
	HOSE BIBB	-	-	1/2"	-	ANACONDA 1663, ANGLE TYPE, LOOSE SET KEY, HOSE THREAD
	ROOF DRAIN	4"	-	-	-	ZURN Z-100-RC WITH CLAMP MODIFIED FOR 5/8" PLYWOOD ROOF DECK

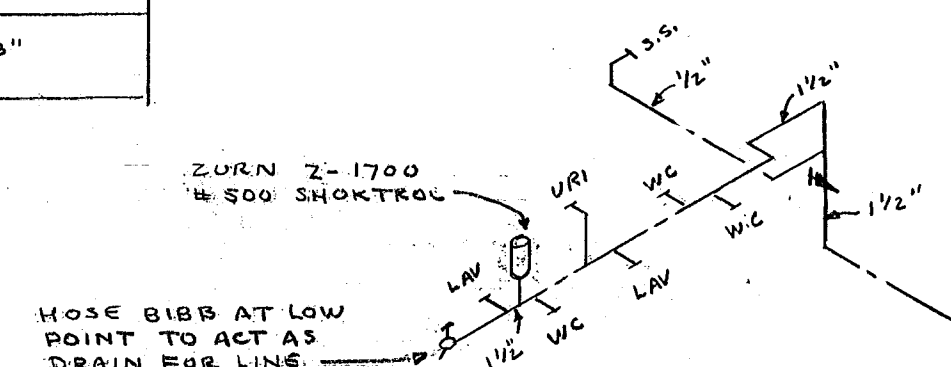


SCHEMATIC WATER PIPING
NO SCALE

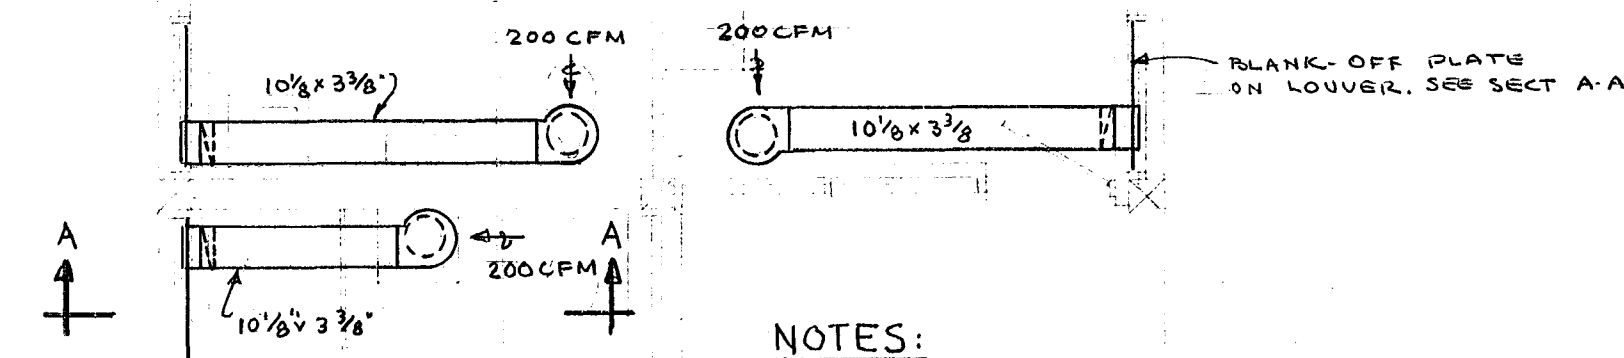

- NOTES:
- FANS - BROAN NO 400 CEILING FAN 10" x 8" 85W 120V 1/2 60C MOTOR. STAINLESS STEEL GRILLE 200CFM
 - PROVIDE 4" H STARTERS FOR EACH FAN # RL-11-PL-G
 - WIRING BY ELEC. CONTE.

PLAN VENTILATING
SCALE 1/8" = 1'-0"

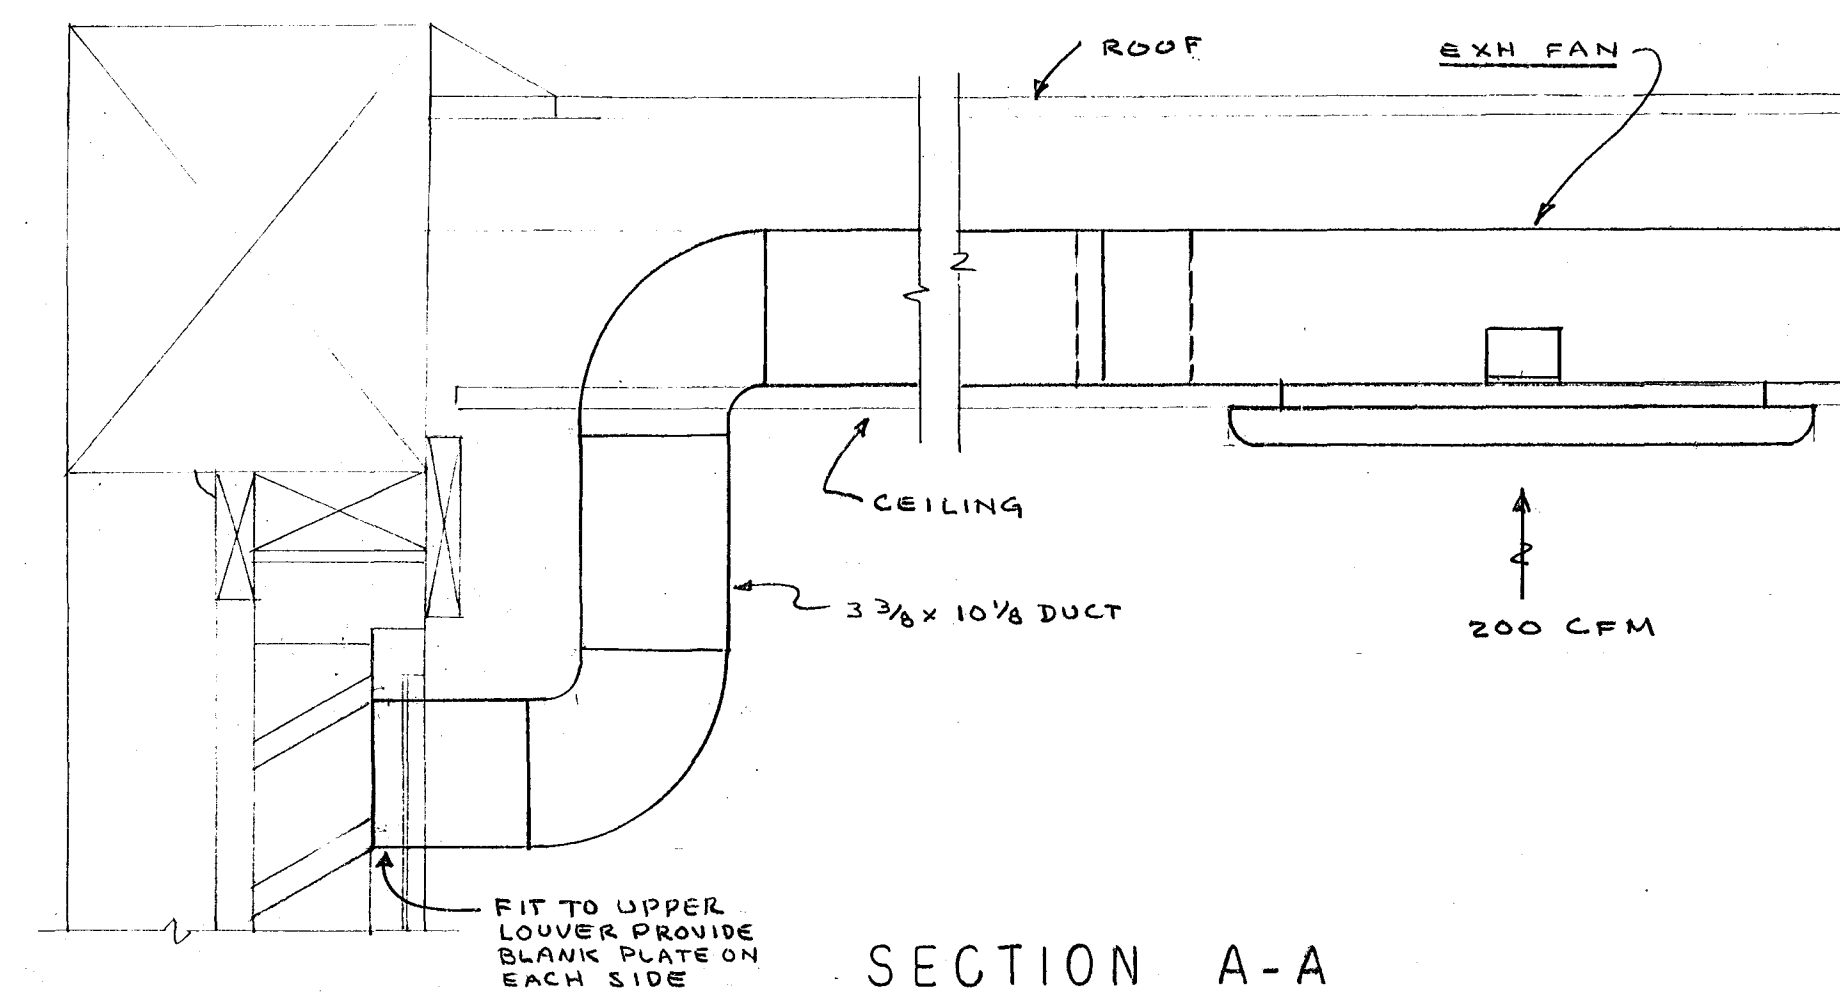

SECTION A-A
SCALE 3/8" = 1'-0"

CITY OF HARTFORD, CONNECTICUT
DEPARTMENT OF ENGINEERING

TYPICAL FIELD HOUSE
MECHANICAL & ELECTRICAL
SOUTH END PLAYGROUND
HARTFORD, CONN.

SUBMITTED: R.B. PDP
RECOMMENDED: Daniel J. Taylor
APPROVED: Peter H. Banon
CITY ARCHITECT CITY ENGINEER

DESIGN: R.B. PDP
DRAWN: R.B. PDP
DAYBOOK NO. 09935-E

TRACED: R.B. PDP
CHECK: R.B. PDP
DATE: APRIL 15, 1966

DWG. NO. 5