


PLUMBING FIXTURE SCHEDULE									
SYM. NO.	FIXTURE	SOIL OR WASTE	VENT	C.W.	H.W.	SPECIFICATION			
(A)	W.C.	4	2	1	-	AM. STD. "GLENCO" F-2498 BOWL, #112 VV SLOAN ROYAL VALVE, OLSONITE #10 BLACK SEAT, ZURN INTEGRAL CARRIAGE & FITTINGS WITH FOOT SUPPORT OF SIZES & TYPES AS SHOWN ON PLANS, WITH VANDAL PROOF NUTS			
(B)	URINAL	2	1/2	3/4	-	AM. STD. "WASHBROOK" F-4501-1 WITH #18C-11 SLOAN ROYAL VALVE			
(C)	LAVATORY	1 1/2	1 1/2	1/2	1/2	AM. STD. "REGALYN" P-4867 20" X 18" C.I. ACID RESISTING ENAMEL WITH N-2542 POP-UP DRAIN, R-2215 H&C FAUCETS R-2407 3/8" SUPPLY & STOP WITH LOOSE SET KEY, R-7000-47 1 1/4" X 1 1/2" P. TRAP			
(D)	DRINKING FOUNTAIN	1 1/2	1 1/2	1/2	-	HALSEY-TAYLOR WALL MTD MODEL NO WM-16A ELECTRIC AIR COOLED WITH STAINLESS STL TOP & BONDORIZED STL SIDES, CAPACITY 16 GPH 80° TO 50° F @ 30° F AMBIENT TEMP MOUNT 40" ABOVE FLR, MOTOR 1/4 HP 115V-1P-60C, 1 1/2" X 1 1/2" ADJ. P. TRAP & STOP			
(E)	MOP SERVICE BASIN	8	1 1/2	3/4	3/4	FIAT MODEL SB 24" X 24" X 6", PRECAST TERRAZO WITH ANODIZED ALUMINUM THRESHOLD GUARDS WITH VINYL INSERT FOR EXPANDED SIDES, 3" C.I. P. TRAP, AM. STD. R-5084-T FAUCETS & INTEGRAL STOPS			
(F)	SHOWER	-	-	-	-	BRADLEY WALL MTD LMD SHOWER WITH 2 HEADS, SOAP TRAYS, AUTOMATIC METERING VALVE (400 GALLONS MIN), STAINLESS STEEL COVER, MTG HEIGHT 6'0" ONE BACK & ONE OVERHEAD SUPPLY			
(G)	SHOWER	-	-	-	-	BRADLEY-WADESTY MODULE NO 102-4 WITH ENAMELED PANELS OF COLOR TO BE SPECIFIED BY ARCH, CURTAINS, SEATS & STAINLESS STEEL TRIM, SHOWER TYPE LMD AS SPECIFIED IN (F) ABOVE			
FD-1	FLOOR DRAIN	8	1 1/2	-	-	ZURN ZN-415 DCC BODY 6" X 8" N.B. STRAINER TYPE B			
(H)	WATER CONTROLLER	-	-	3/4	3/4	LAWLER TYPE B&M THERMOSTATIC WATER CONTROLLER NO 2 30 GPM AT 45 PSI RANGE 50° TO 115° F COMPLETE WITH CHECK VALVE, REMOVABLE STRAINER, HOSE KEY UNION, ADJUST VALVE TEMP ADJ LOCK PIN, 40° TO 140° F, 3/8" THERM WITH SEPARABLE SOCKET			
(I)	HOSE BIB	-	-	3/4	-	ANGLE TYPE, LOCK SHIELD, LOOSE SET KEY - HOSG THREAD			


- NOTES
- EXISTING - TO REMAIN
 - EXISTING - TO BE REMOVED
 - EXISTING FLOOR DRAIN TO BE REMOVED AND REPLACED WITH FD-1 SET TO NEW FLOOR FINISH.
 - EXISTING CLEANOUT ACCESS BOX TO BE REMOVED AND REPLACED WITH NEW ZURN NO. Z-13BS-1 ZNAB BOX SET TO NEW FLOOR FINISH.
 - IN THIS AREA REMOVE EXISTING 1 1/2" W, 1/2" H&C PIPING FROM SINK ABOVE TO MAINS AND INSTALL NEW 1 1/2" WASTE WITH DRAINAGE FITTINGS AND NEW 1/2" H&C WITH VALVES
 - ALL EQUIPMENT & PIPING IN BOILER ROOM TO REMAIN AS IS. THIS CONTR. TO INSTALL NEW 3/4" C BRANCH VALVE TO NEW BOILER. SEE H&V PLAN FOR EXACT LOCATION. PIPE TO BE INSULATED.
 - REMOVE EXIST. F.D. & VENT. CONNECT NEW WASTE & VENT FROM D.F. TO EXISTING SYSTEM AT THESE POINTS.
 - EXISTING 2" C & 1 1/2" H PIPING IN MENS LOCKER ROOM TO REMAIN. REMOVE EXISTING INSULATION AND INSTALL NEW INSULATION IN THIS ROOM.

WOMEN'S LOCKER ROOM

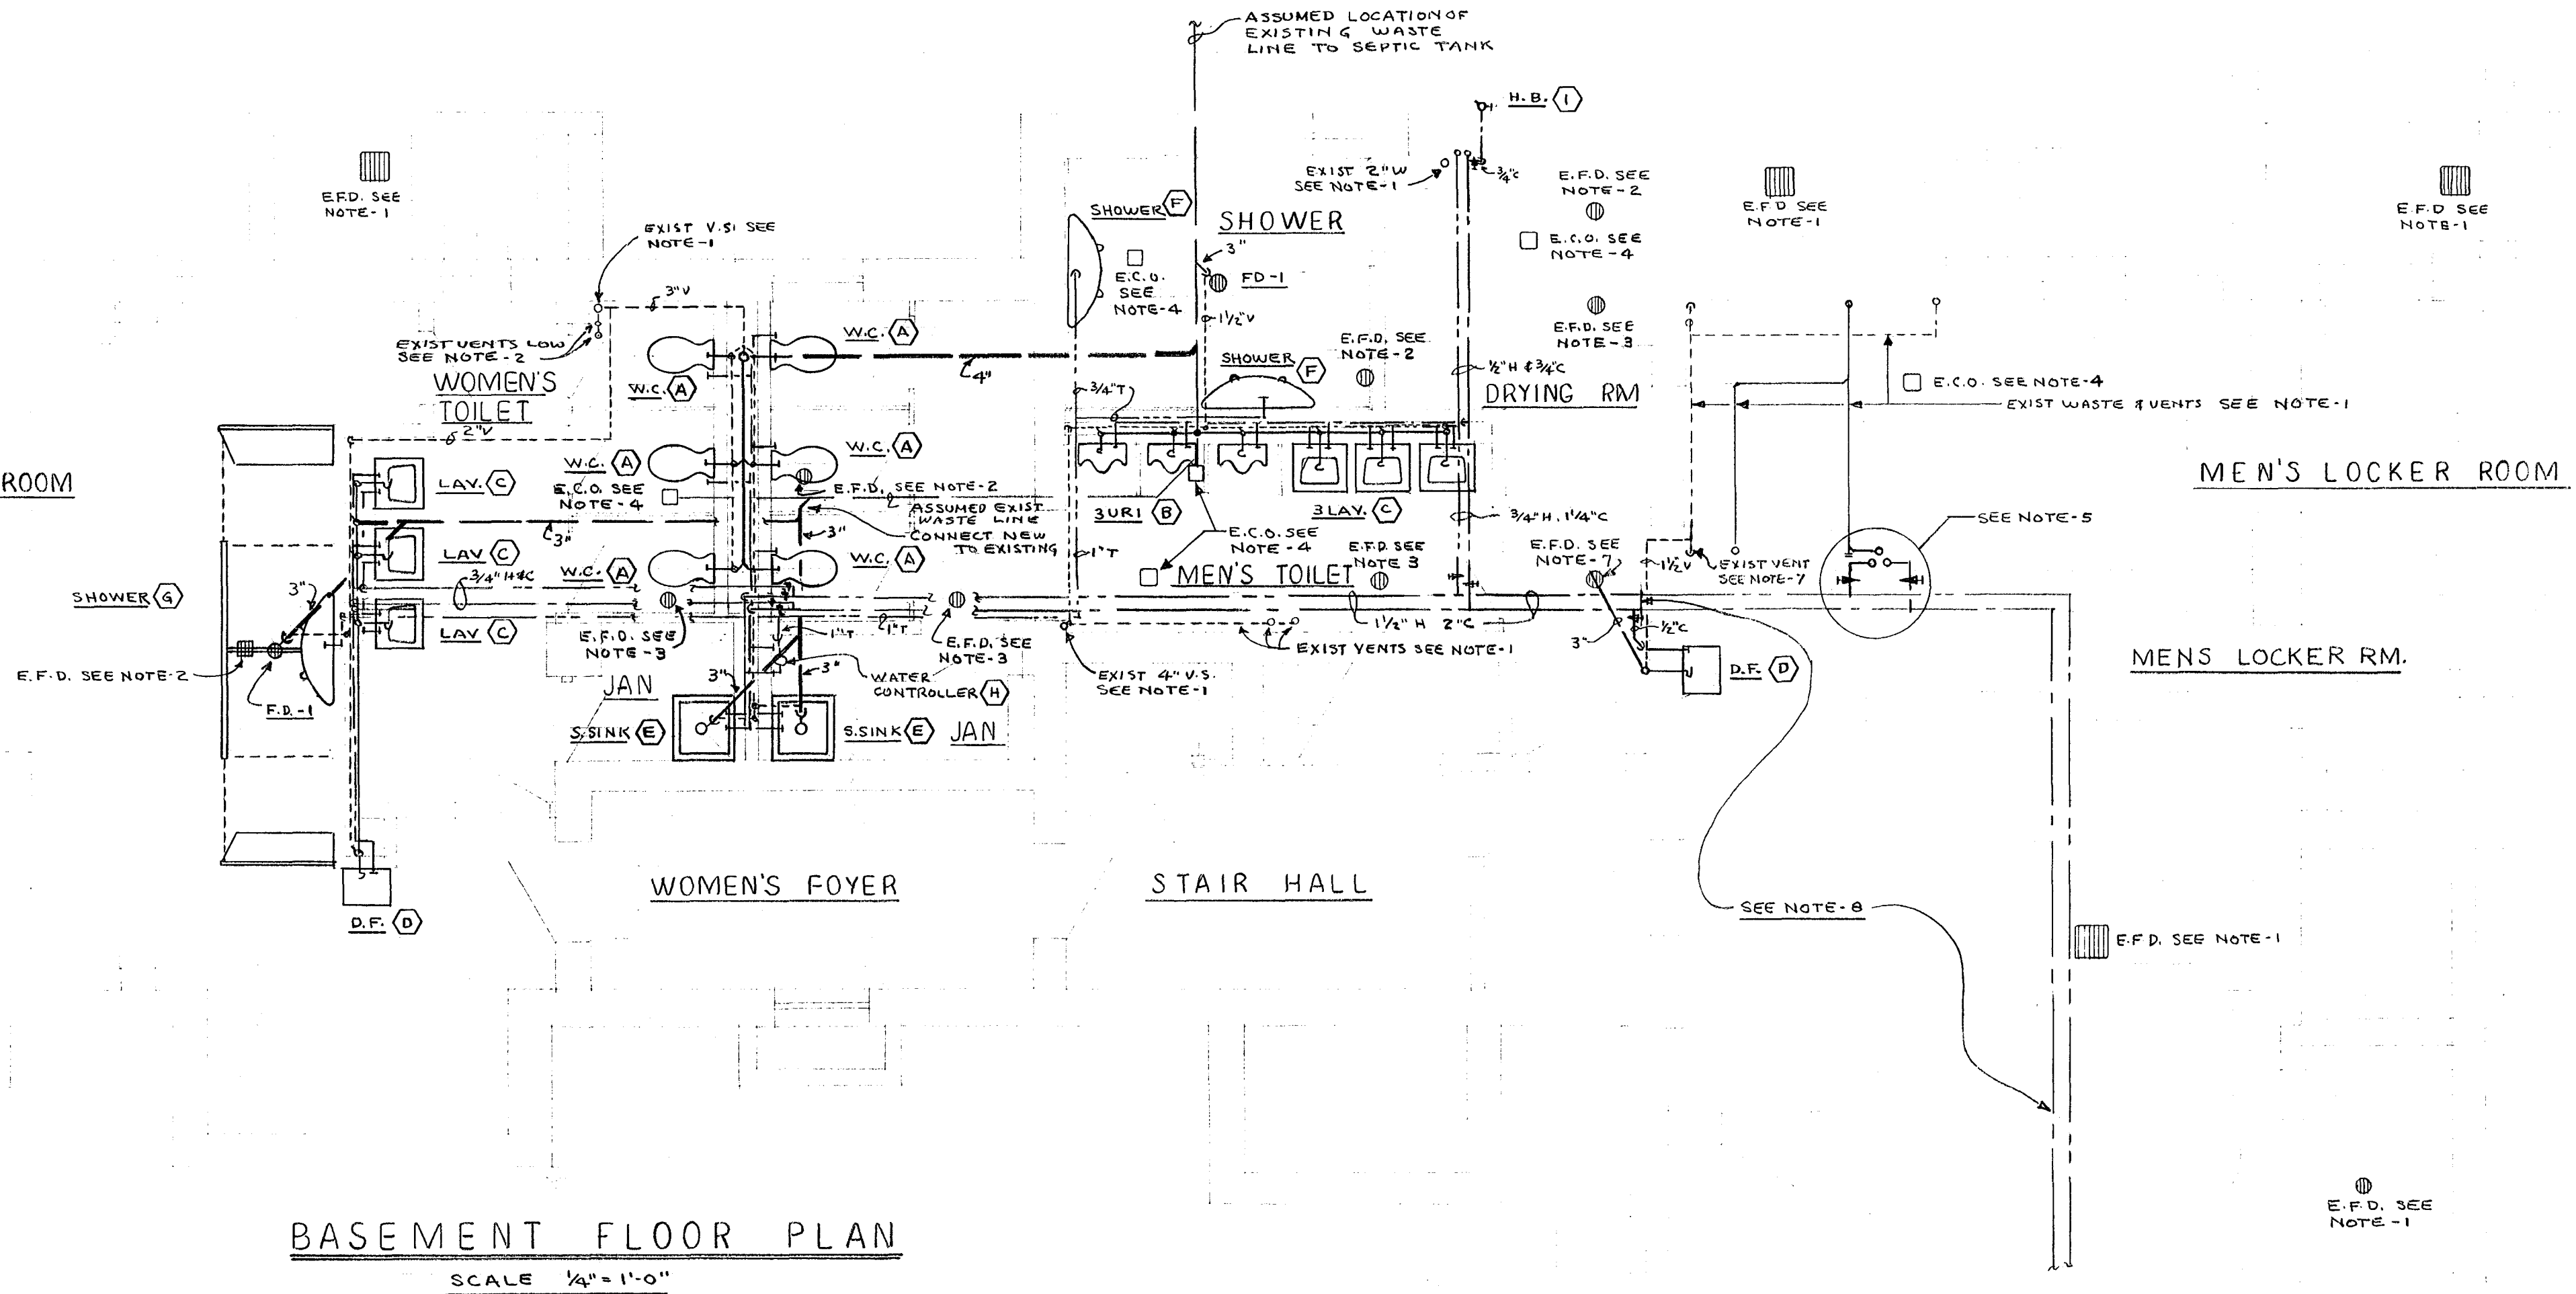


BASEMENT FLOOR PLAN
SCALE 1/4" = 1'-0"

PLUMBING SYMBOLS	
	SOIL OR WASTE
	BURIED SOIL OR WASTE
	VENT
	COLD WATER
	HOT WATER
	TEMPERED WATER TO SHOWERS
	GATE VALVE
	UNION
	CHECK VALVE
	CLEANOUT
	CLEANOUT WITH FLR ACCESS BOX
	EXISTING FLOOR DRAIN
	EXISTING CLEANOUT & ACCESS BOX
	TRAP

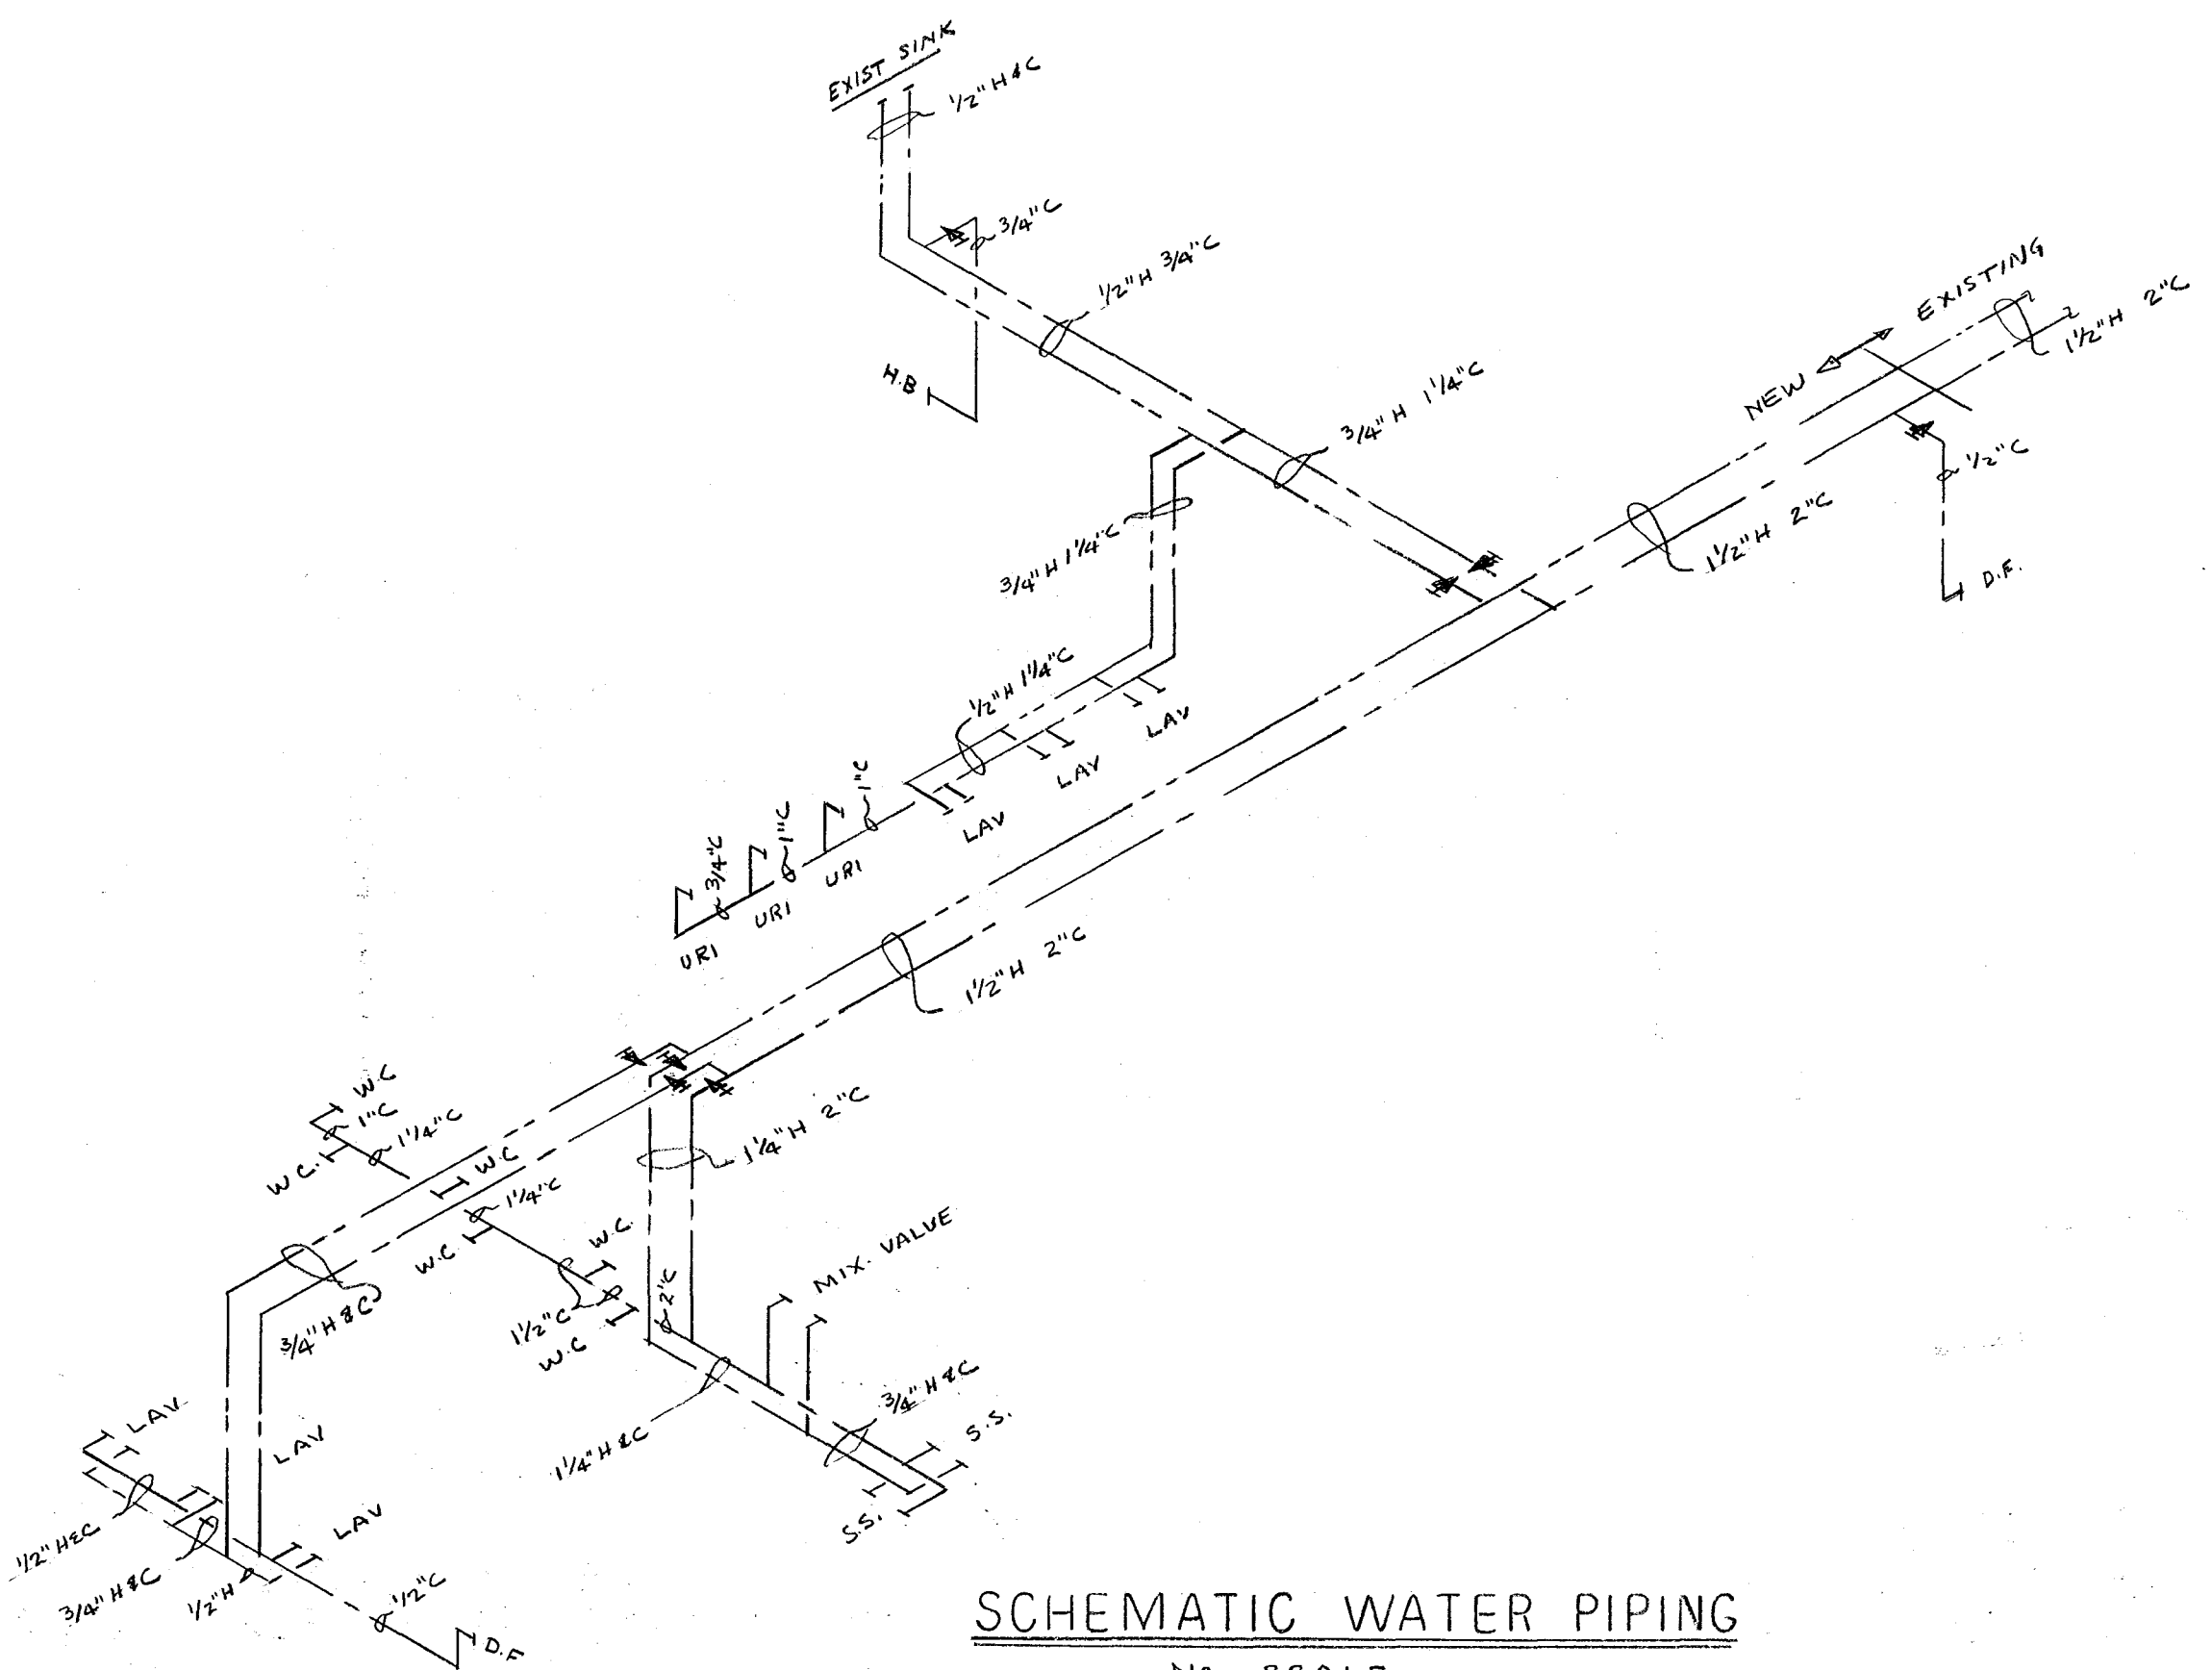

SCHEMATIC WATER PIPING
NO. SCALE

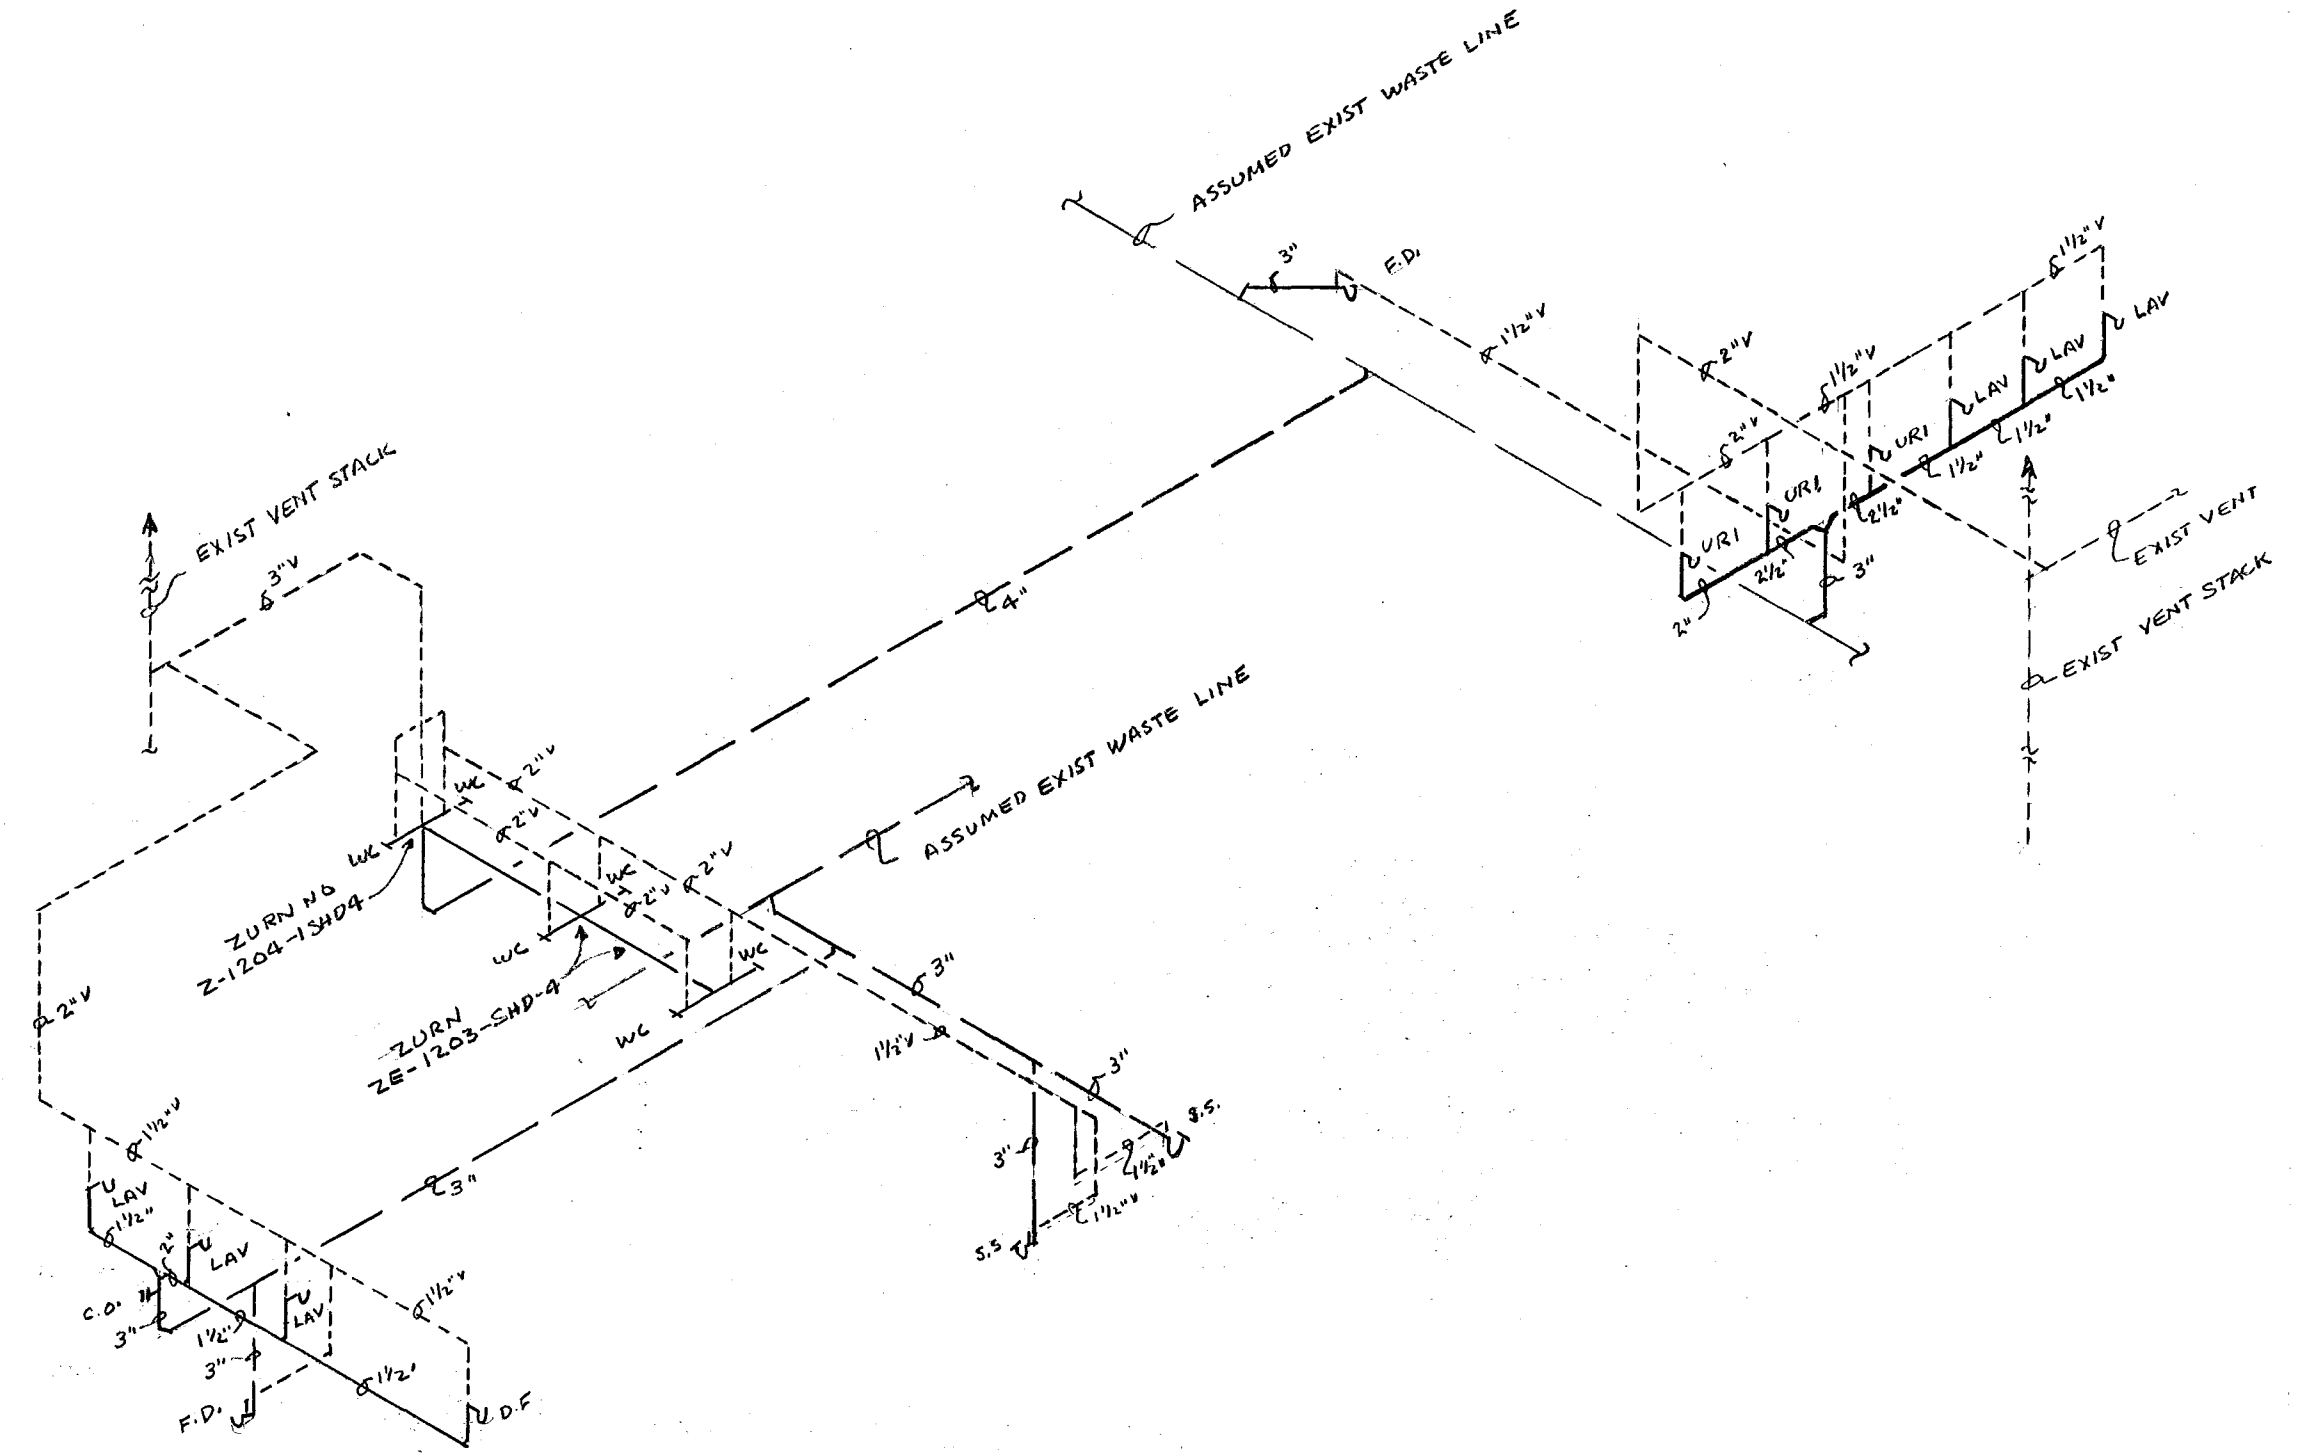

SCHEMATIC WASTE AND VENT PIPING
NO. SCALE

BOILER ROOM
SEE NOTE-6

VERIFY EXISTING
CONDITIONS AND
DIMENSIONS AT
BUILDING

CITY OF HARTFORD, CONNECTICUT DEPARTMENT OF ENGINEERING		
ALTERATIONS TO KENY PARK GOLF CLUB HOUSE WINDSOR, CONNECTICUT		
SUBMITTED <i>Paul D. Bennett</i>	RECOMMENDED <i>David J. Bailey</i>	APPROVED <i>John A. Bennett</i>
DESIGN P.D.P.	DRAWN P.D.P.	DAYBOOK NO. 09943-D
TRACED	CHECK	DATE OCT. 31, 1966