


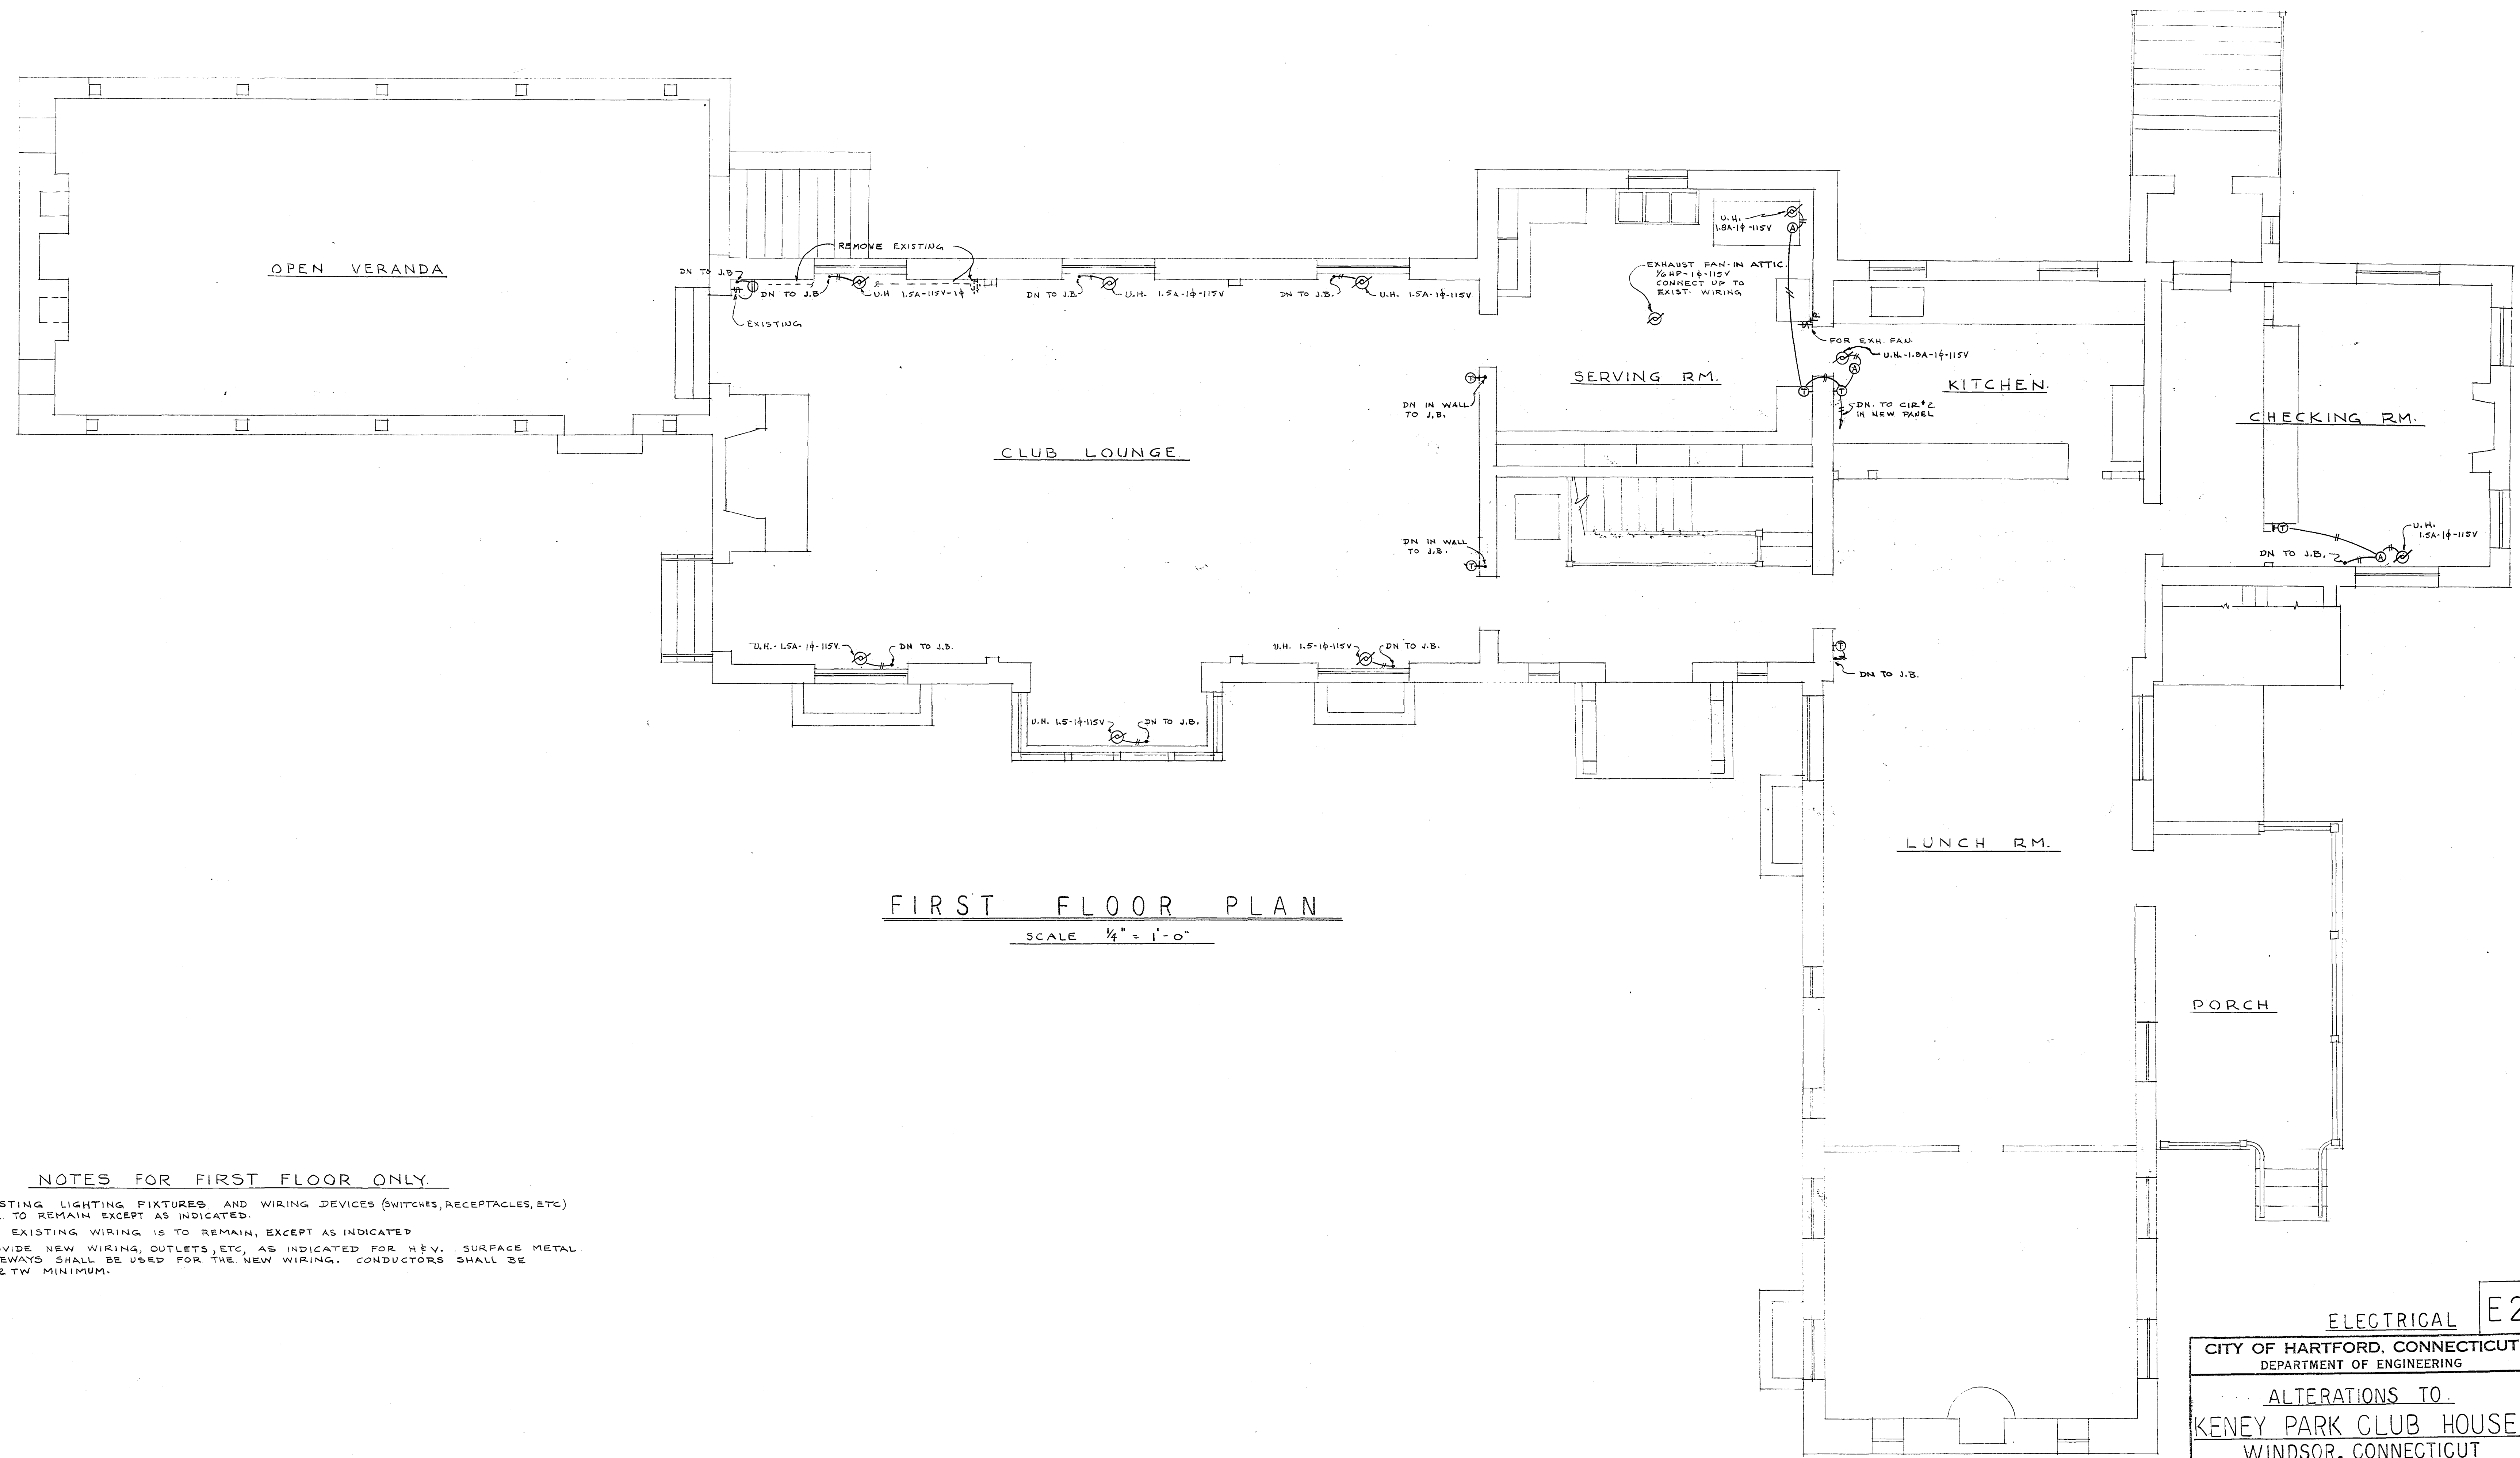

FIRST FLOOR PLAN
 SCALE 1/4" = 1'-0"

NOTES FOR FIRST FLOOR ONLY.

1. EXISTING LIGHTING FIXTURES AND WIRING DEVICES (SWITCHES, RECEPTACLES, ETC.) ARE TO REMAIN EXCEPT AS INDICATED.
2. ALL EXISTING WIRING IS TO REMAIN, EXCEPT AS INDICATED.
3. PROVIDE NEW WIRING, OUTLETS, ETC., AS INDICATED FOR H.V. SURFACE METAL RACEWAYS SHALL BE USED FOR THE NEW WIRING. CONDUCTORS SHALL BE #12 TW MINIMUM.

VERIFY EXISTING
 CONDITIONS AND
 DIMENSIONS AT
 BUILDING

ELECTRICAL			E2
CITY OF HARTFORD, CONNECTICUT DEPARTMENT OF ENGINEERING			
ALTERATIONS TO KENEY PARK CLUB HOUSE WINDSOR, CONNECTICUT			
SUBMITTED <i>Raymond A. Bennett</i>	RECOMMENDED <i>Charles W. Bennett</i>	APPROVED <i>Charles W. Bennett</i>	
DESIGN <i>R.G.B.</i>	DRAWN <i>R.G.B.</i>	DAYBOOK NO. 09943-H	
TRACED	CHECK	DATE, OCT. 31, 1966	