


SYMBOL LIST

- SURFACE MTD FLOOR. FIXTURE ~ LITHONIA CAT N° WA-240-RH. LAMPS - F40CW
- DUPLEX CONV. OUTLET ~ H&H #5262 ~ UP 3'-0"
- THREE-WAY SW ~ H&H #1993 ~ UP 3'-0"
- MOTOR - SEE NOTE #1.
- MAGNETIC MOTOR STARTER - SEE NOTE #1.
- DISCONNECT ~ WEATHERPROOF.
- TRANSFORMER.
- COOLING THERMOSTAT - SEE NOTE #2.
- HEATING THERMOSTAT - SEE NOTE #2.
- DUCT HEATER - SEE NOTE #1.



NOTE #1. FURNISHED & INSTALLED BY OTHERS. WIRED BY THIS ELEC. CONTR.

NOTE #2. FURNISHED BY OTHERS. INSTALLED & WIRED BY THIS ELEC. CONTR.

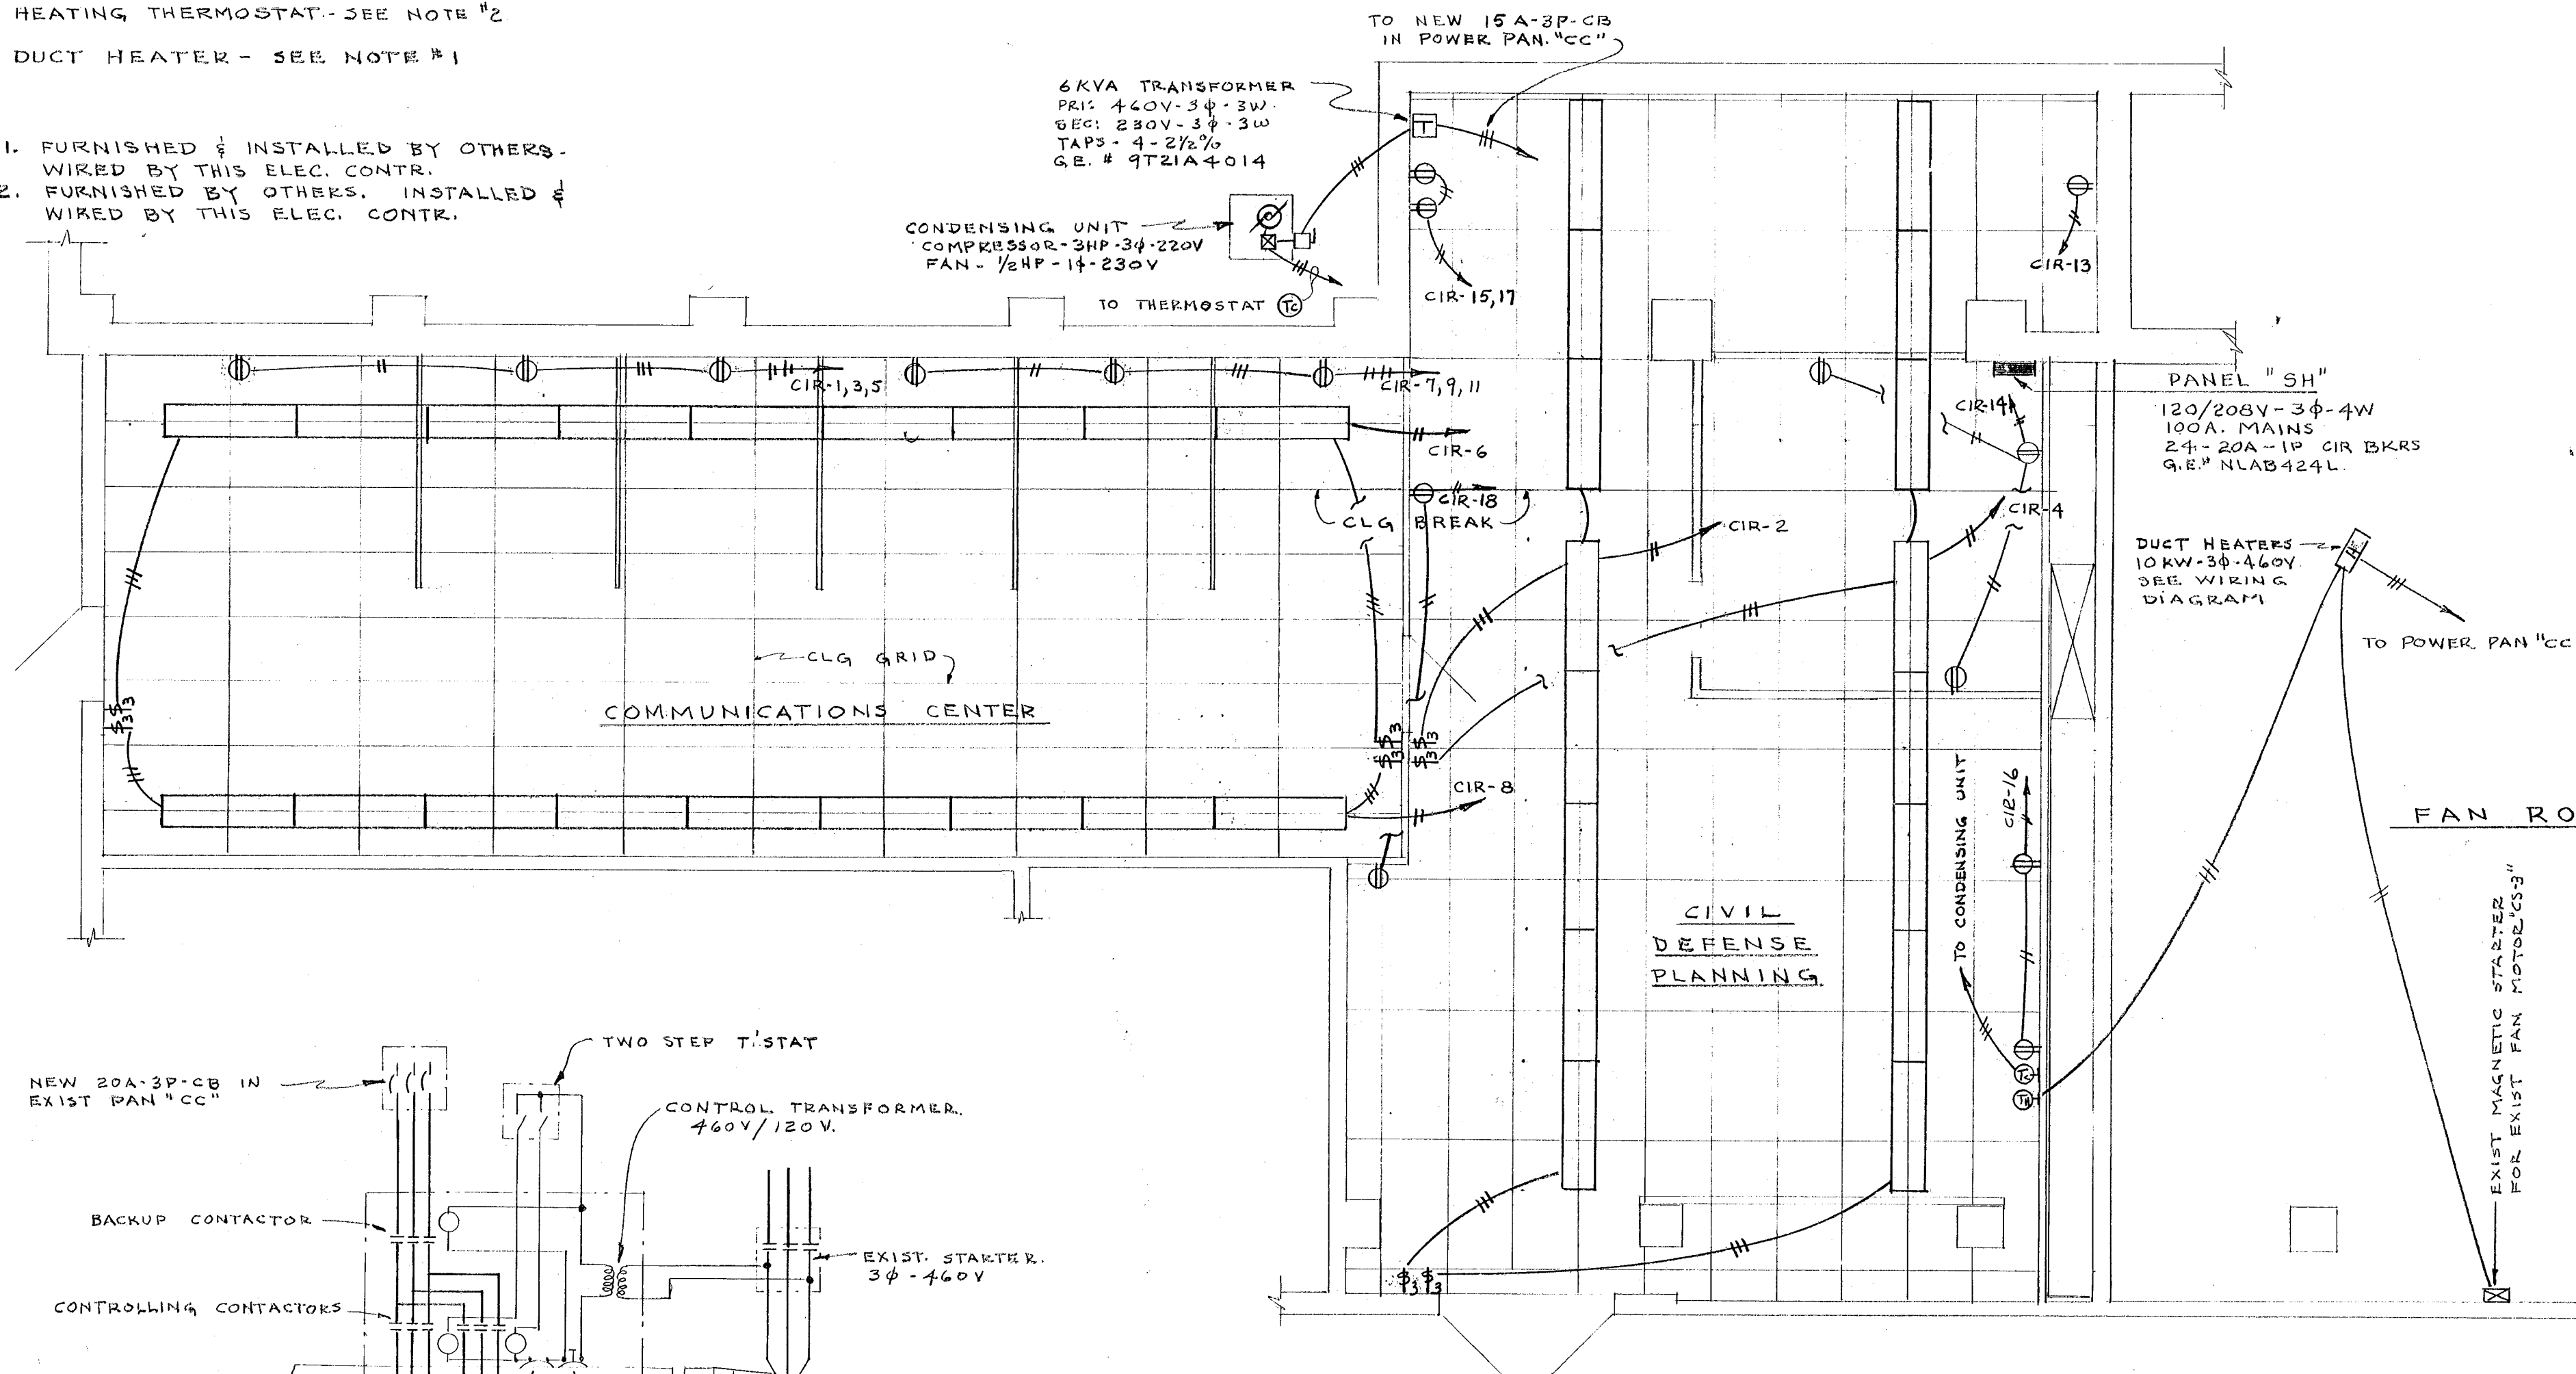


FLOOR PLAN
SCALE 1/4" = 1'-0"

DUCT HEATER WIRING DIAGRAM
NO SCALE

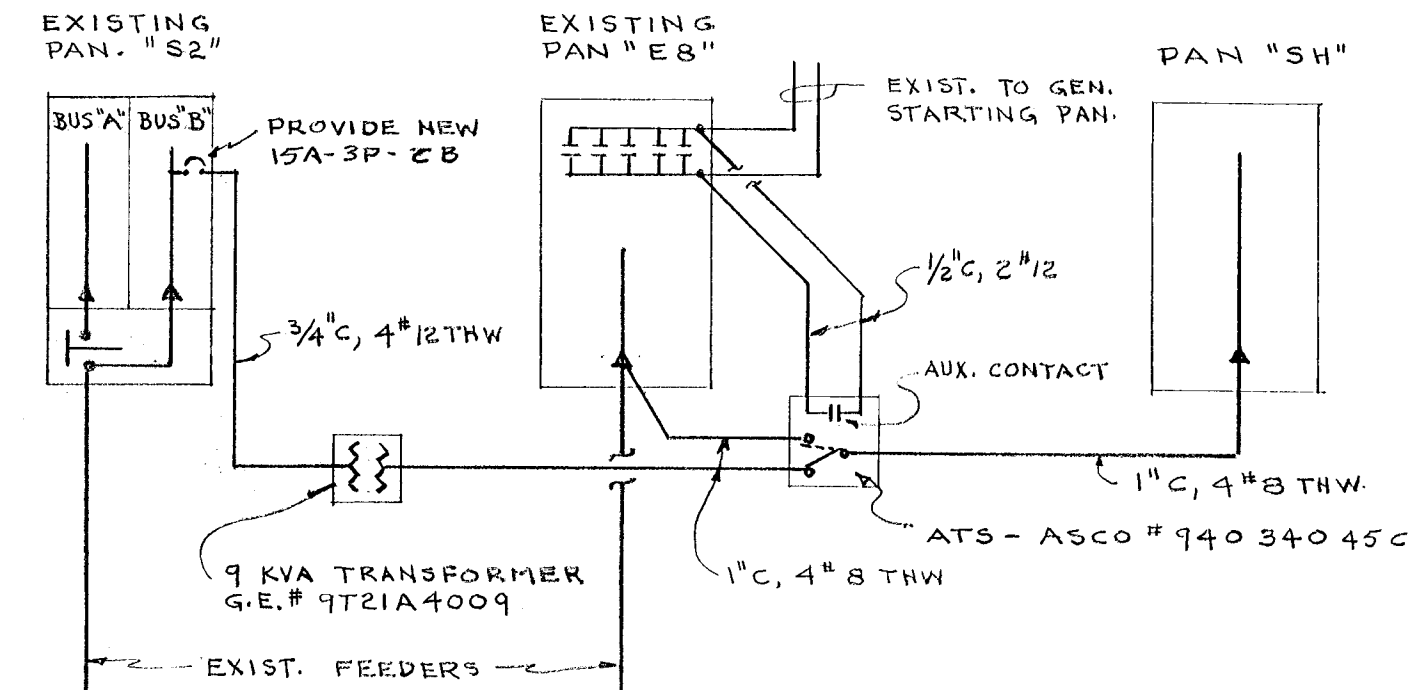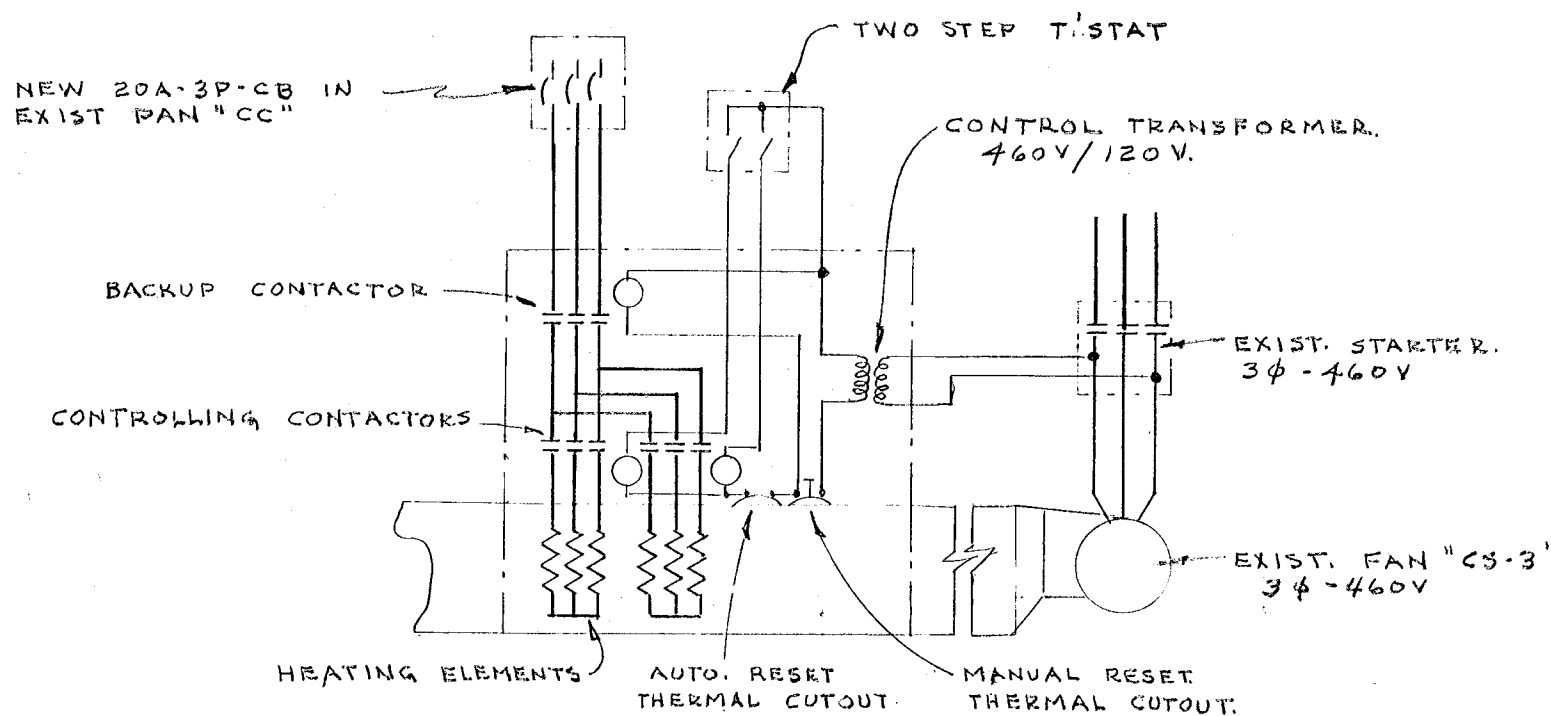

POWER RISER DIAGRAM
NO SCALE

FAN ROOM C-B-3

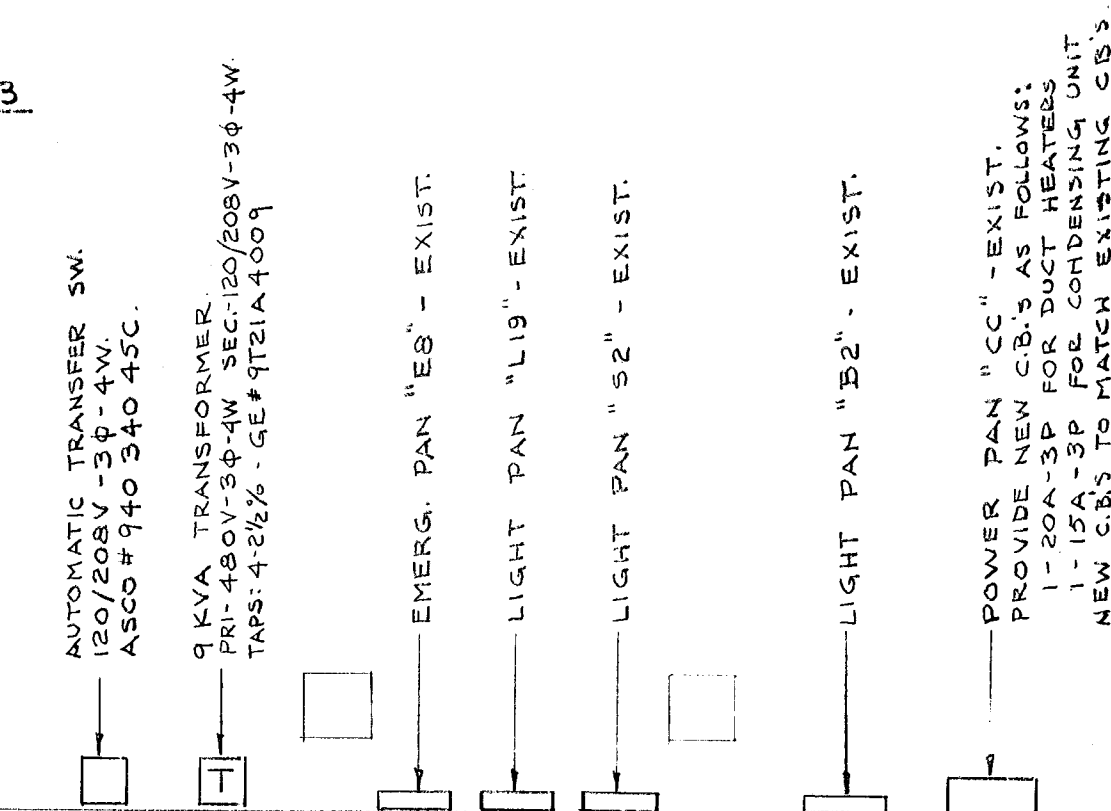

E1

CITY OF HARTFORD, CONNECTICUT DEPARTMENT OF ENGINEERING	
ALTERATIONS TO CIVIL DEFENSE HDQTRS.	
HARTFORD PUBLIC HIGH SCHOOL	
FOREST ST.	HARTFORD, CONN.
SUBMITTED	RECEIVED
DESIGNED BY <i>Raymond A. Bennett</i>	CITY ENGINEER
DRAWN BY <i>R.G.B.</i>	DAYBOOK NO. 09965-C
TRACED	CHECK
DATE 2-1-67	

VERIFY EXISTING
CONDITIONS AND
DIMENSIONS AT
BUILDING