


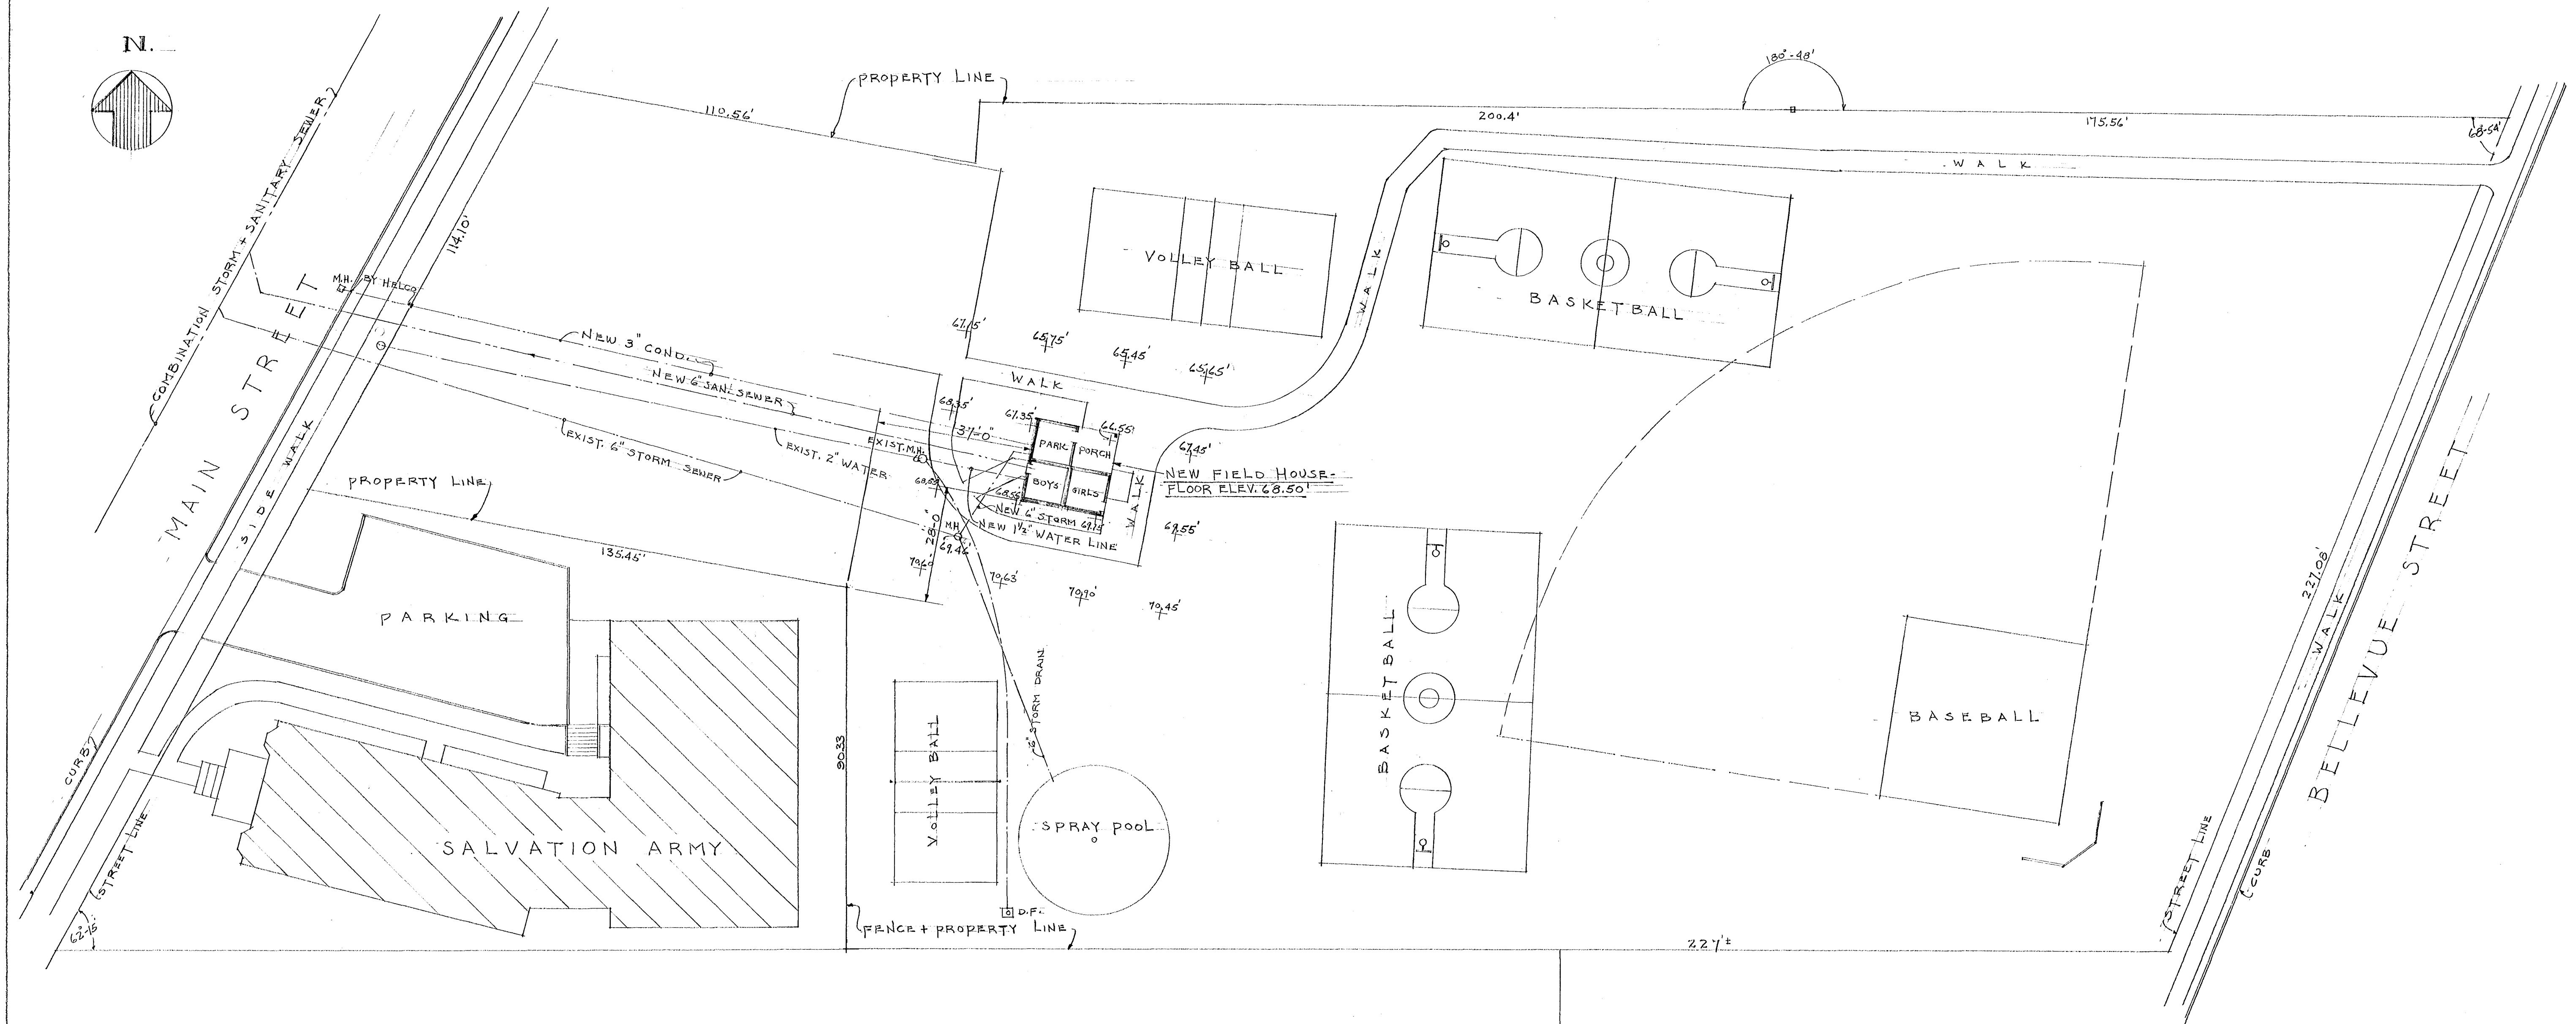

• PLOT PLAN - ST. BENEDICT'S PLAYGROUND •
SCALE 1" = 20'-0"

FIELD HOUSE - ST. BENEDICT'S PLAYGROUND

SHELTER - DELUCCO PLAYGROUND

DRAWING INDEX		CITY OF HARTFORD, CONNECTICUT	
DWG. NO.	TITLE	DEPARTMENT OF ENGINEERING	
1	TITLE SHEET & PLOT PLAN	FIELD HOUSE AT ST. BENEDICT'S PLAYGROUND - N. MAIN ST. AND SHELTER AT DELUCCO PLAYGROUND BROOK ST. - HARTFORD, CONN.	DWG. No.
2	PLAN AND ELEVATIONS		1
3	TYPICAL SECTIONS		
4	FRAMING DETAILS		
5	MECHANICAL PLAN		
6	PLAN OF SHELTER		
SUBMITTED BY: A.H. STRONG		RECOMMENDED BY: [Signature]	APPROVED BY: [Signature]
DESIGN		CITY ARCHITECT	CITY ENGINEER
DRAWN: AHS		DAYBOOK No. 010018 A	
TRACED		DATE: MAR. 13, 1968	