


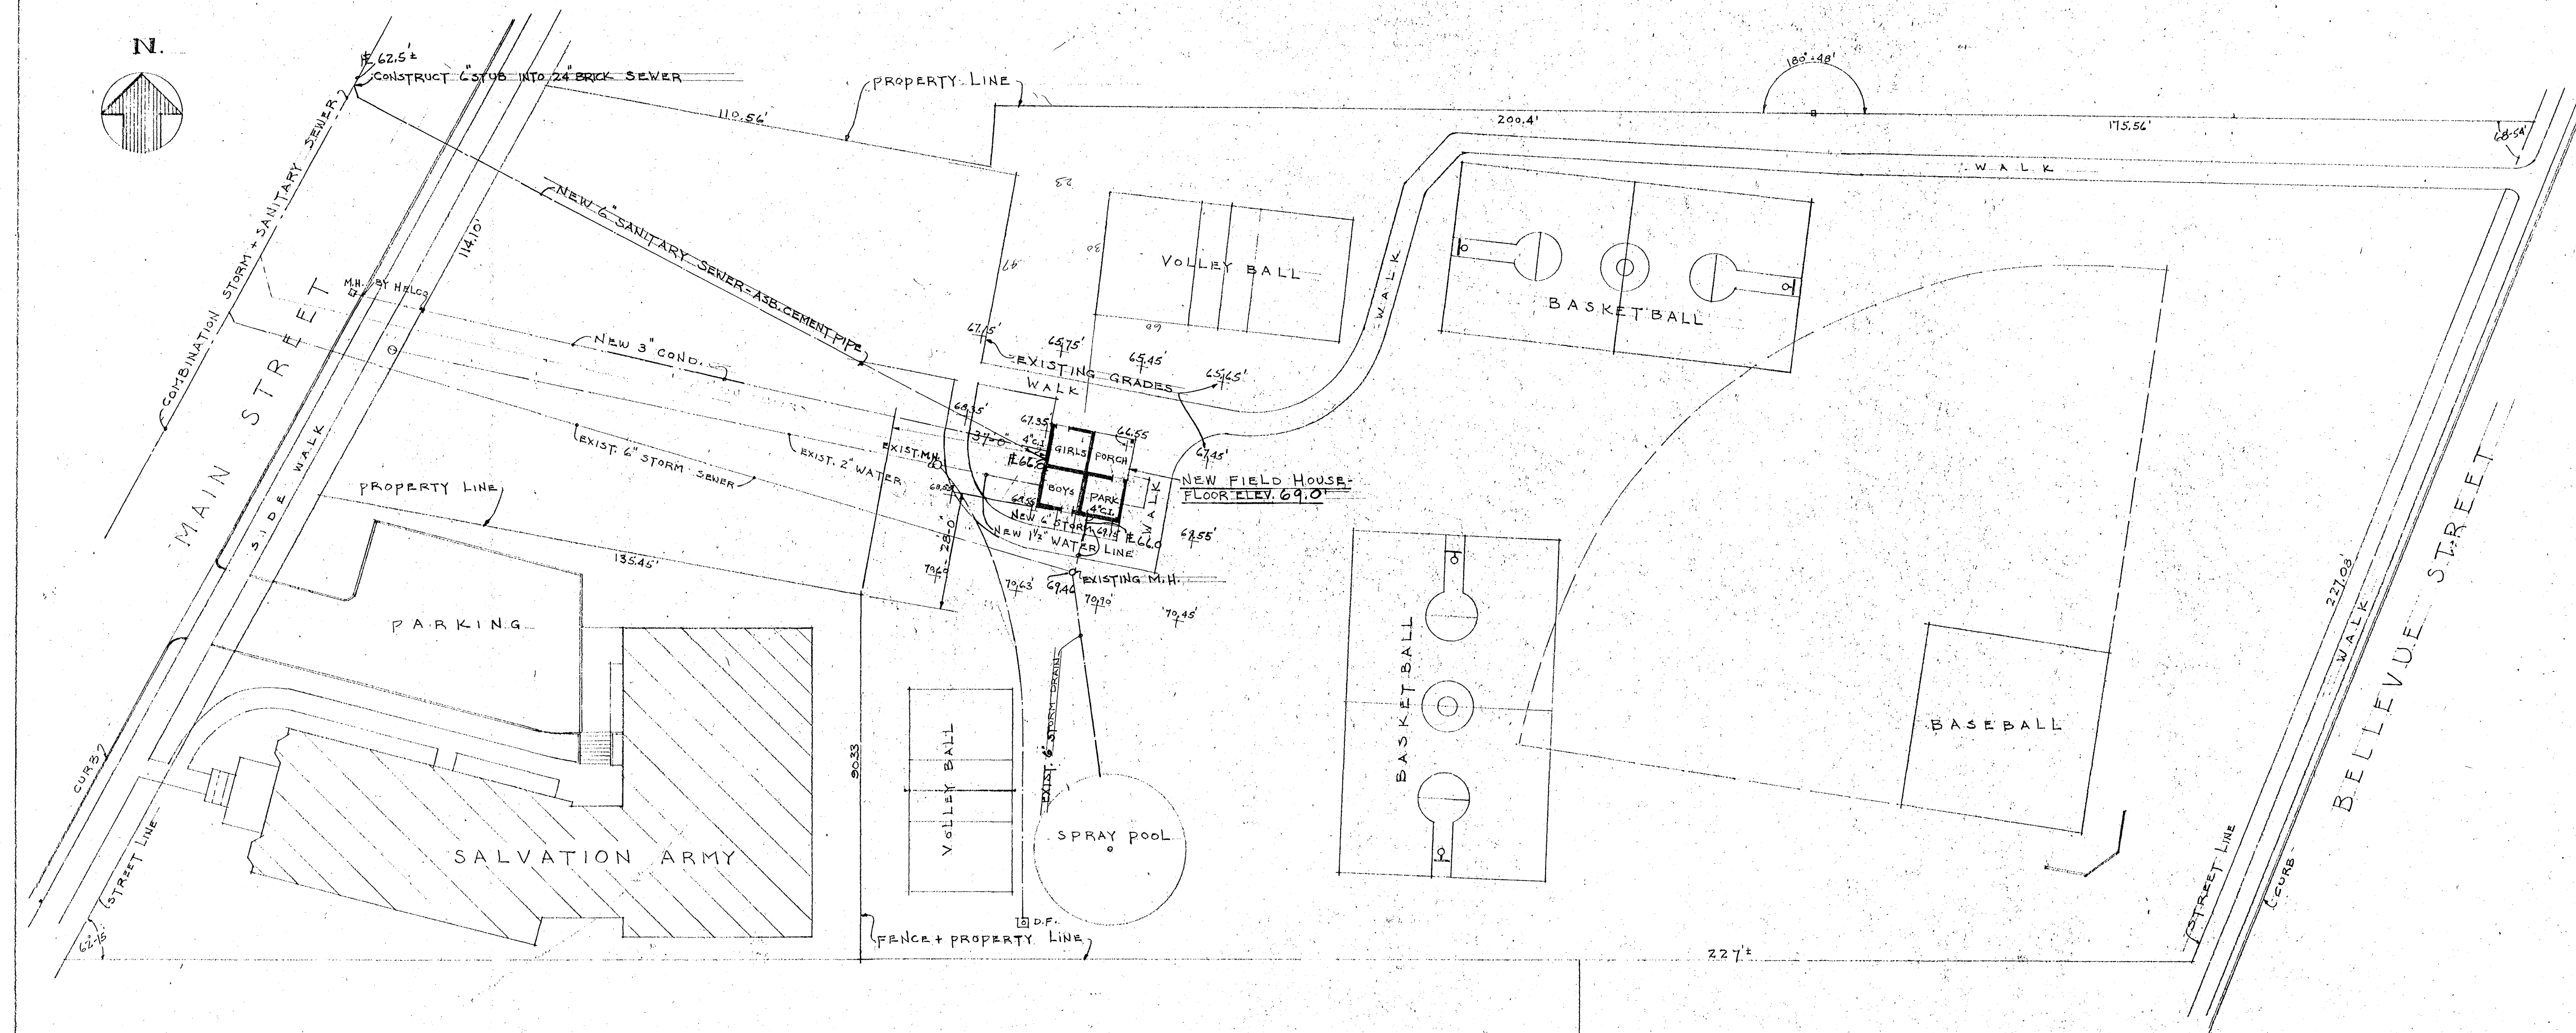

• PLOT PLAN - ST. BENEDICT'S PLAYGROUND.

SCALE 1" = 20'-0"

NOTE:

WHERE LESS THAN 4' OF FILL EXISTS OVER SEWER PIPES THEY SHALL BE ENCLOSED IN 6" OF CONCRETE

FIELD HOUSE - ST. BENEDICT'S PLAYGROUND

SHELTER - DELUCCO PLAYGROUND

DRAWING INDEX		CITY OF HARTFORD, CONNECTICUT	
DWG. NO.	TITLE	DEPARTMENT OF ENGINEERING	
1	TITLE SHEET & PLOT PLAN	FIELD HOUSE AT ST. BENEDICT'S PLAYGROUND - N. MAIN ST. AND SHELTER AT DELUCCO PLAYGROUND - BROOK ST. - HARTFORD, CONN.	DWG. NO. 1
2	PLAN AND ELEVATIONS		
3	TYPICAL SECTIONS		
4	FRAMING DETAILS		
5	MECHANICAL PLAN		
6	PLAN OF SHELTER		
DESIGN		DRAWN AHS	DAYBOOK NO. 010018 AA
TRACED		CHECK	DATE MAR. 13, 1968

REV. 4-30-68-AHS
REV. 4-5-68-AHS